


PROJECT LOCATION MAP

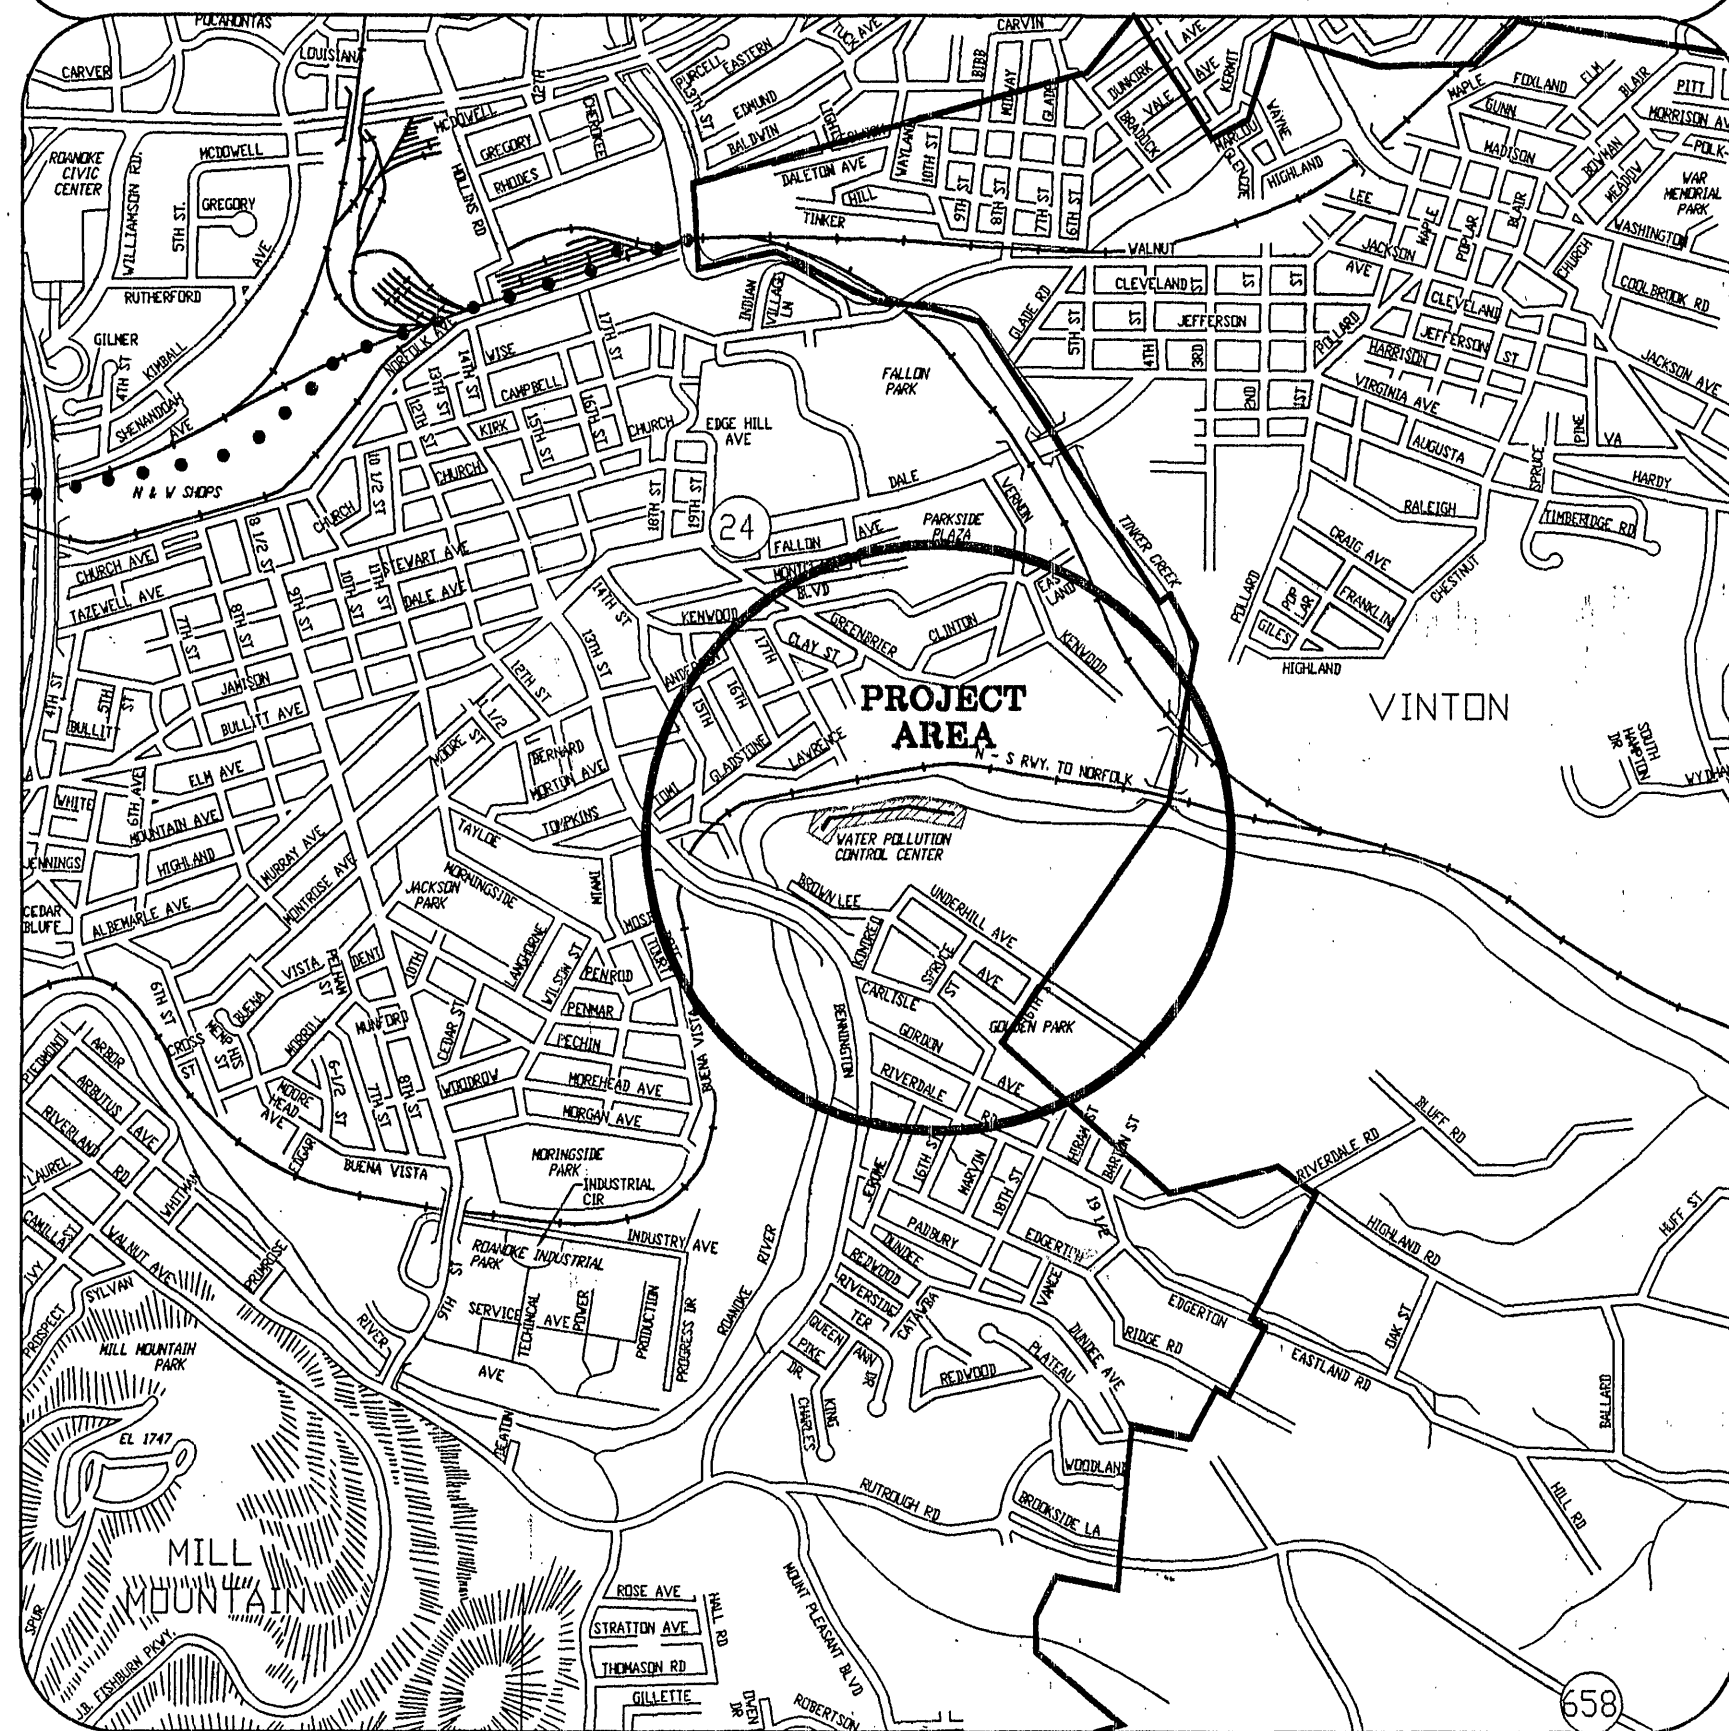


OFFICE OF CITY ENGINEER
ROOM 350
MUNICIPAL BUILDING
215 CHURCH AVENUE, S.W.
ROANOKE, VIRGINIA 24011


INDEX OF SHEETS

- 1 TITLE
- 2 SUMMARY OF QUANTITIES
- 3 GENERAL ABBREVIATIONS AND LEGEND
- 4 CONSTRUCTION NOTES
- 5 PLAN AND PROFILE
- 6 PLAN AND PROFILE
- 7 DETAILS
- 8 DETAILS
- 9 DETAILS
- 10 PLANT DRAIN PUMP STATION

Commonwealth of Virginia
State Health Department
Division of Wastewater Engineering
Date MAR 07 1997
☒ Plans and Specifications Approved
☐ Plans and Specifications Approved with conditions
☐ Plans and Specifications Disapproved
Carl Gentry
Director, Division of Wastewater Engineering
DWE-1


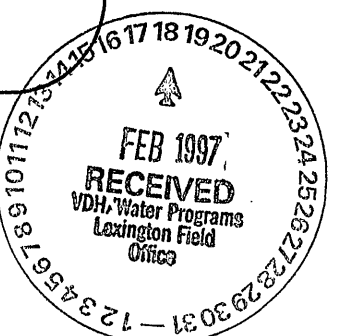


CONSULTING ENGINEERS

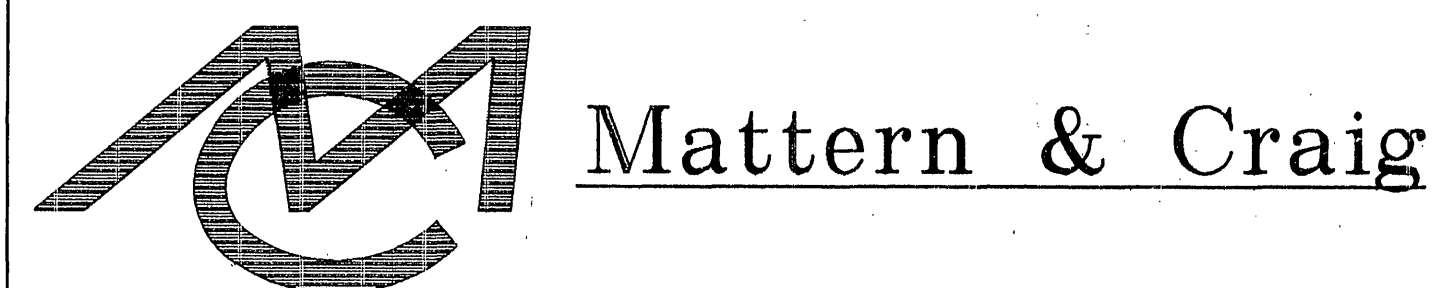

Mattern & Craig
CONSULTING ENGINEERS
SURVEYORS
701 FIRST STREET
ROANOKE, VIRGINIA
(540) 345-9342

COMMISSION NUMBER: 1488

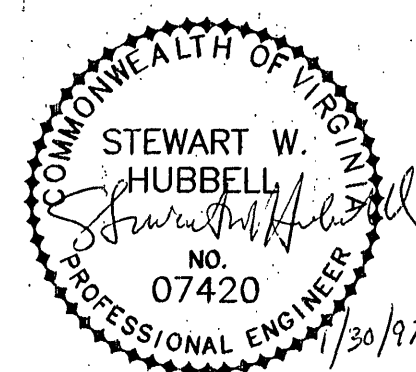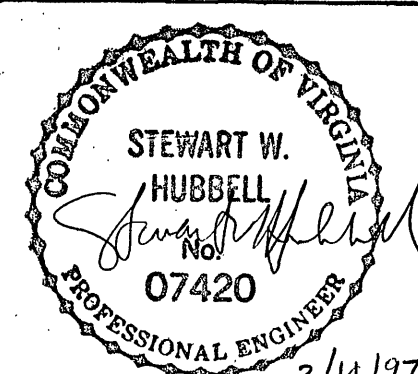

PROJECT NAME

TINKER CREEK INTERCEPTOR
54" SANITARY SEWER PROJECT
CITY OF ROANOKE, VIRGINIA

PROJECT NUMBER: 0000

REVISION BY	DESCRIPTION:	DATE
REVISION BY	DESCRIPTION:	DATE
REVISION BY	DESCRIPTION:	DATE
REVISION BY	DESCRIPTION:	DATE

APPROVED FOR CONSTRUCTION

<i>Charles M. Huffine</i> ROANOKE CITY ENGINEER	<u>2-13-97</u> DATE
<i>William F. Clark</i> DIRECTOR OF PUBLIC WORKS	<u>2-13-97</u> DATE
<i>W. B. J.</i> DIRECTOR OF PUBLIC UTILITIES AND OPERATIONS	<u>2/13/97</u> DATE
	DATE
	DATE

ADVERTISED DATE: _____

SET NUMBER: _____

SHEET NUMBER: 1 OF 10