



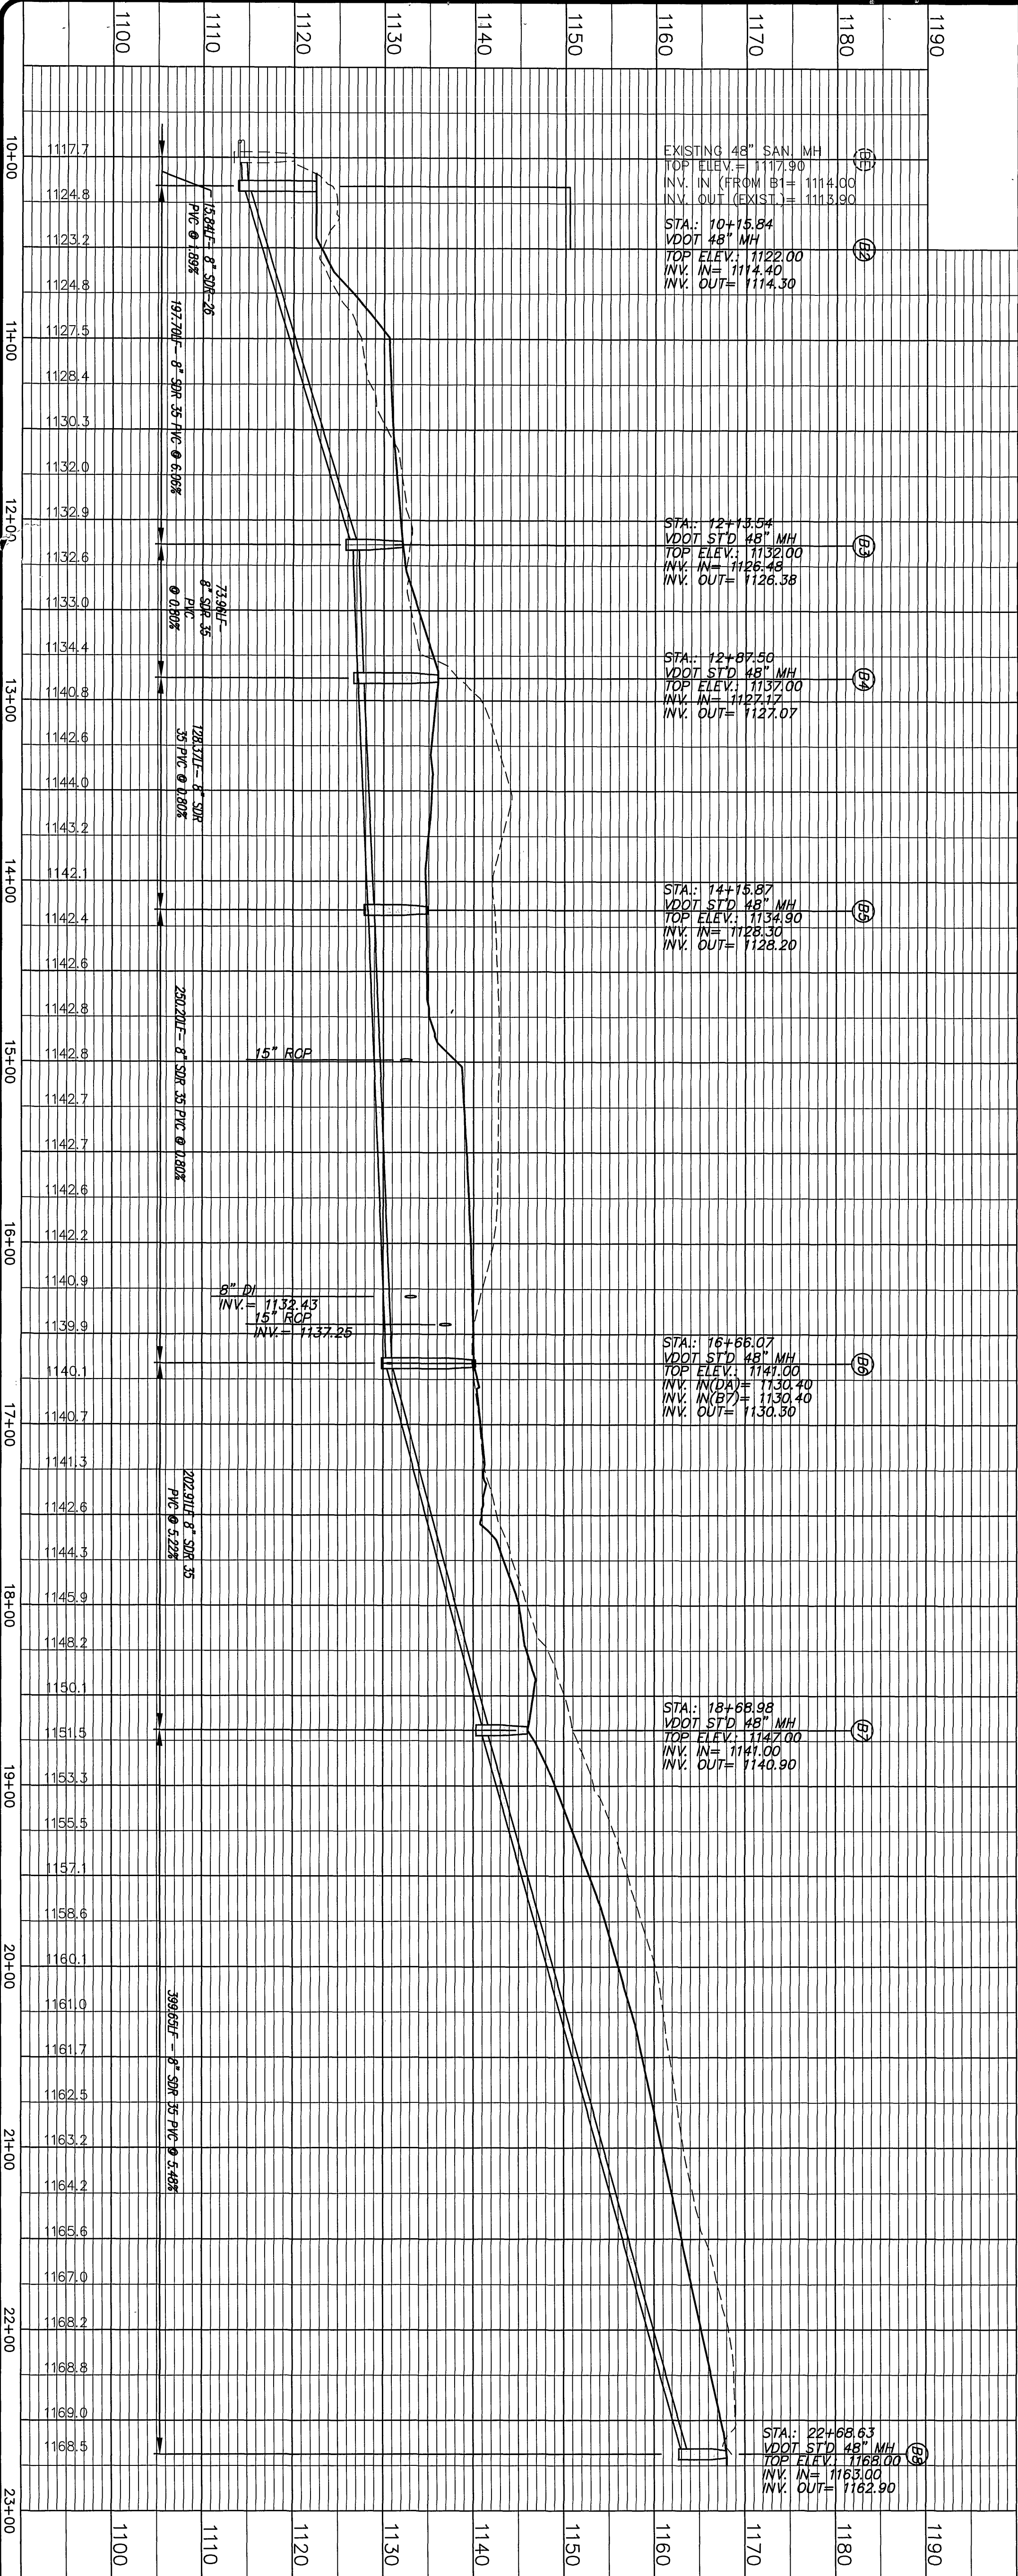

SANITARY SEWER LINE 'A'
8" SDR 35- PVC

1. ALL CONSTRUCTION METHODS, DETAILS, AND SPECIFICATIONS ARE TO BE PER THE LATEST EDITION OF THE STANDARD SPECIFICATIONS FOR HIGHWAY CONSTRUCTION.
2. IF ANY OF THE ABOVE SPECIFICATIONS MUST BE ADDED BY THE A.I.D. LINES DURING THE CONSTRUCTION OF THE SANITARY SEWER LINE
3. THE SAVING OF SPACE BETWEEN STORM SEWER LINES, WATER LINES AND THE SANITARY SEWER LINES
4. TO NOTIFY EXISTENCE OF ANY DISCREPANCIES BETWEEN PLANS AND ACTUAL FIELD CONDITIONS
5. MAINTAIN 3' OF COVER AS A MINIMUM
6. ALL SEWER SERVICE MATERIALS TO BE 6" MINIMUM, ALL REINFORCING LABELS SHALL BE 1"-85#
7. ALL SEWER SERVICE TO BE 1" MINIMUM SIZE OF CURB
8. OVERLAP JOINTS TO BE 1'-0"
9. ALL JOINTS TO BE PROPERLY PATCHED TO BE REMOVED AND BACKFILLED WITH COMPACTED STONE TO FIT
10. ALL SEWER MANHOLES LEFT OPEN OR SHALLOWER THAN BE SRJ 35 P.C.
11. ALL SEWER MAINS DEEPER THAN 10 FT. SHALL BE SRJ 20 P.C.

SITE DEVELOPMENT PLAN FOR THE TOWNES AT HIDDEN VALLEY WINDSOR HILLS DISTRICT, ROANOKE COUNTY, VIRGINIA

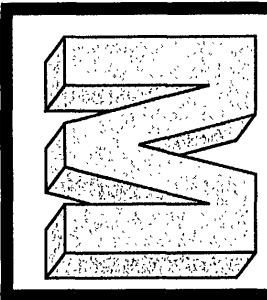

MIKE MORGAN ENGINEERING, LLC
14350 SOMMERVILLE COURT
MIDLOTHIAN, VA 23113
Office: 804.419.2559
Fax: 804.419.2558

NAME PROJECT NUMBER DRAWN BY: DLG DATE: 03/24/07		CHECK BY: MDM ISSUE: 12/14/07	
SHEET TITLE SANITARY SEWER LINE A 78375 PLAN AND PROFILE			
SHEET NO. 5978 OF 5979		PER COUNTY COMMENTS 1. 10/02/07 PER VDOT AND PER COUNTY COMMENTS 3. 11/06/07 PER COUNTY COMMENTS 4. 12/14/07 PER VDOT COMMENTS	

COMMONWEALTH OF MASSACHUSETTS
 REGISTERED PROFESSIONAL ENGINEER
 No. 04763
 MICHAEL D. MORGAN
 12/14/07
 RESEAL