


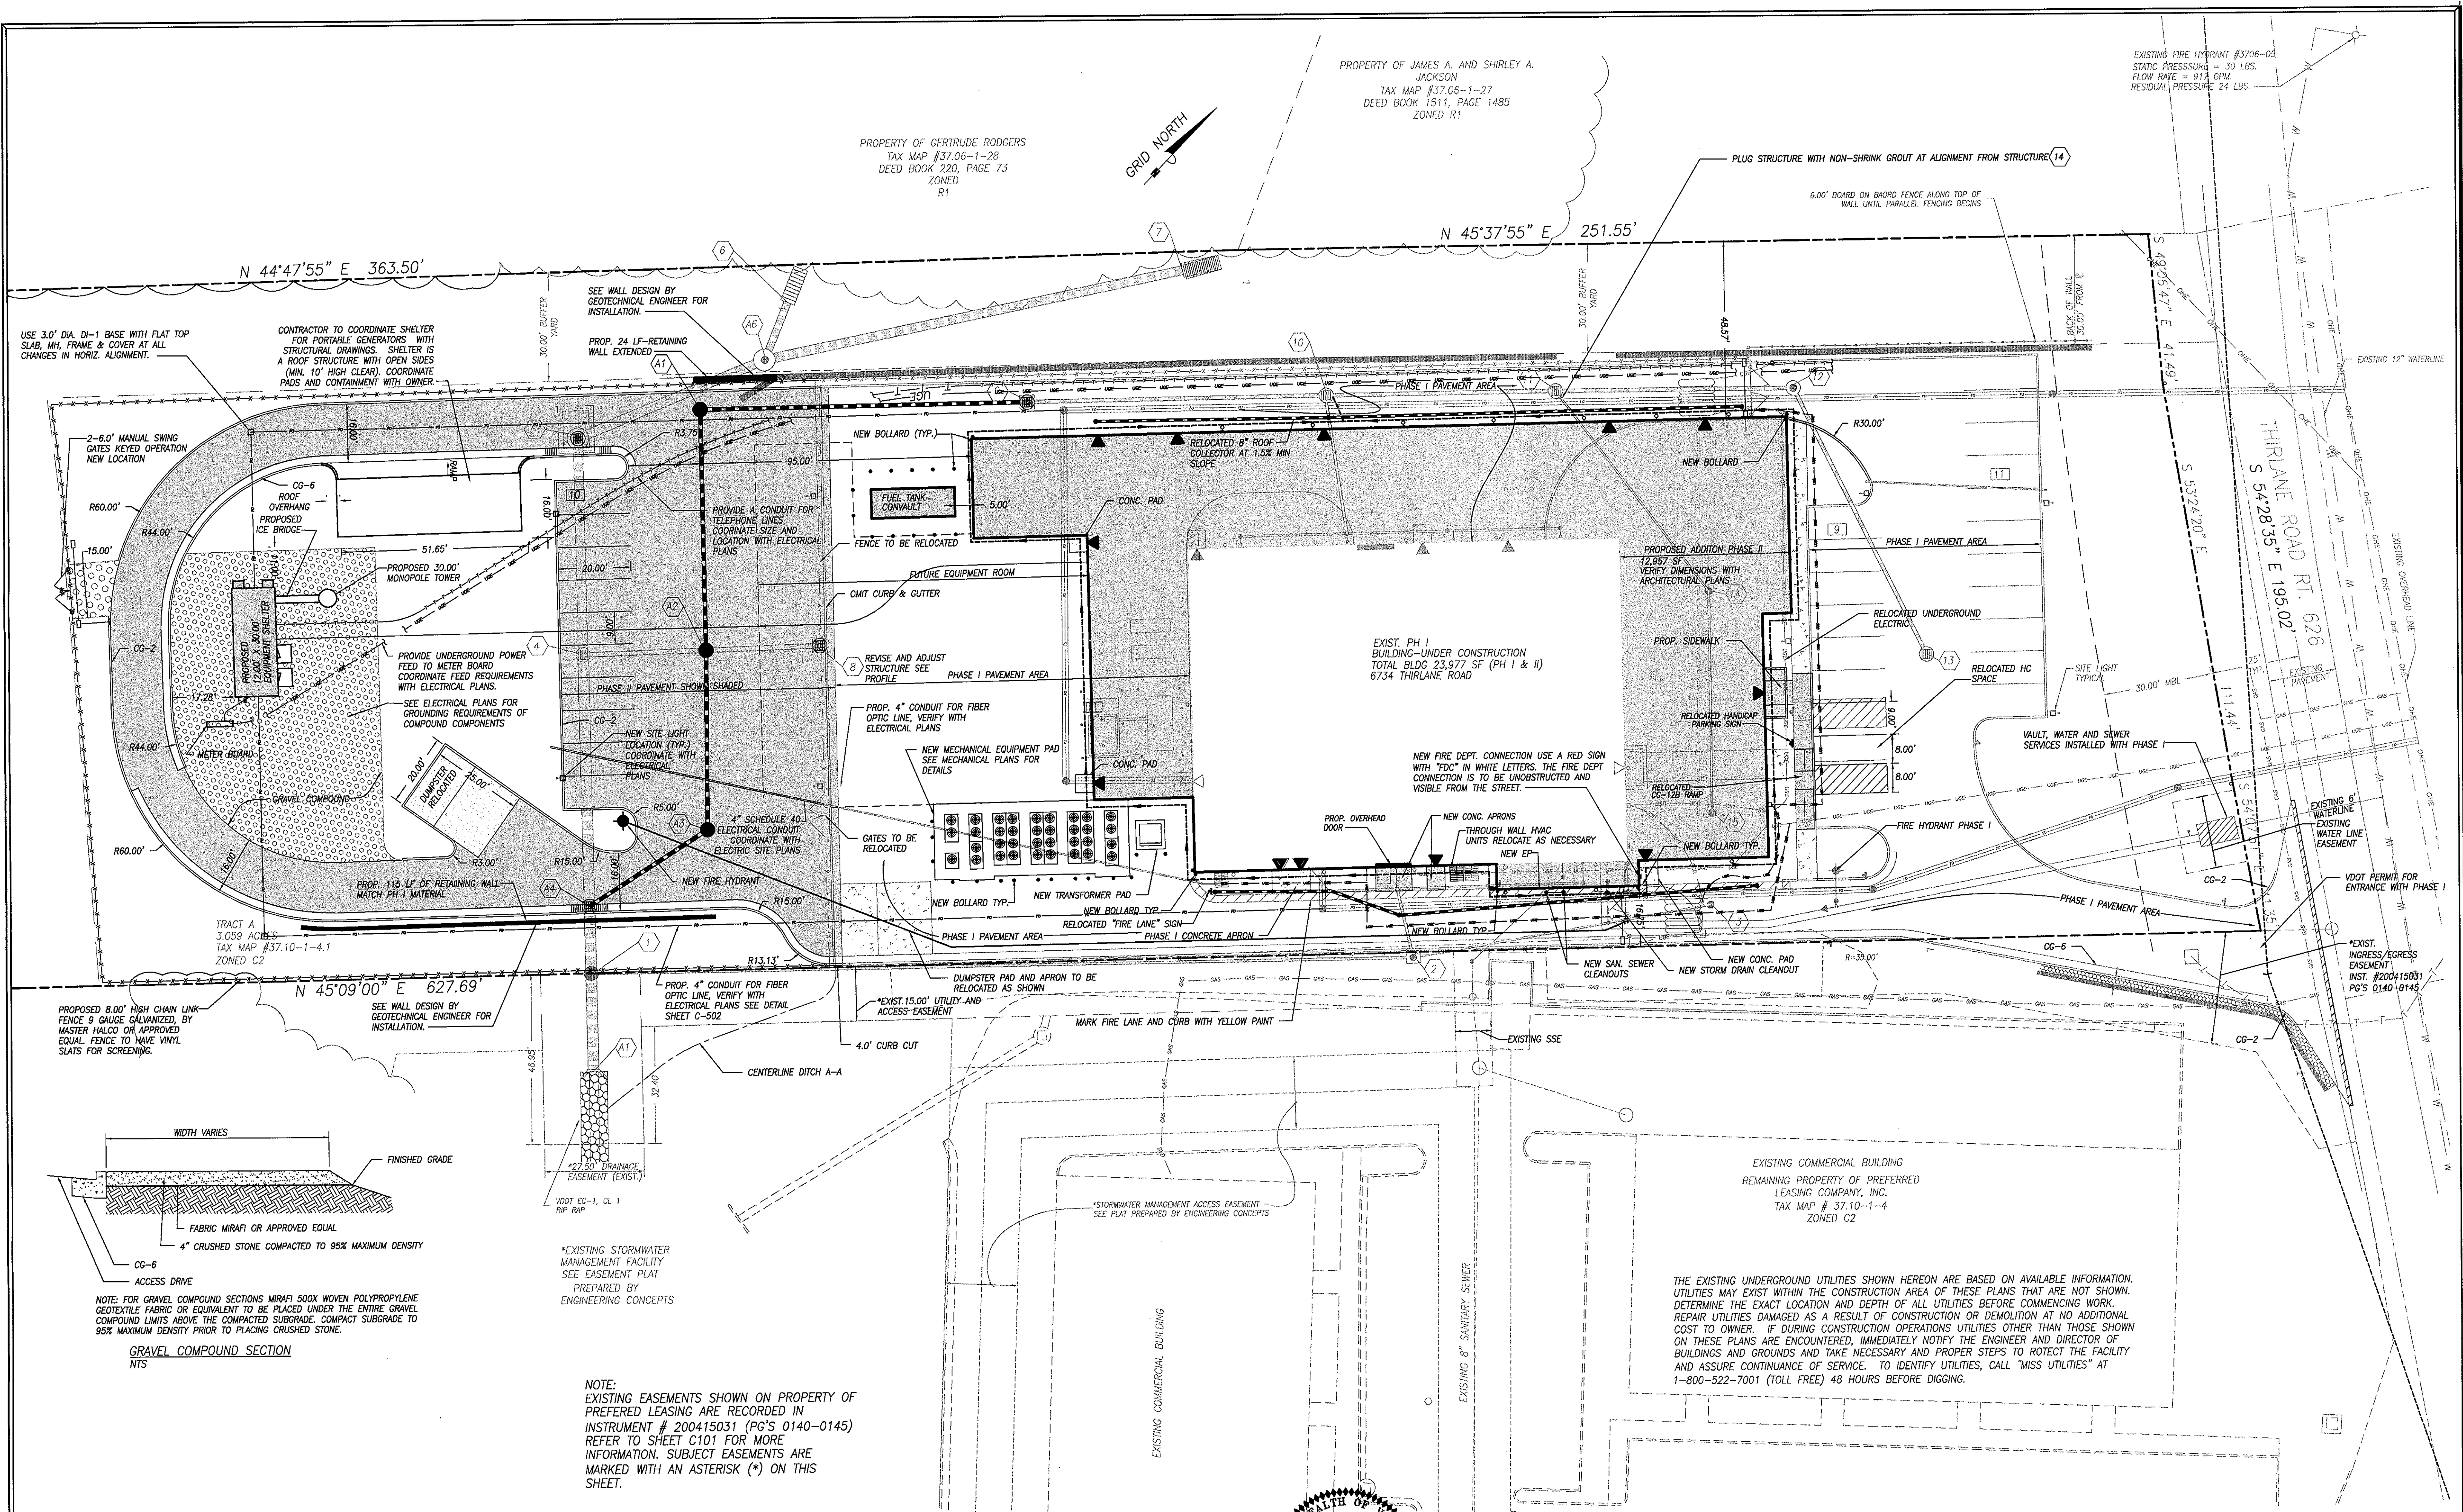

ENGINEERING CONCEPTS, INC.
 3433 BRAMBLETON AVENUE, SUITE 200B
 ROANOKE, VIRGINIA 24018
 540.776.5715 FAX: 540.776.8543

NOTE:
 CONTRACTOR SHALL RELOCATE INSTALLED UTILITY CONNECTIONS AND ASSOCIATED STRUCTURES TO FUNCTION WITH THE NEW BUILDING ADDITION AS NECESSARY. SITE ELEMENTS THAT WERE NOT INSTALLED IN PHASE I, PRIOR TO WORK STOPPAGE, SHALL BE OMITTED OR RECONFIGURED TO ACCOMMODATE THE ADDITION. CLEANOUTS THAT ARE NOW IN PAVED AREAS SHALL BE TRAFFIC BEARING.

JACK DURRELL
 ELLINWOOD
 5/30/06
 LANDSCAPE ARCHITECT

No.	Revision	By	Appd	Date	Drawn	DRB
1	COMMENTS CO AND VDOT	DRB	JDE	05-09-06	Designed	JDE
2	COMMENTS CO 05-25-06 AND VDOT 05-23-06	DRB	JDE	05-30-06	Checked	JDE
					Approved	JDE

**VERIZON WIRELESS BUILDING ADDITION
 PHASE II THIRLANE ROAD
 LAYOUT AND UTILITY PLAN
 ROANOKE COUNTY, VIRGINIA**

SCALE: 1"=20'
 MAR. 27, 2006
 PROJECT: 05083
 C-102