



NOTE:
1. SEE SHEET G3 FOR STRUCTURE INFORMATION.

NOTE:
LIQUID PETROLEUM FACILITIES ON CITY OF ROANOKE PROPERTY ARE PERMITTED BY AGREEMENT "BK DEL R/W 64" DATED 15 SEPT. 1964 BETWEEN VIRGINIA HOLDING CORP. AND PLANTATION PIPE LINE CO. AND BY DEED NO. 3013 DATED 6 JUNE 1970 (DB 1280 PCS 185-188) CONVEYED BY VIRGINIA HOLDING CORP. TO THE CITY OF ROANOKE.

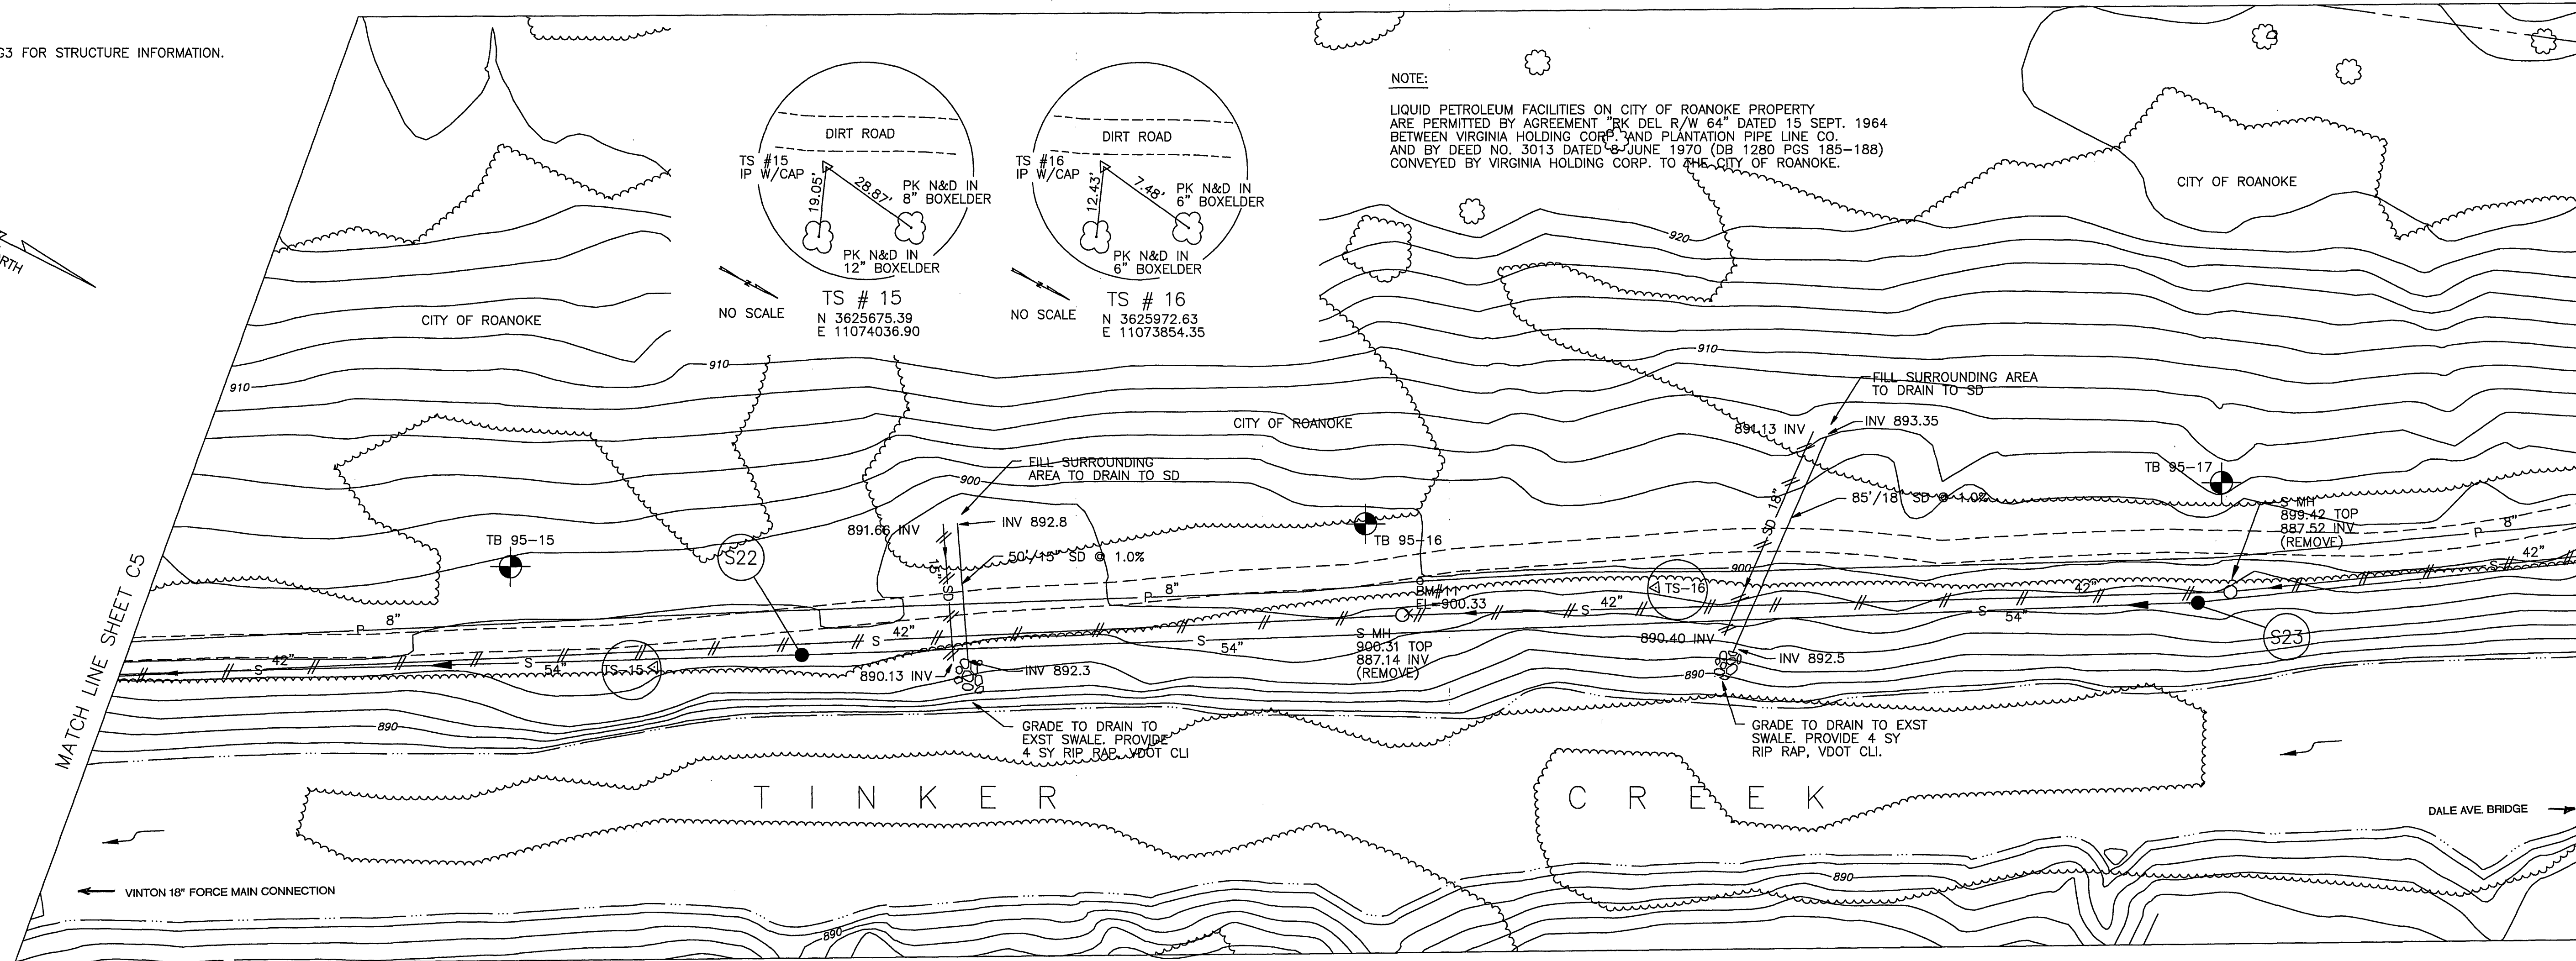

PLAN
SCALE: 1"=30'

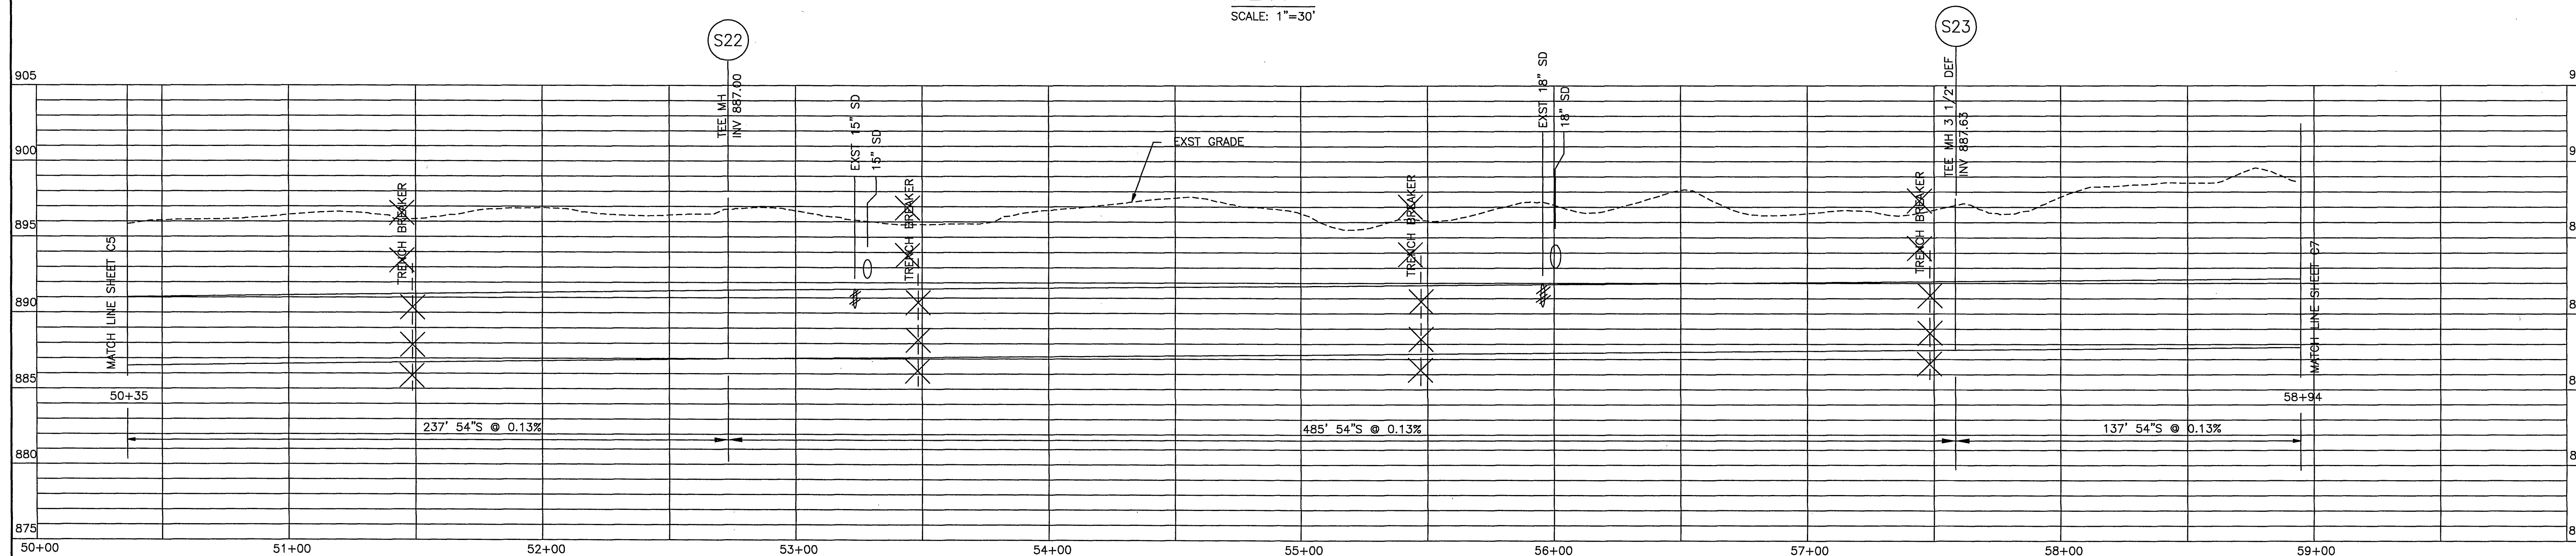

HAYES, SEAY, MATTERN & MATTERN, INC.
ARCHITECTS/ENGINEERS/PLANNERS
ROANOKE, VIRGINIA

DESIGNED: DMH	DATE		BY		REVISIONS	
	10/15/98		MNH		DESCRIPTION	
DRAWN: MHL					RECORD DRAWINGS SEE SHEET G1 FOR NOTE	
CHECKED:						
APPROVED:						

GRAPHIC SCALES

VERTICAL 1" = 5'
HORIZONTAL 1" = 30'

TINKER CREEK INTERCEPTOR SEWER
CITY OF ROANOKE, VIRGINIA

PLAN AND PROFILE
STA 50+35 TO STA 58+94

COMM. NO.: 7211 SCALE: AS NOTED DATE: MAY 17, 1996

PROJECT NO.: 6317
CONTRACT A
SHEET NO.
C6
RECORD DRAWINGS