

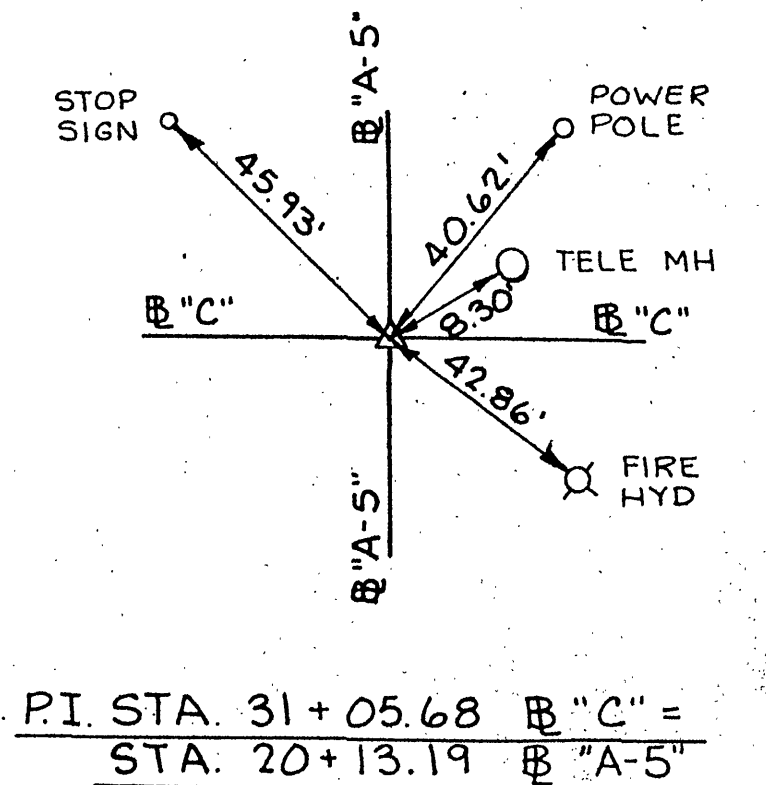


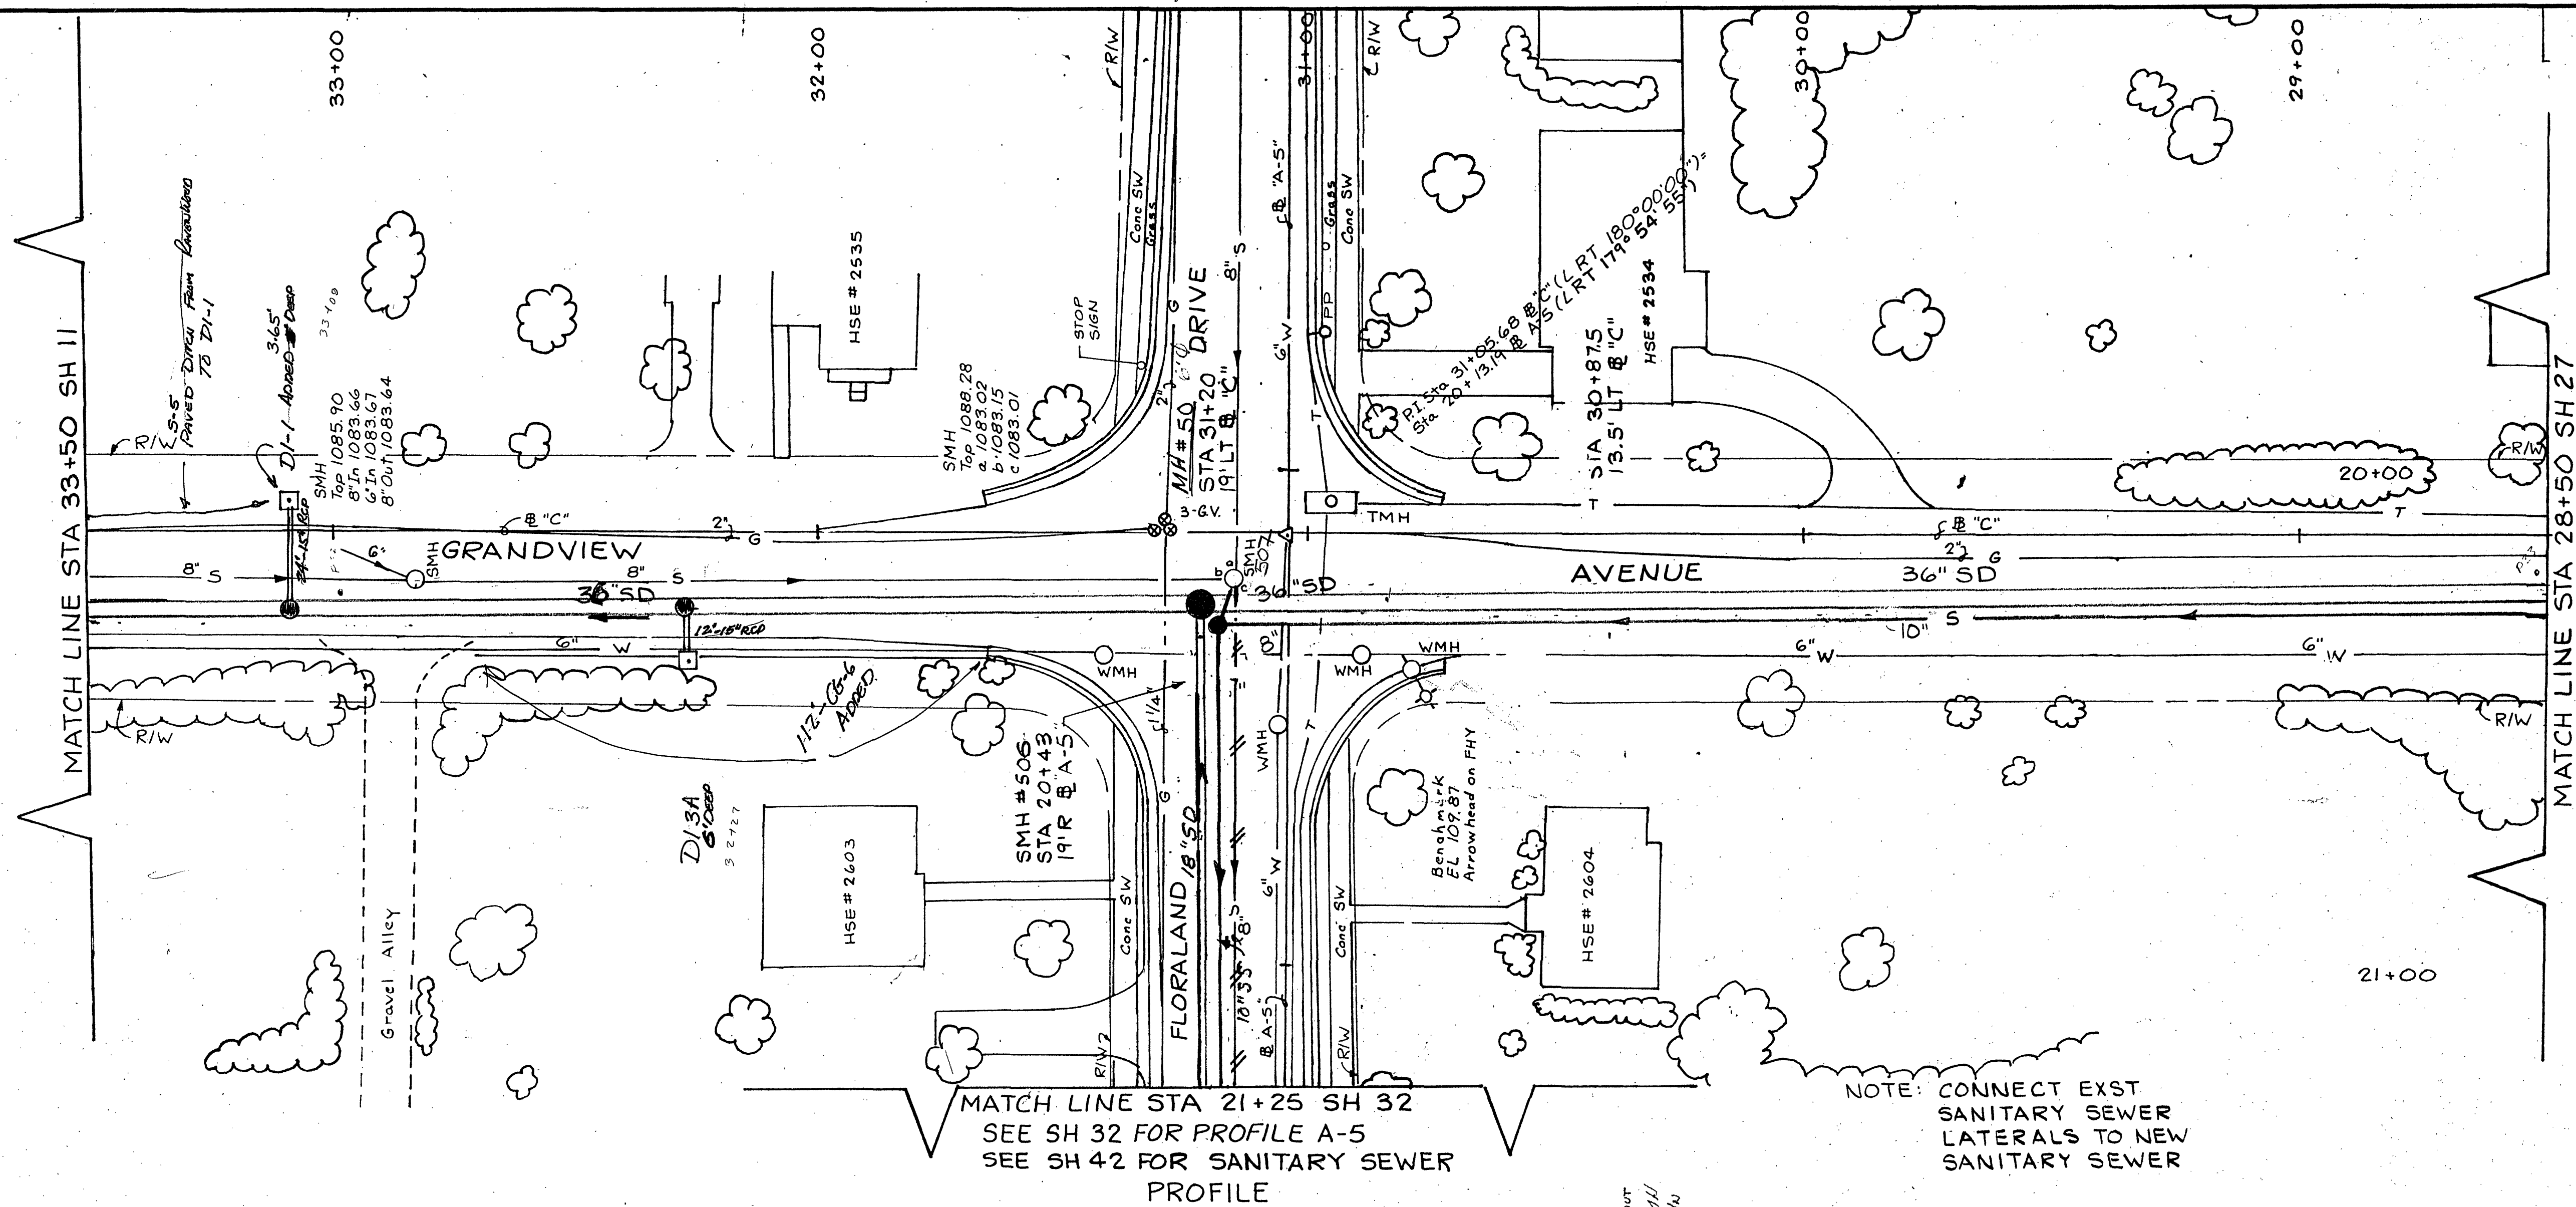


SCALE: HORIZ - 1" = 20'
VERT - 1" = 10'

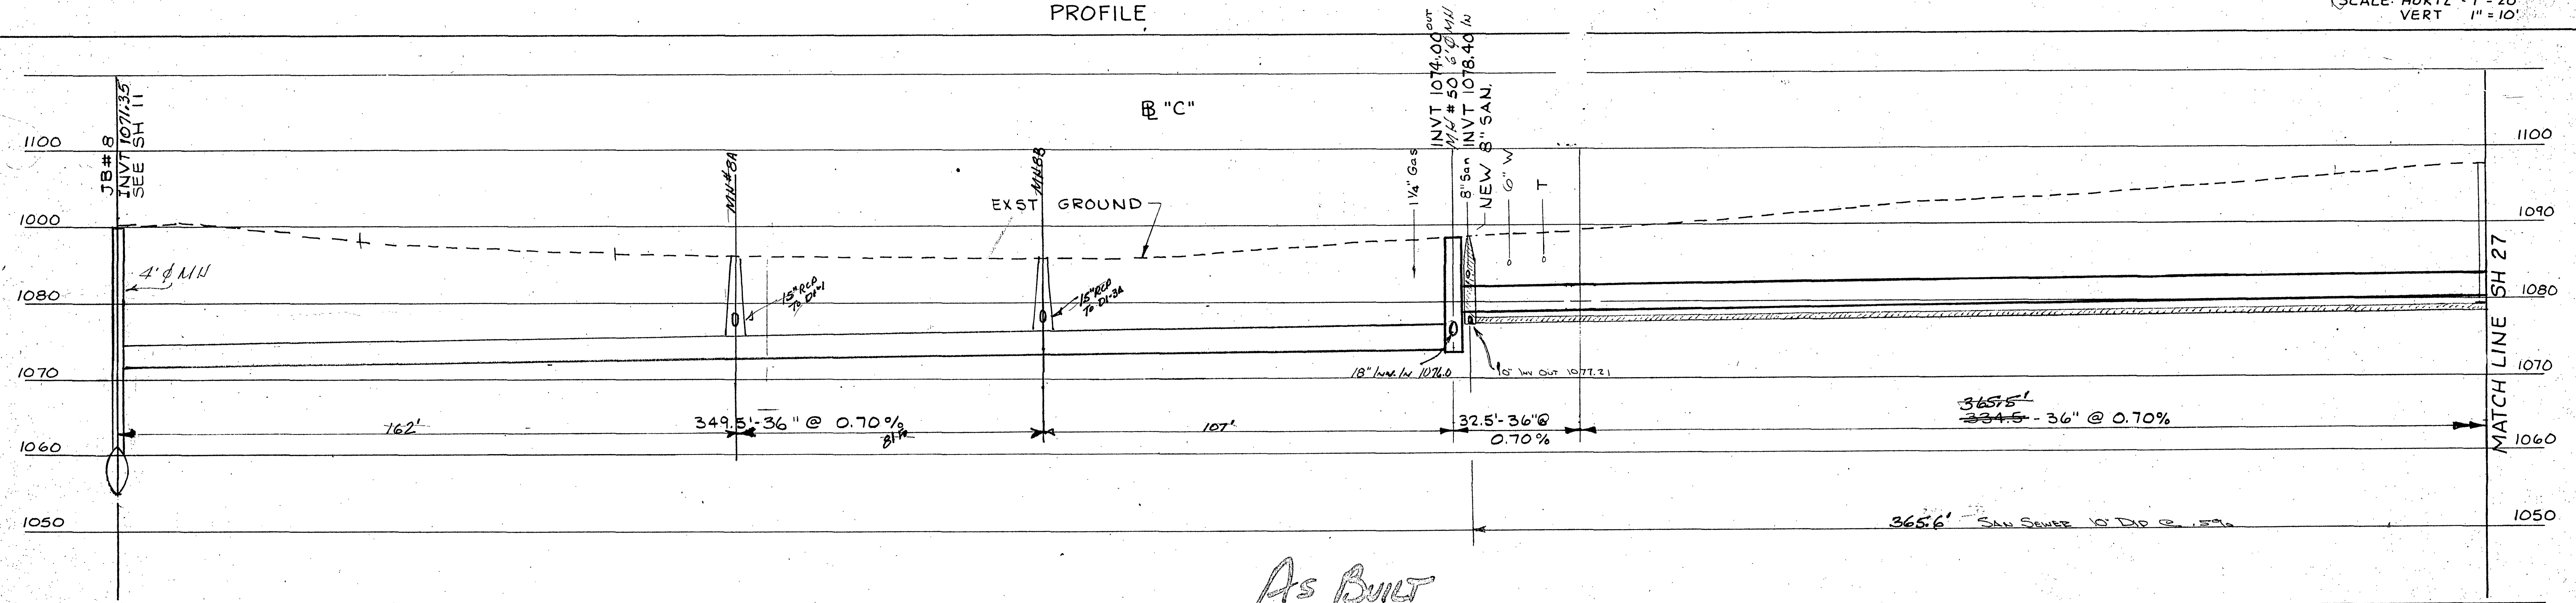

As Built

Mattern & Craig
CONSULTING ENGINEERS
SUITE 401, 707 S. JEFFERSON STREET, ROANOKE, VIRGINIA 24011 (703) 345-9342

DESIGNED: JIJ / SWH
CHECKED: SWH
APPROVED: SWH

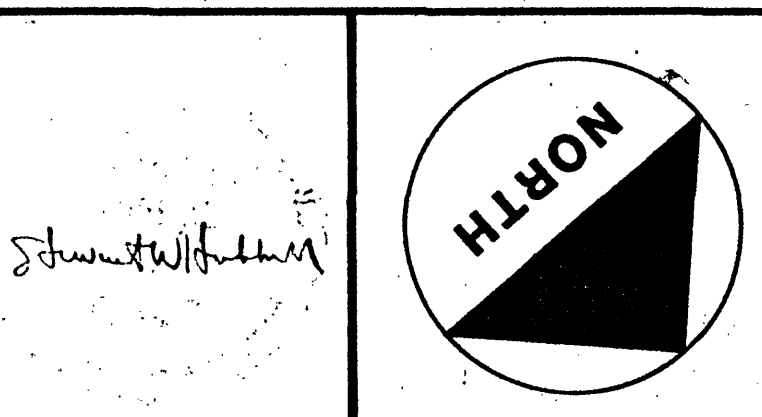

REVISION	DATE	DESCRIPTION	BY	APP.
1	2/1/90	12" RCP to 36" RCP	LGL	

DATE
JULY 1986
COMM.
582

WILLIAMSON ROAD STORM DRAIN - PHASE 2
CONTRACT I-C
ROANOKE, VIRGINIA
PLAN AND PROFILE

SHEET
26