
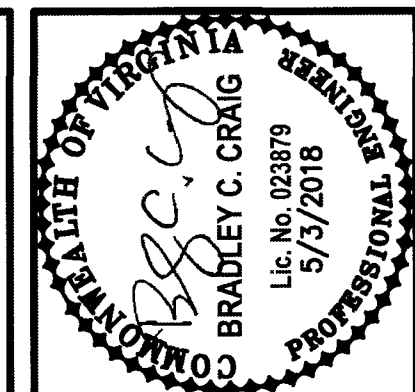
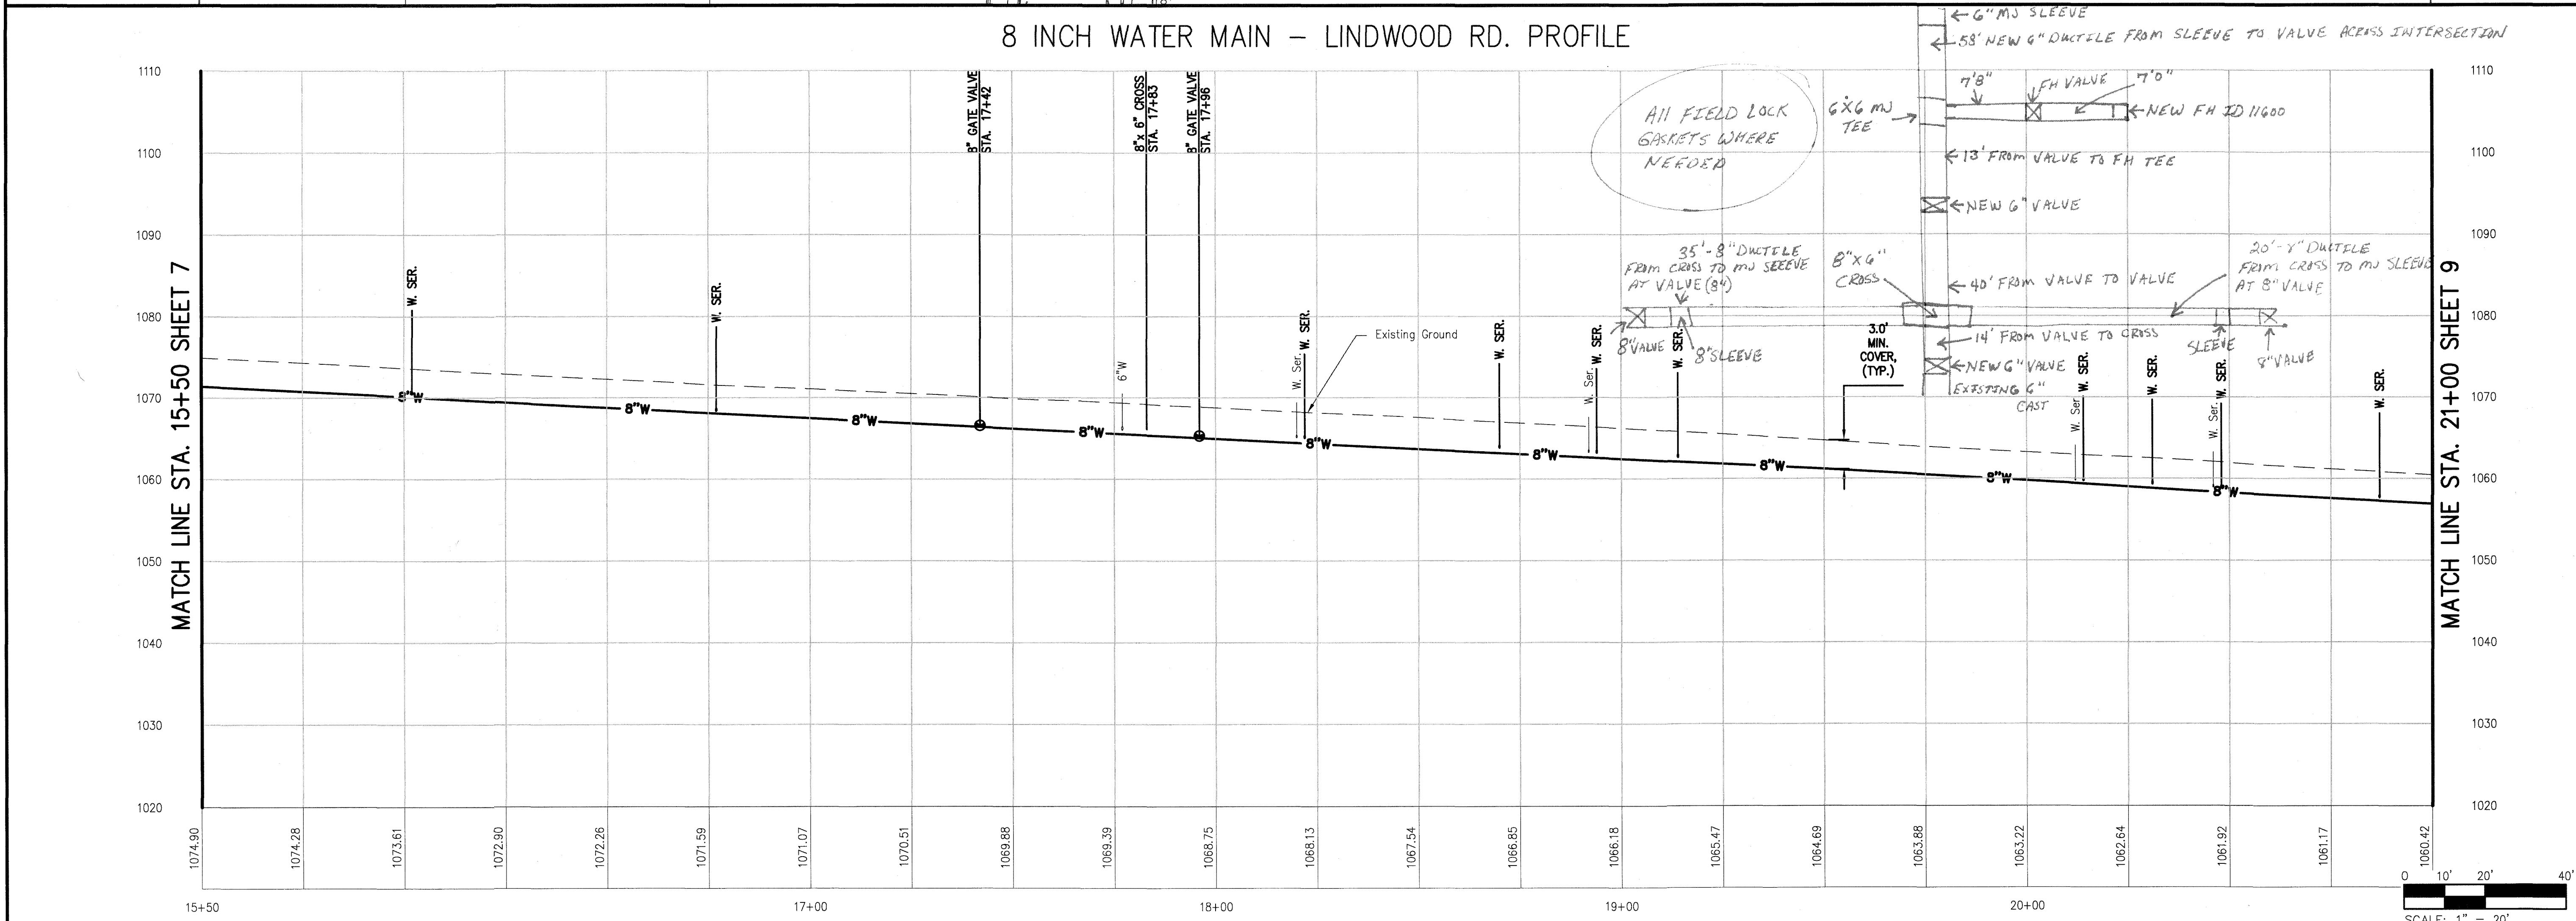


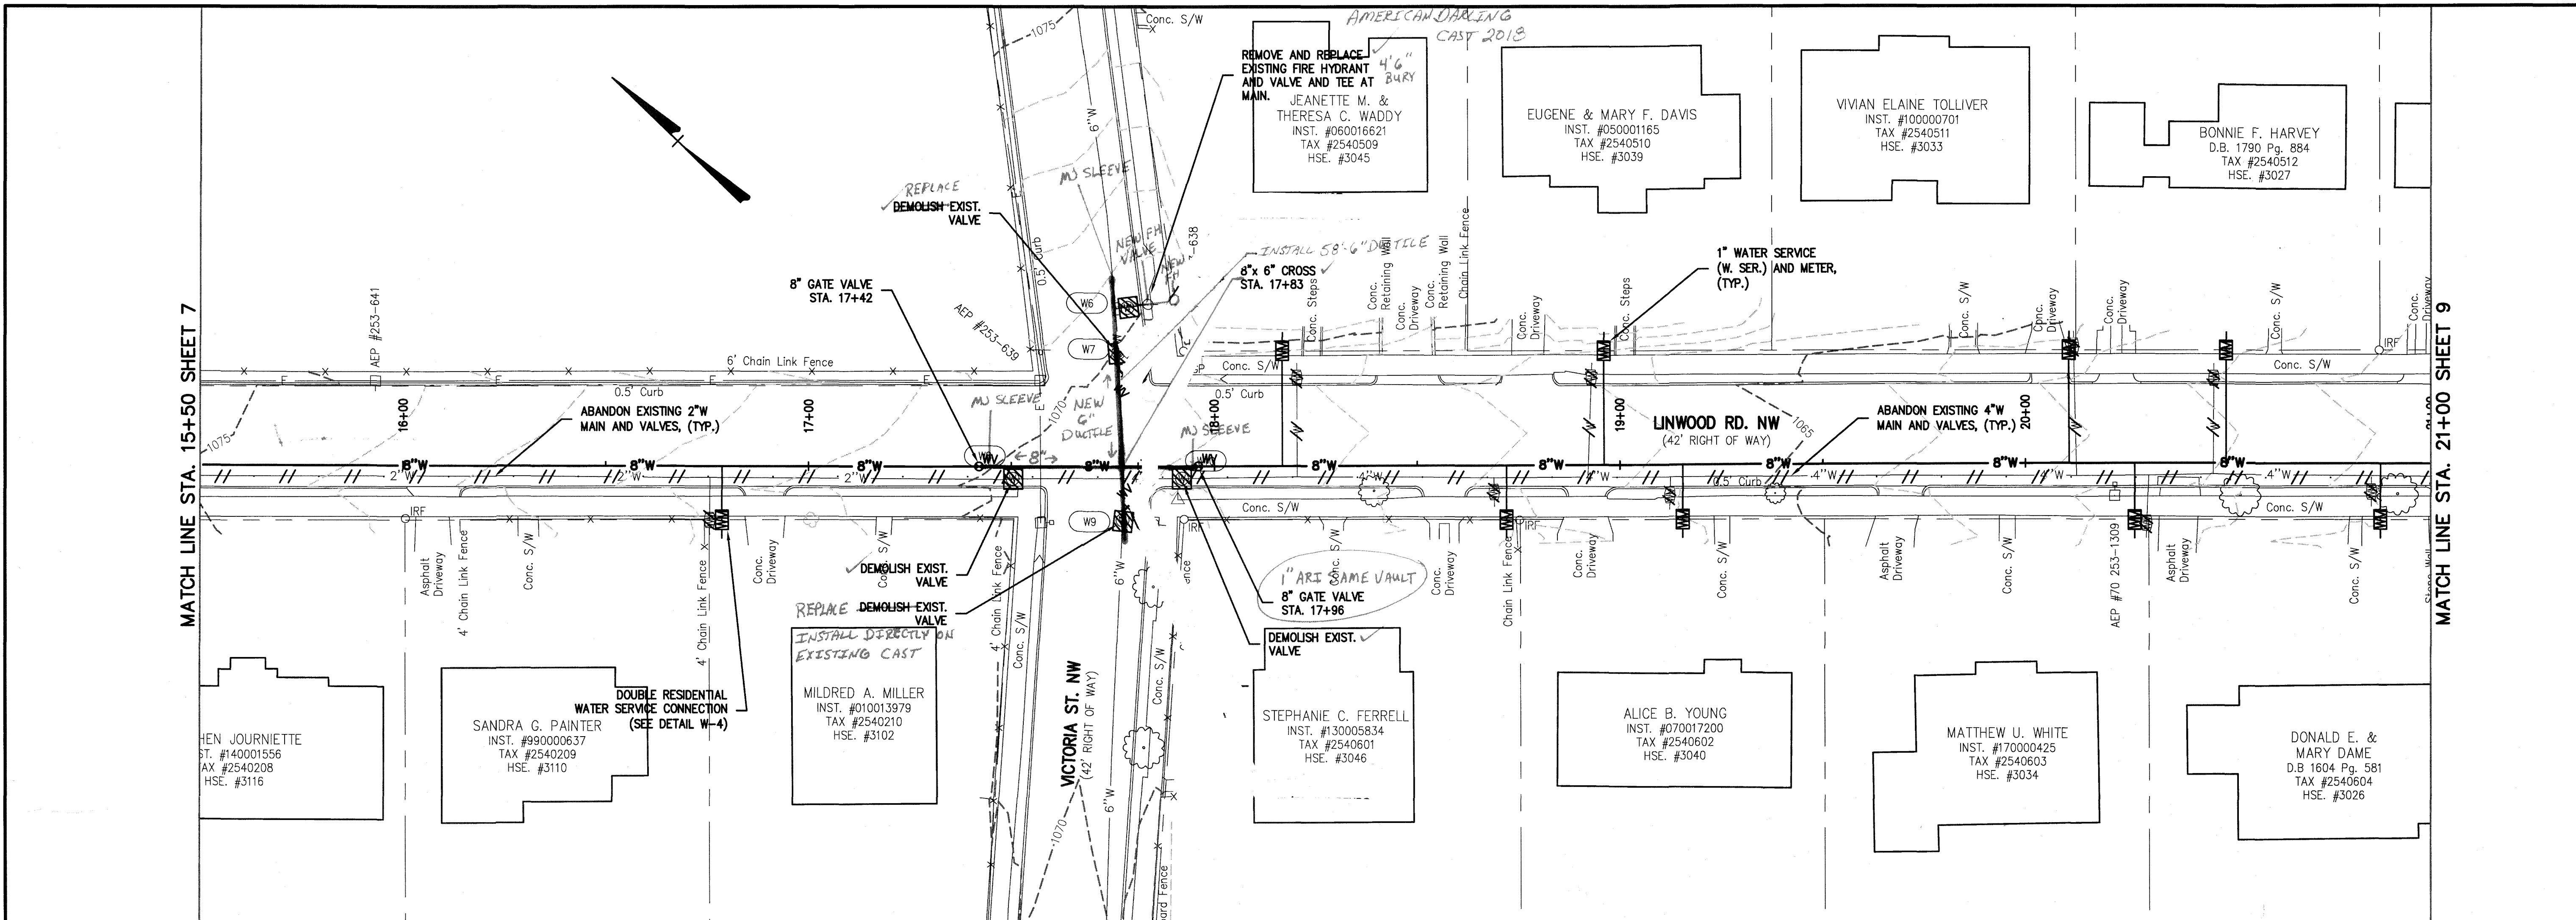

Revisions	Date
REVISED PER ADDENDUM # 2	5/3/18

Issue Date:	May 3, 2018
Drawn By:	DBL/ARB
Designed By:	DBL
Checked By:	BCC
Date:	5/3/2018

Mattern & Craig
ENGINEERS-SURVEYORS
701 FIRST STREET, S.W.
ROANOKE, VIRGINIA 24016
(540) 345-9342
FAX (540) 345-7891

WILLOW ROAD/LINWOOD ROAD WATERLINE REPLACEMENT
PLAN AND PROFILE - 8" WATERLINE
WESTERN VIRGINIA WATER AUTHORITY

Vertical Scale:
1" = 10'

Horizontal Scale:
1" = 20'

Commission Number:
3812

Sheet No.:
8