




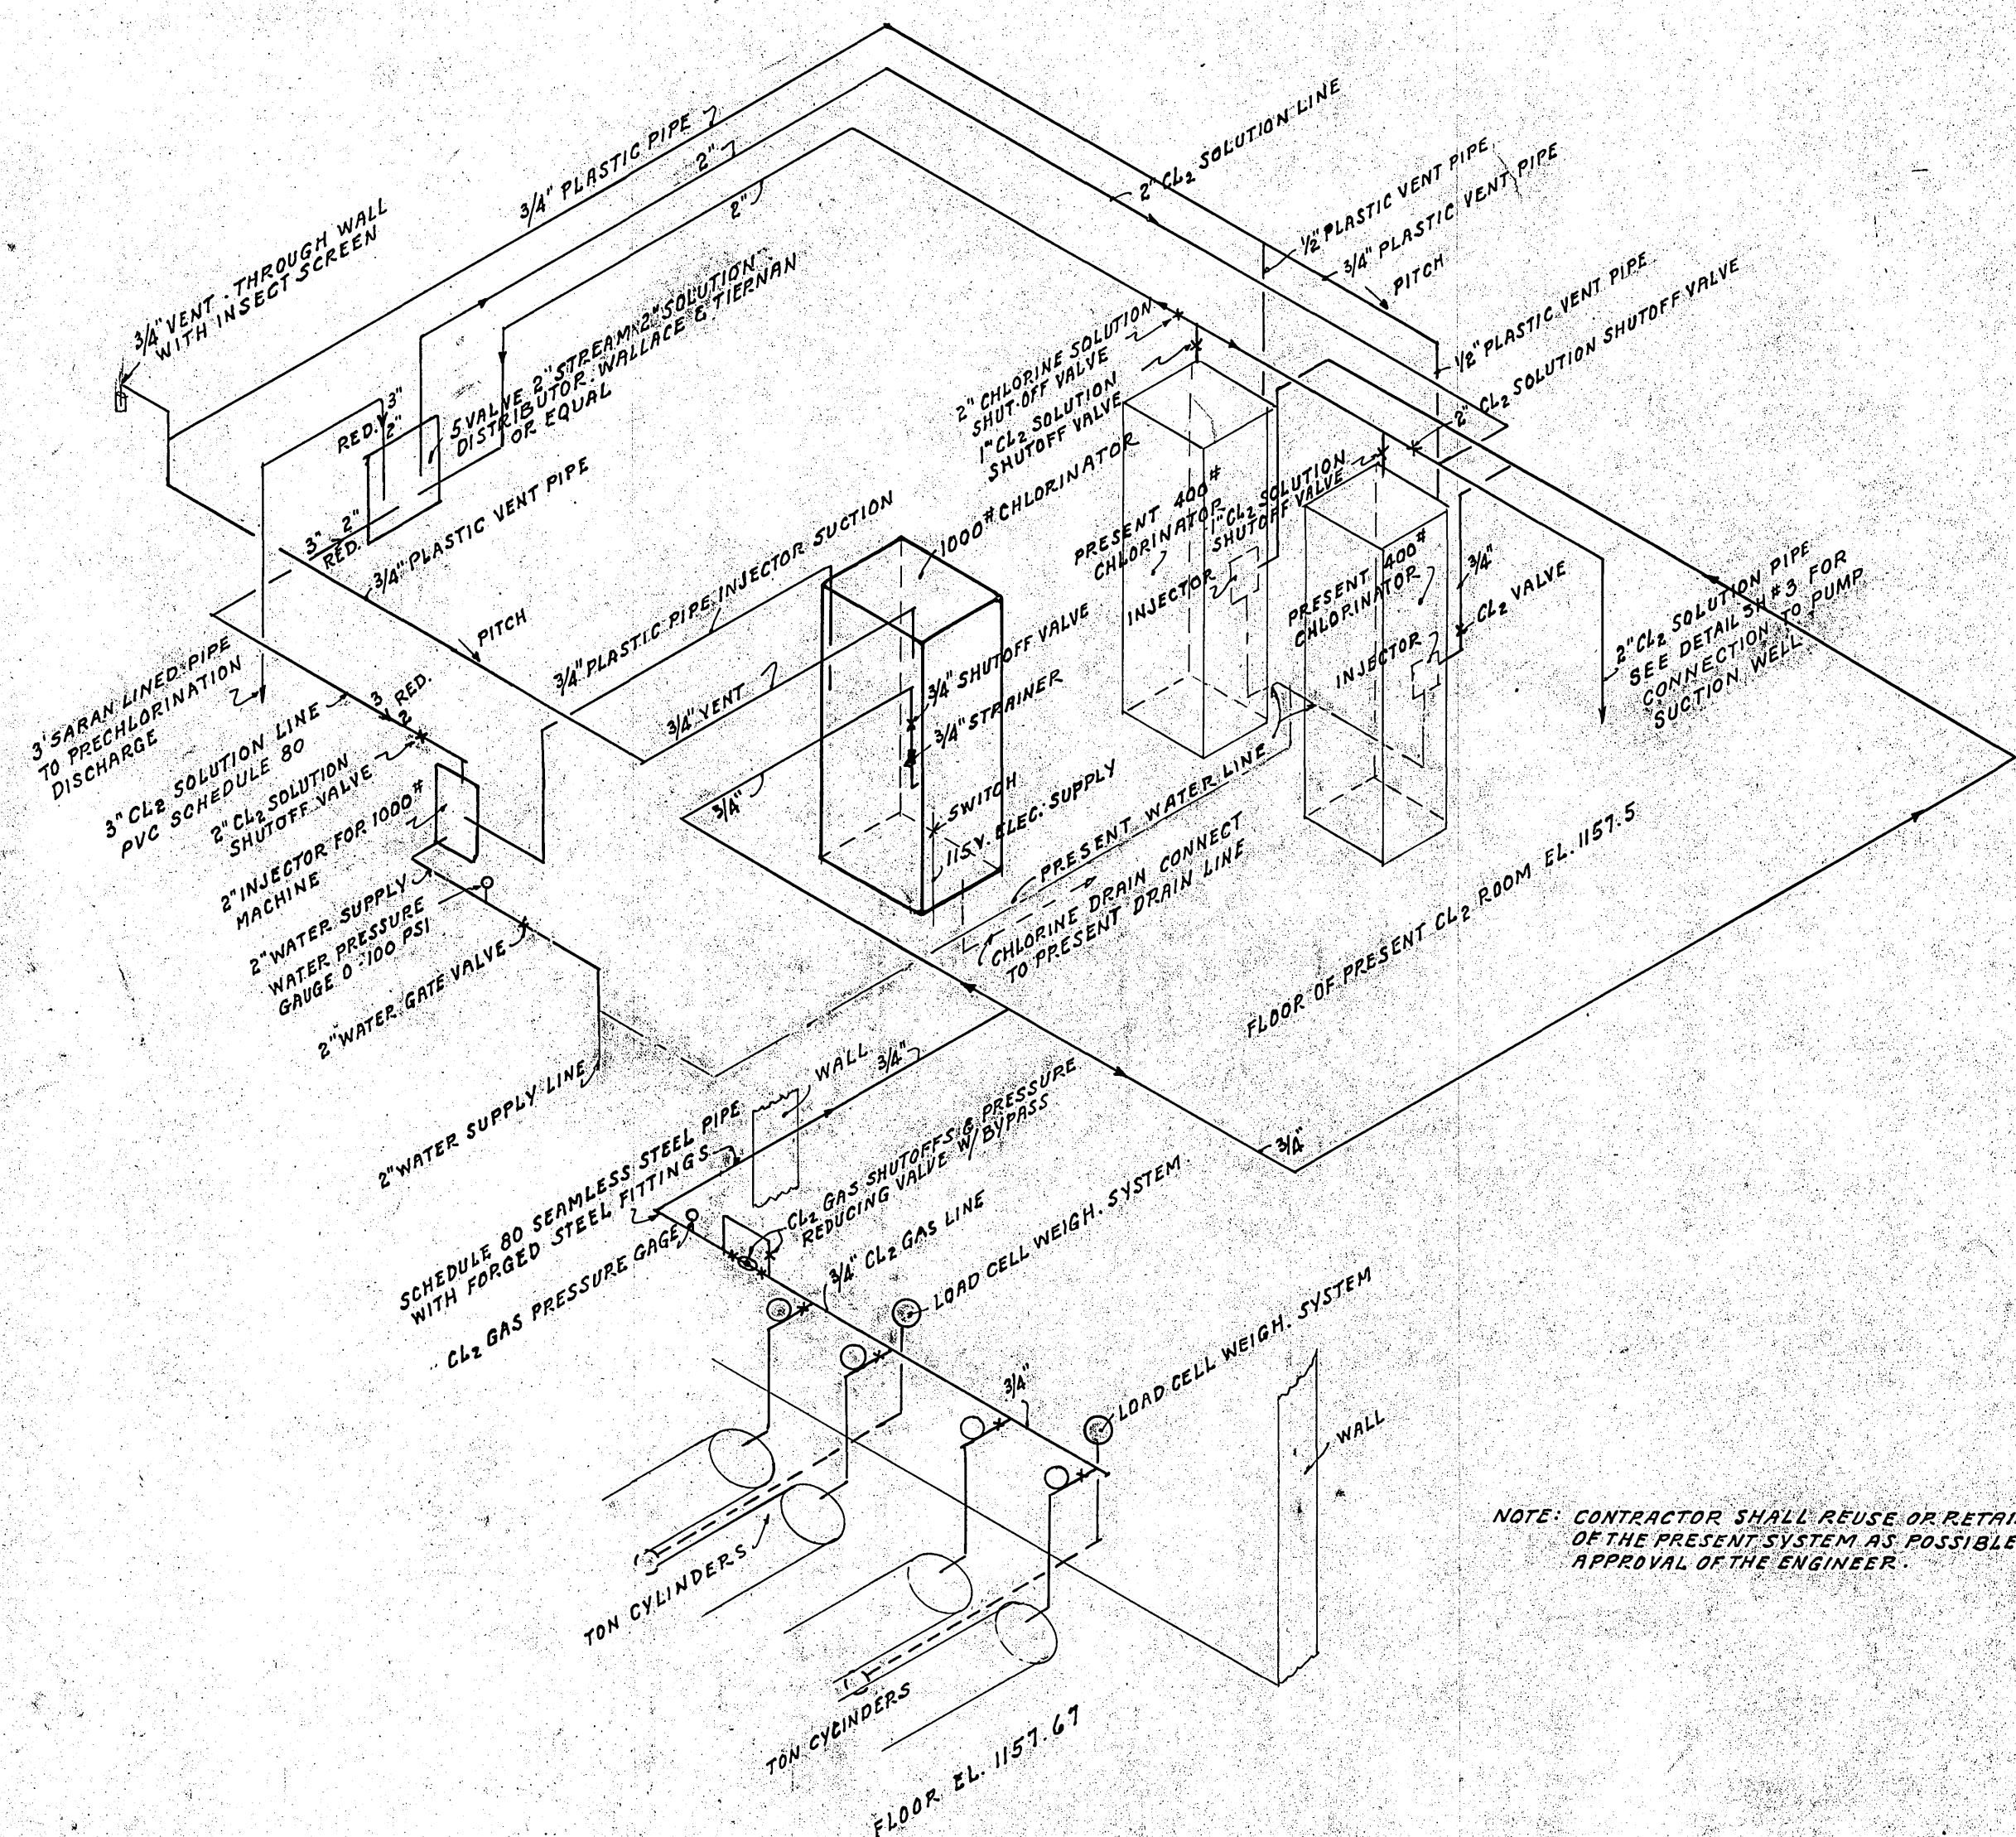


SCHEMATIC CHLORINE SYSTEM
NO SCALE

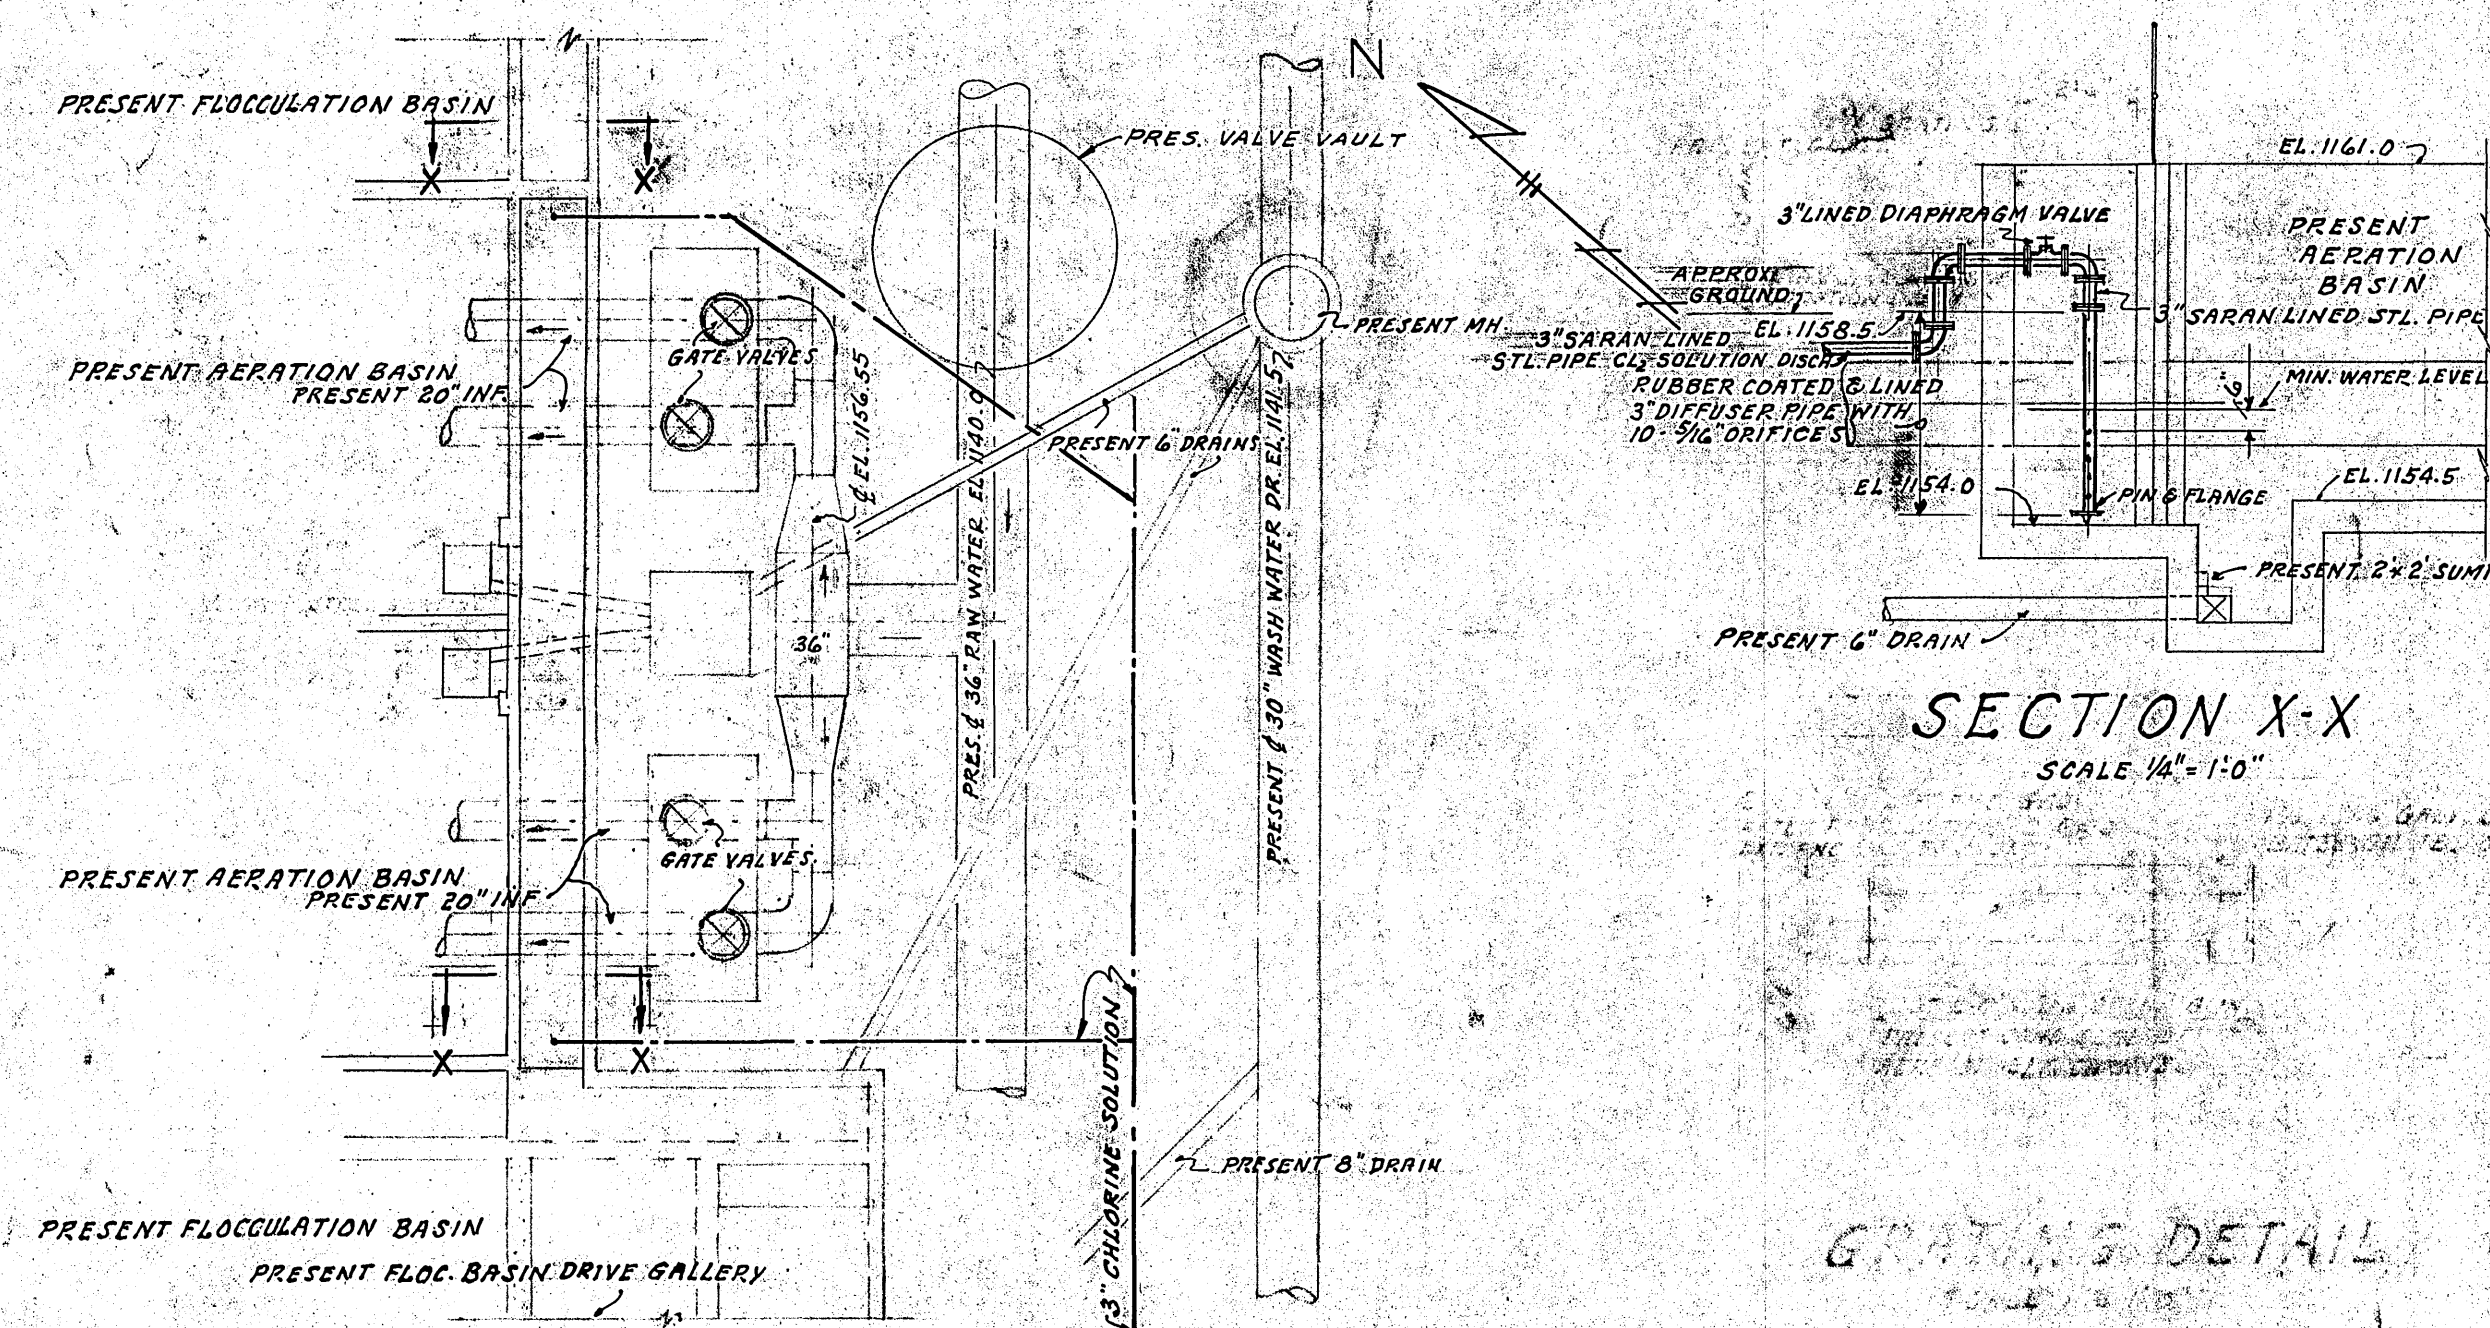


PRESENT YARD PIPING & DETAILS AT PRESENT AERATION BASIN

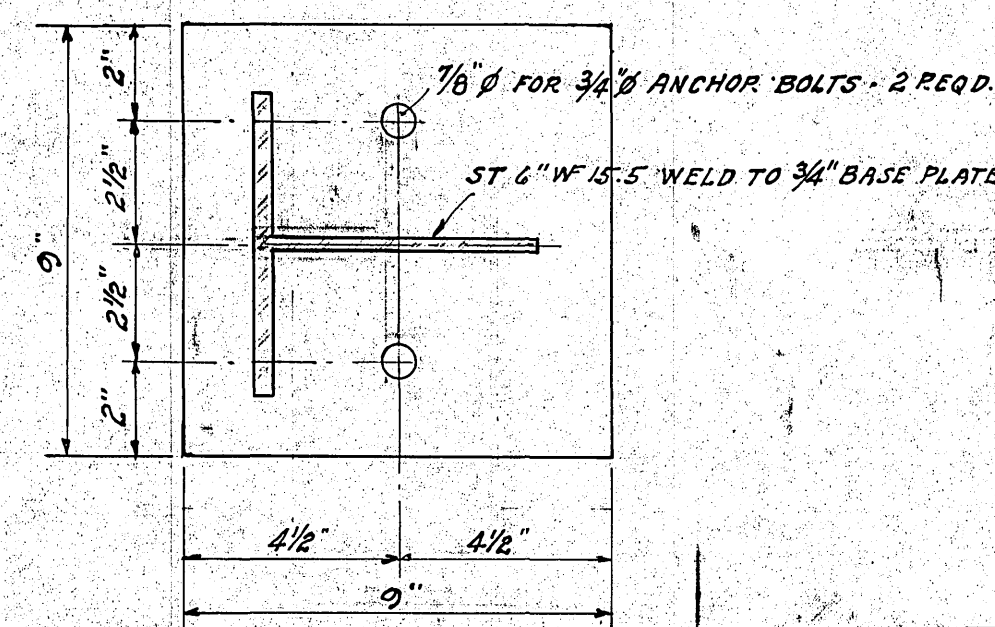


BASE PLATE DETAIL
SCALE 3" = 1'-0"

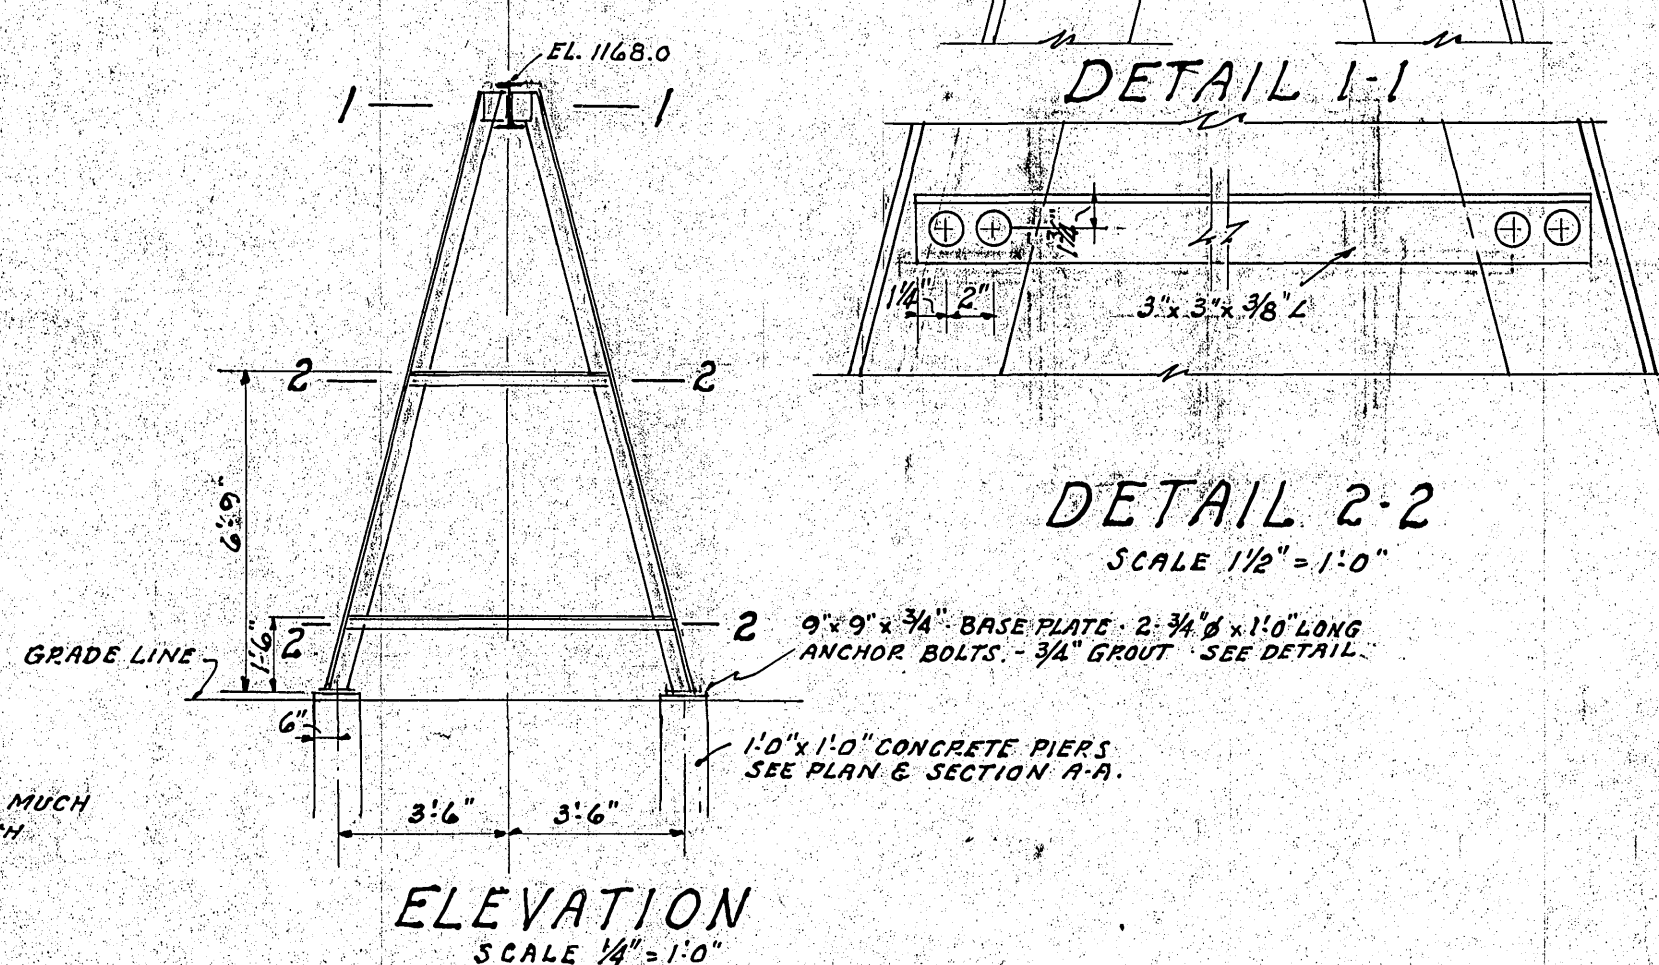


DETAILS OF "A" FRAME

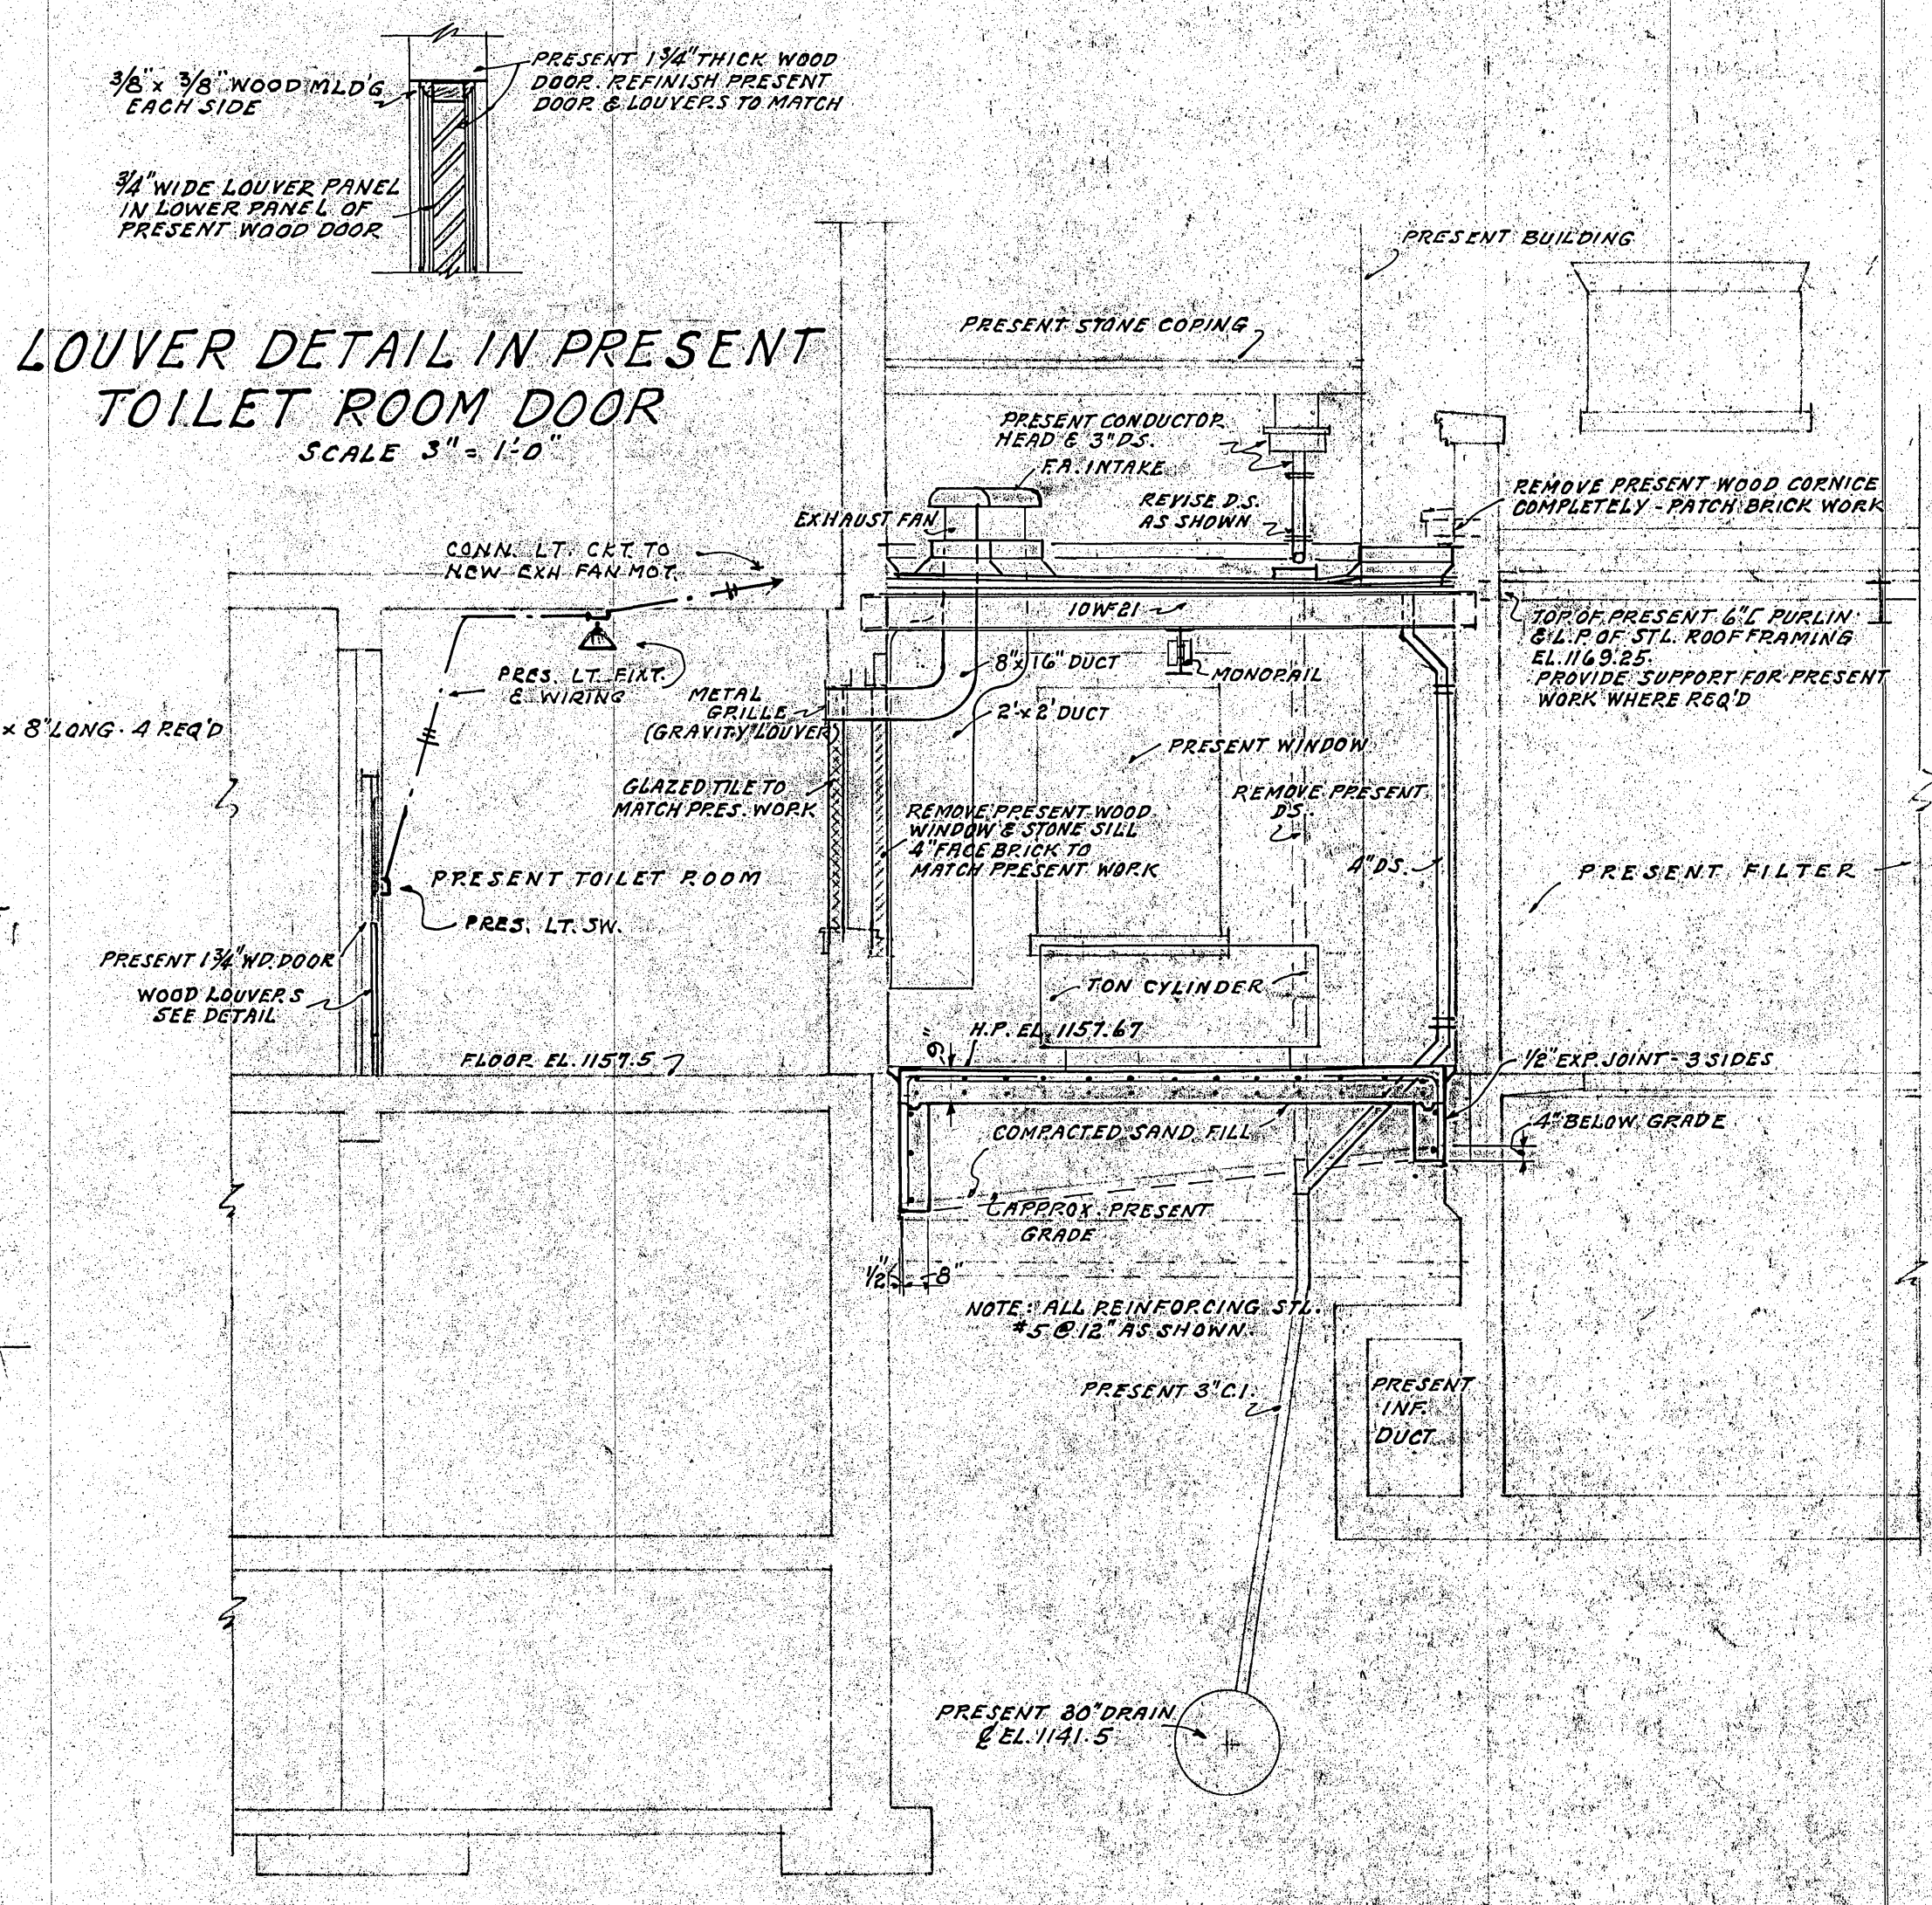

SECTION D-D
SCALE 1/4" = 1'-0"

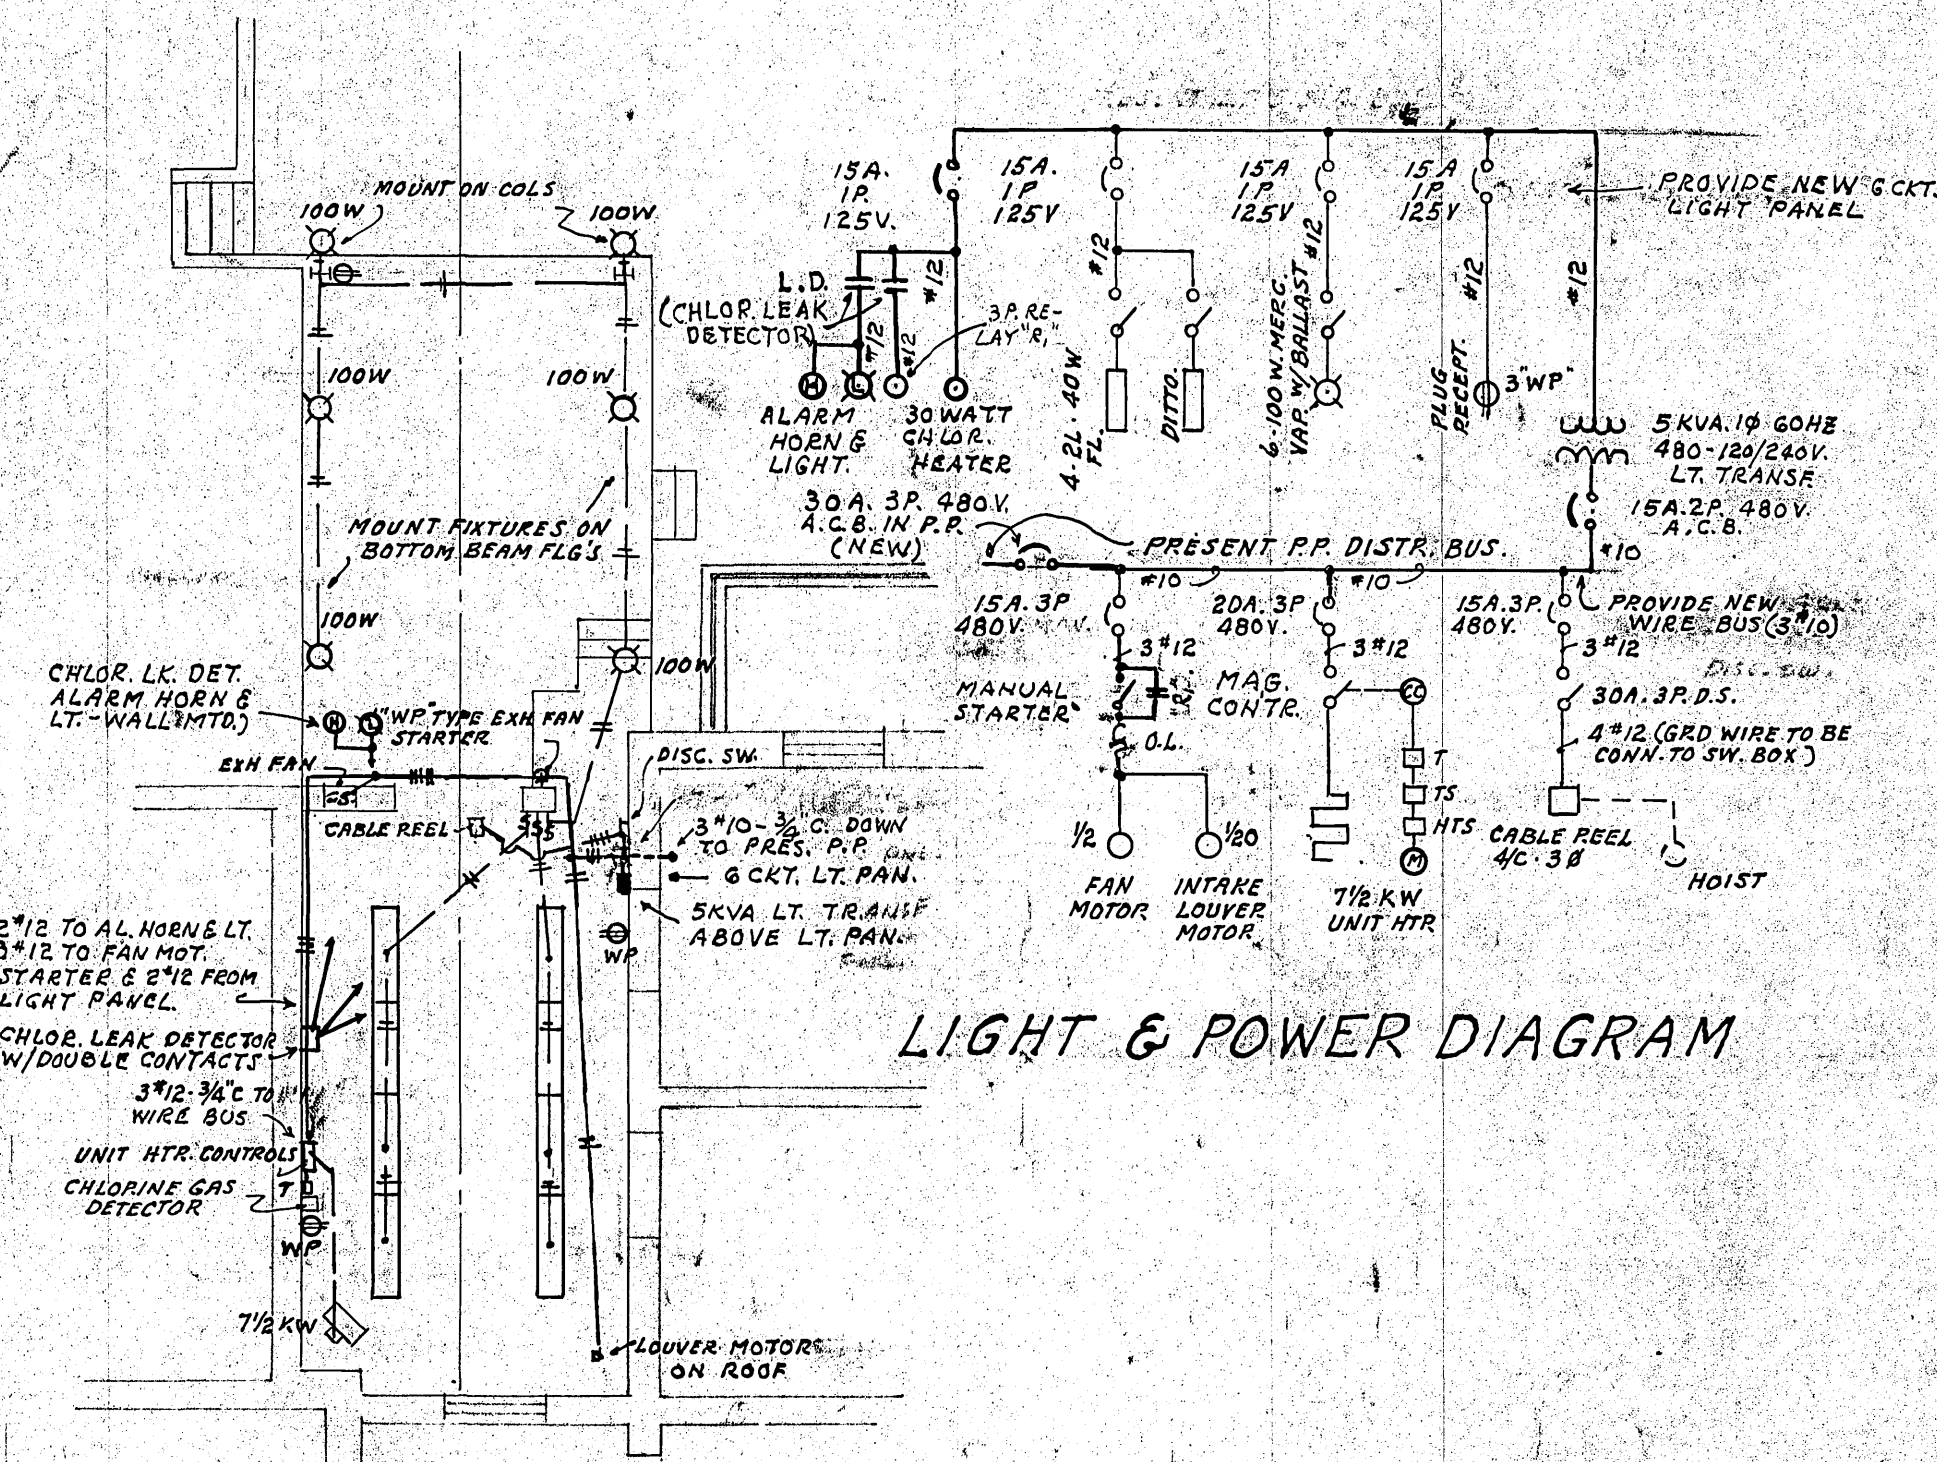

PLAN
SCALE 1/8" = 1'-0"
ELECTRICAL LAYOUT

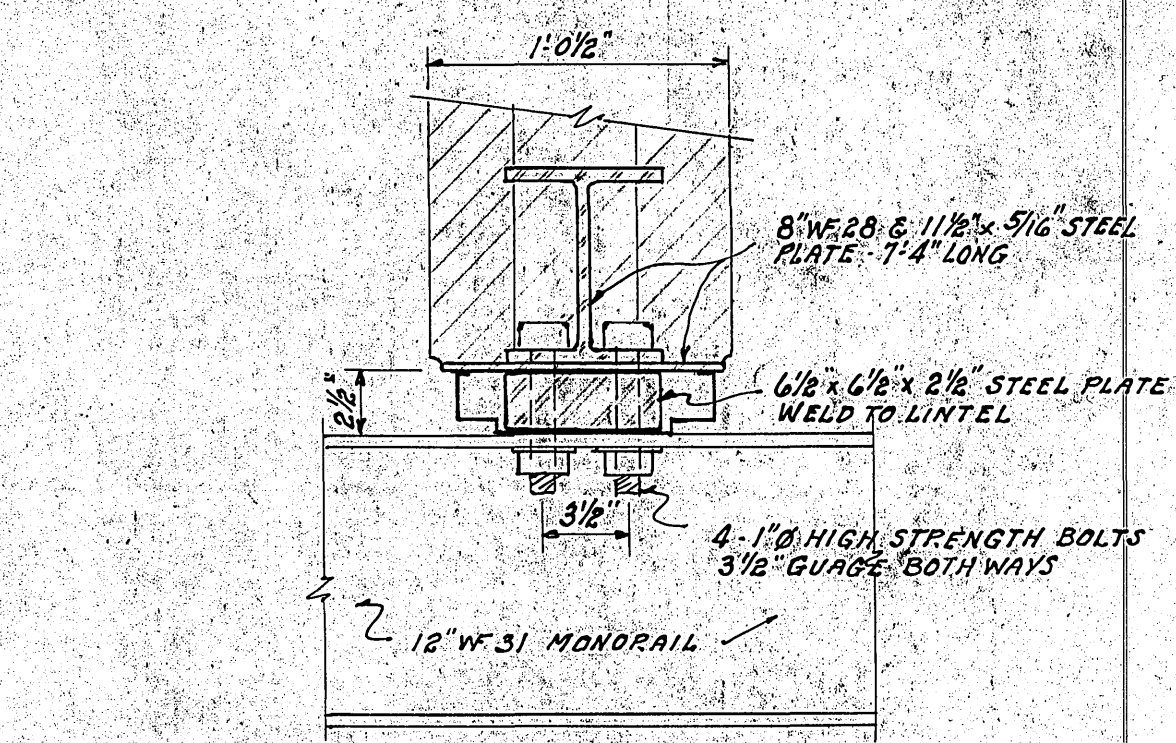

DETAIL OF MONORAIL AT DOOR
SCALE 1 1/2" = 1'-0"

