
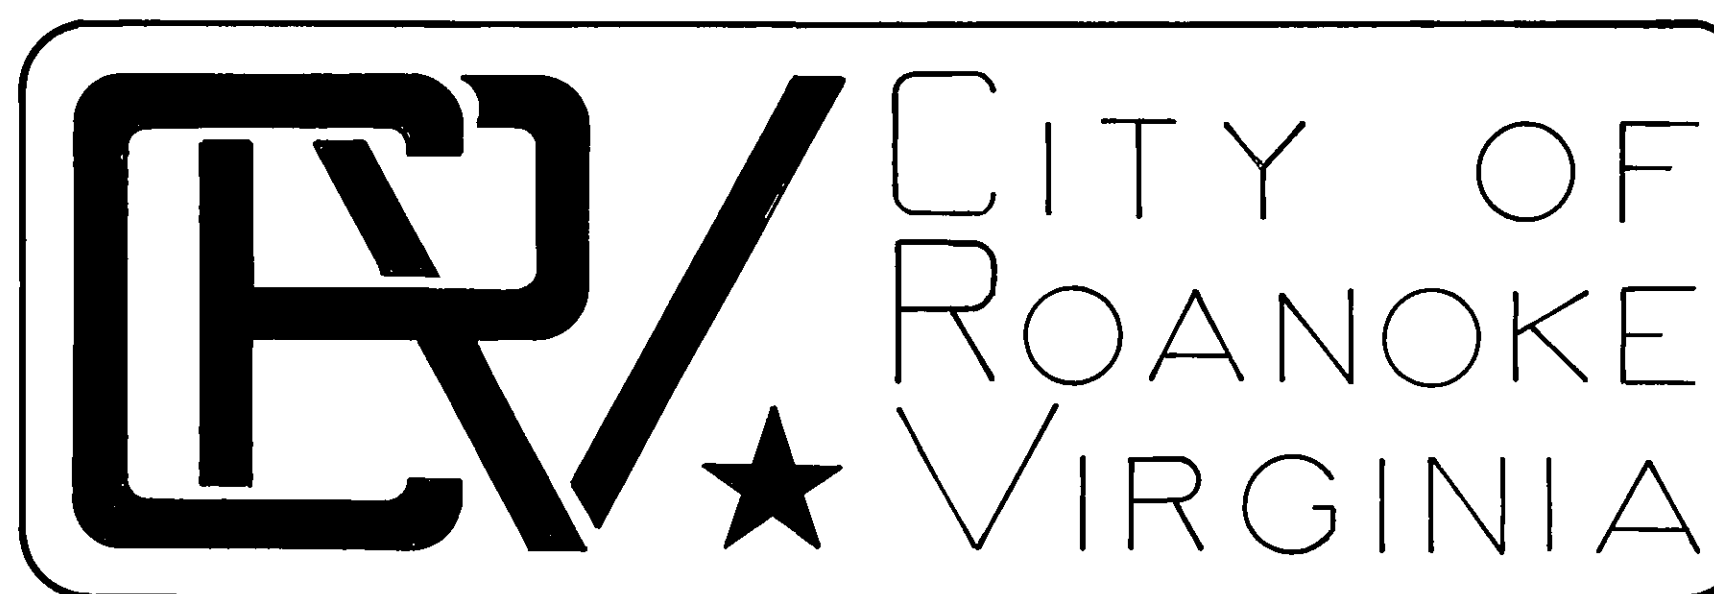


PROJECT LOCATION MAP

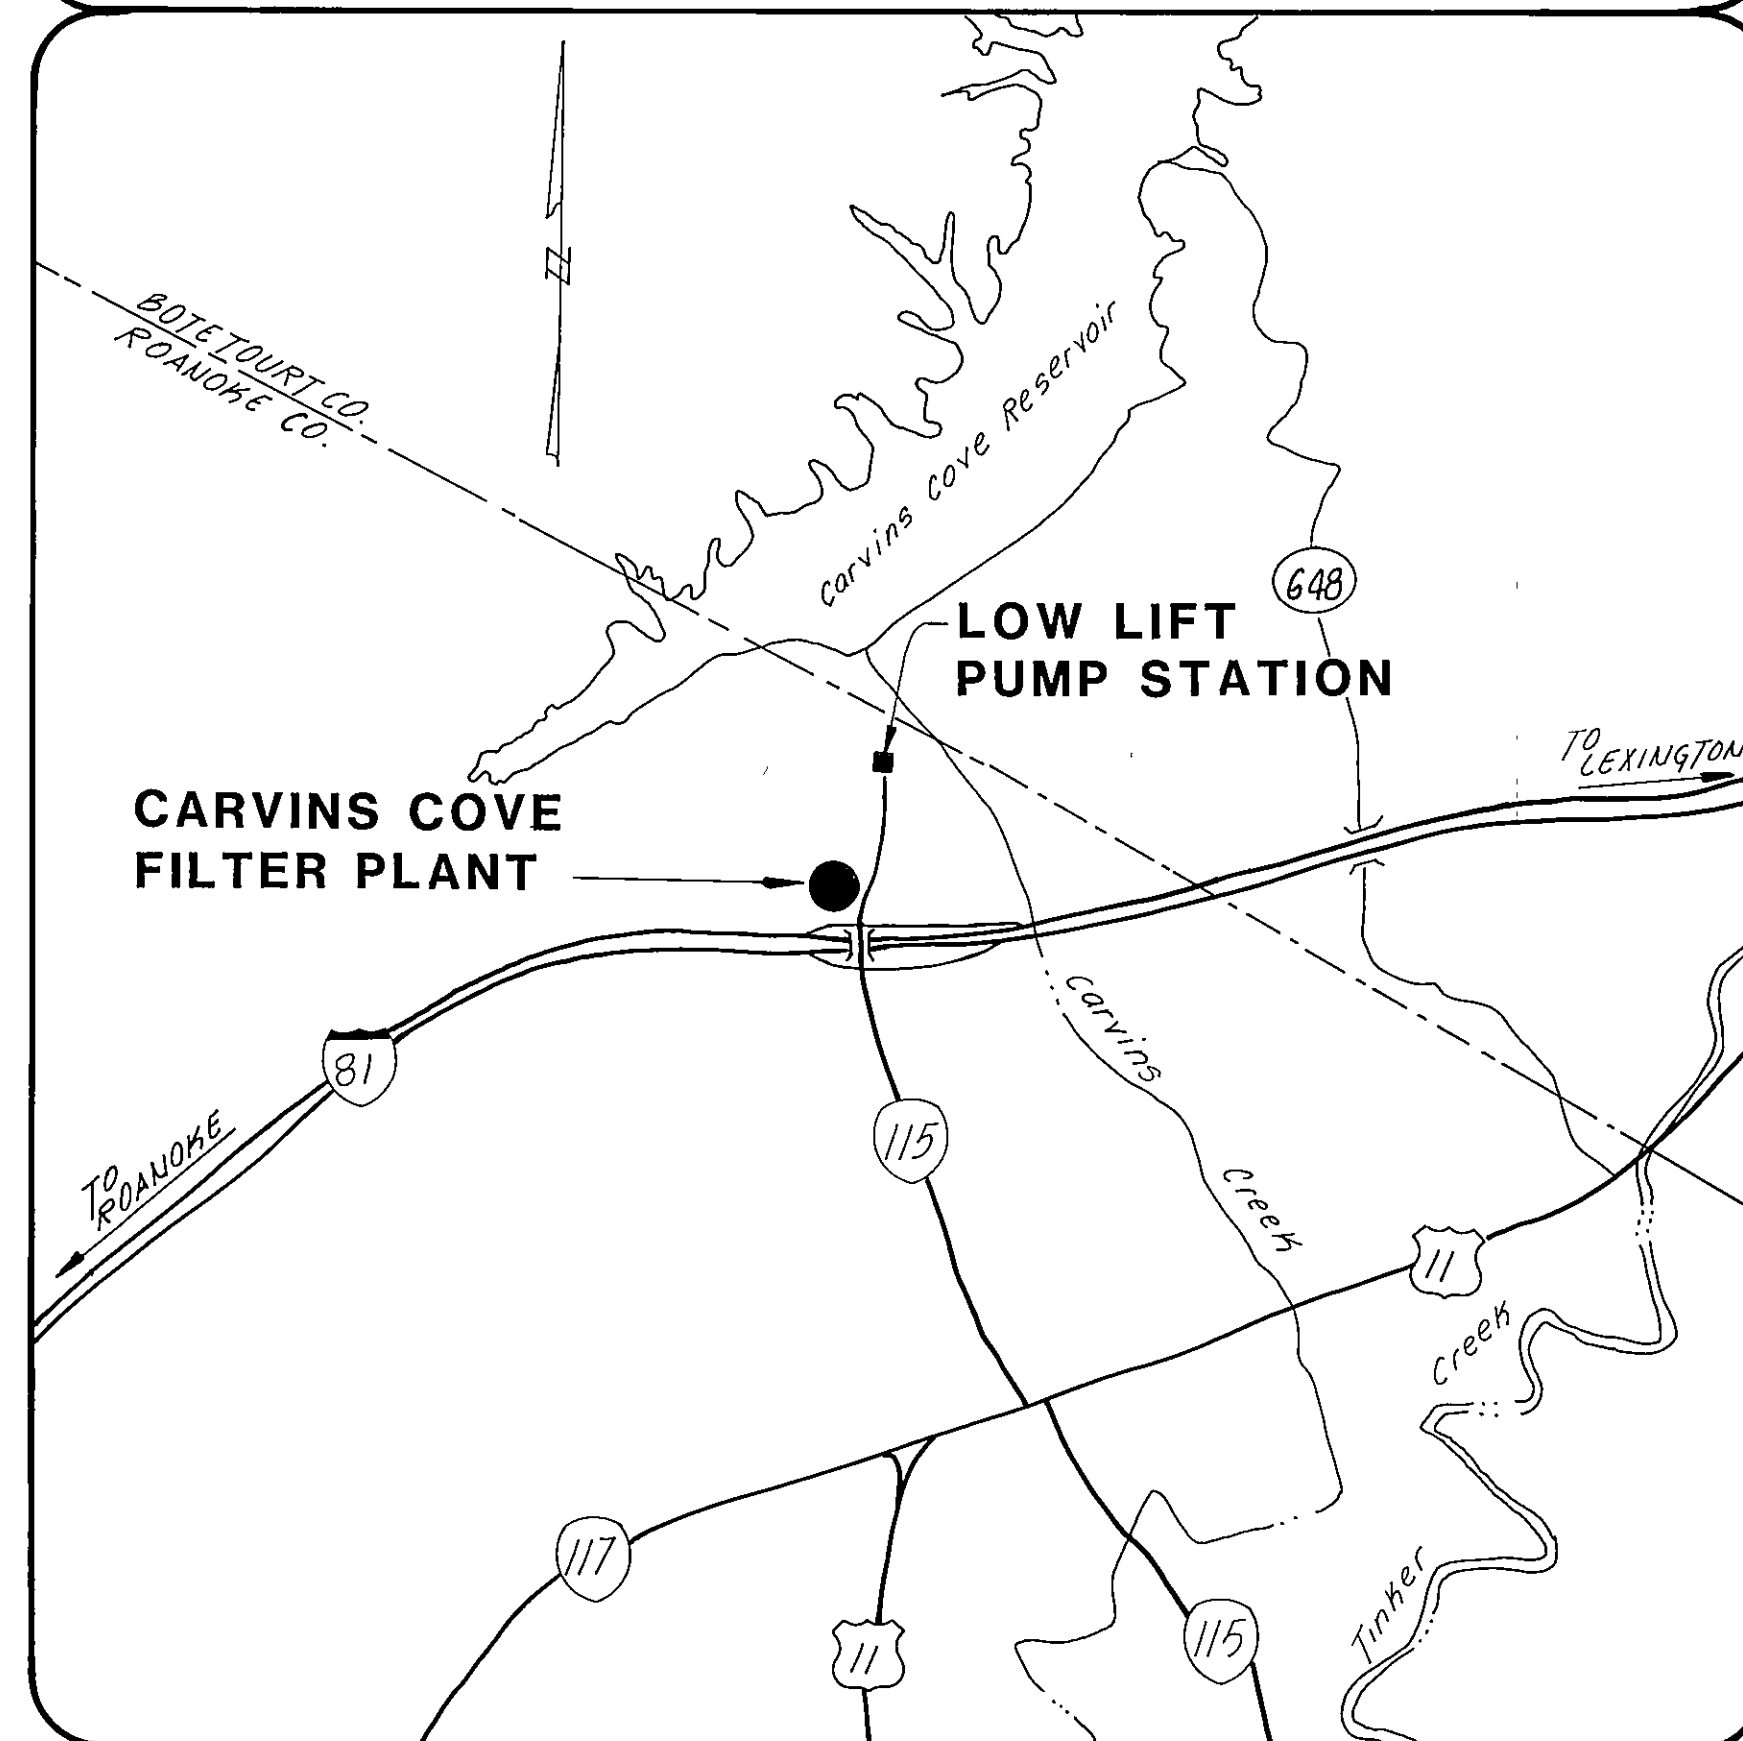

OFFICE OF CITY ENGINEER
ROOM 350
MUNICIPAL BUILDING
215 CHURCH AVENUE, S.W.
ROANOKE, VIRGINIA 24011

INDEX OF SHEETS

- 1 TITLE SHEET
- 2 ABBREVIATIONS, LEGEND, GENERAL NOTES AND VICINITY MAP
- 3 FILTER PLANT FRONT AND REAR ELEVATIONS
- 4 FILTER PLANT LEFT AND RIGHT ELEVATIONS
- 5 LOW LIFT PUMP STATION FRONT, LEFT AND RIGHT ELEVATIONS

CONSULTING ENGINEERS

**MATTERN AND CRAIG
CONSULTING ENGINEERS
ROANOKE, VIRGINIA**

COMMISSION NUMBER: **567**

<i>Stewart W. Huber</i>		
-------------------------	--	--

PROJECT NAME

**EXTERIOR PAINTING
CARVINS COVE FILTER PLANT
AND LOW LIFT PUMP STATION**

PROJECT NO. **85-15**
COMM. NO. 567

PROJECT NUMBER: **85-15**

REVISION	BY	DESCRIPTION:	DATE
REVISION	BY	DESCRIPTION:	DATE
REVISION	BY	DESCRIPTION:	DATE
REVISION	BY	DESCRIPTION:	DATE

APPROVED FOR CONSTRUCTION

ROANOKE CITY ENGINEER

DATE

DIRECTOR OF PUBLIC WORKS

DATE

DIRECTOR OF UTILITIES AND OPERATIONS

DATE

DATE

DATE

ADVERTISED DATE: **MAR 16 1986**

SET NUMBER: **FIVE**

SHEET NUMBER: **1** OF **5**

was rebid
is valid project