
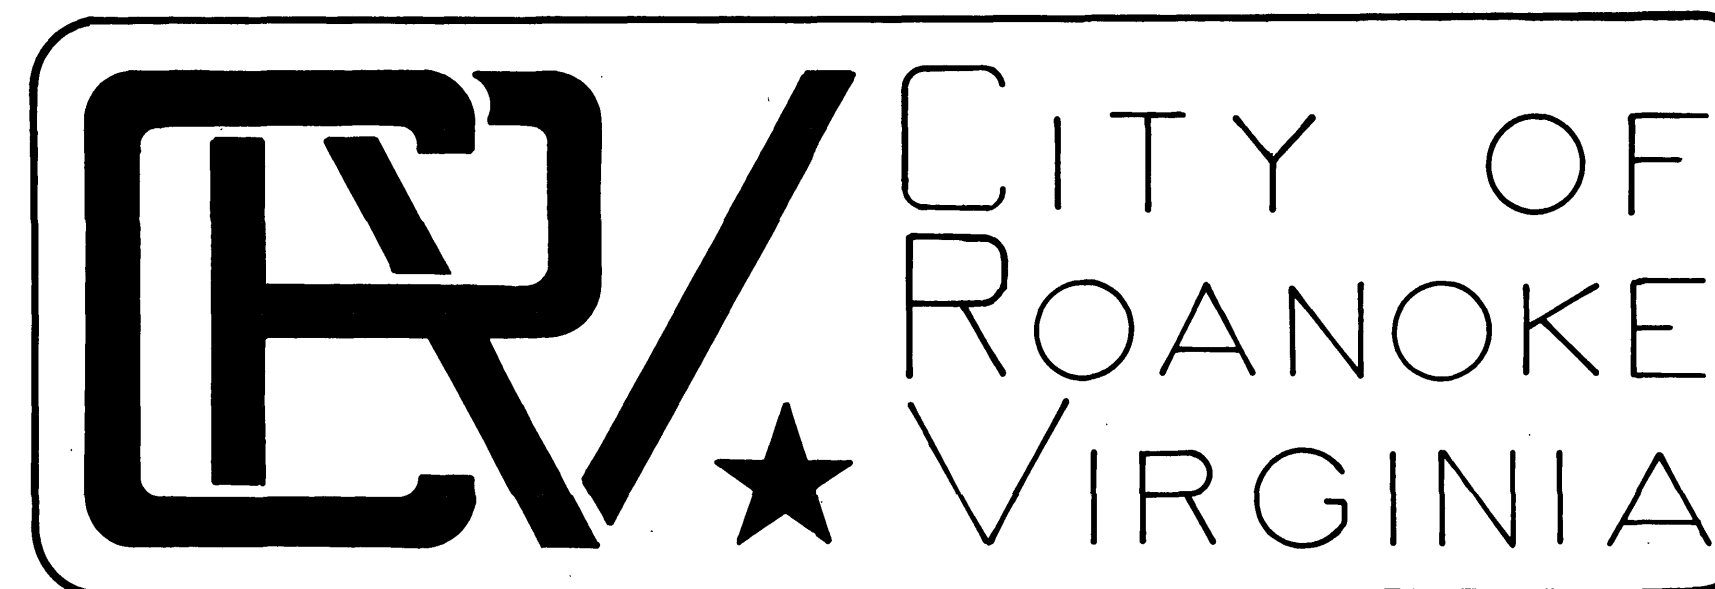


PROJECT LOCATION MAP

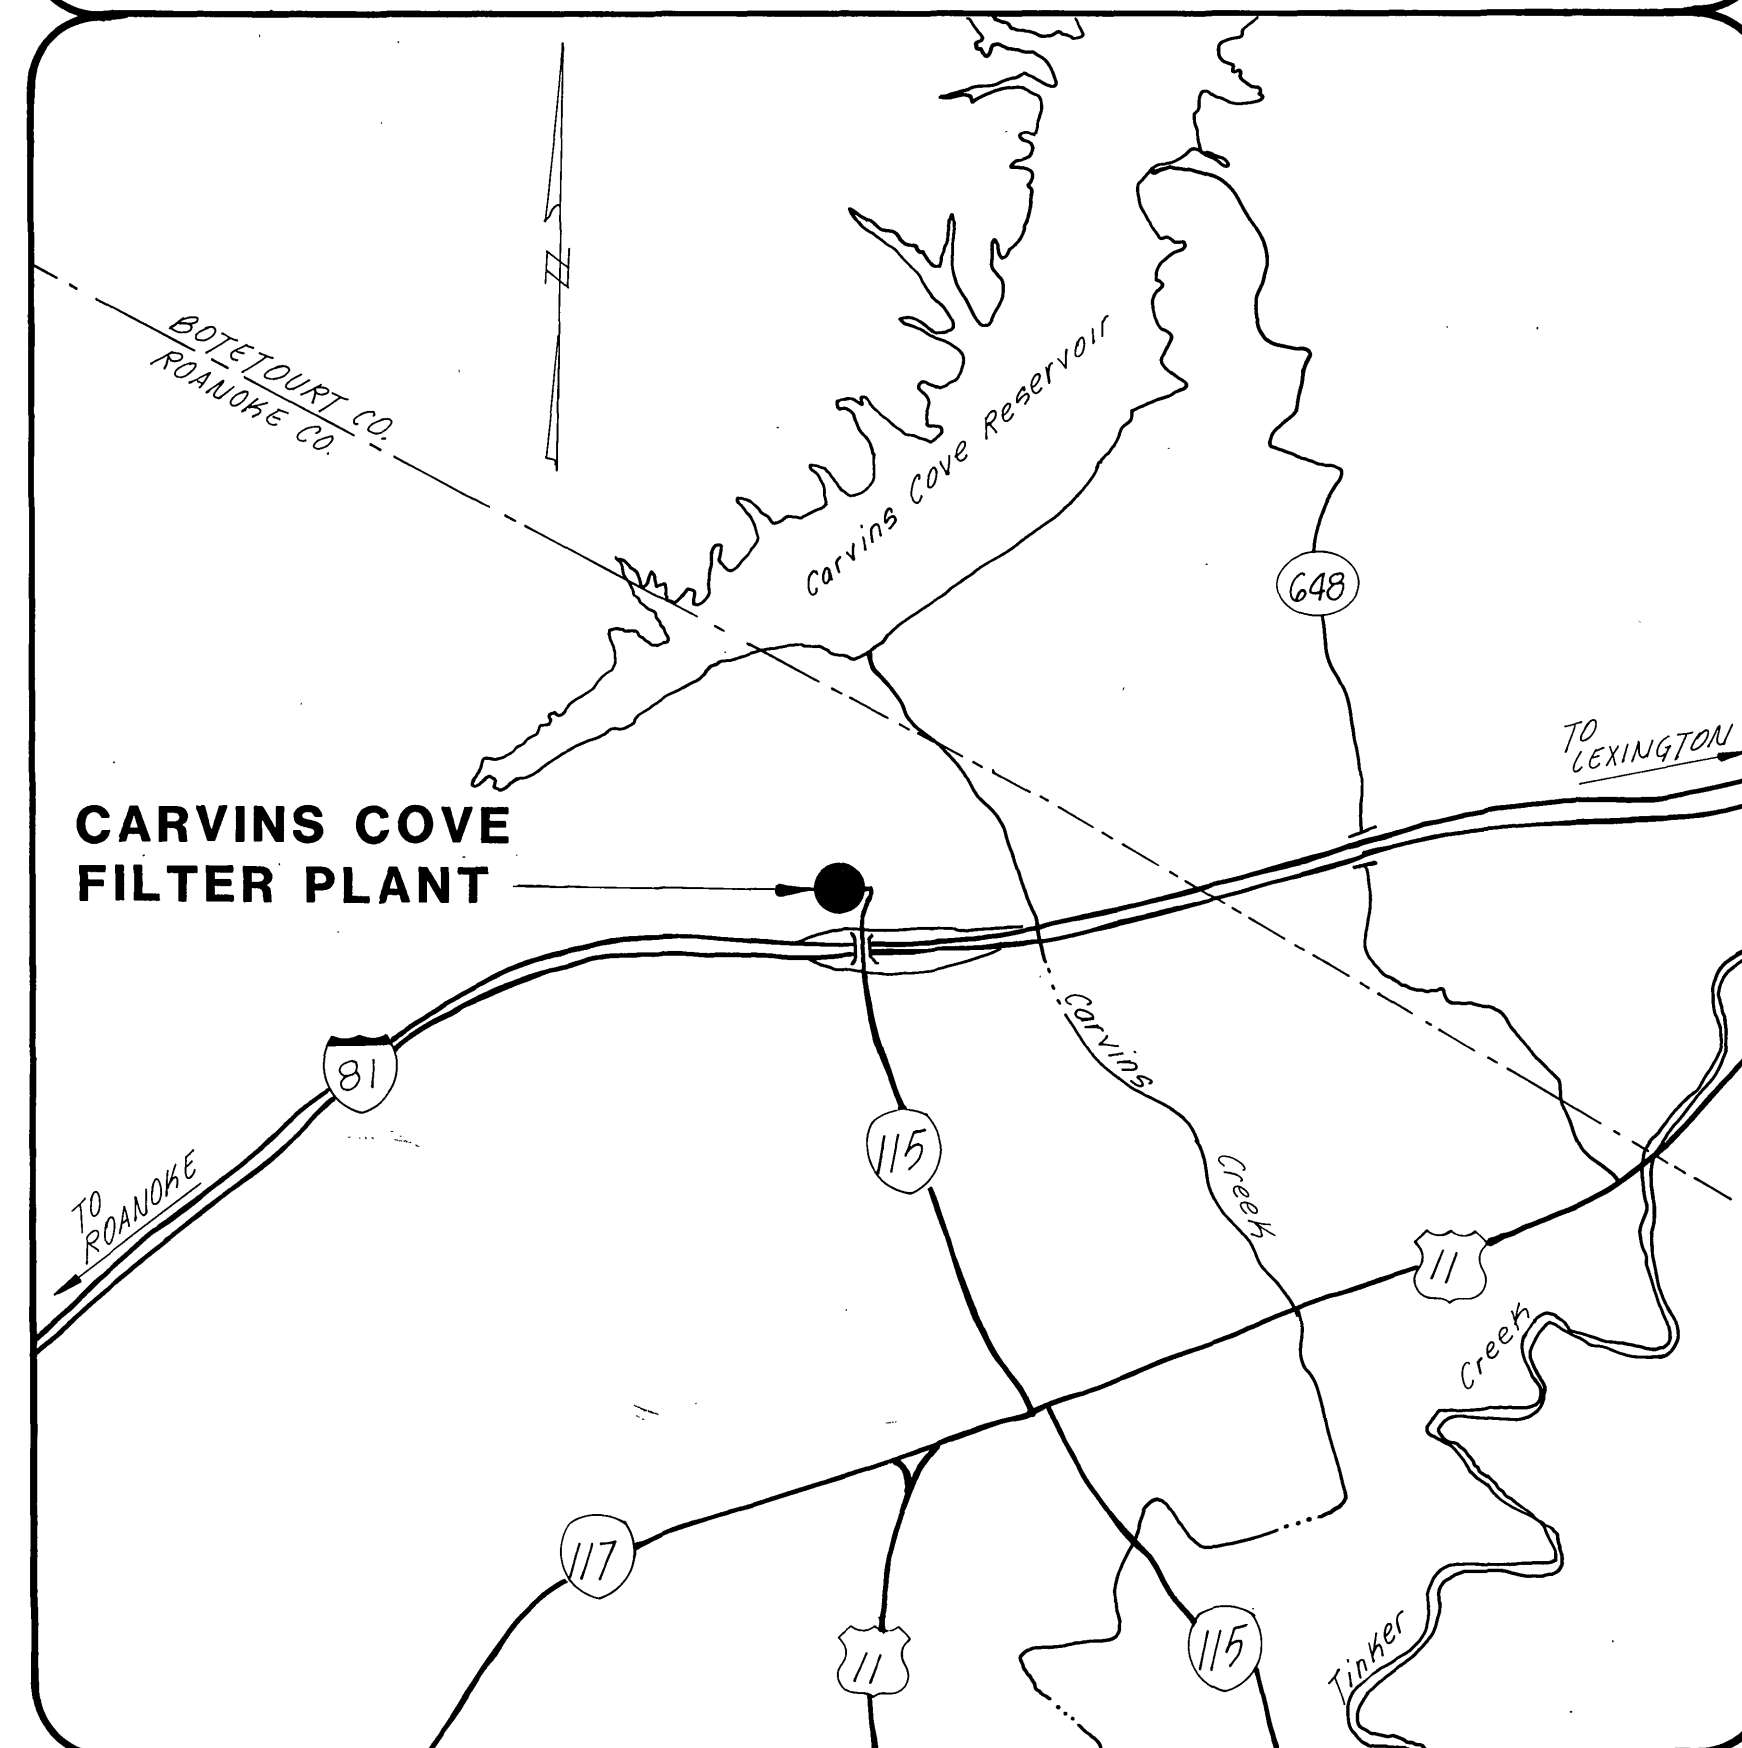

OFFICE OF CITY ENGINEER
ROOM 350
MUNICIPAL BUILDING
215 CHURCH AVENUE, S.W.
ROANOKE, VIRGINIA 24011


INDEX OF SHEETS

- 1 TITLE SHEET
- 2 ABBREVIATIONS, LEGEND GENERAL NOTES, AND VICINITY MAP
- 3 FILTER PLANT FRONT & REAR ELEVATIONS
DETAILS AND STORM WINDOW INSTALLATIONS
- 4 FILTER PLANT LEFT & RIGHT ELEVATIONS
WINDOW REPLACEMENTS & STORM WINDOW
INSTALLATIONS
- 5 FILTER PLANT MAIN FLOOR PLAN
STORM WINDOW INSTALLATIONS
- 6 FILTER PLANT SECOND FLOOR & PARTIAL
ROOF PLANS WINDOW REPLACEMENTS AND
STORM WINDOW INSTALLATIONS

CONSULTING ENGINEERS

**MATTERN AND CRAIG
CONSULTING ENGINEERS
ROANOKE , VIRGINIA**

COMMISSION NUMBER: **568**

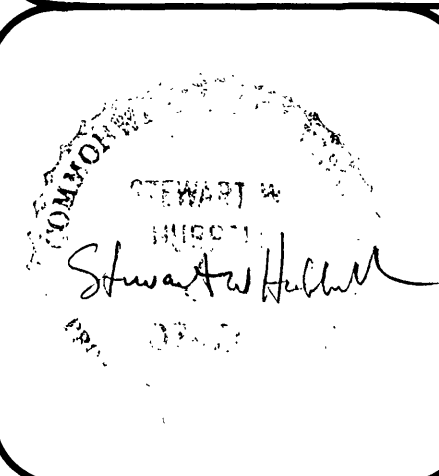

PROJECT NAME

**WINDOW REPLACEMENTS AND
STORM WINDOW INSTALLATIONS
CARVINS COVE FILTER PLANT**

PROJECT NO. 85-15

COMM. NO. 568

PROJECT NUMBER: **85-15**

REVISION	BY	DESCRIPTION:	DATE
REVISION	BY	DESCRIPTION:	DATE
REVISION	BY	DESCRIPTION:	DATE
REVISION	BY	DESCRIPTION:	DATE

APPROVED FOR CONSTRUCTION

ROANOKE CITY ENGINEER

DATE

DIRECTOR OF PUBLIC WORKS

DATE

DIRECTOR OF UTILITIES AND OPERATIONS

DATE

DATE

DATE

ADVERTISED DATE : **MAR 16 1986**

SET NUMBER: **FIVE**

SHEET NUMBER: **1** OF **6**

AS - BUILT
1986

85-15