



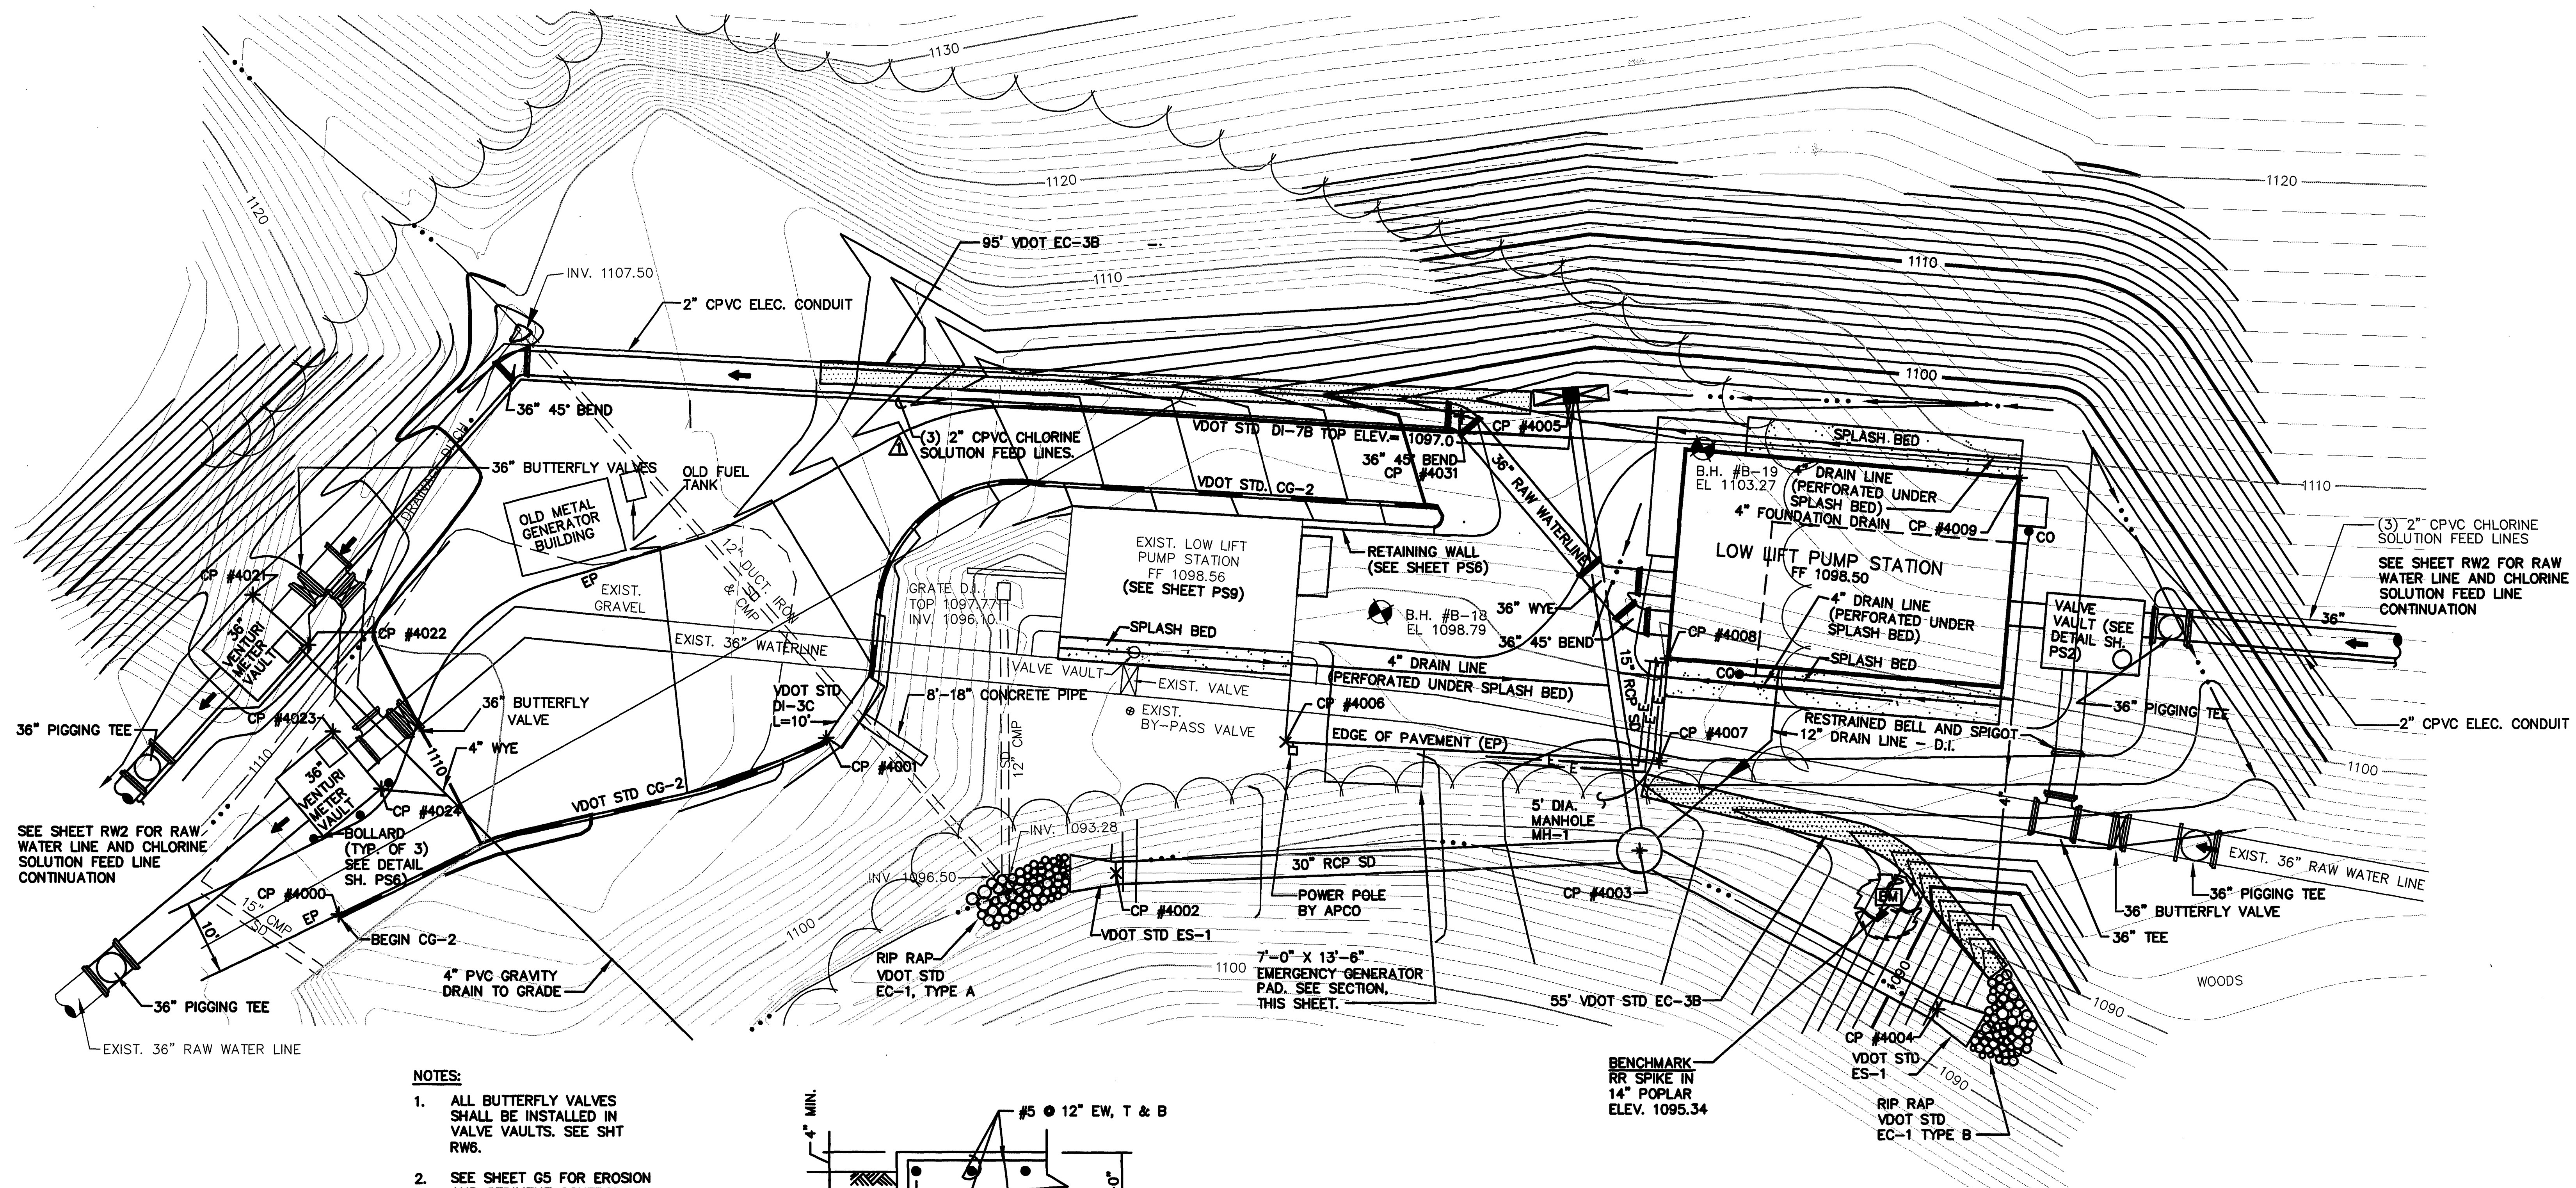

NOTES:

1. ALL BUTTERFLY VALVES SHALL BE INSTALLED IN VALVE VAULTS. SEE SHT RW6.
2. SEE SHEET G5 FOR EROSION AND SEDIMENT CONTROL LEGEND.
3. DISTURBED AREAS FLATTER THAN 2:1, NOT COVERED BY BUILDINGS OR PAVEMENT SHALL BE TOPSOILED.

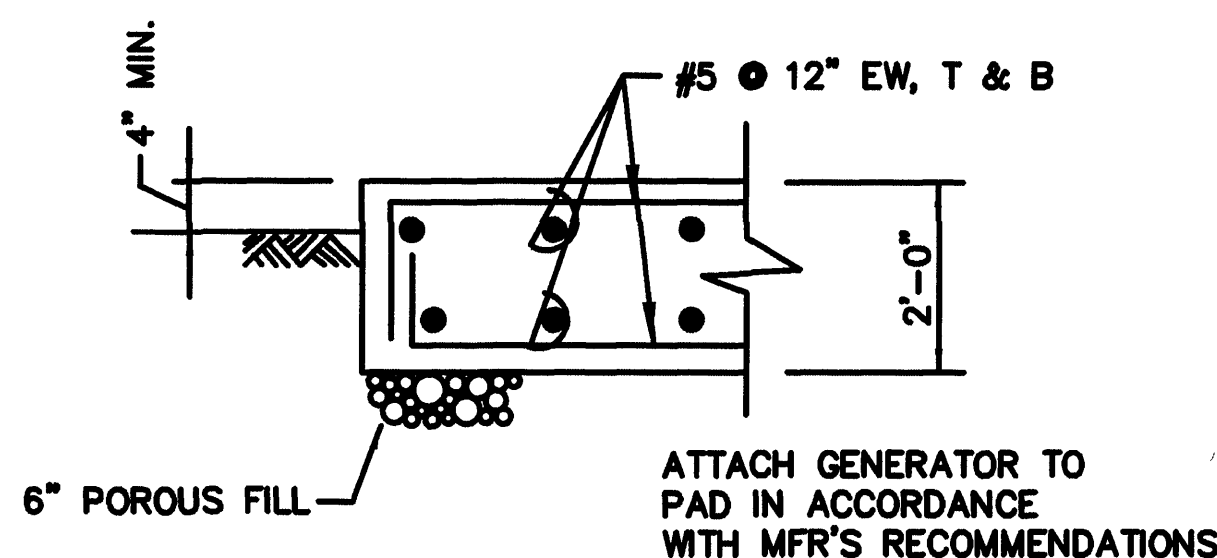

GENERATOR PAD SECTION

SCALE: NONE

RECORD DRAWINGS

9-12-97

SCALE IN FEET
0 10 20

MATTERN & CRAIG CONSULTING ENGINEERS • SURVEYORS ROANOKE VIRGINIA	DESIGNED: RWB			REV.	DATE	DESCRIPTION	BY	APP.	CARVINS COVE FILTER PLANT IMPROVEMENTS – PHASE I ROANOKE, VIRGINIA	DATE MARCH 1992
	DRAWN: DSG				5/93	C.O. #3	FMP	RWB		COMM. NO. 1138
ALVORD, BURDICK & HOWSON ENGINEERS CHICAGO	CHECKED: SWH				9/97	RECORD DRAWING	BCB	JMB	LOW LIFT PUMP STATION SITE PLAN	SHEET PS1