

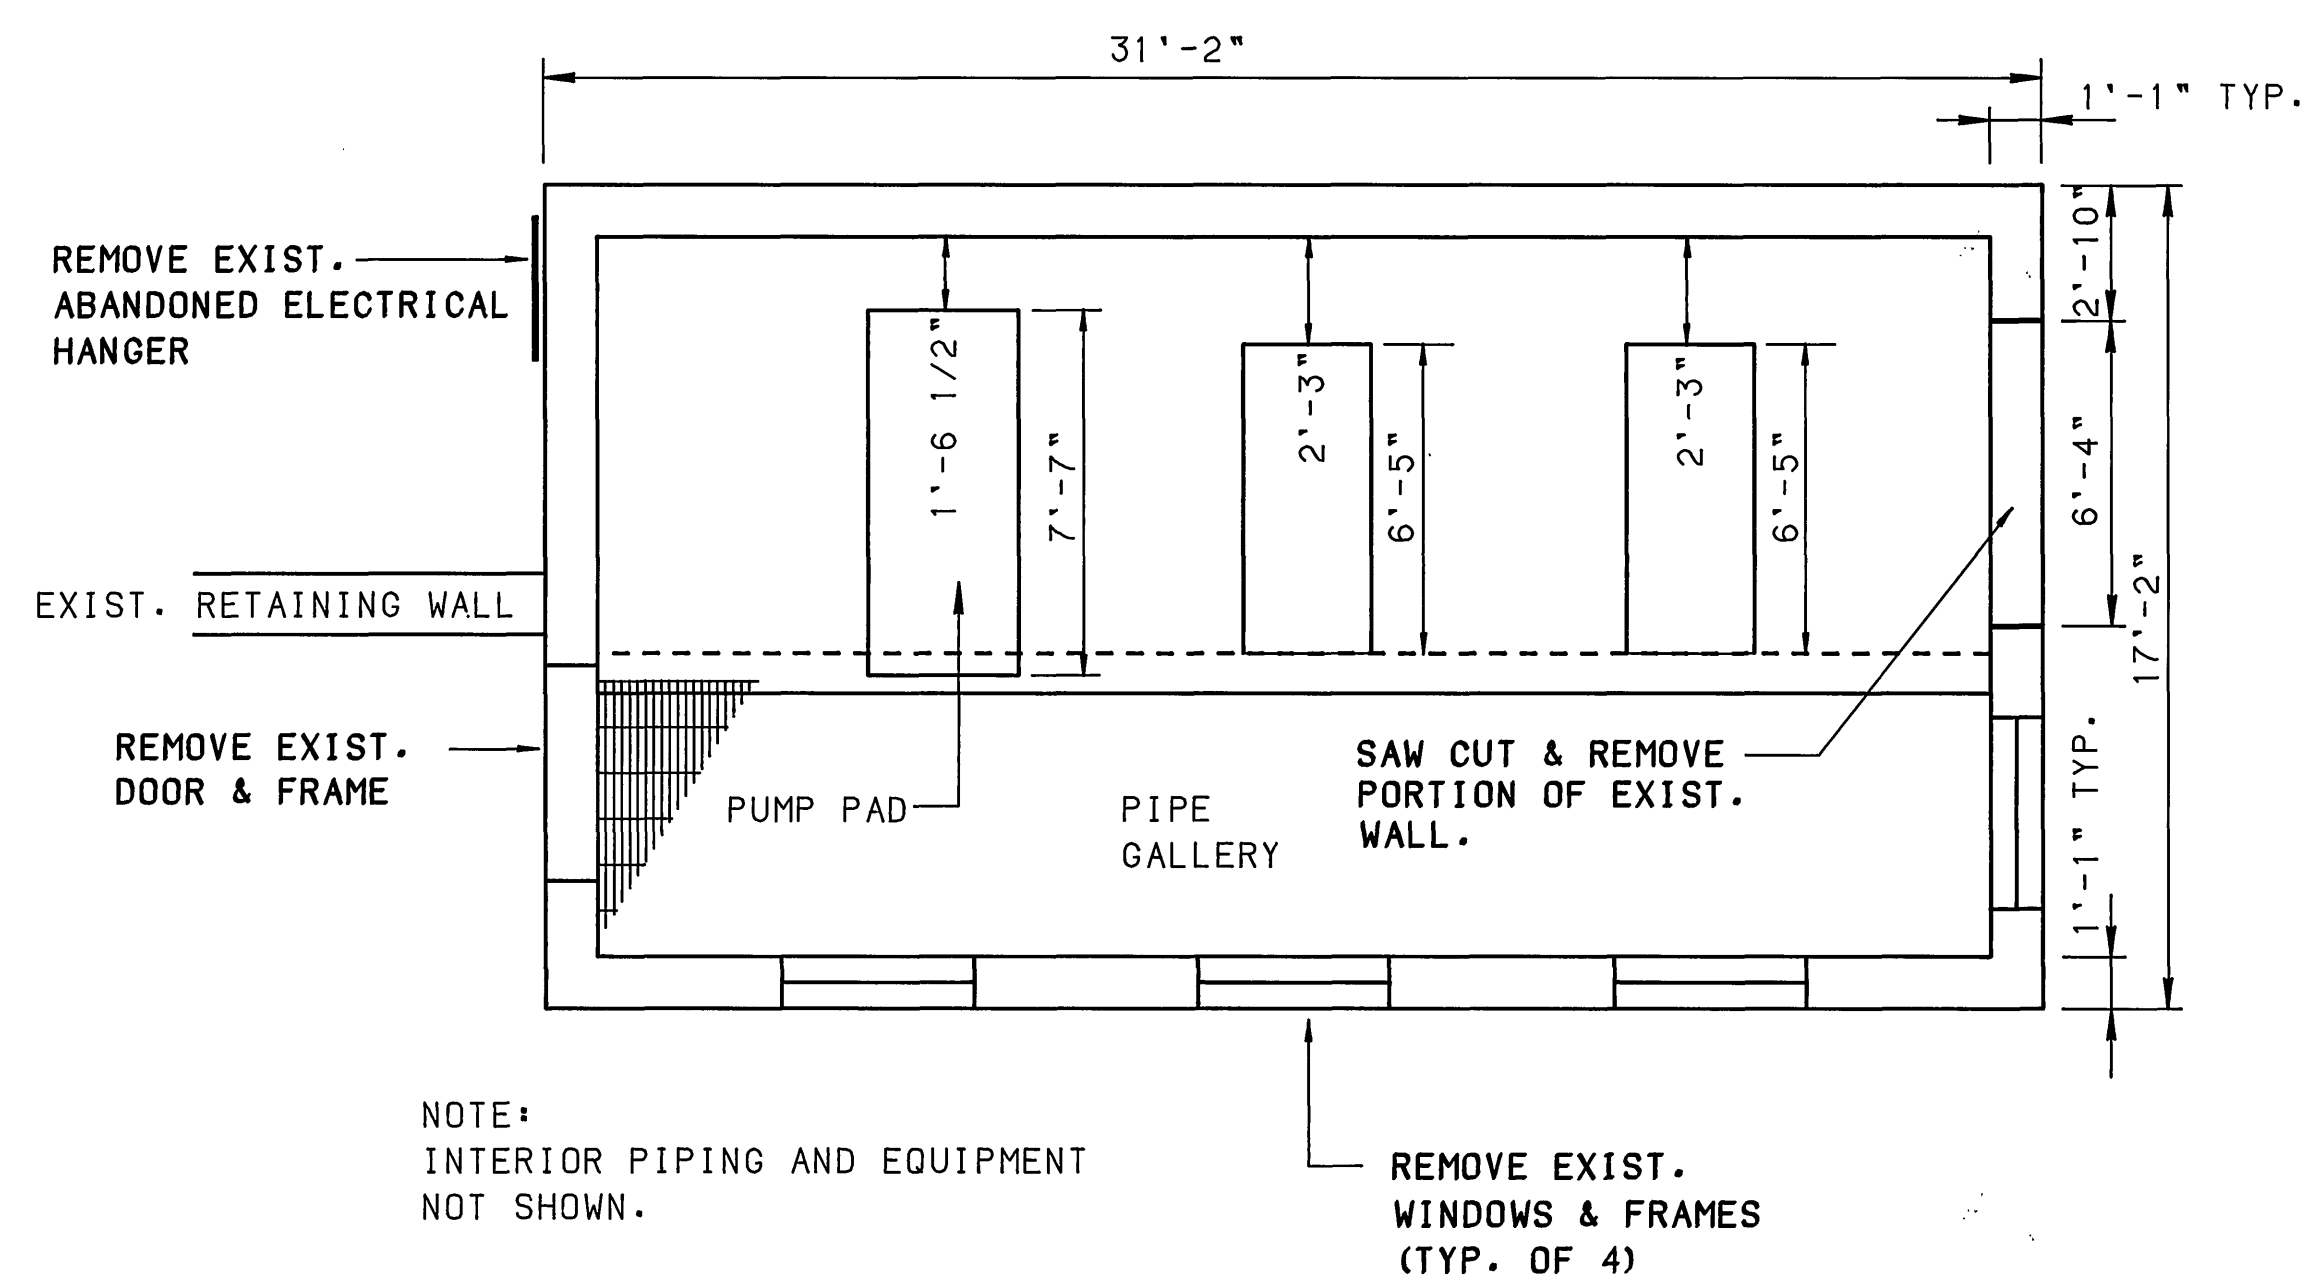
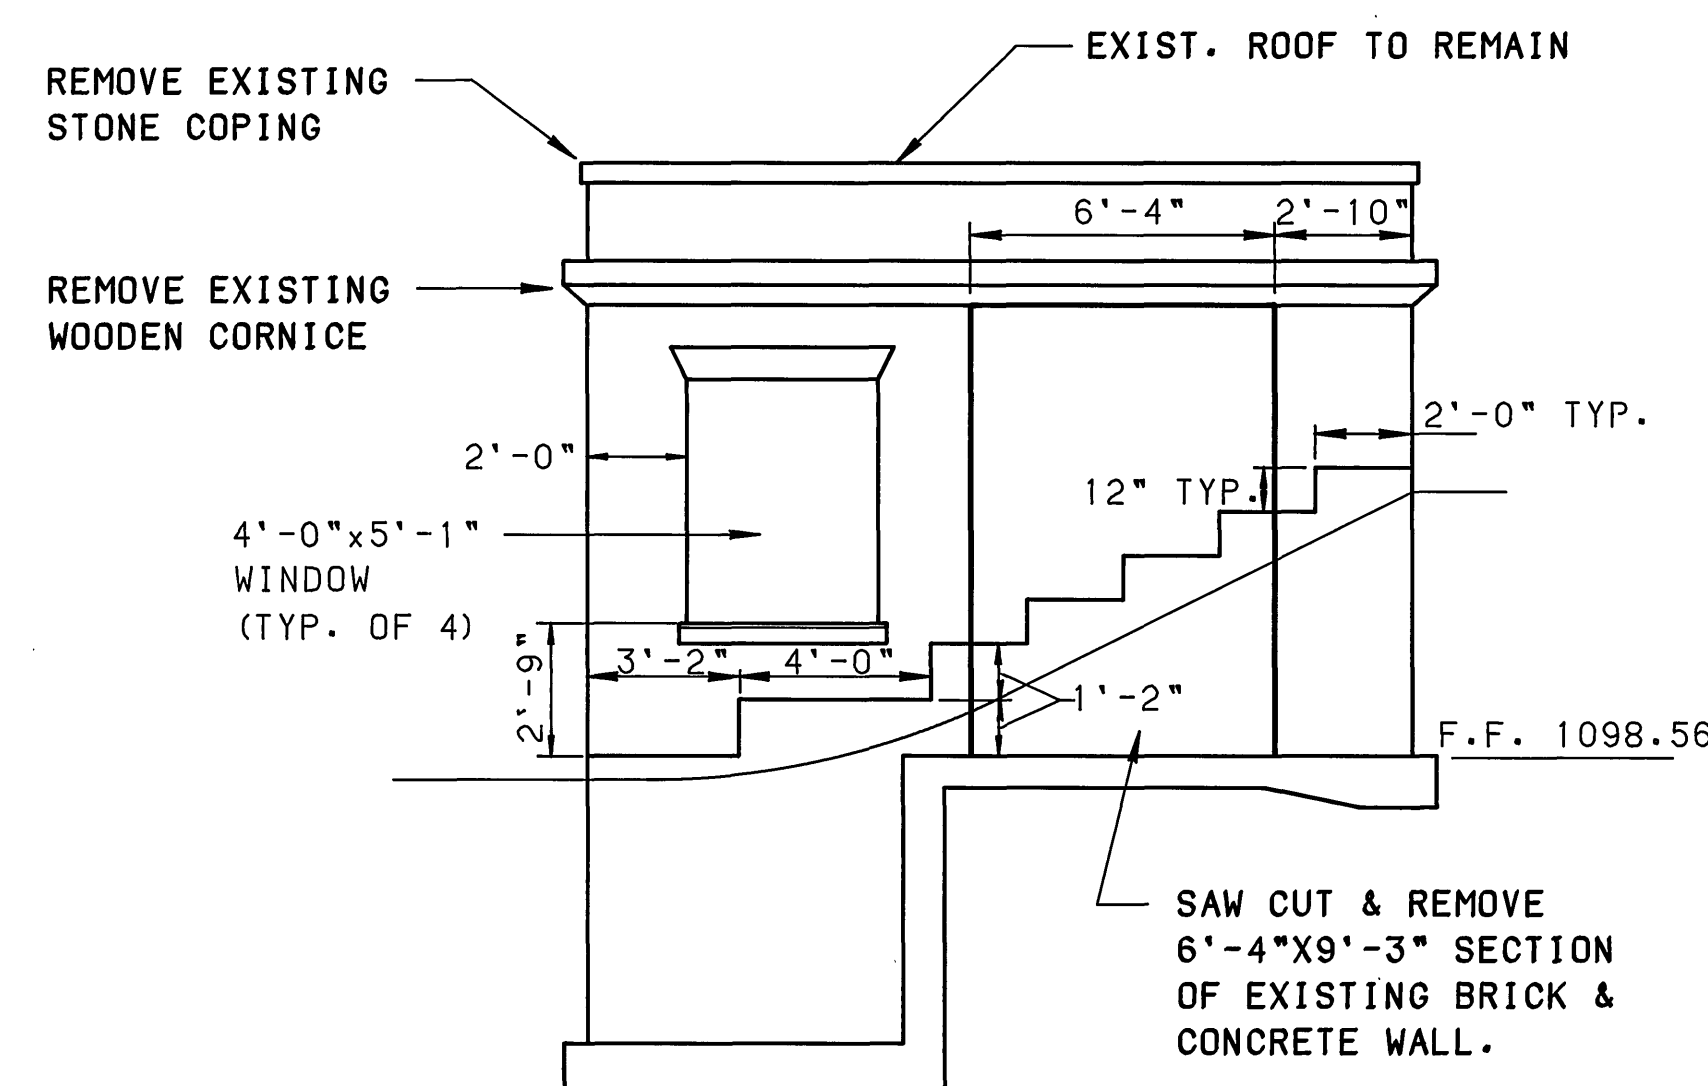
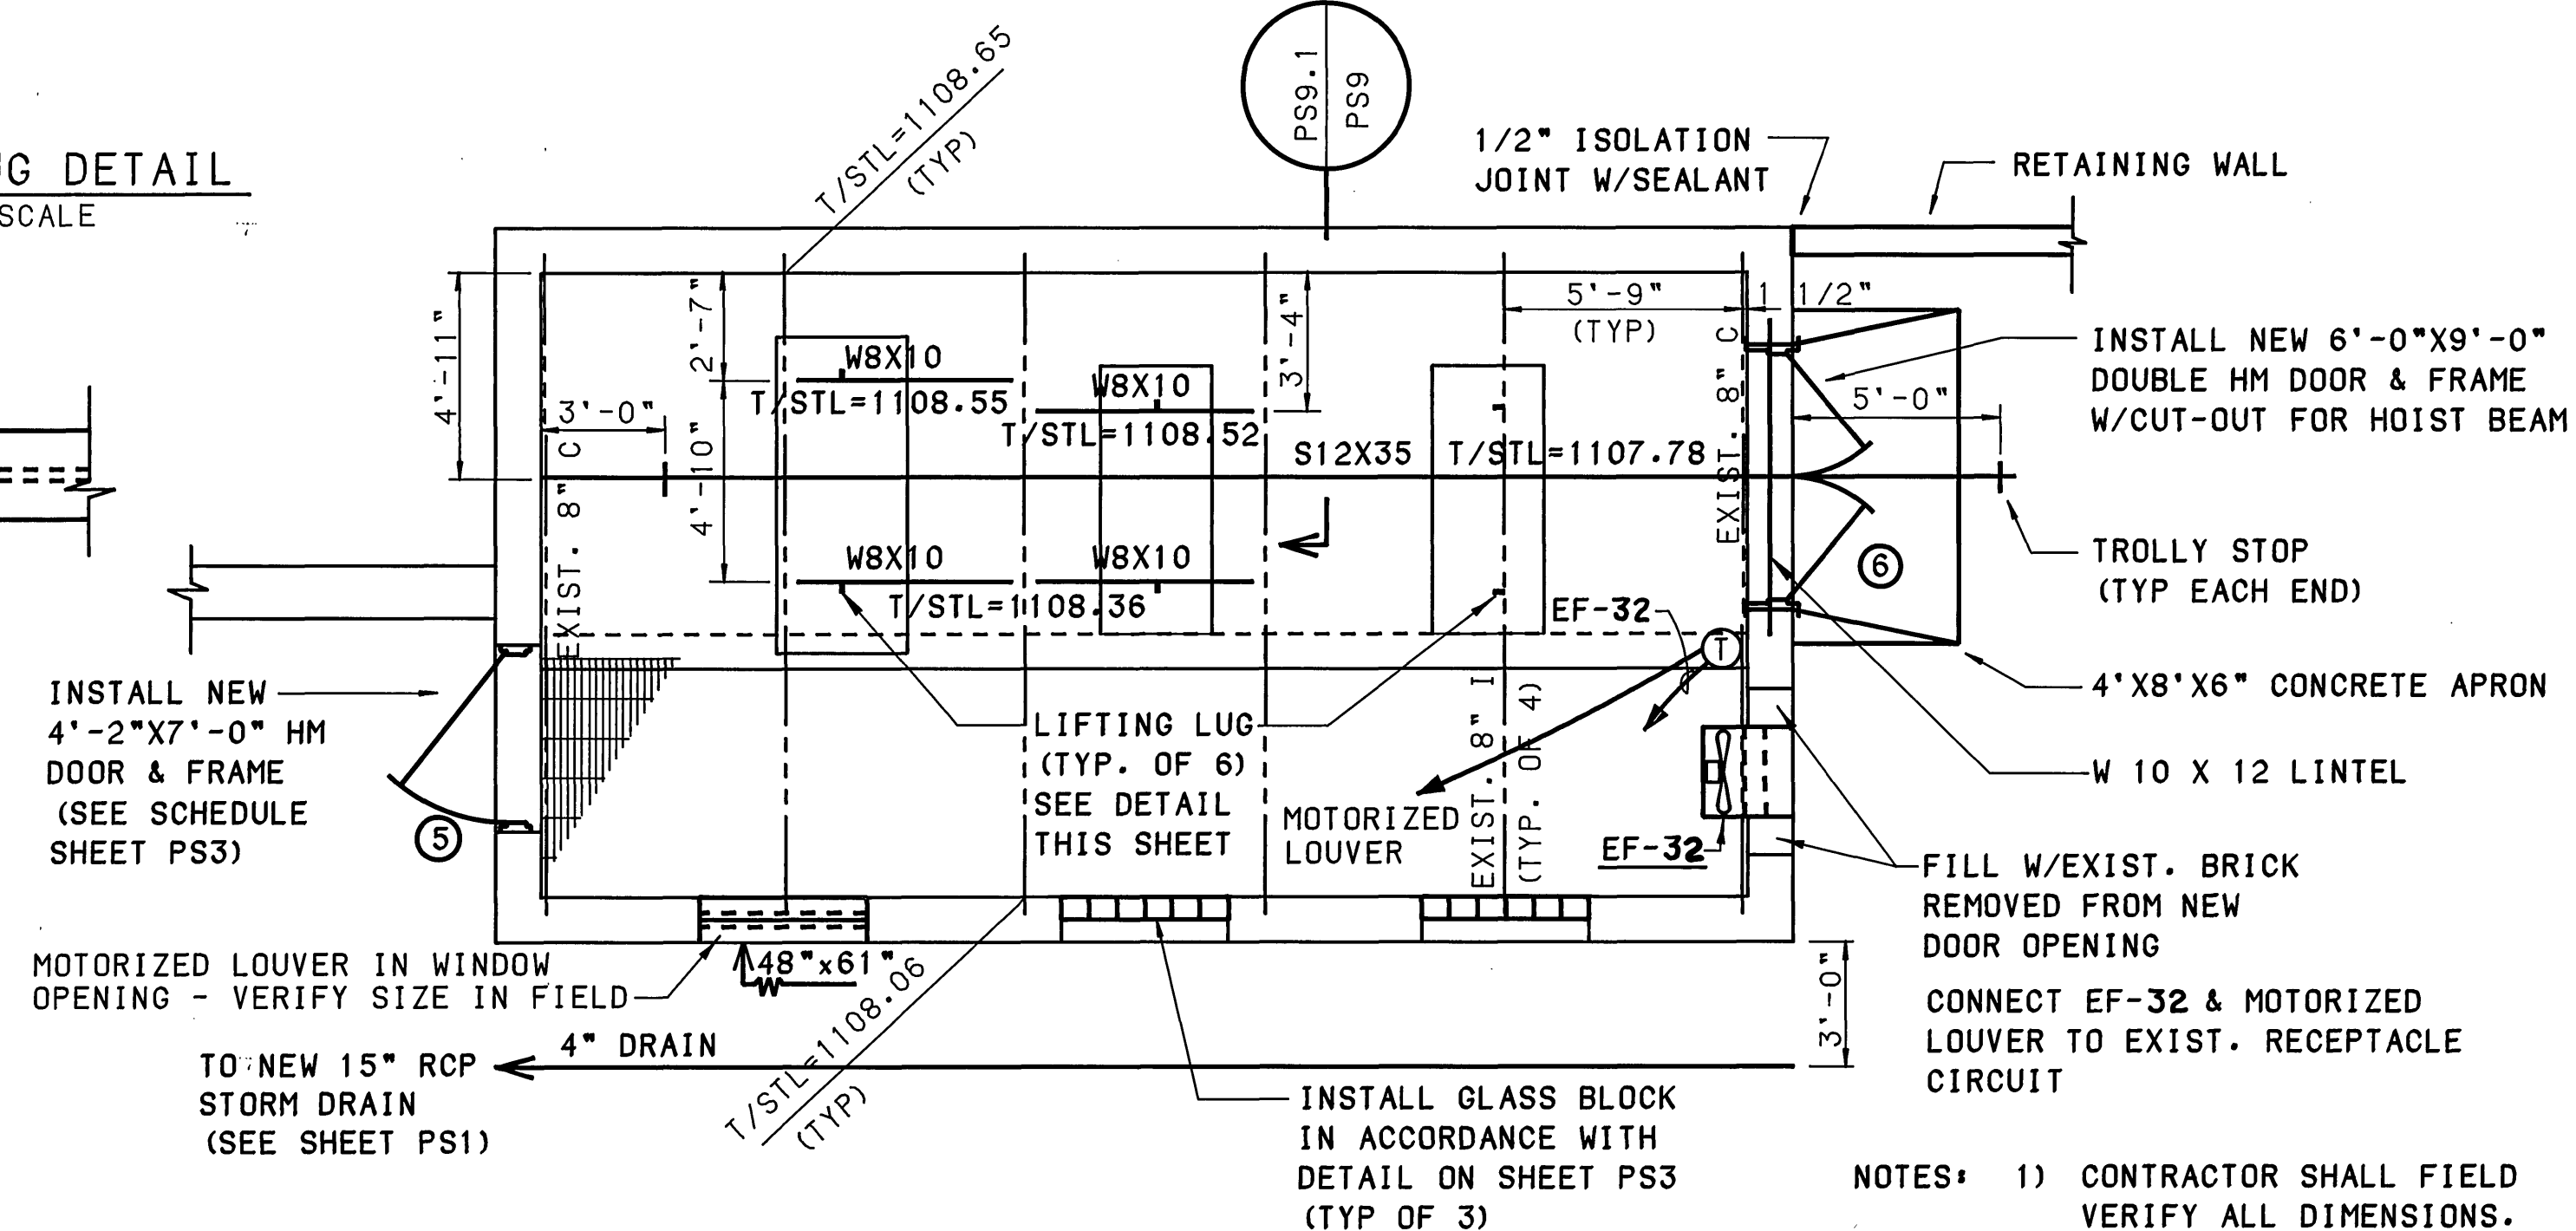
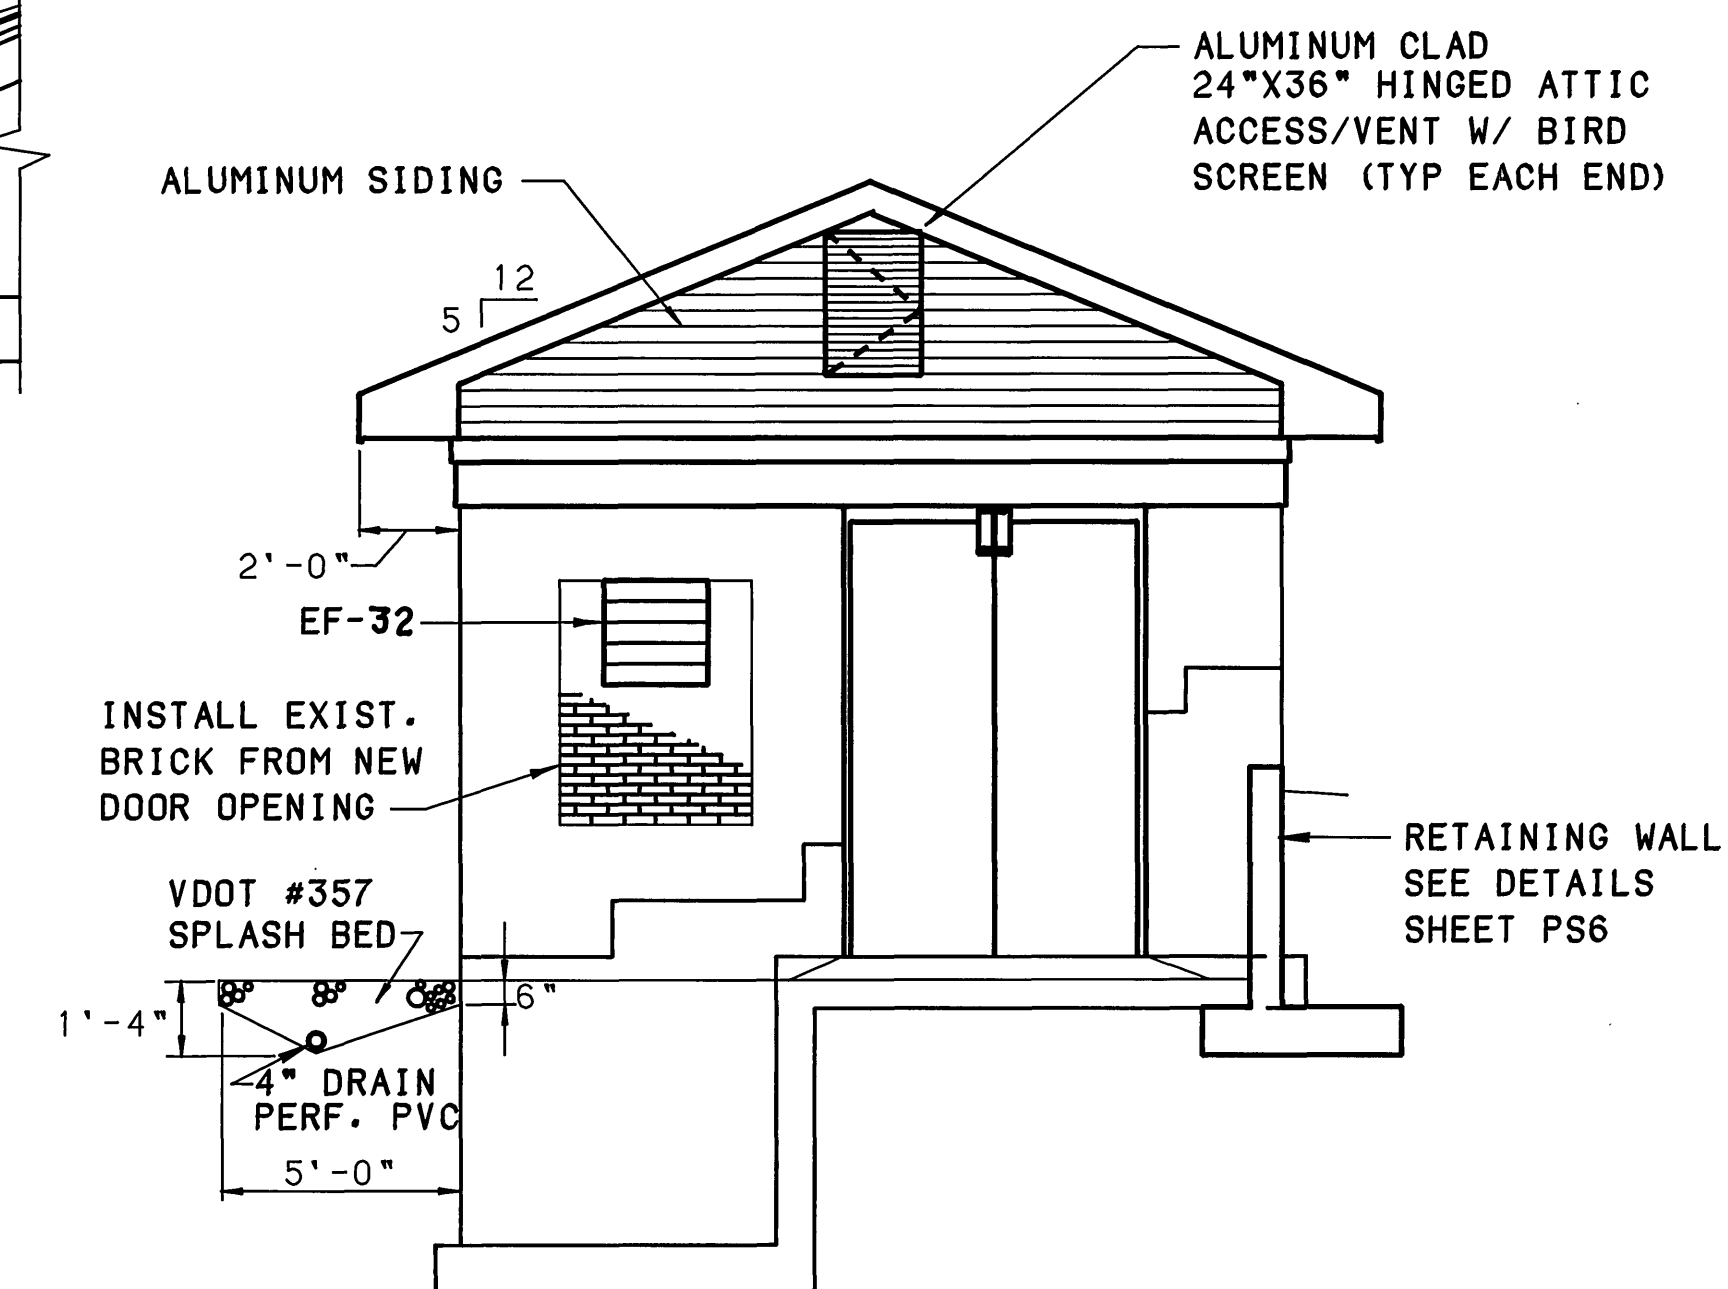
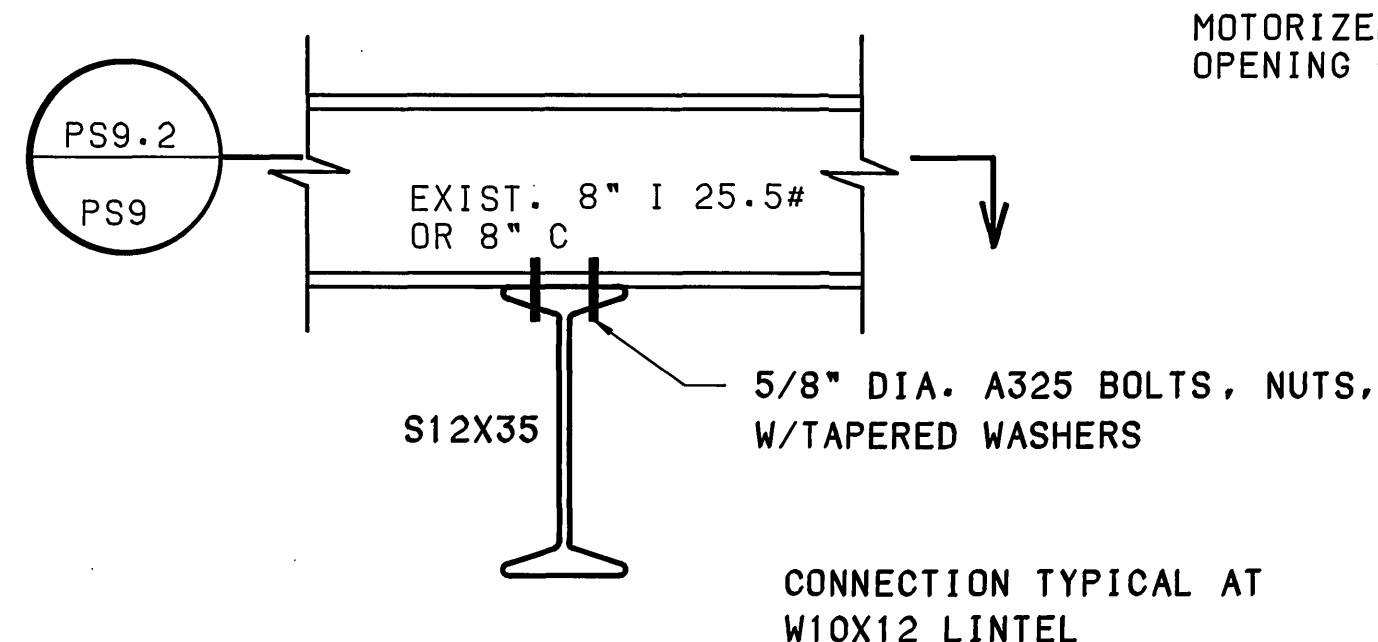
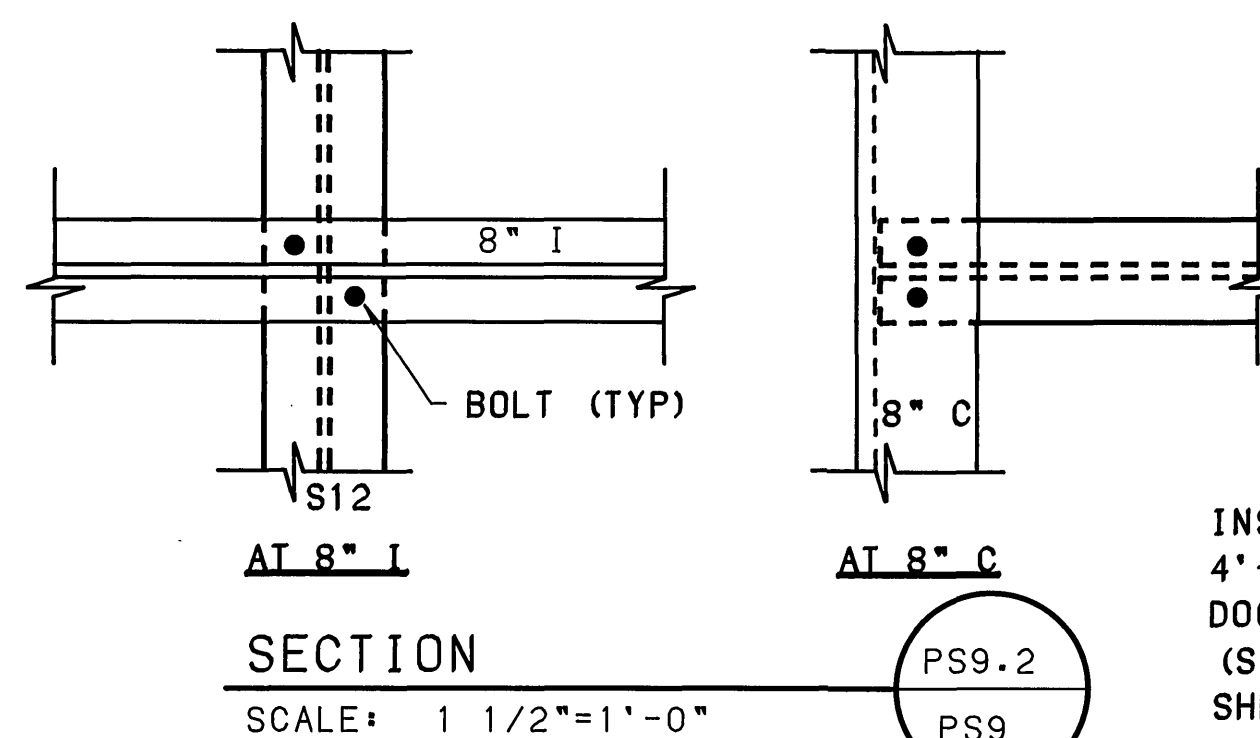
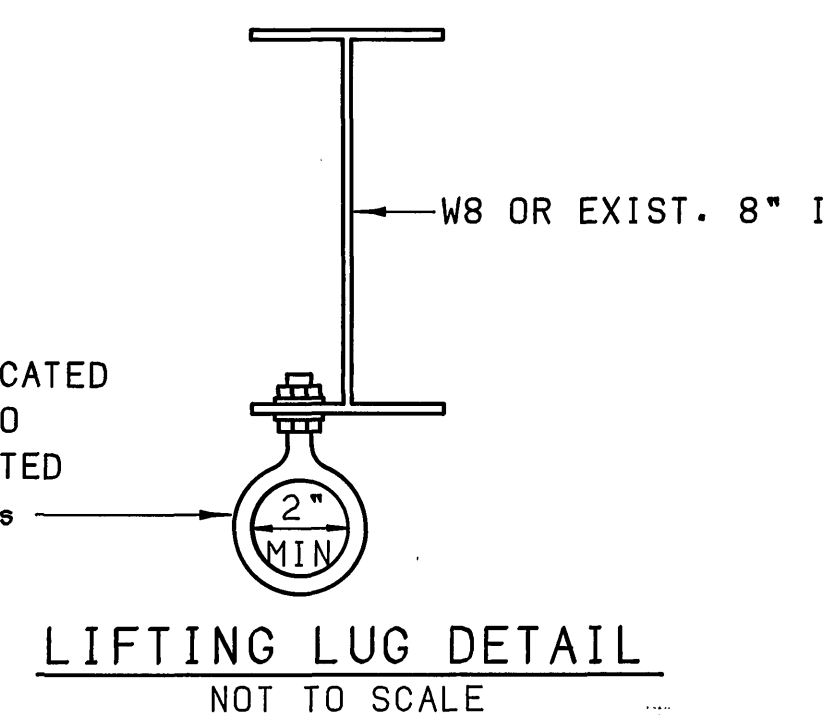
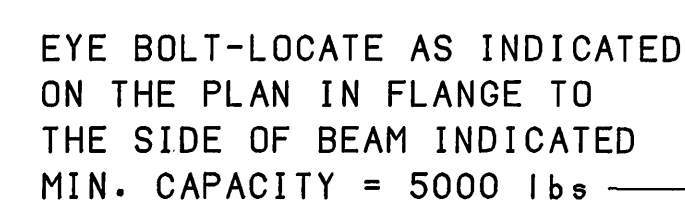


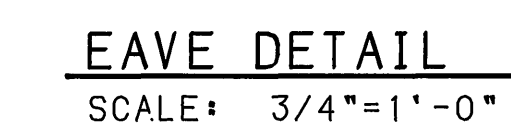

DEMOLITION

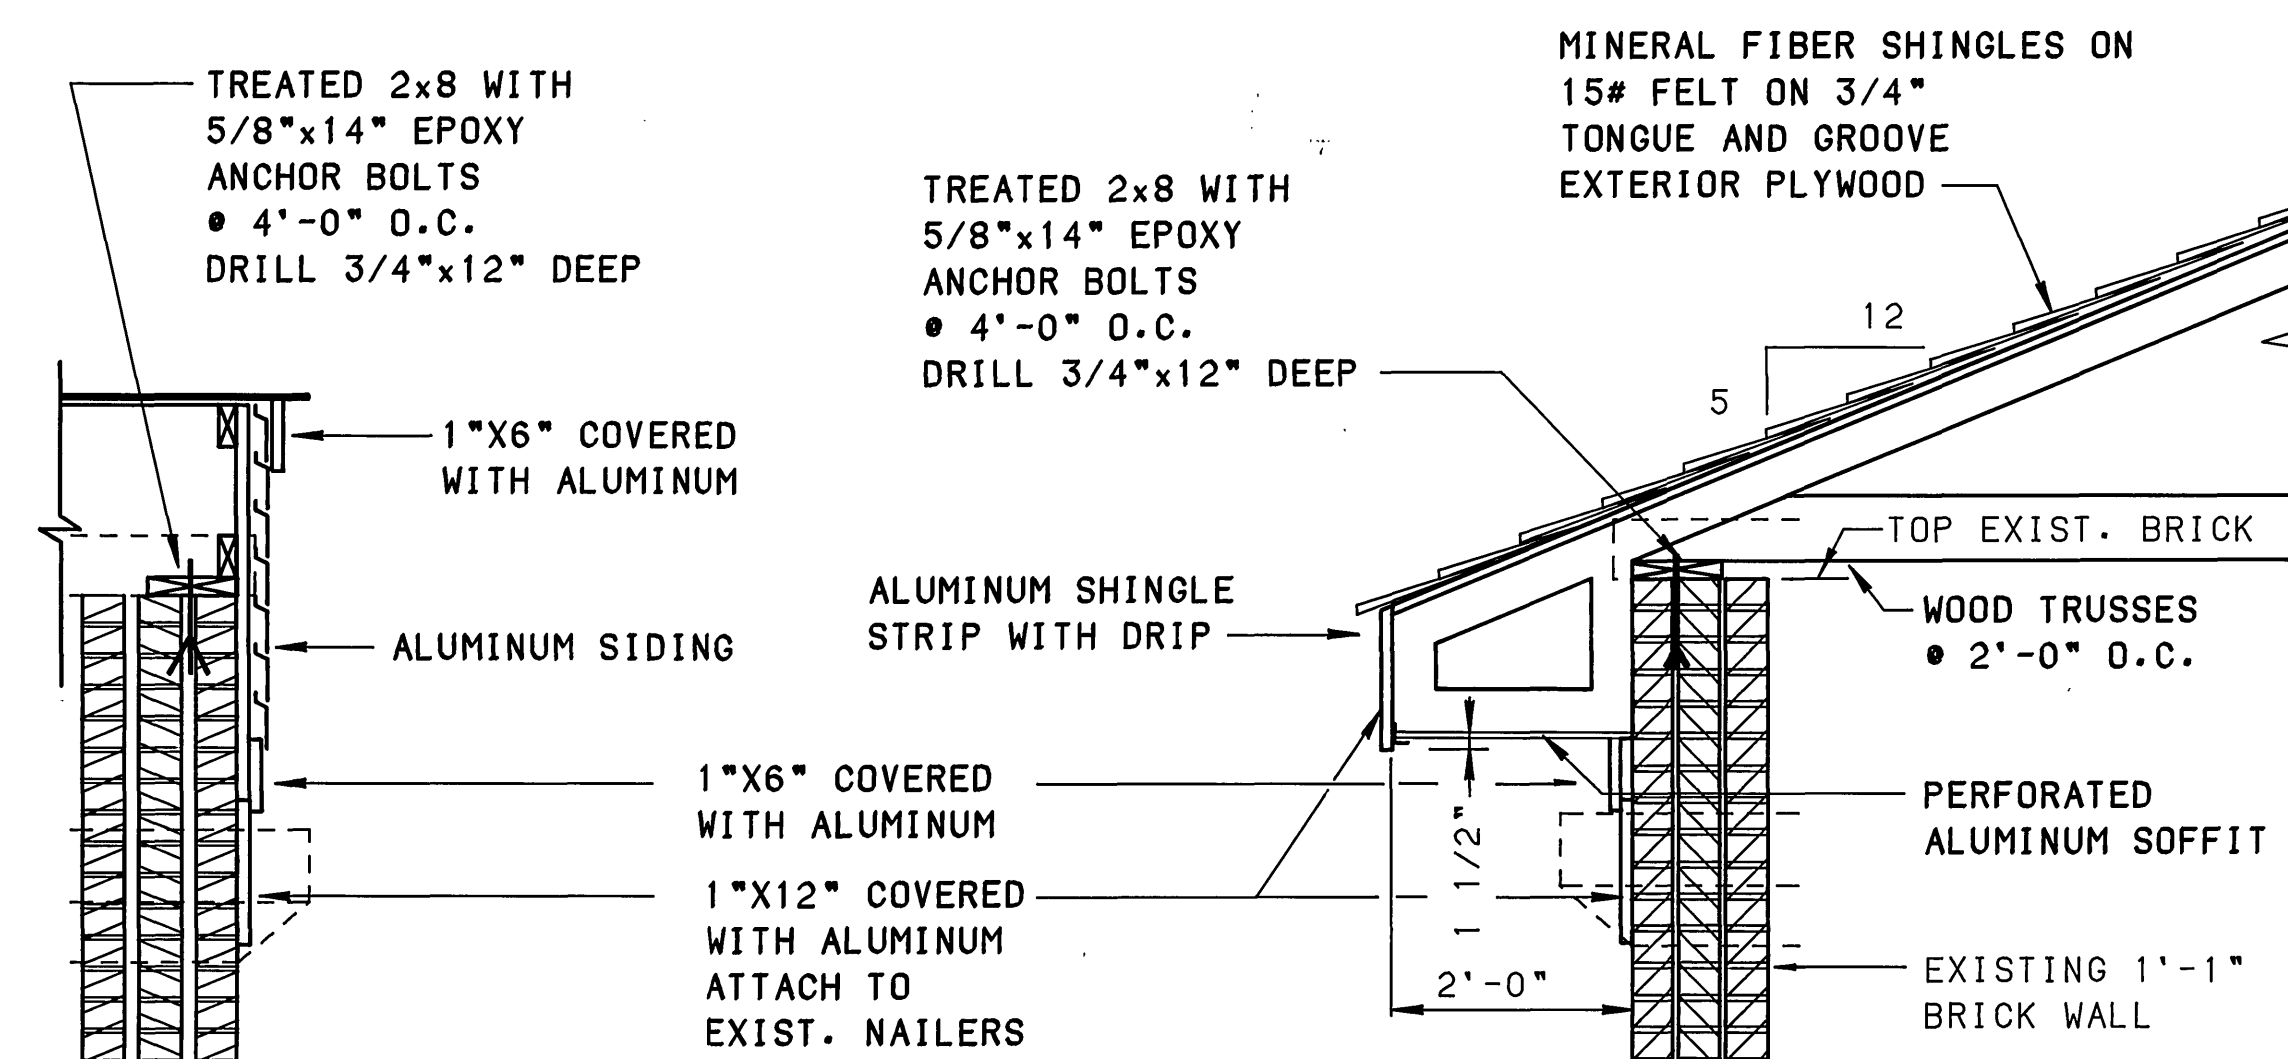

- NOTES:
- 1) CONTRACTOR SHALL FIELD VERIFY ALL DIMENSIONS.
 - 2) SEE SHEET PS3 FOR DOOR SCHEDULE.
 - 3) 3 PUMPS, PIPING, ELECTRICAL AND APPURTENANCES IN STATION ARE NOT SHOWN.
 - 4) CLEAN AND PAINT ALL EXIST. STEEL W/TWO (2) COATS ENAMEL.



NEW CONSTRUCTION

RECORD DRAWING

MATTERN & CRAIG
CONSULTING ENGINEERS • SURVEYORS
ROANOKE VIRGINIA

ALVORD, BURDICK & HOWSON
ENGINEERS CHICAGO

DESIGNED:	RWB
DRAWN:	DSG
CHECKED:	SWH

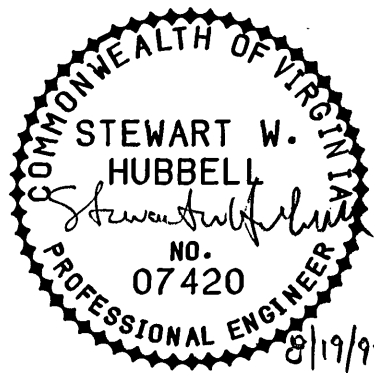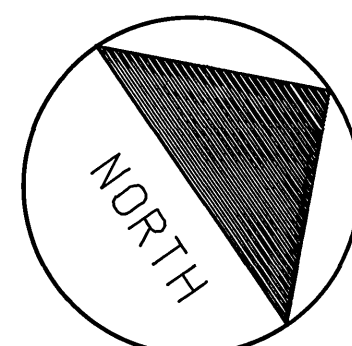

REV	DATE	DESCRIPTION	BY	APP
1	8/92	MISCELLANEOUS	DSG	RW

CARVINS COVE FILTER PLANT IMPROVEMENTS - PHASE I
ROANOKE, VIRGINIA

LOW LIFT PUMP STATION MODIFICATIONS TO EXISTING PUMP STATION

DATE	MARCH 1992
COMM. NO.	1138
SHEET	PS9

PLAN NO. 6199