


PROPERTY OF
CHURCH OF GOD TRS.
D.B. 816 PG. 73
TAX NO. 18.00-1-8
(ROANOKE COUNTY)

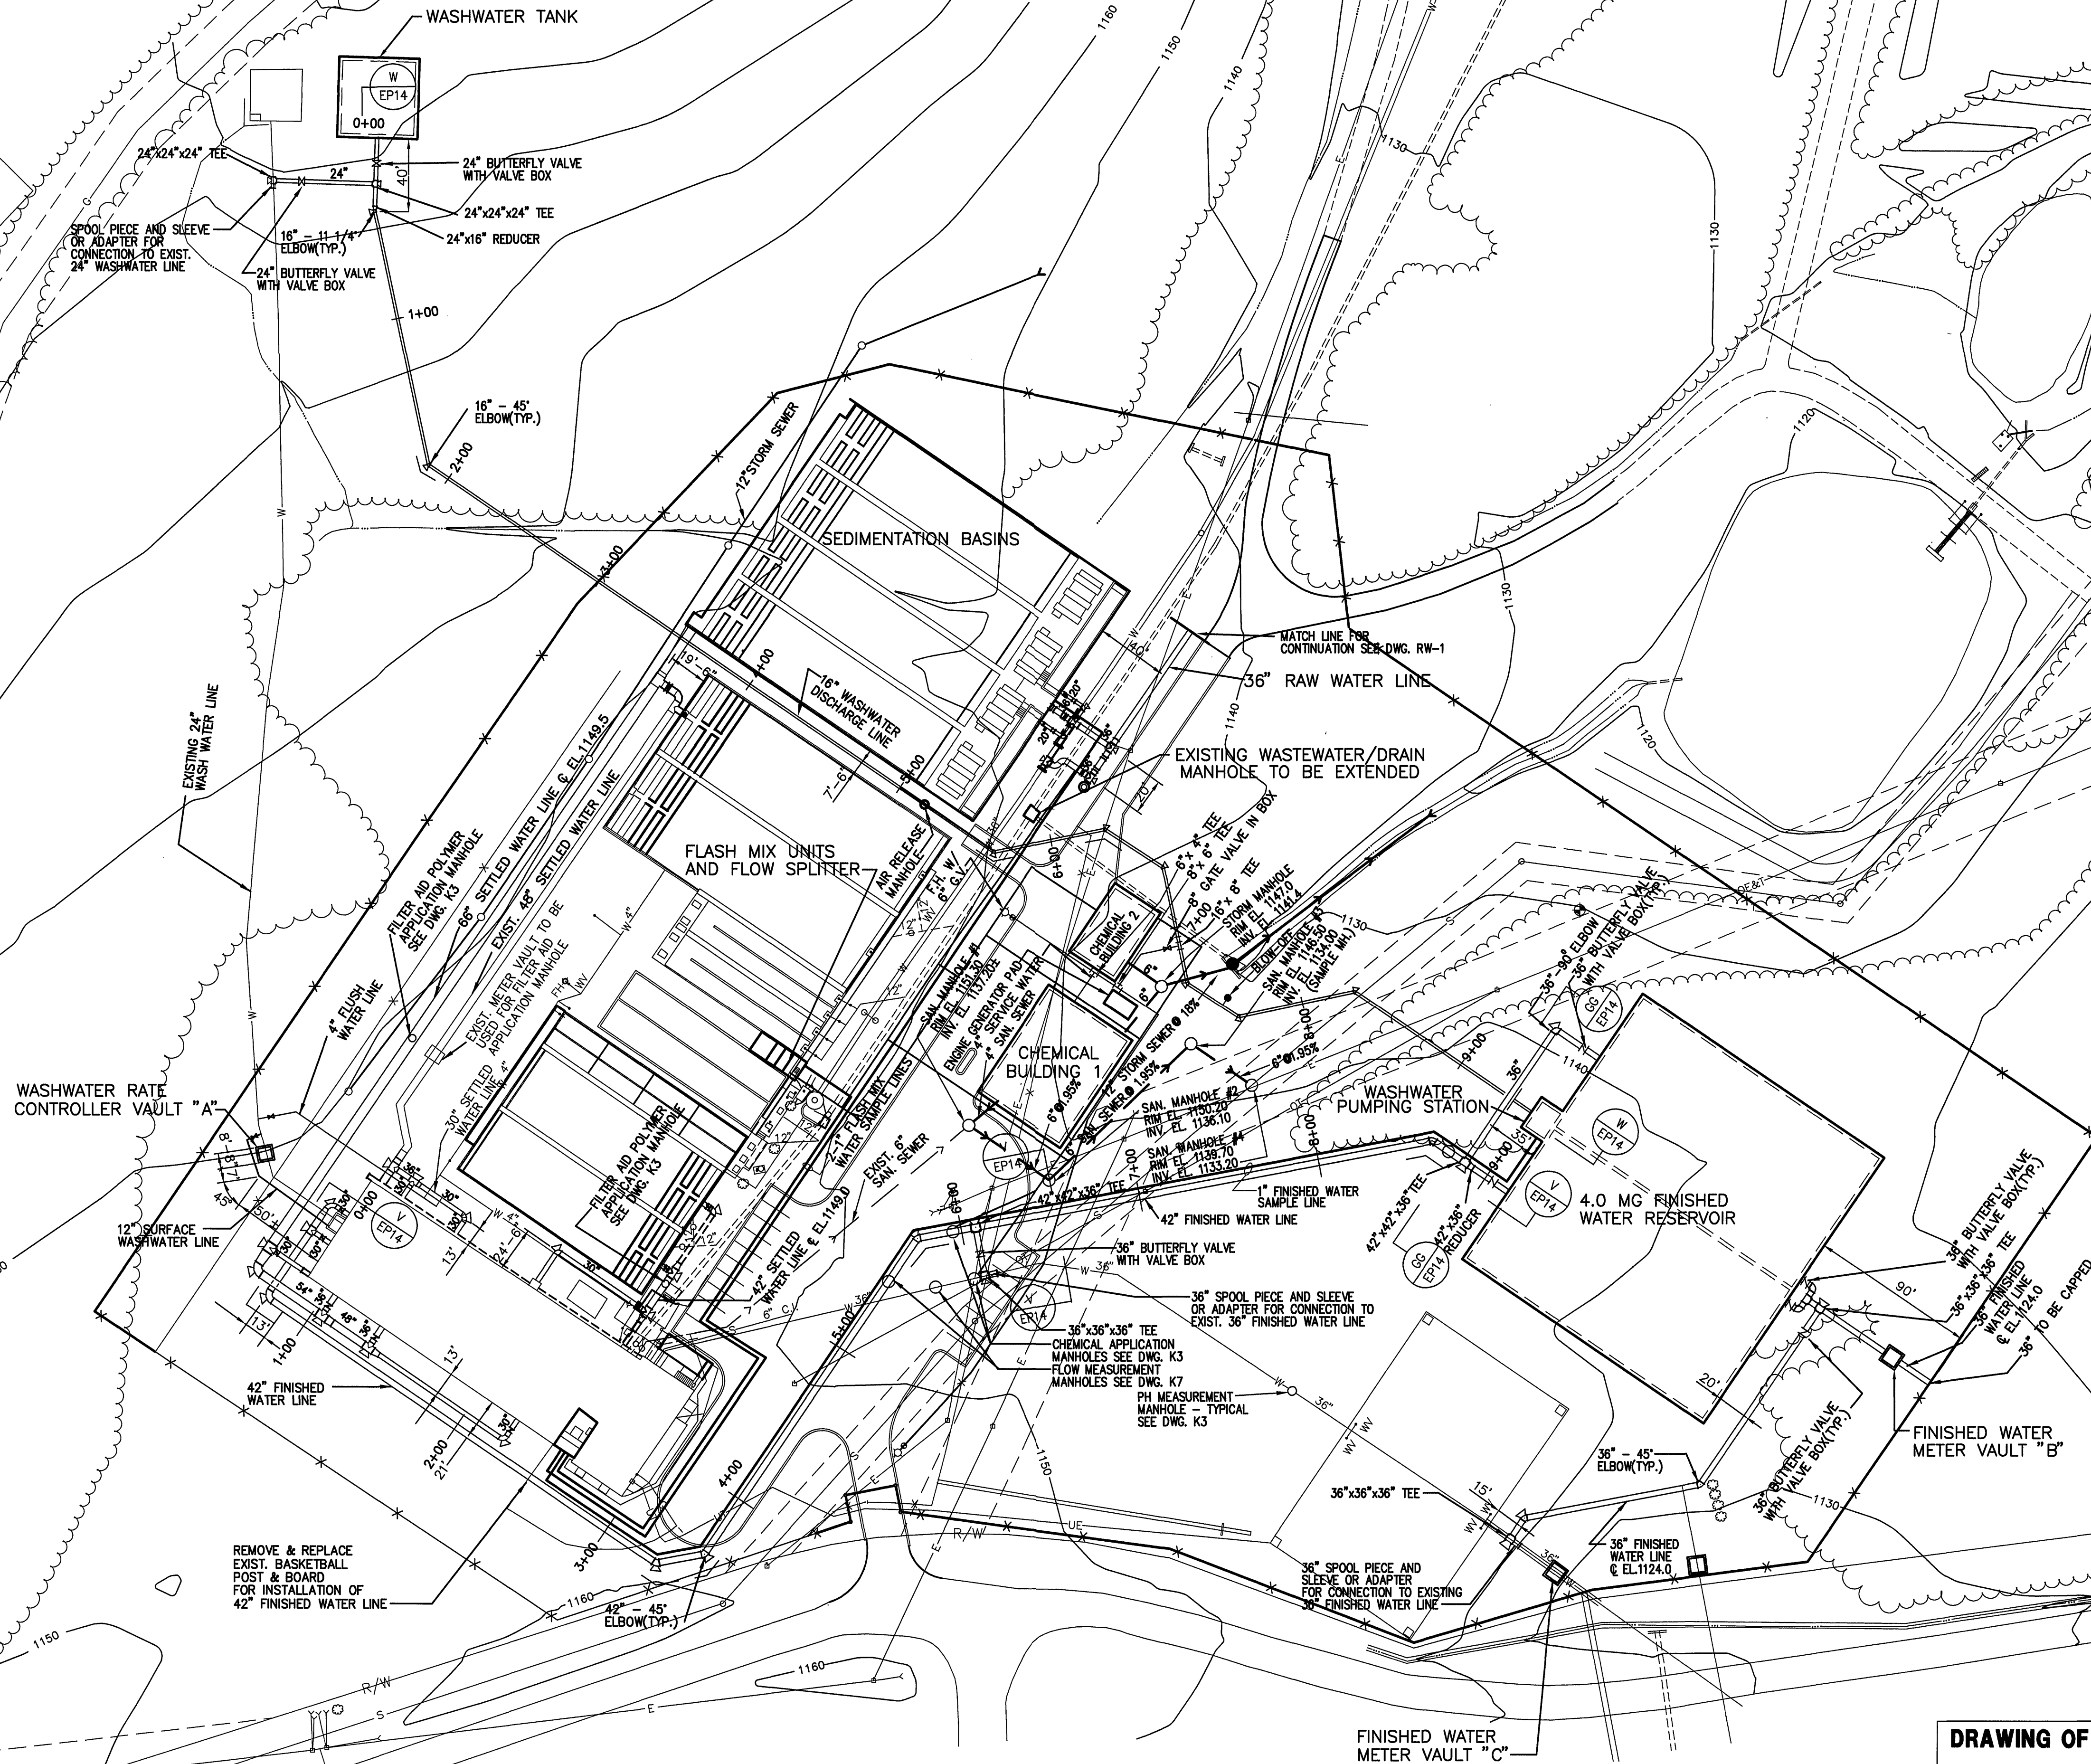

SCALE OF DRAWING
1" = 50'-0"
50' 0' 50' 100'

DRAWING OF RECORD
DATE: SEP 30 1997

- NOTES: 1. FOR STRUCTURE LOCATION SEE DWG. EP1.
2. FOR GRADING PLANS SEE DWGS. A1 & FR1.
3. FOR YARD PIPING PROFILE SEE DWG. EP14.
4. FOR CONCRETE THRUST BLOCK & COUNTERWEIGHT DETAILS SEE DWG. EP16.
5. FOR MORE YARD PIPING SECTIONS & DETAILS SEE DWGS. EP3, EP12, EP13, FL1, FR1 & FR6.
6. FOR CHEMICAL YARD PIPING SEE DWG. K5.
7. FOR UNDERGROUND ELECTRICAL CONDUITS SEE DWG. E1.

MATTERN & CRAIG
CONSULTING ENGINEERS • SURVEYORS
ROANOKE VIRGINIA

DESIGNED: KHC
DRAWN: RT
HFF
CHECKED: YTL



REV.	DATE	DESCRIPTION	BY	APP.

CARVINS COVE FILTER PLANT IMPROVEMENTS – PHASE I
ROANOKE, VIRGINIA

ALVORD, BURDICK & HOWSON
ENGINEERS CHICAGO

YARD PIPING

DATE
JULY 1992
COMM. NO.
9130
SHEET
EP5