




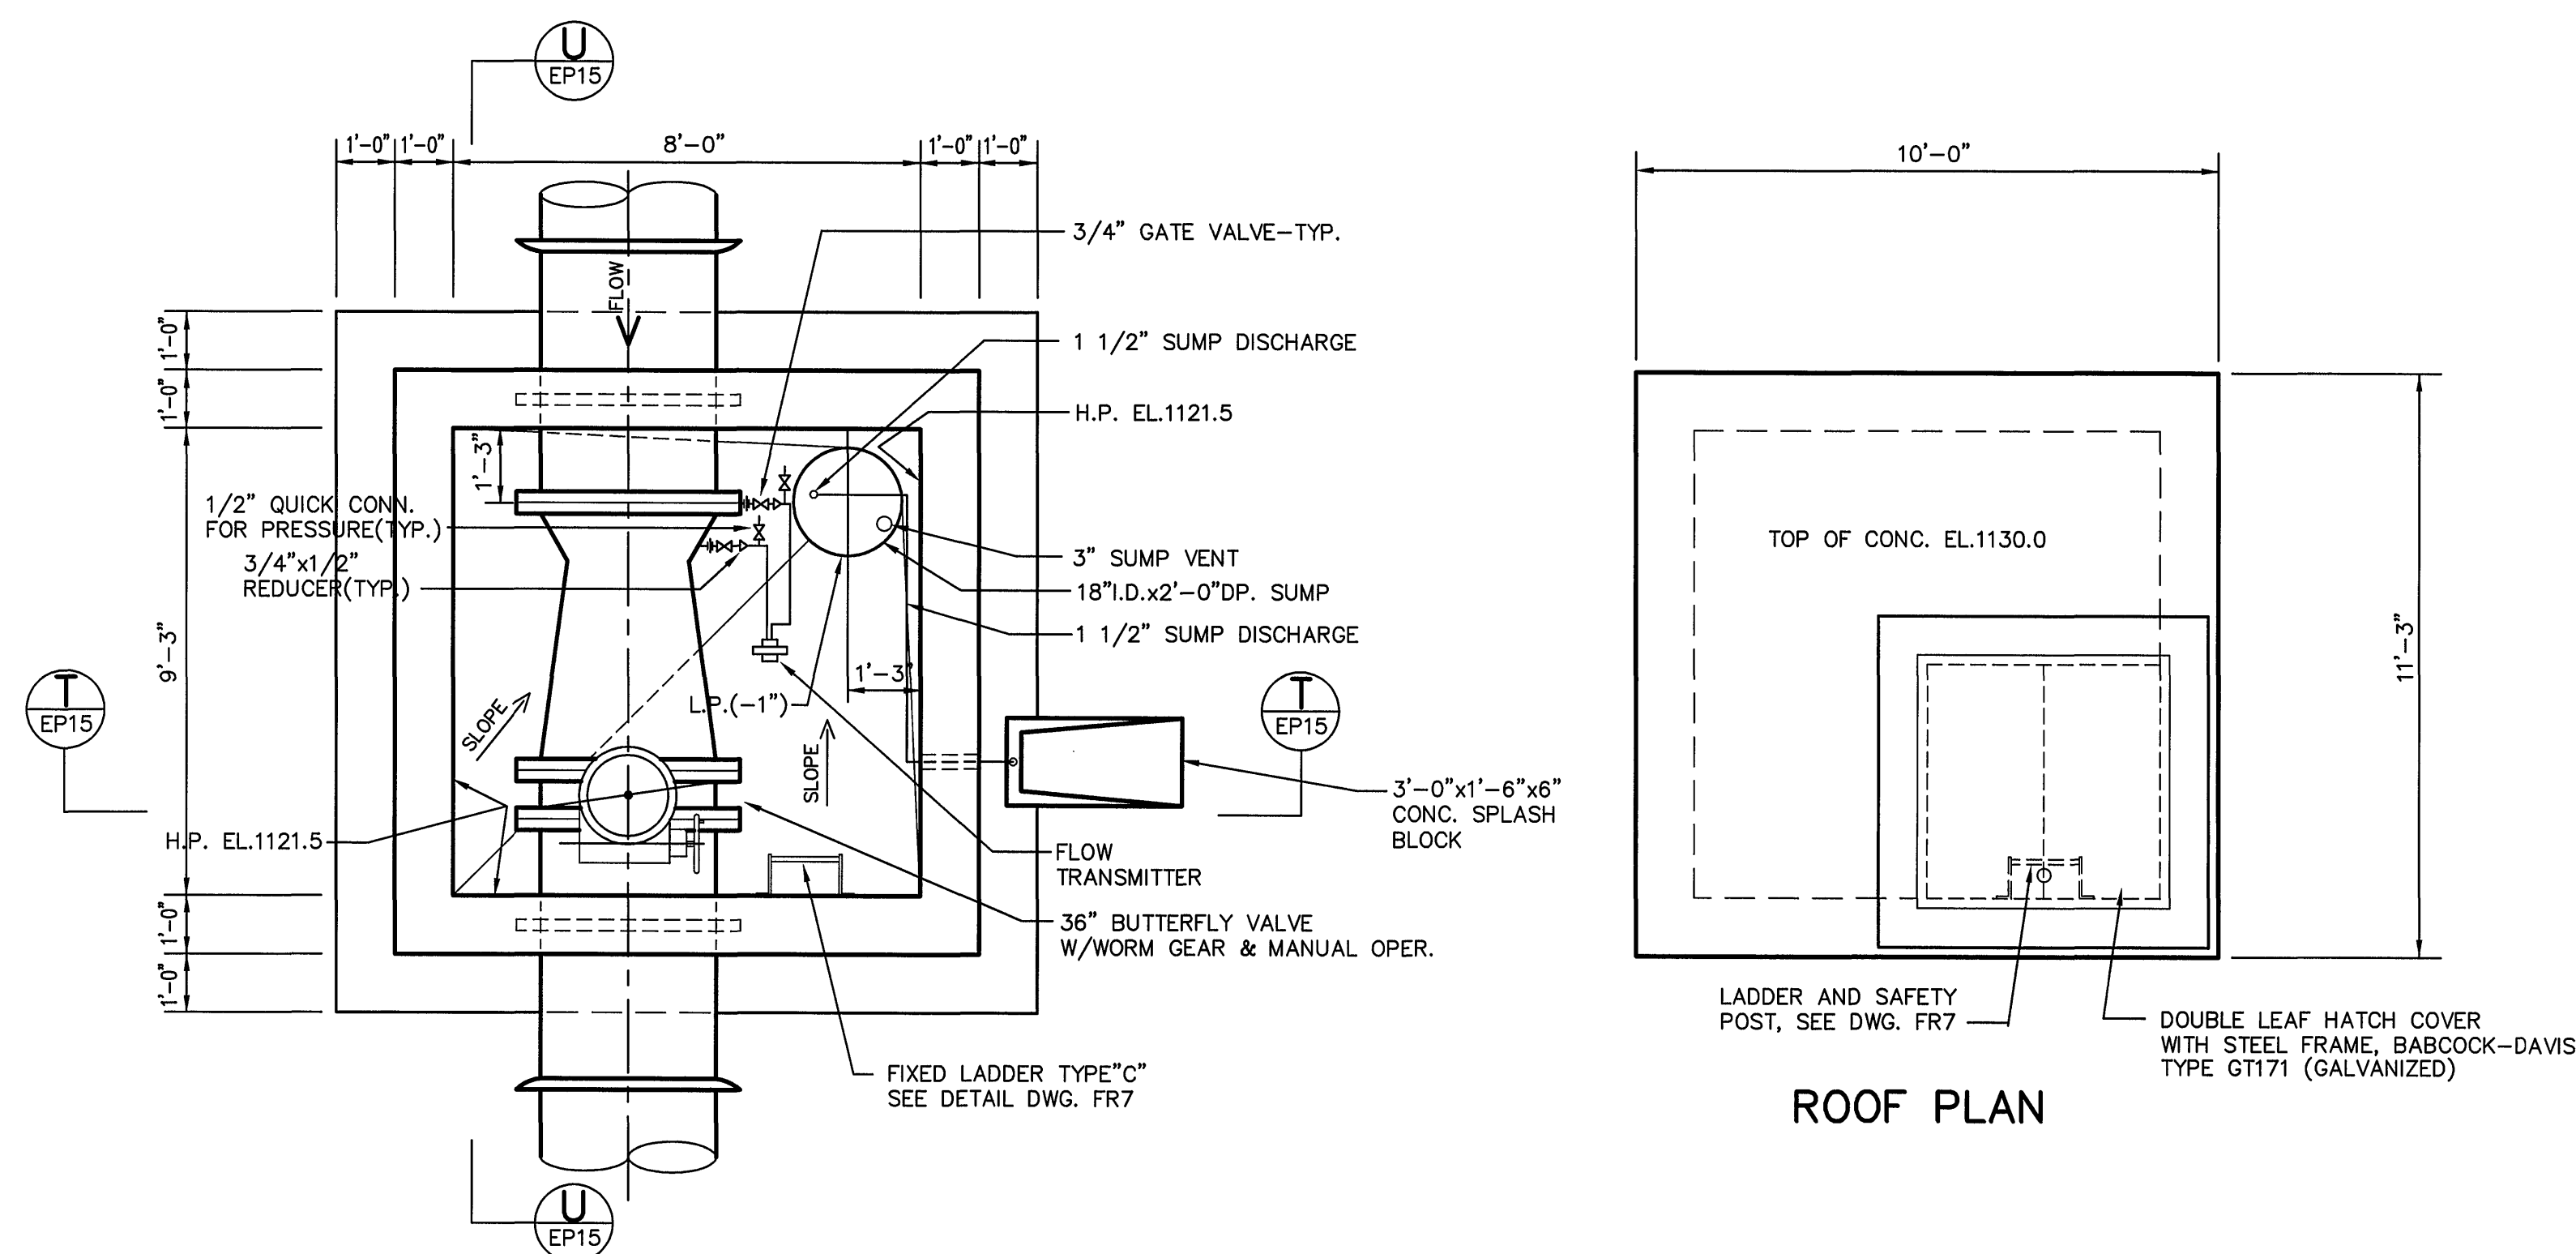

ROOF PLAN

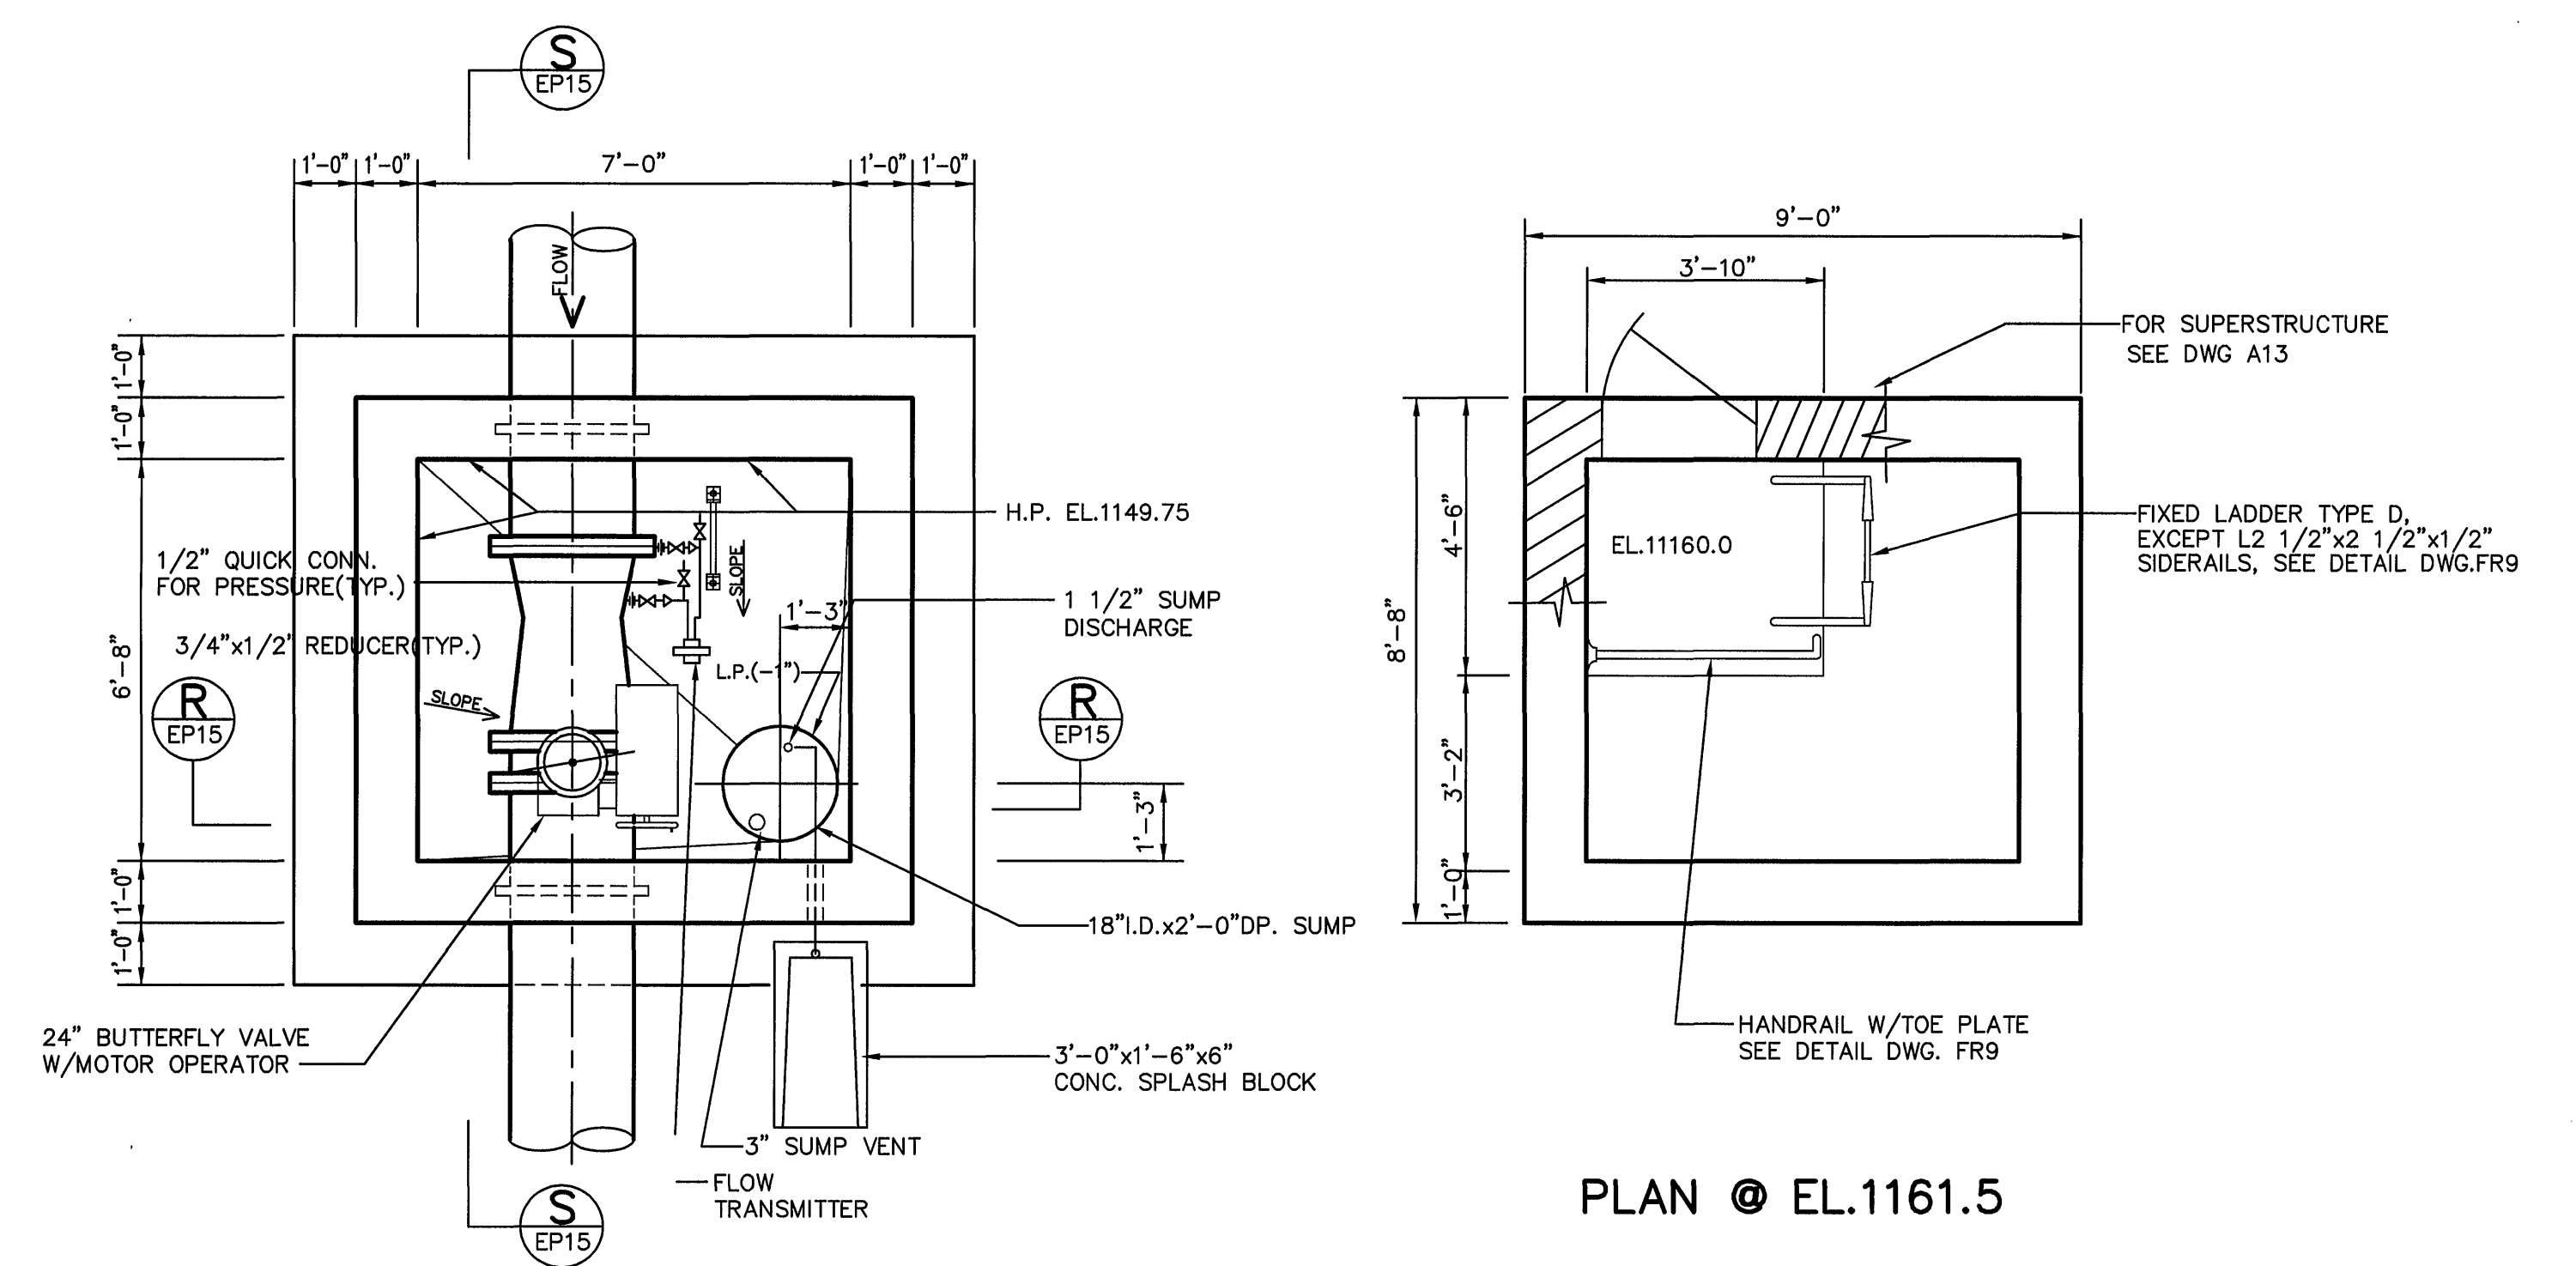


PLAN @ EL.1161.5

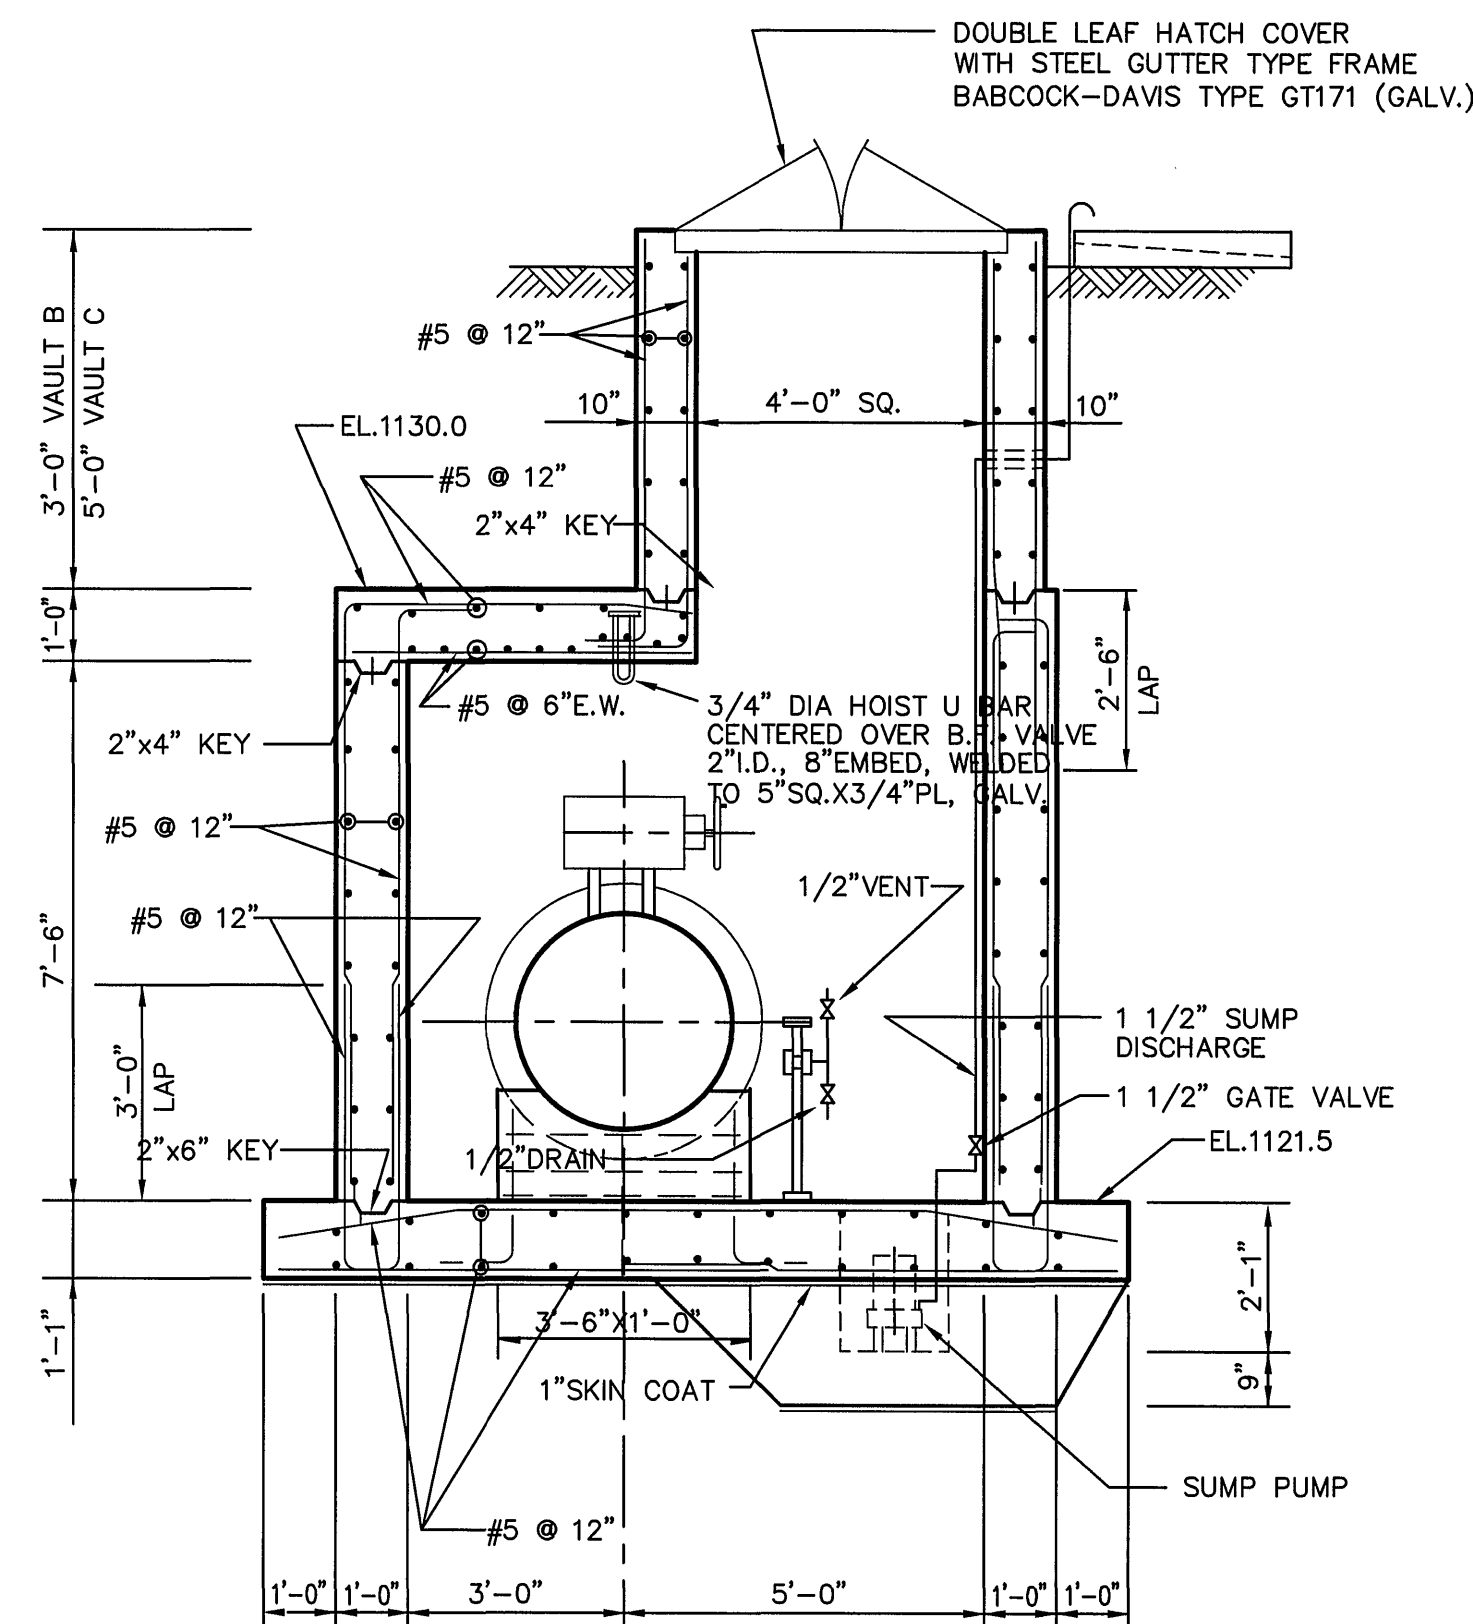


SECTION T

36" DIA. METER VAULTS B & C

SEE EP5 AND FR2 FOR LOCATION

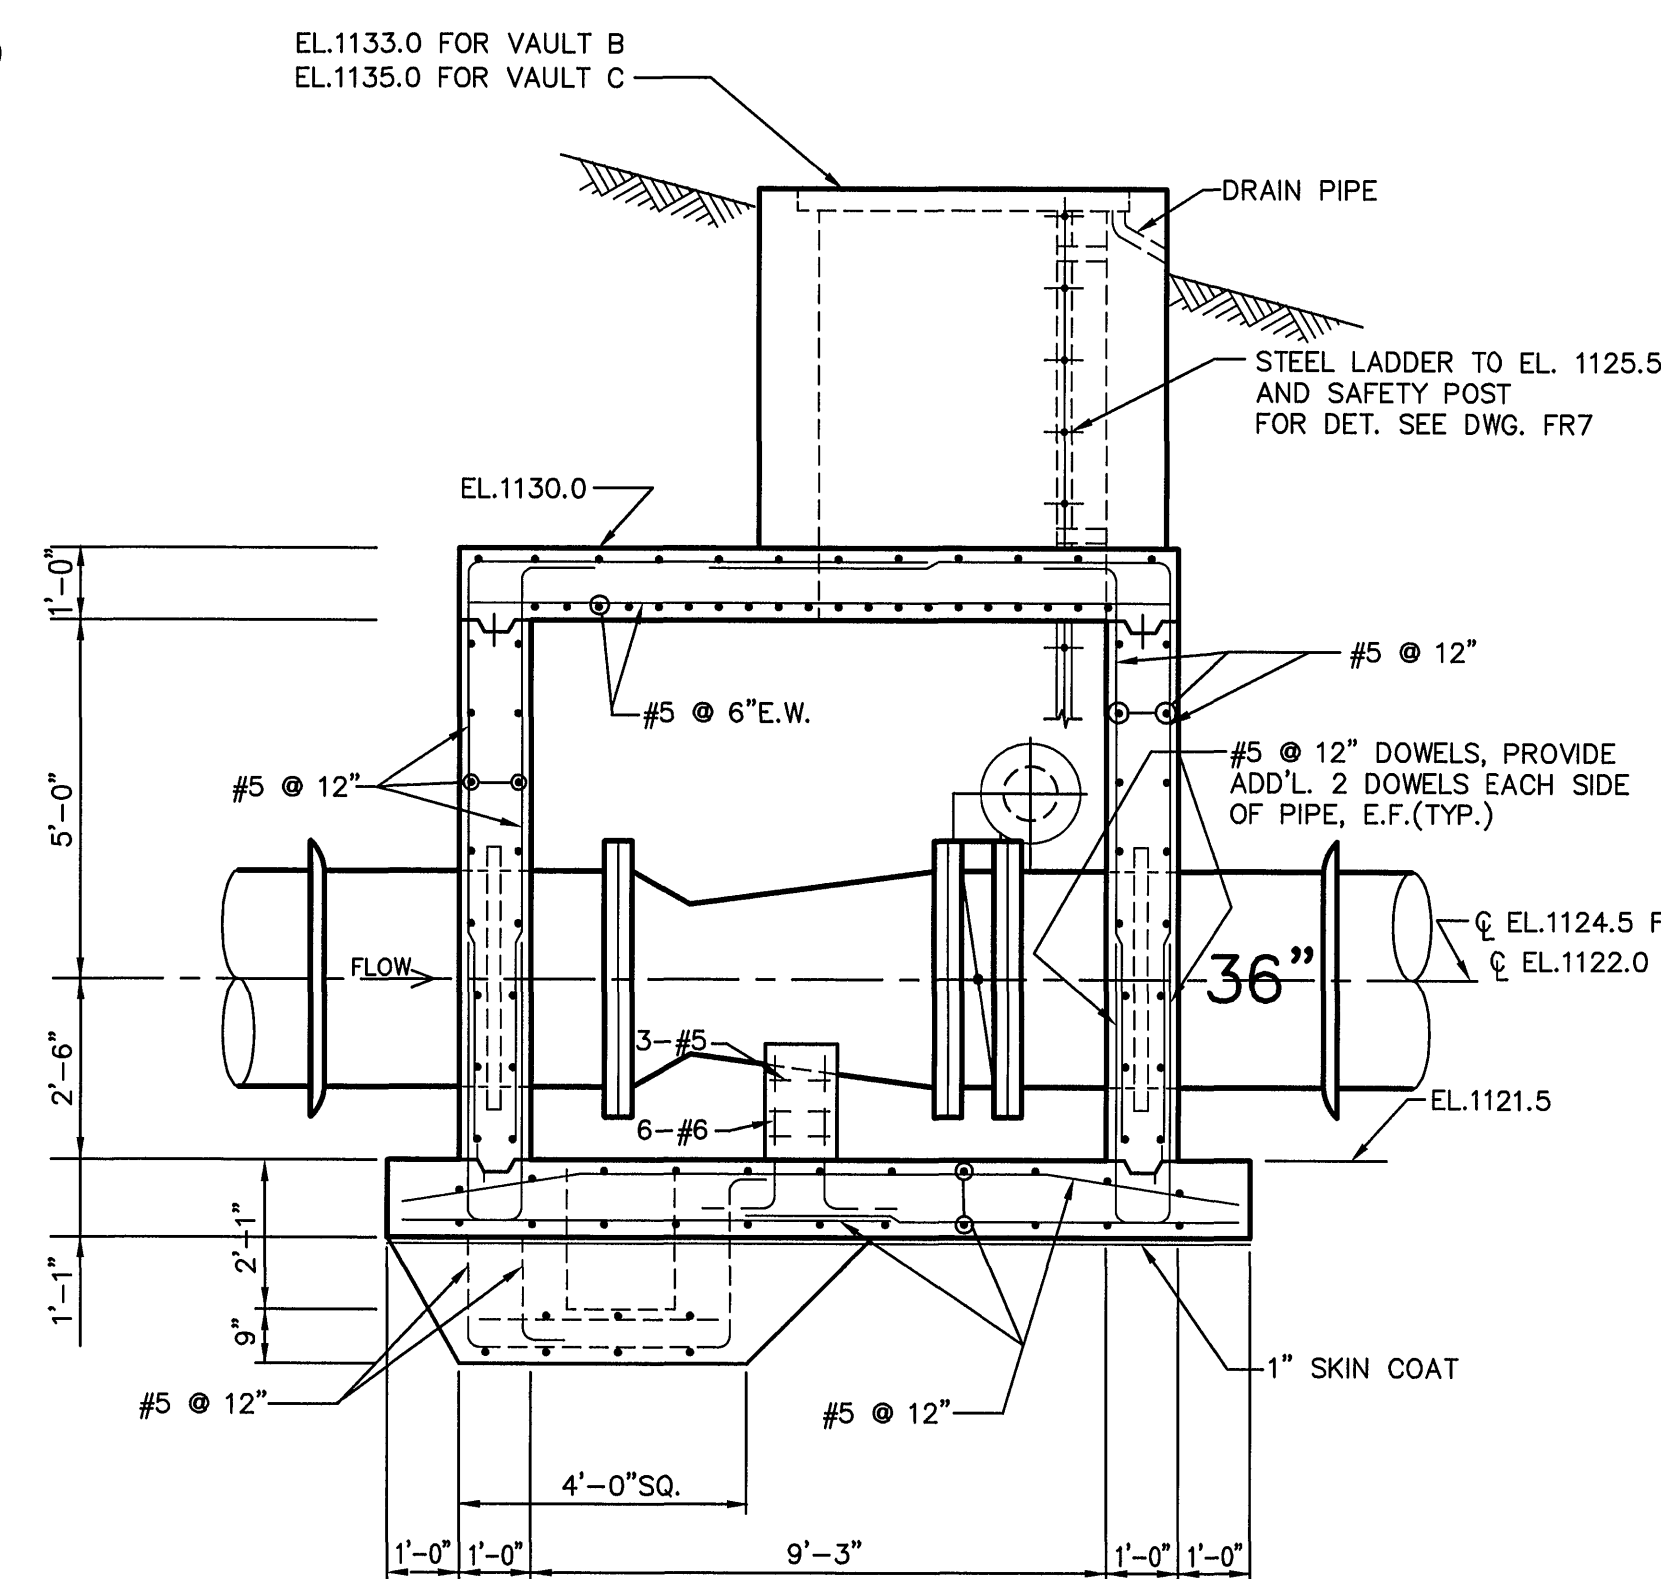


SECTION U

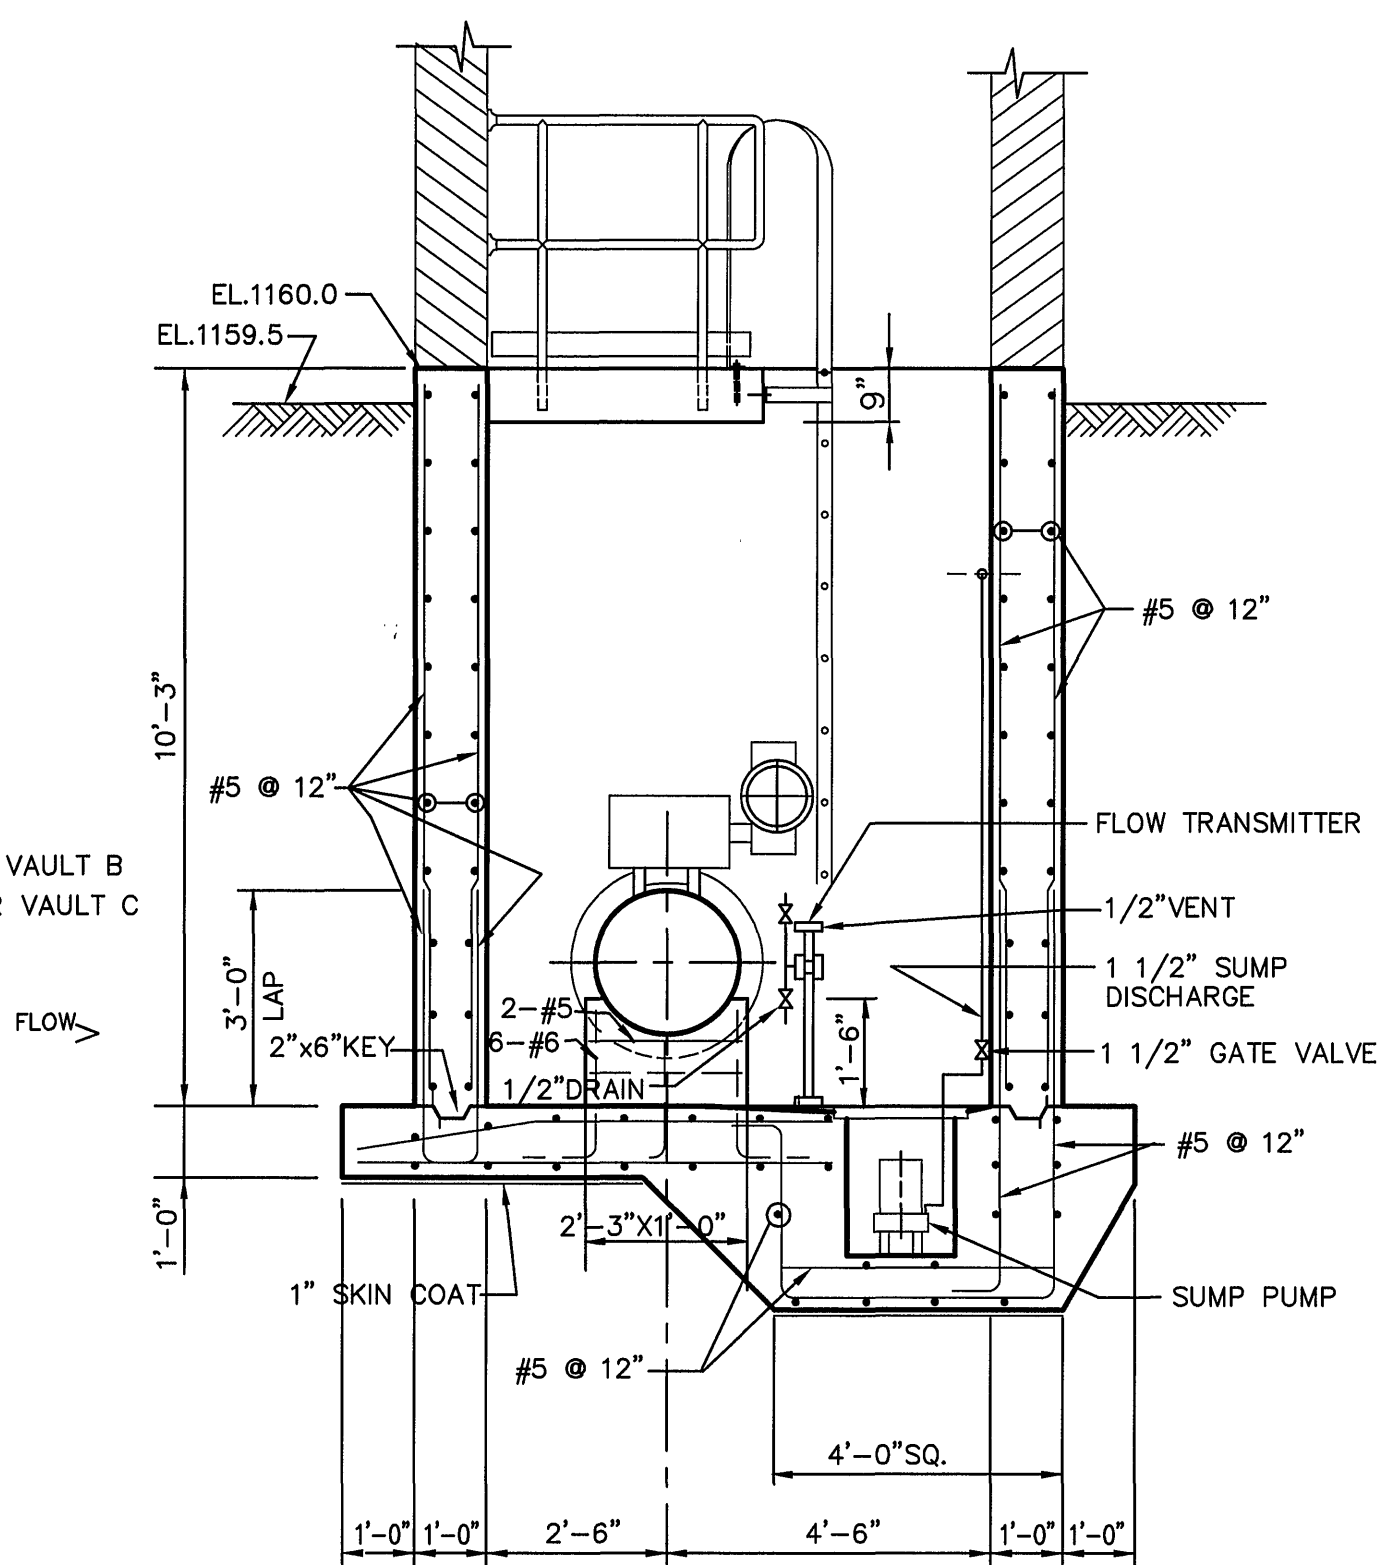

SECTION R

24" DIA. RATE CONTROLLER VAULT A

SEE EP5 AND FL1 FOR LOCATION

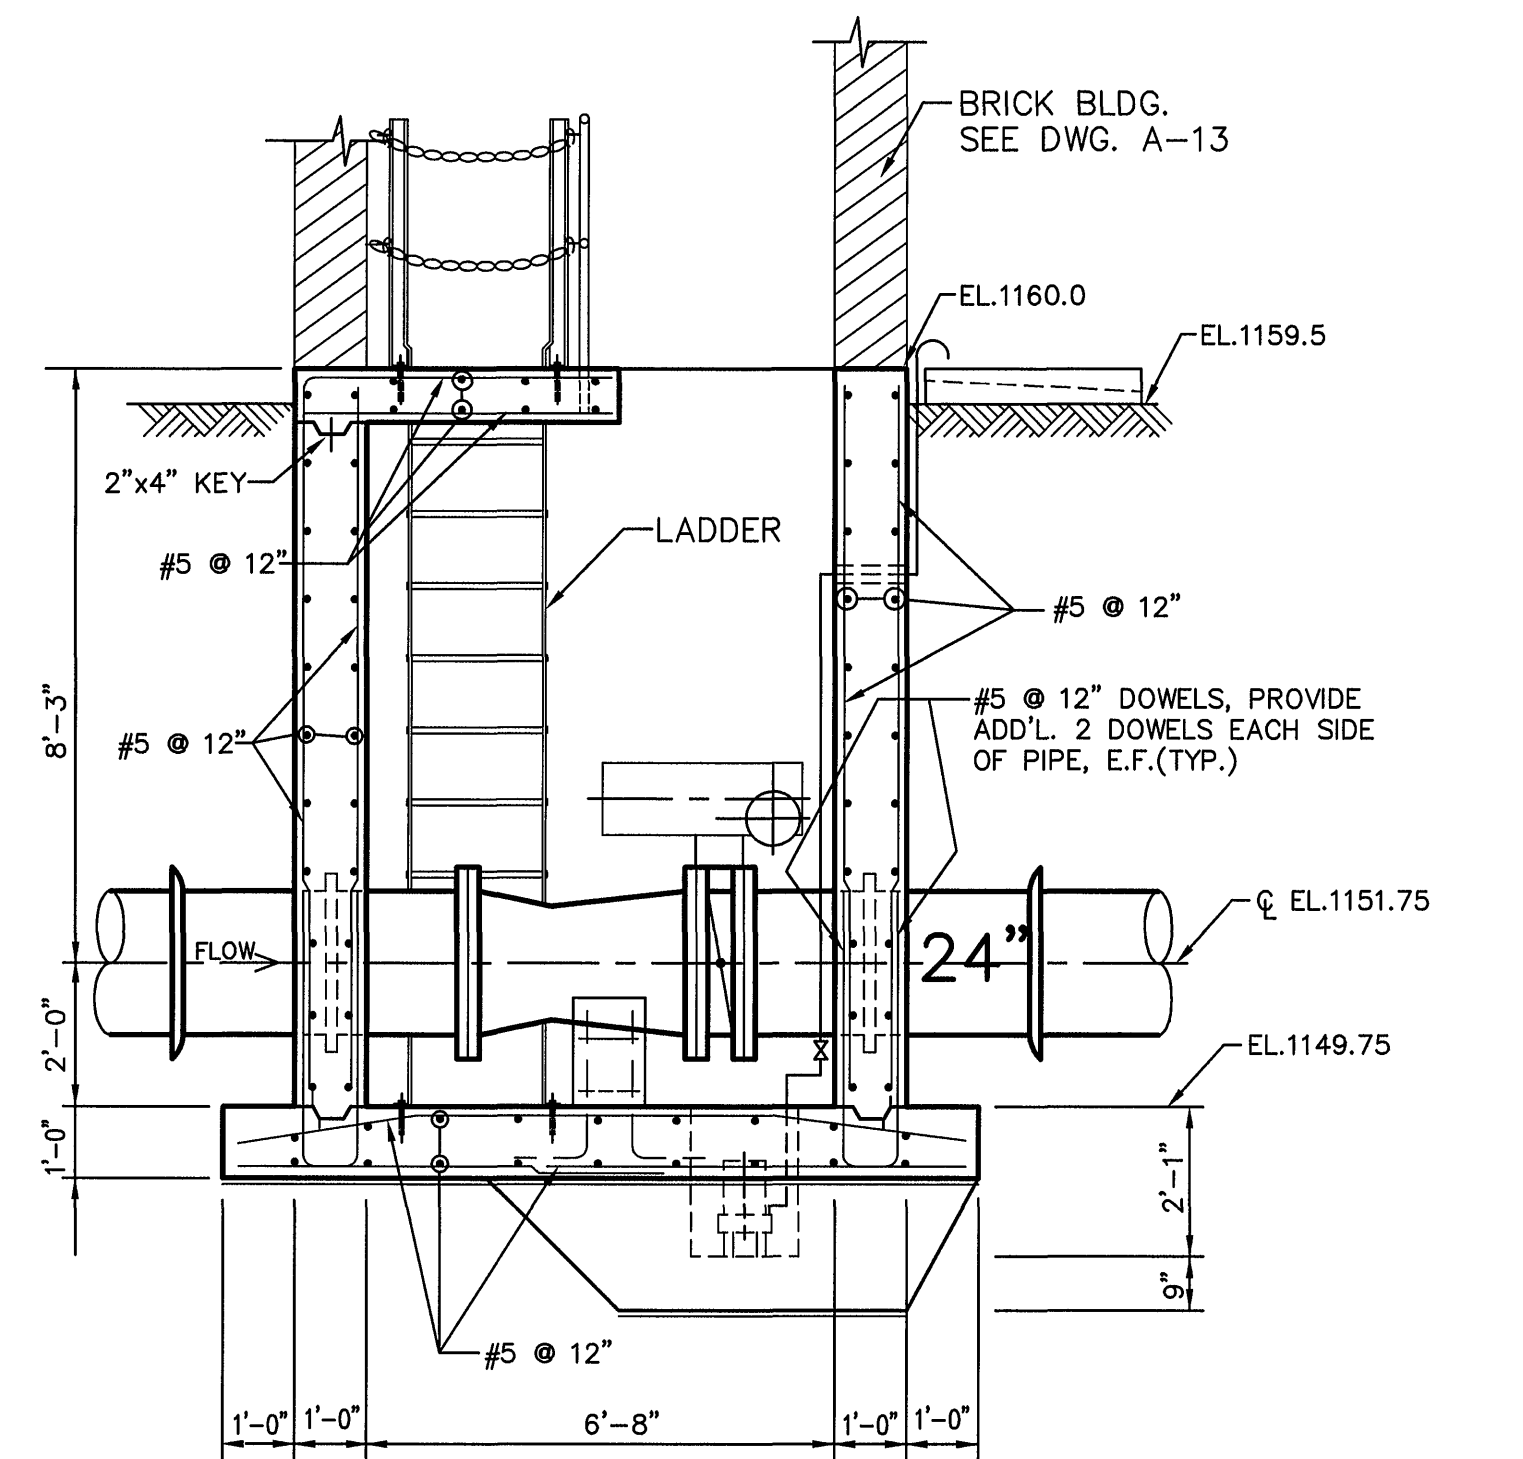

SECTION R

SCALE: 2 1 0 1 2 3 4 5 6 FT

DRAWING OF RECORD

DATE: SEP 30 1997

GENERAL NOTES:
1. FOR GENERAL STRUCTURAL DETAILS SEE DWG. FR9.

MATTEN & CRAIG CONSULTING ENGINEERS • SURVEYORS ROANOKE VIRGINIA	DESIGNED: K.C. S.C.P.			REV.	DATE	DESCRIPTION	BY	APP.	CARVINS COVE FILTER PLANT IMPROVEMENTS – PHASE I ROANOKE, VIRGINIA	DATE APRIL 1992	
	DRAWN: H.F. R.T.										COMM. NO. 9130
	CHECKED: Y.T.L.										SHEET EP15
ALVORD, BURDICK & HOWSON ENGINEERS CHICAGO									WASHWATER RATE CONTROLLER VAULT A AND METER VAULTS B & C		