



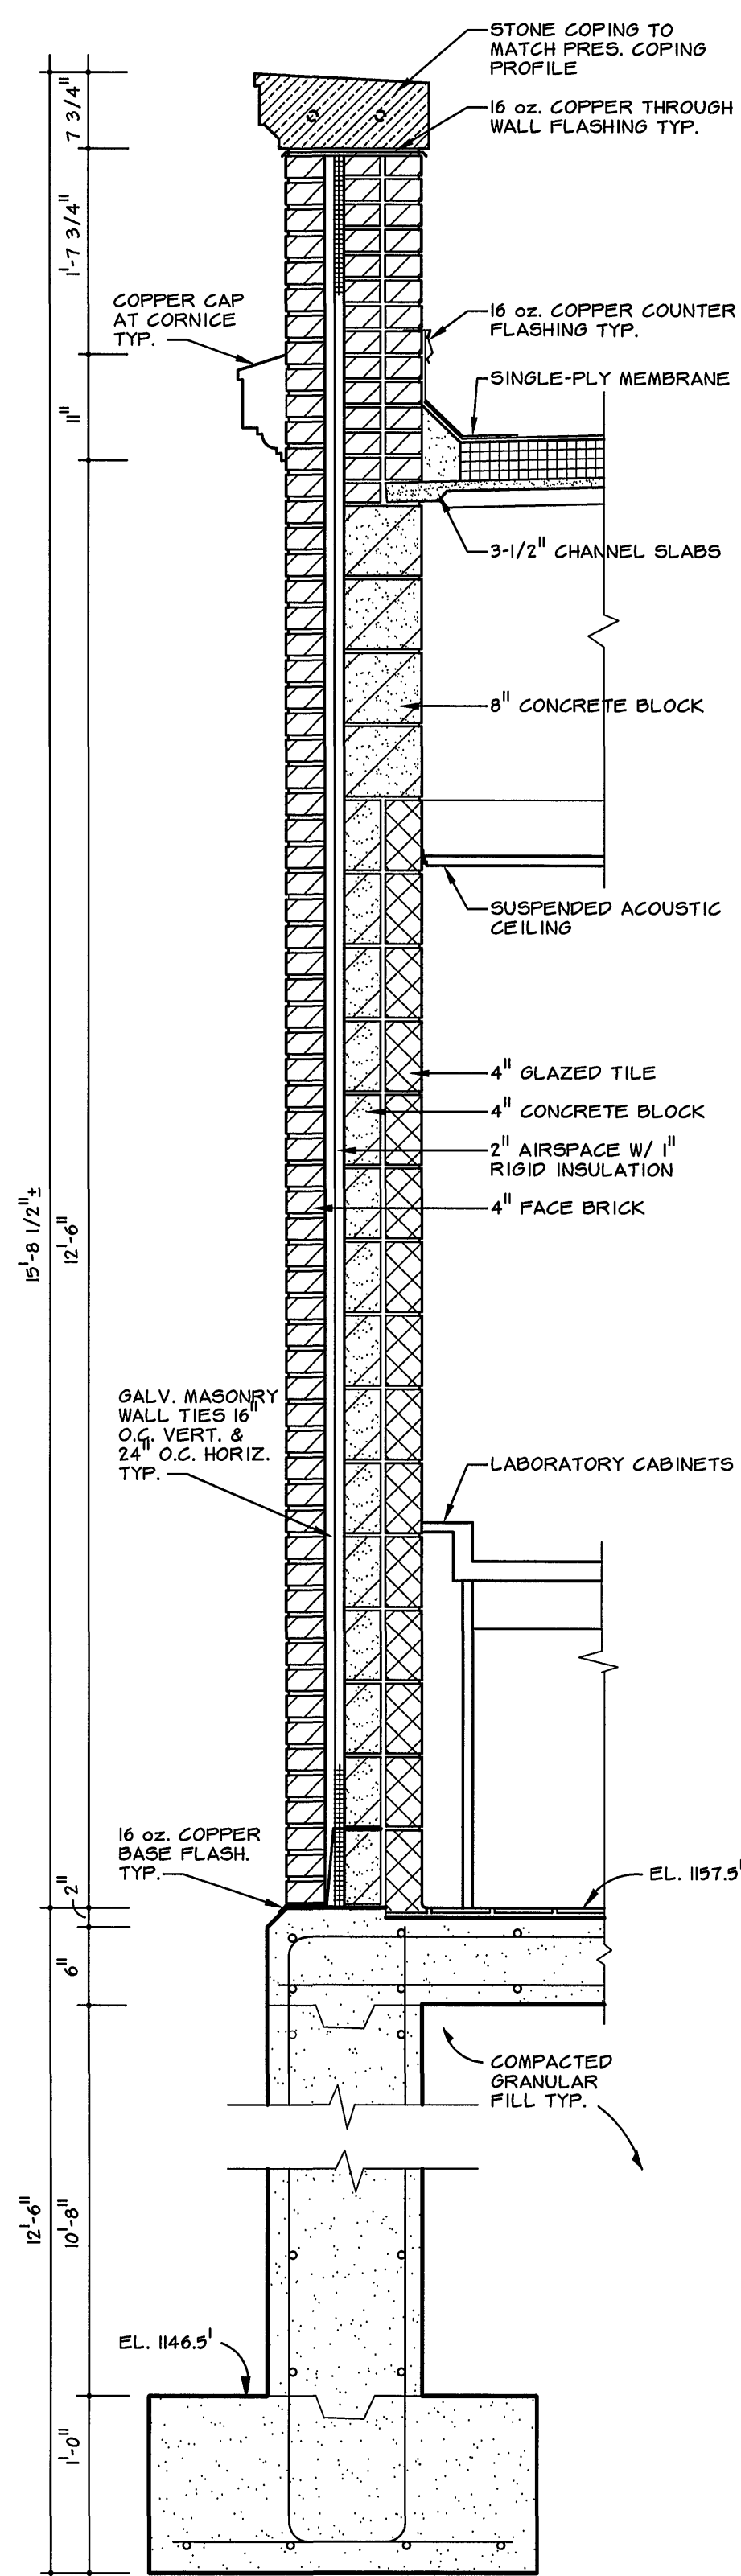

WALL SECTION 1

SCALE: 0 6" 1'-0" 2'-0" 3'-0"


A4

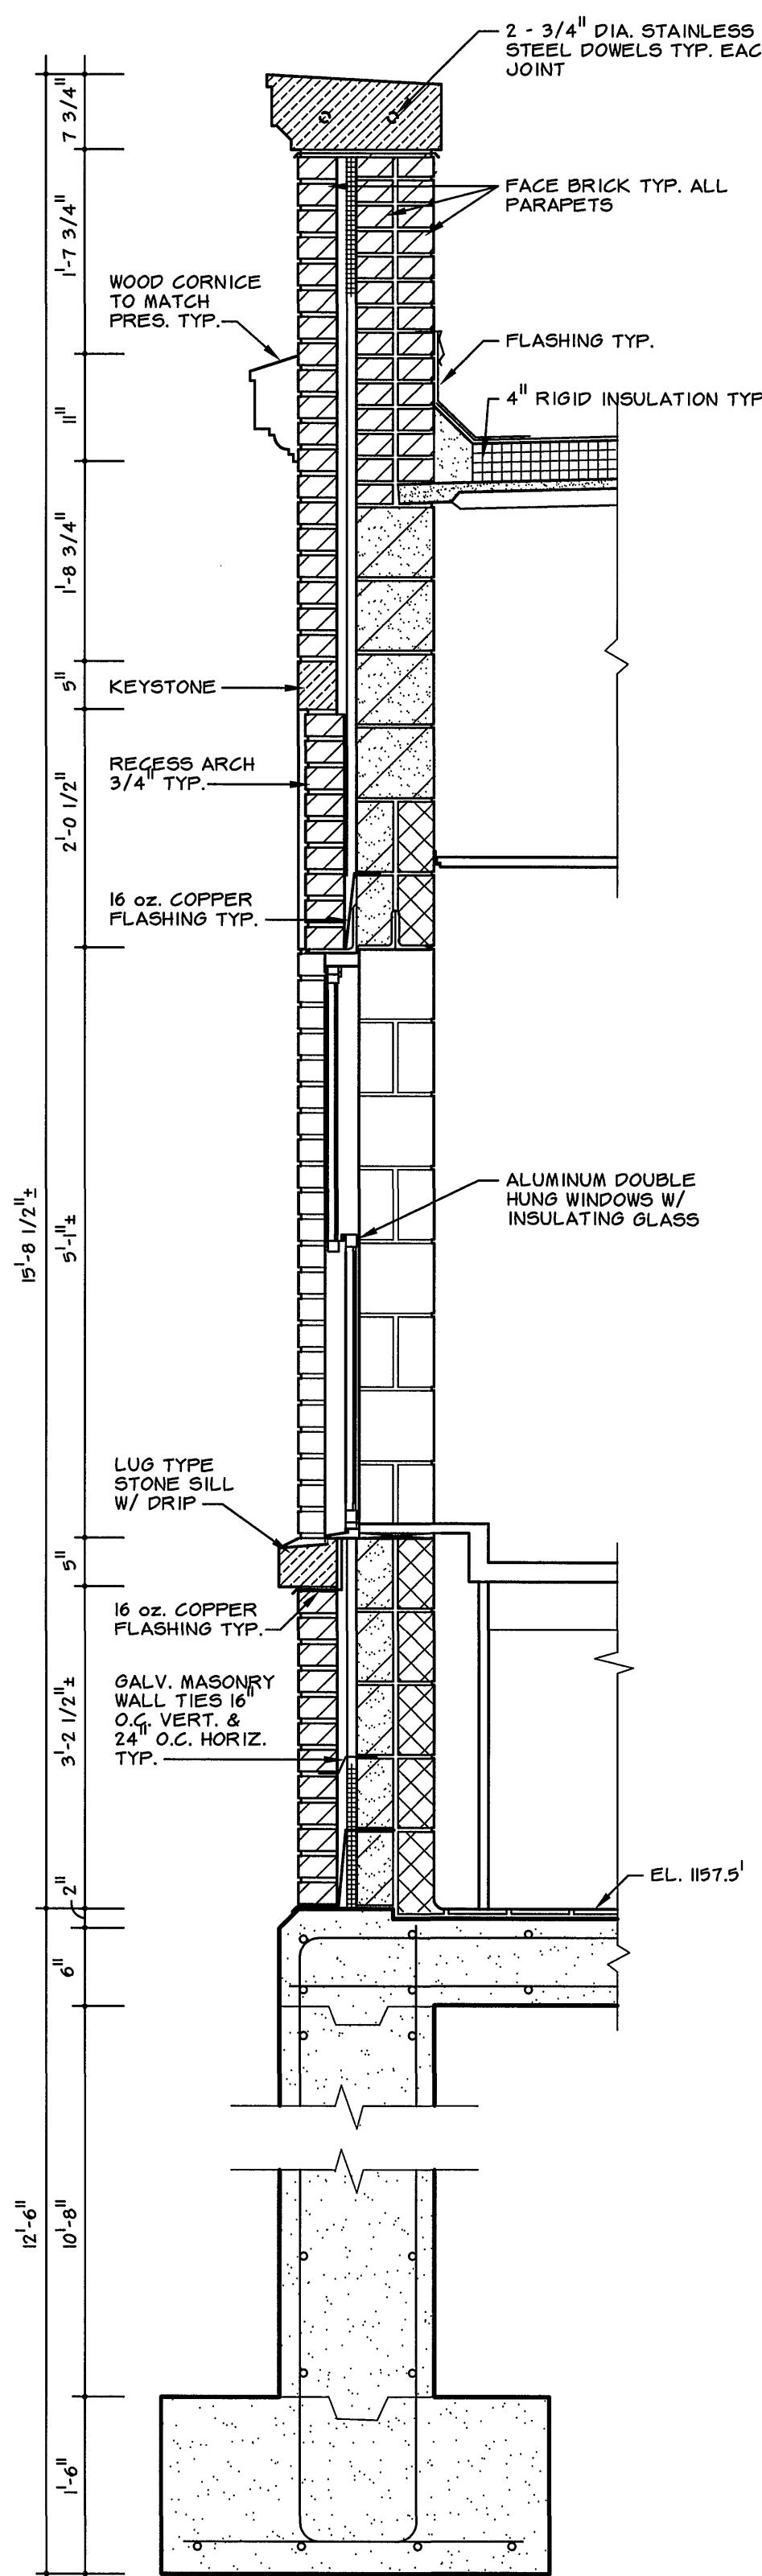

WALL SECTION 2

SCALE: 0 6" 1'-0" 2'-0" 3'-0"


A4

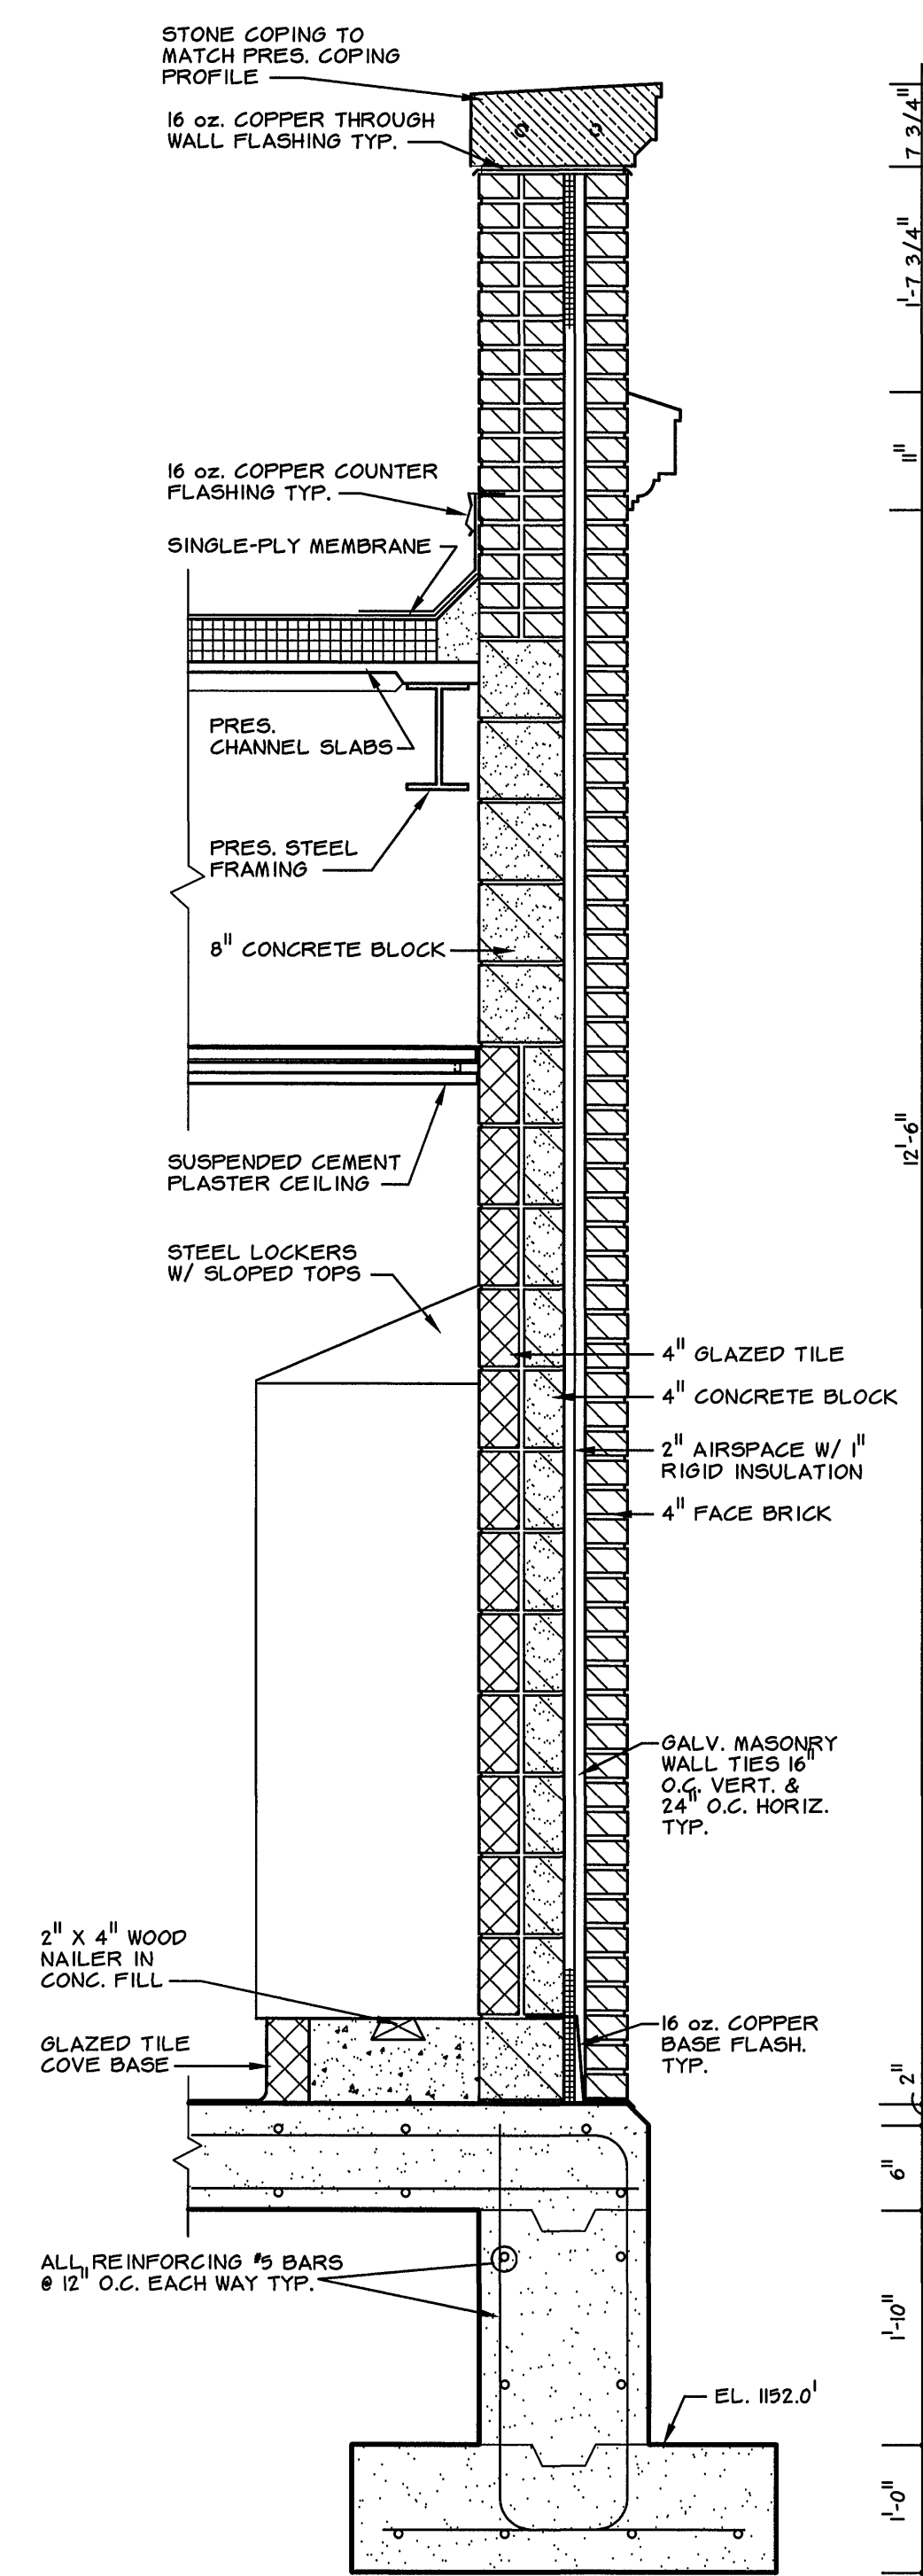

WALL SECTION 3


SCALE: 0 6" 1'-0" 2'-0" 3'-0"

A4

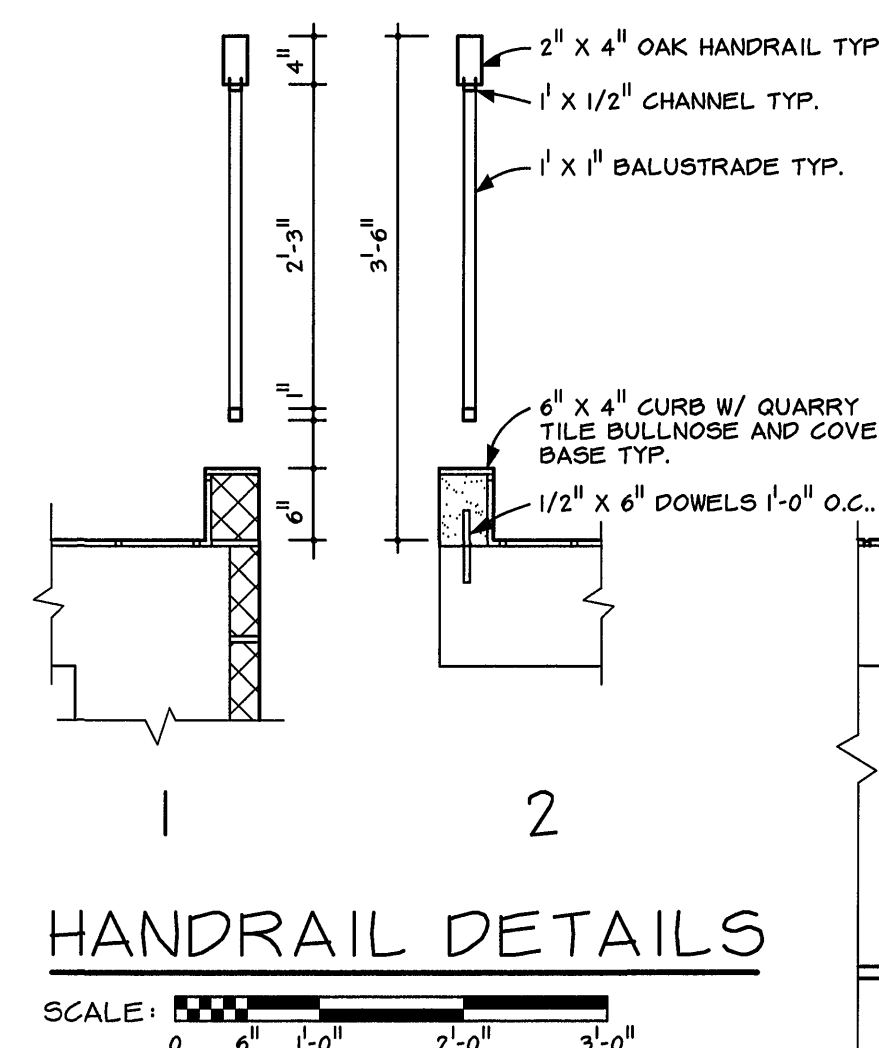

HANDRAIL DETAILS

SCALE: 0 6" 1'-0" 2'-0" 3'-0"

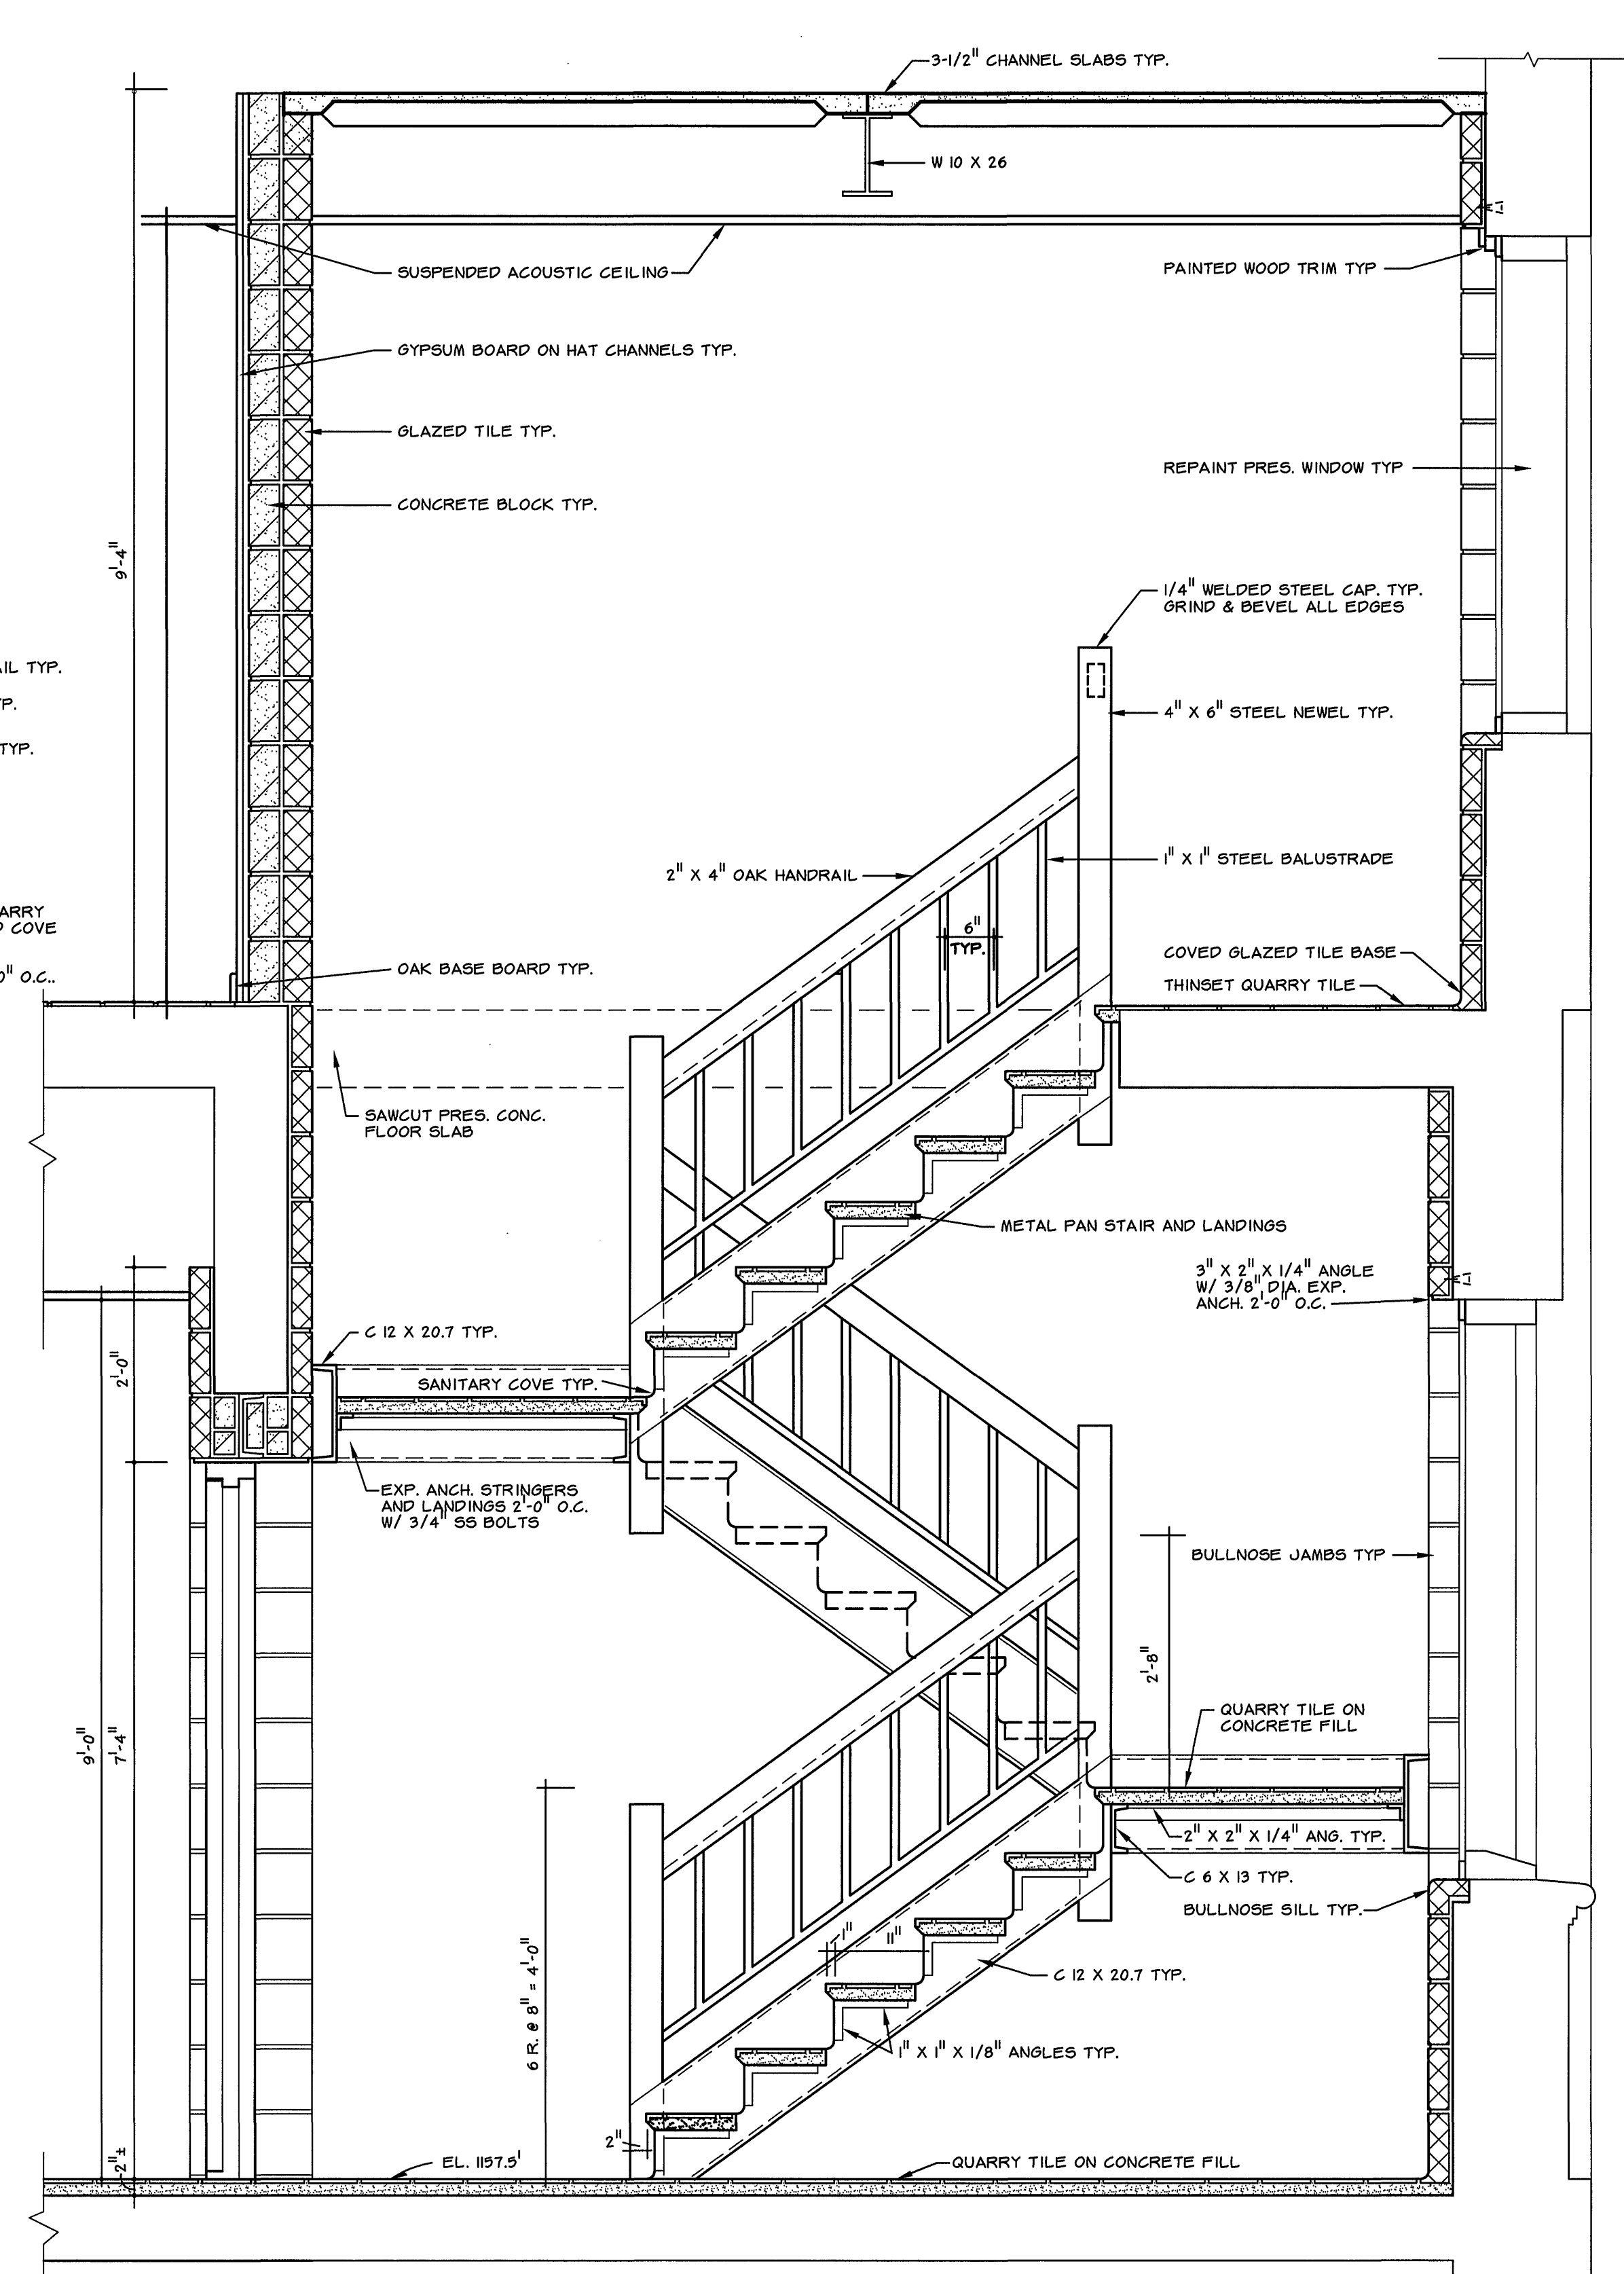

WALL & STAIR SECTION 4

SCALE: 0 6" 1'-0" 2'-0" 3'-0"

A4

DRAWING OF RECORD

DATE: SEP 30 1997


MATTERN & CRAIG
CONSULTING ENGINEERS • SURVEYORS
ROANOKE VIRGINIA

ALVORD, BURDICK & HOWSON
ENGINEERS CHICAGO

DESIGNED:

DRAWN:

CHECKED:

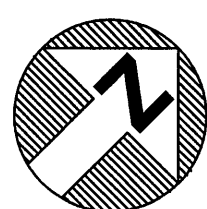

COMMONWEALTH OF VIRGINIA
YA-TAI LIN
NO. 022786
PROFESSIONAL ENGINEER

REV.	DATE	DESCRIPTION	BY	APP.

CARVINS COVE FILTER PLANT IMPROVEMENTS — PHASE I

ROANOKE, VIRGINIA

ADMINISTRATION BUILDING
WALL SECTIONS & DETAILS

DATE
APRIL 1992
COMM. NO.
9130
SHEET
A7

PLAN NO. 6199