
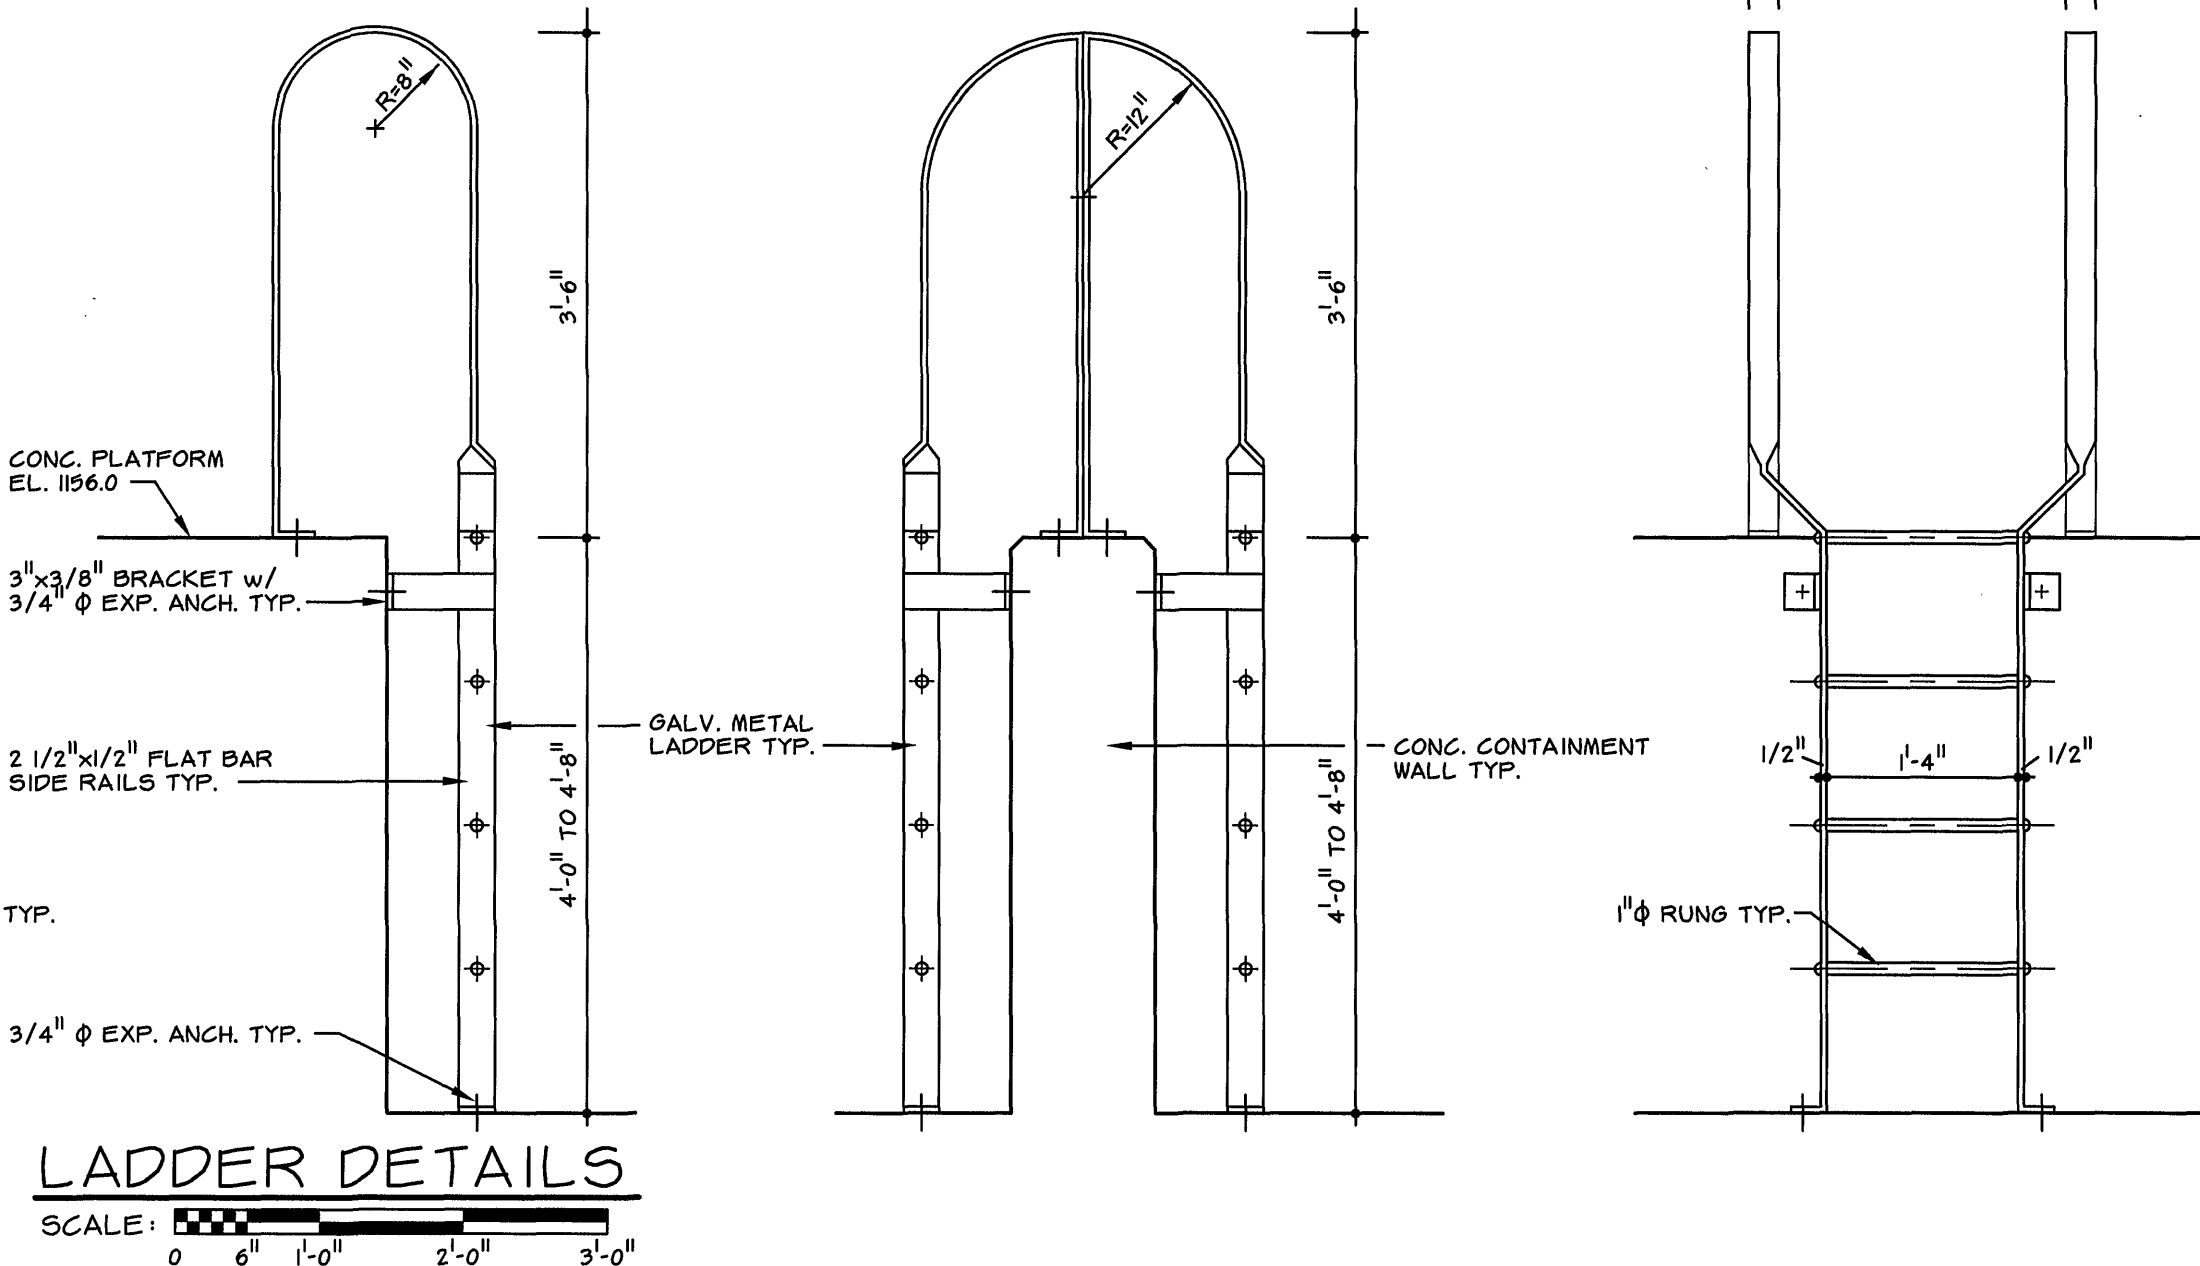
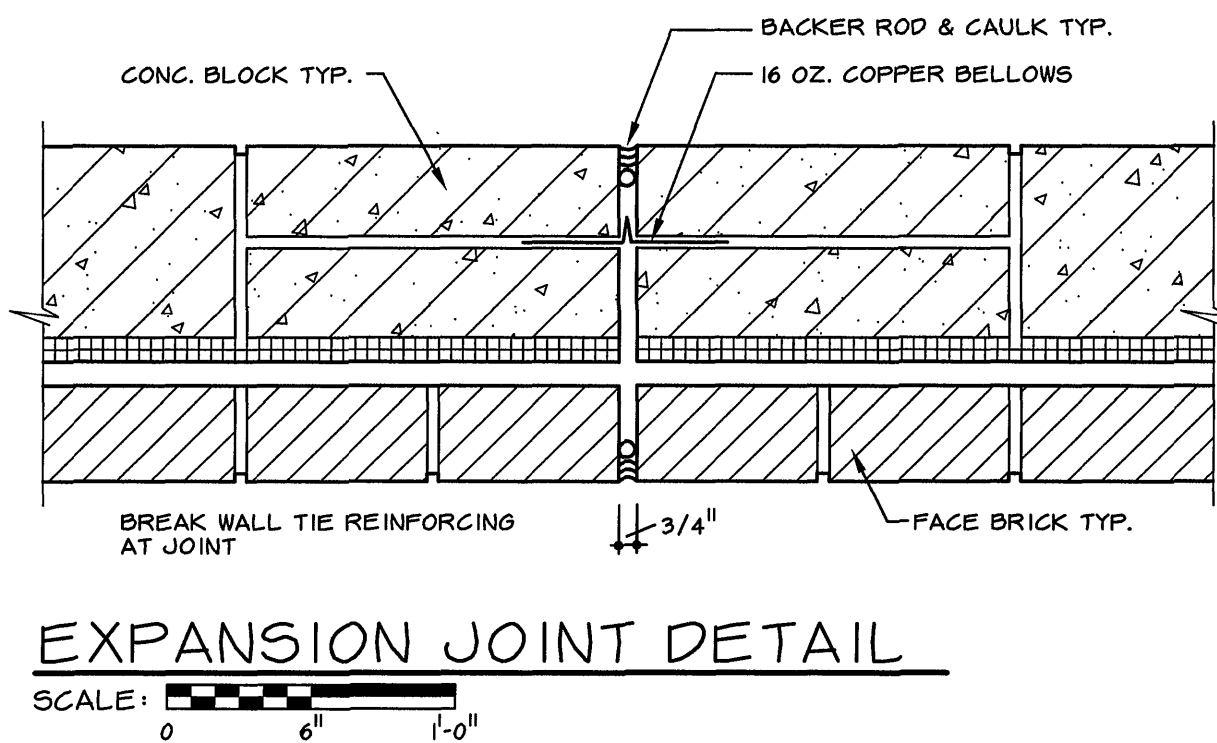
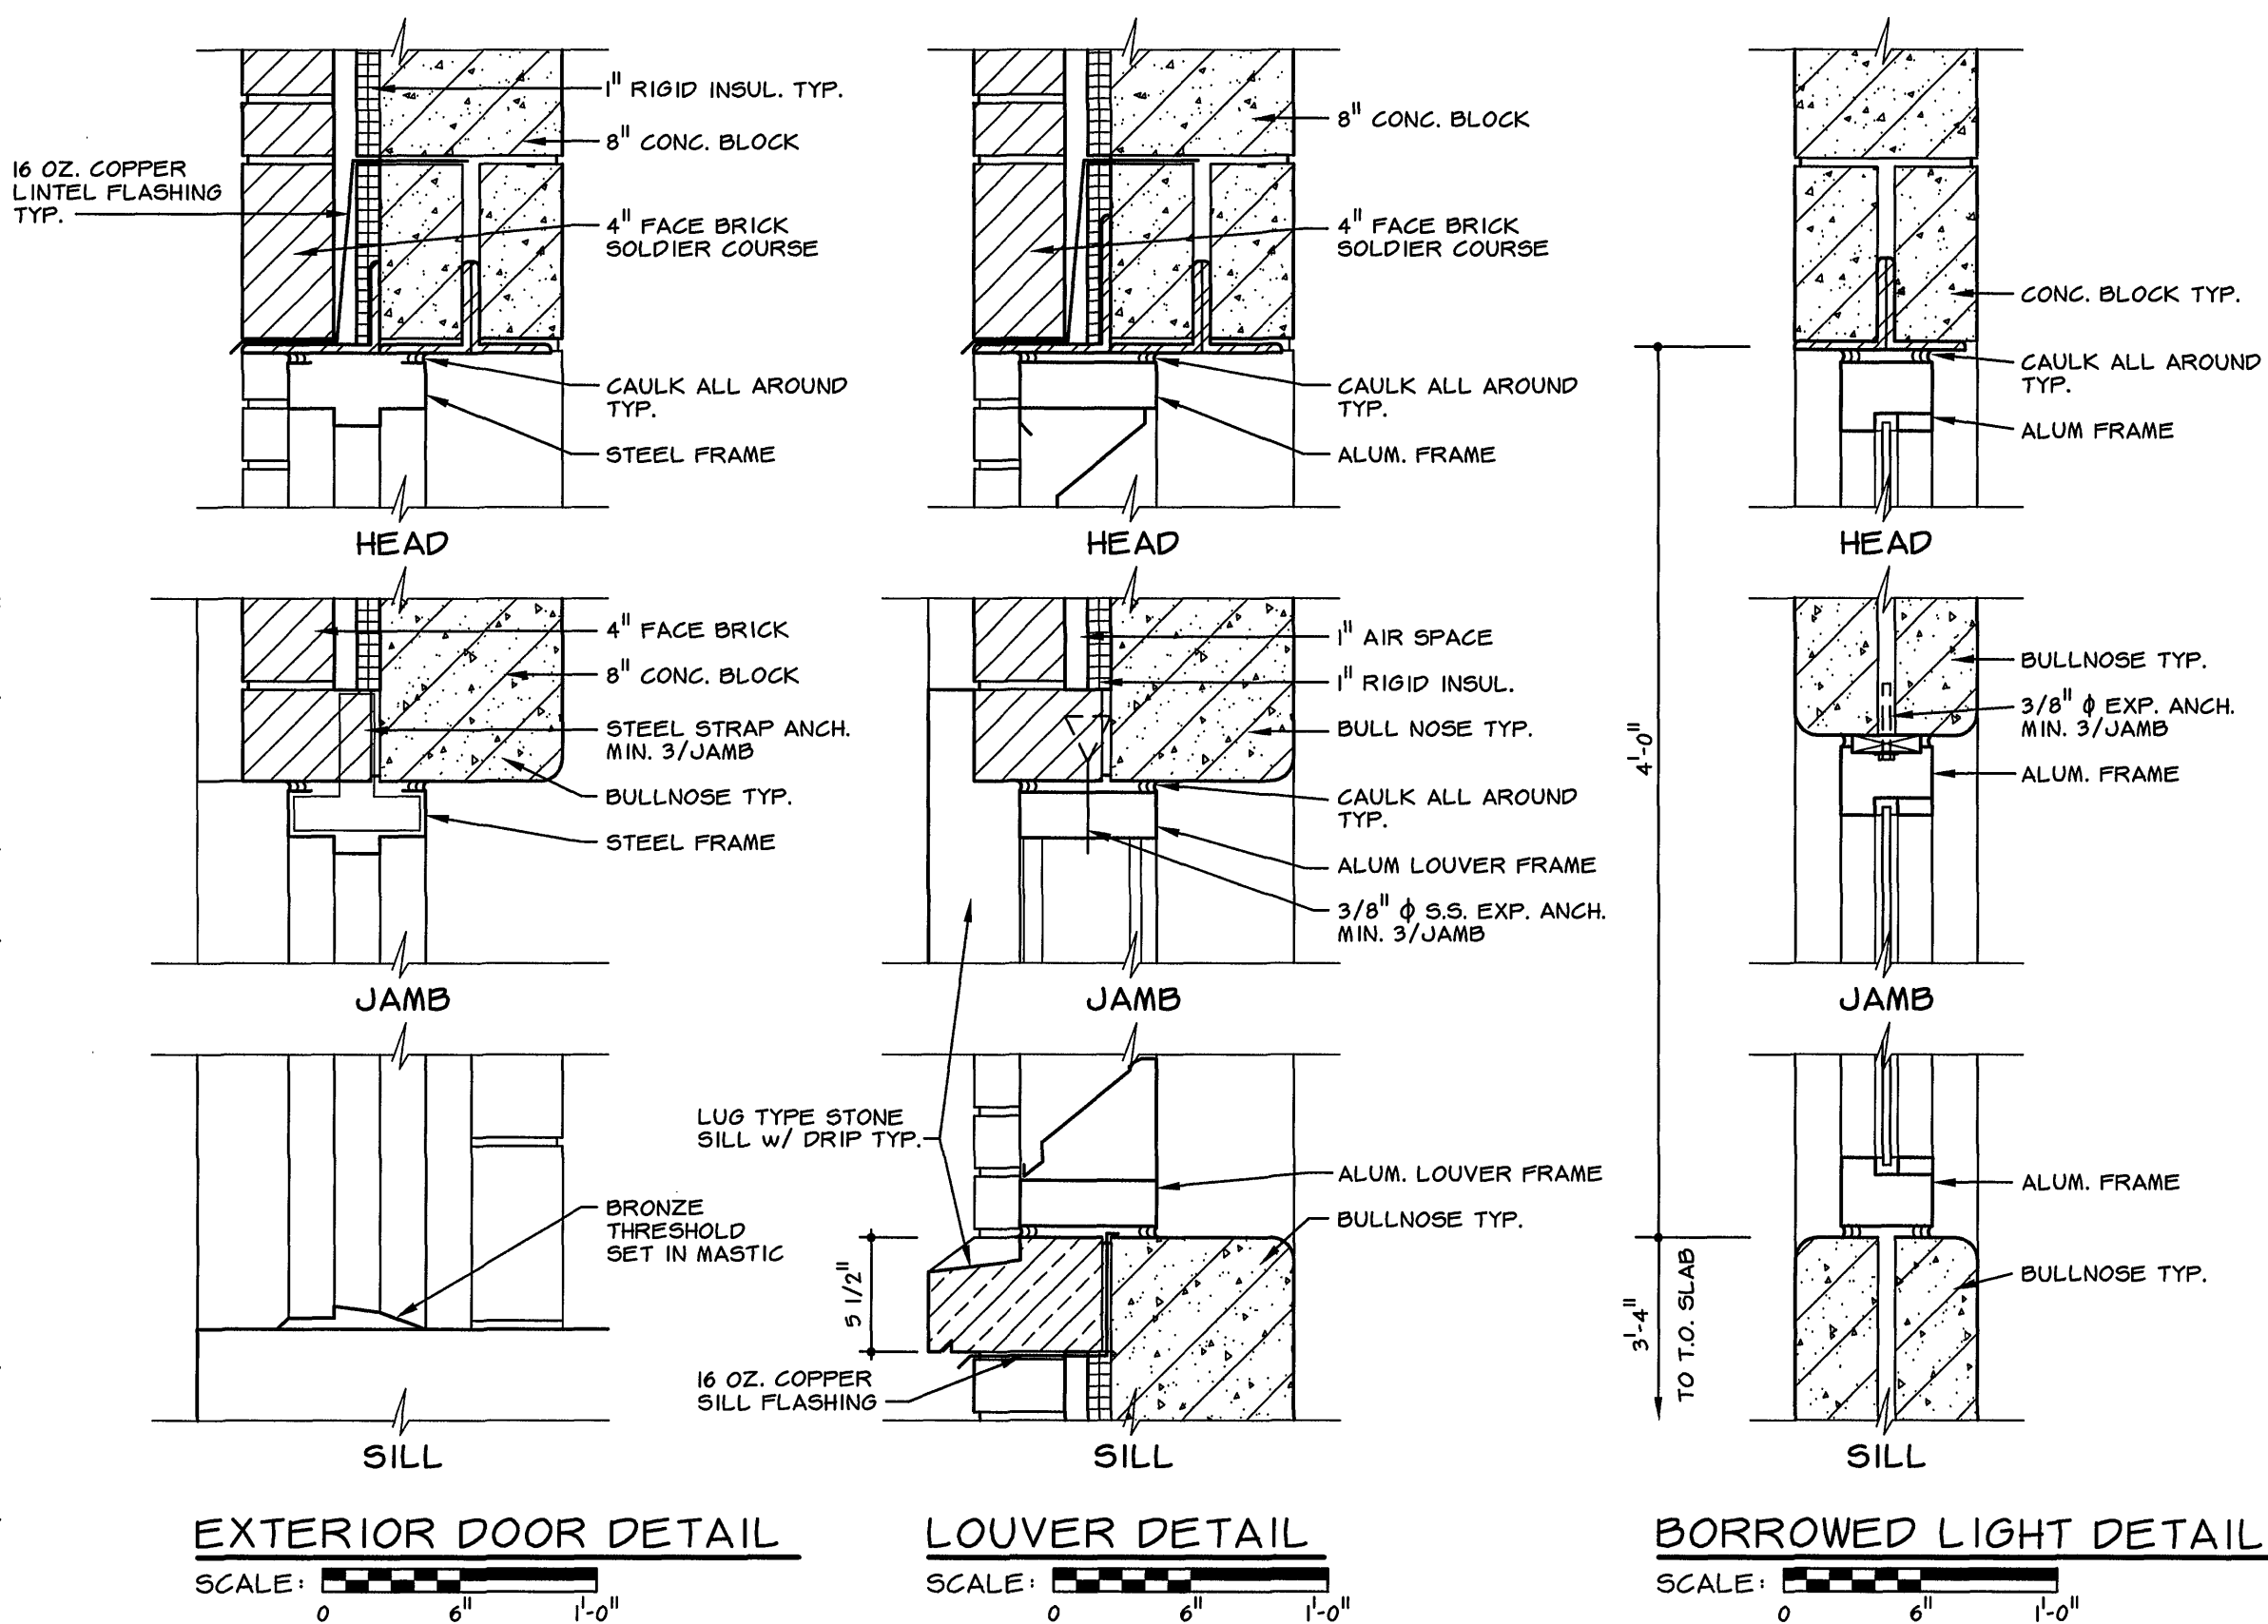


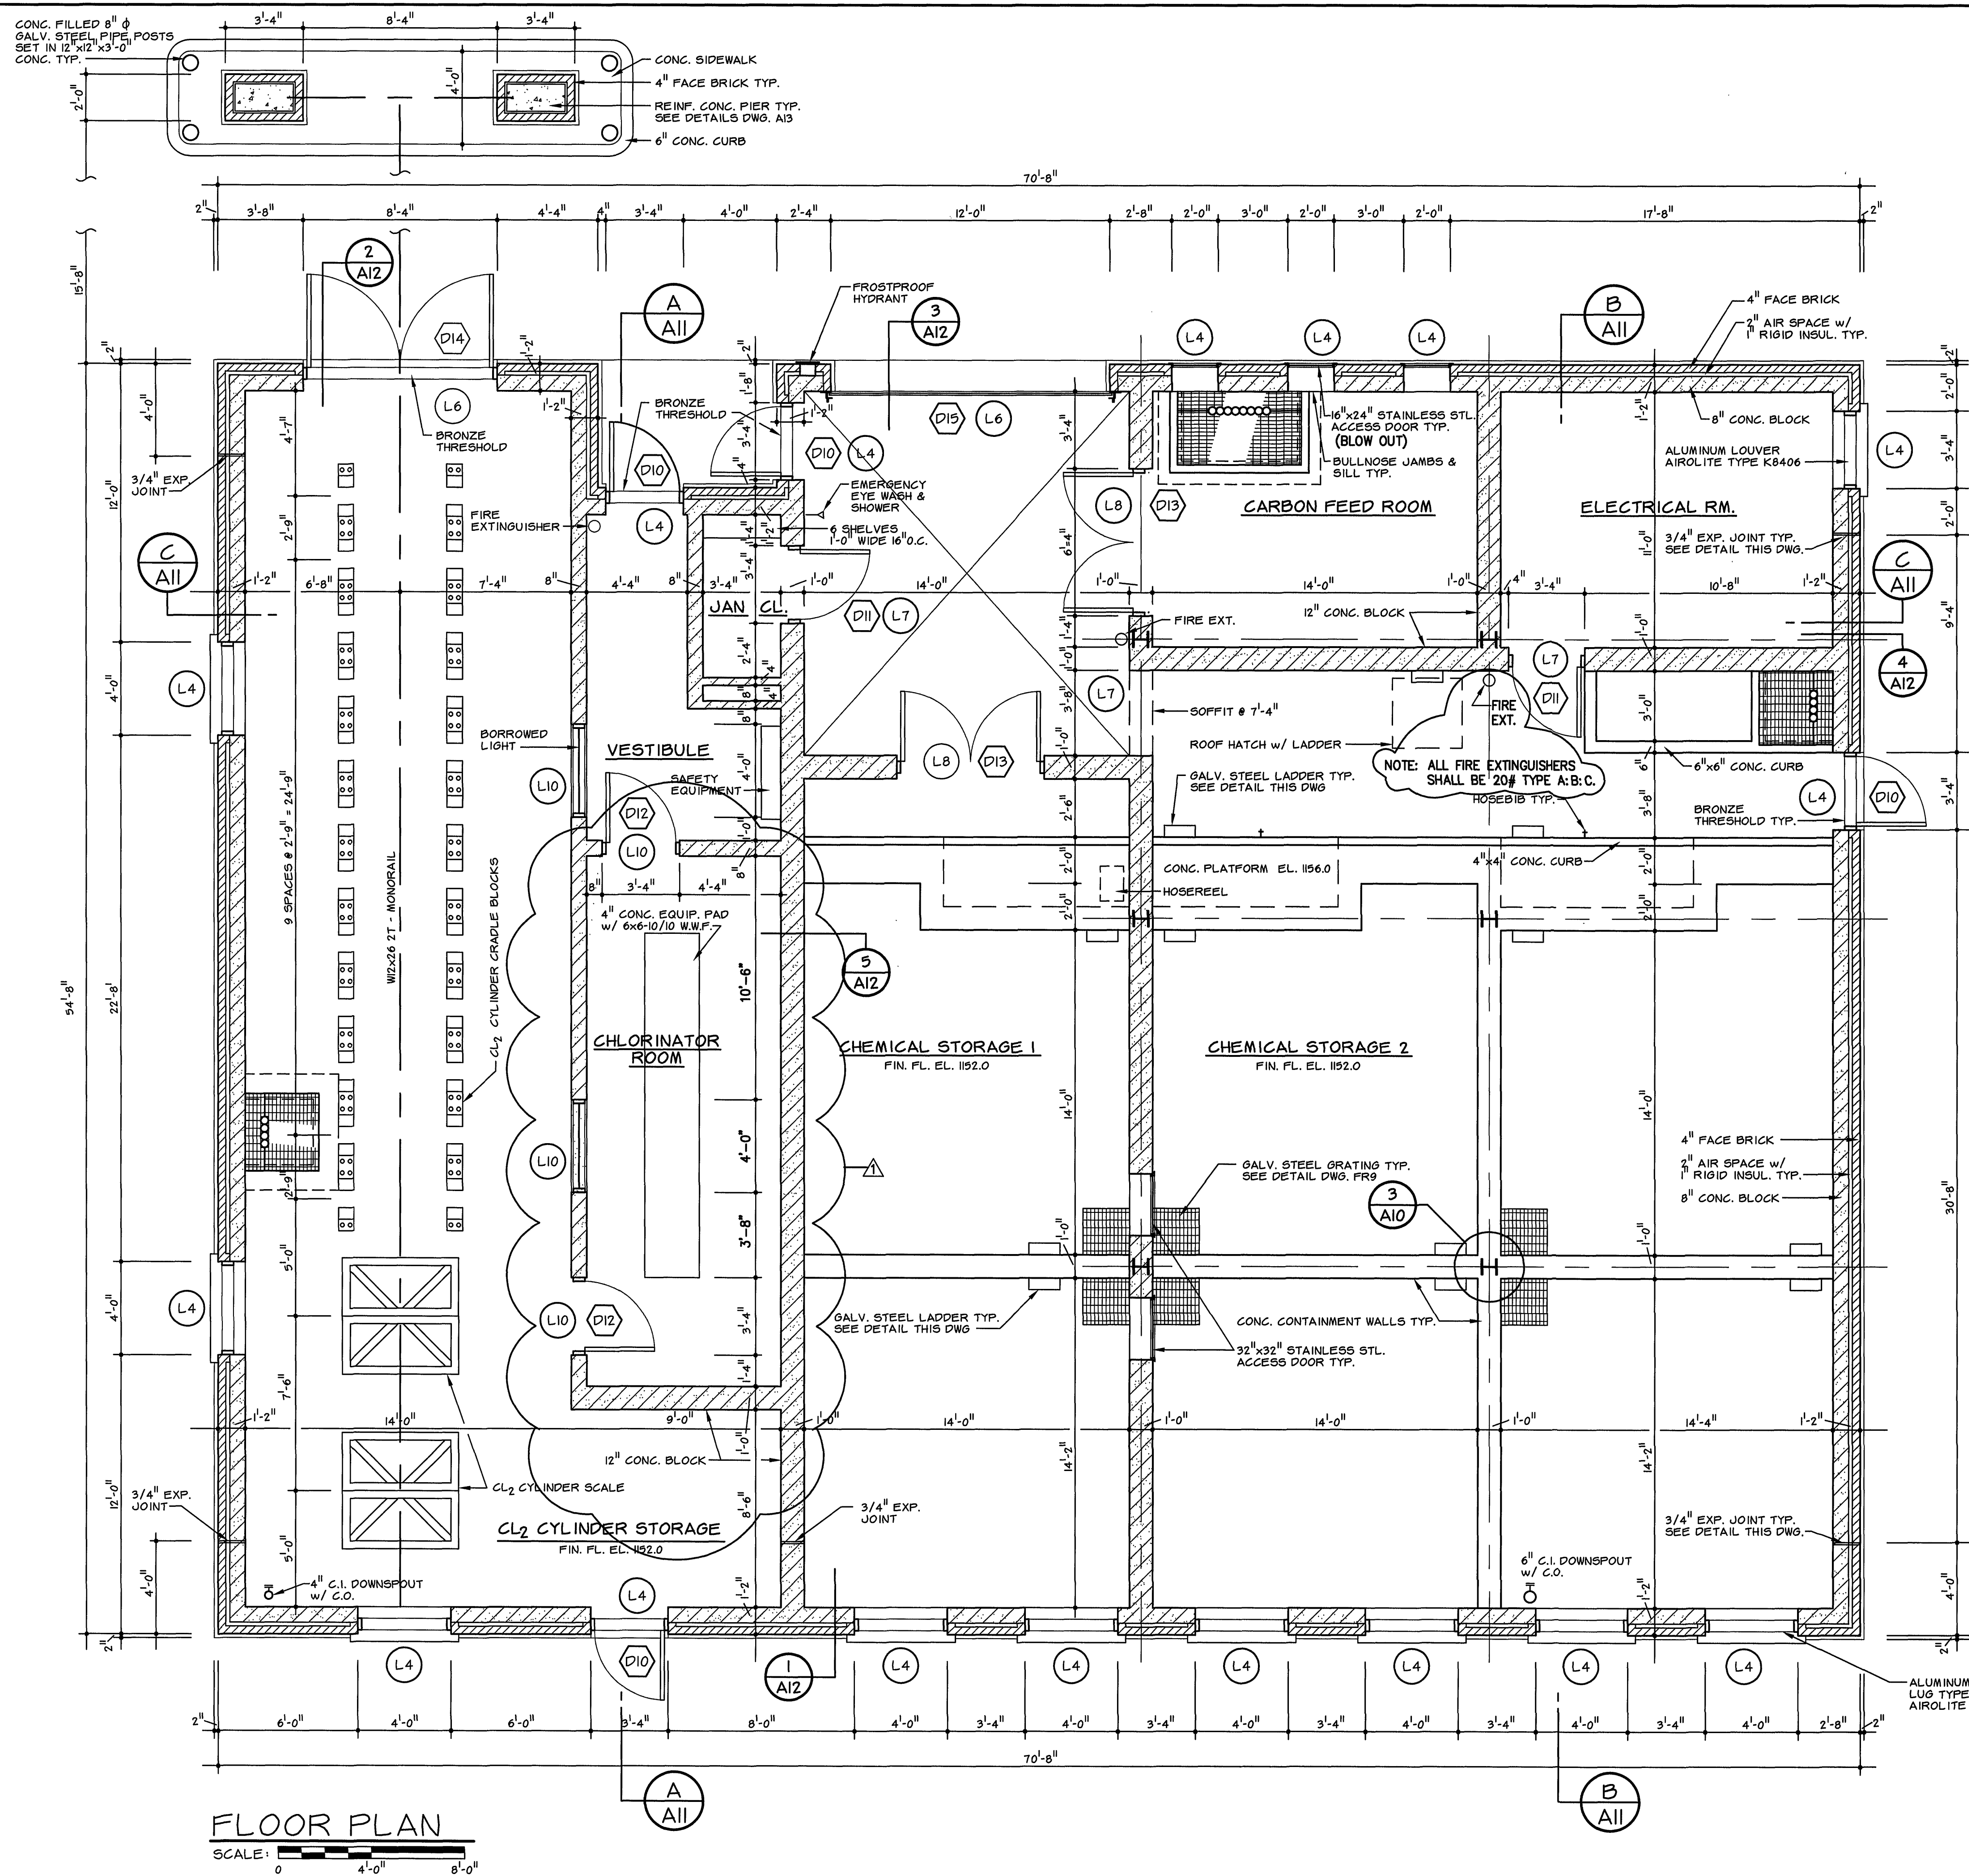


DRAWING OF RECORD
DATE: SEP 30 1997

MATTEN & CRAIG
CONSULTING ENGINEERS • SURVEYORS
ROANOKE VIRGINIA

ALVORD, BURDICK & HOWSON
ENGINEERS CHICAGO

DESIGNED:
DRAWN:
CHECKED:

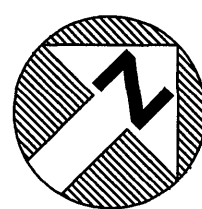

REV.	DATE	DESCRIPTION	BY	APP.
1	5/12/93	REVISED CHLORINATOR ROOM	DBY	

CARVINS COVE FILTER PLANT IMPROVEMENTS – PHASE I
ROANOKE, VIRGINIA

CHEMICAL BUILDING 1
FLOOR PLAN & DETAILS

DATE
APRIL 1992
COMM. NO.
9130
SHEET
A9