


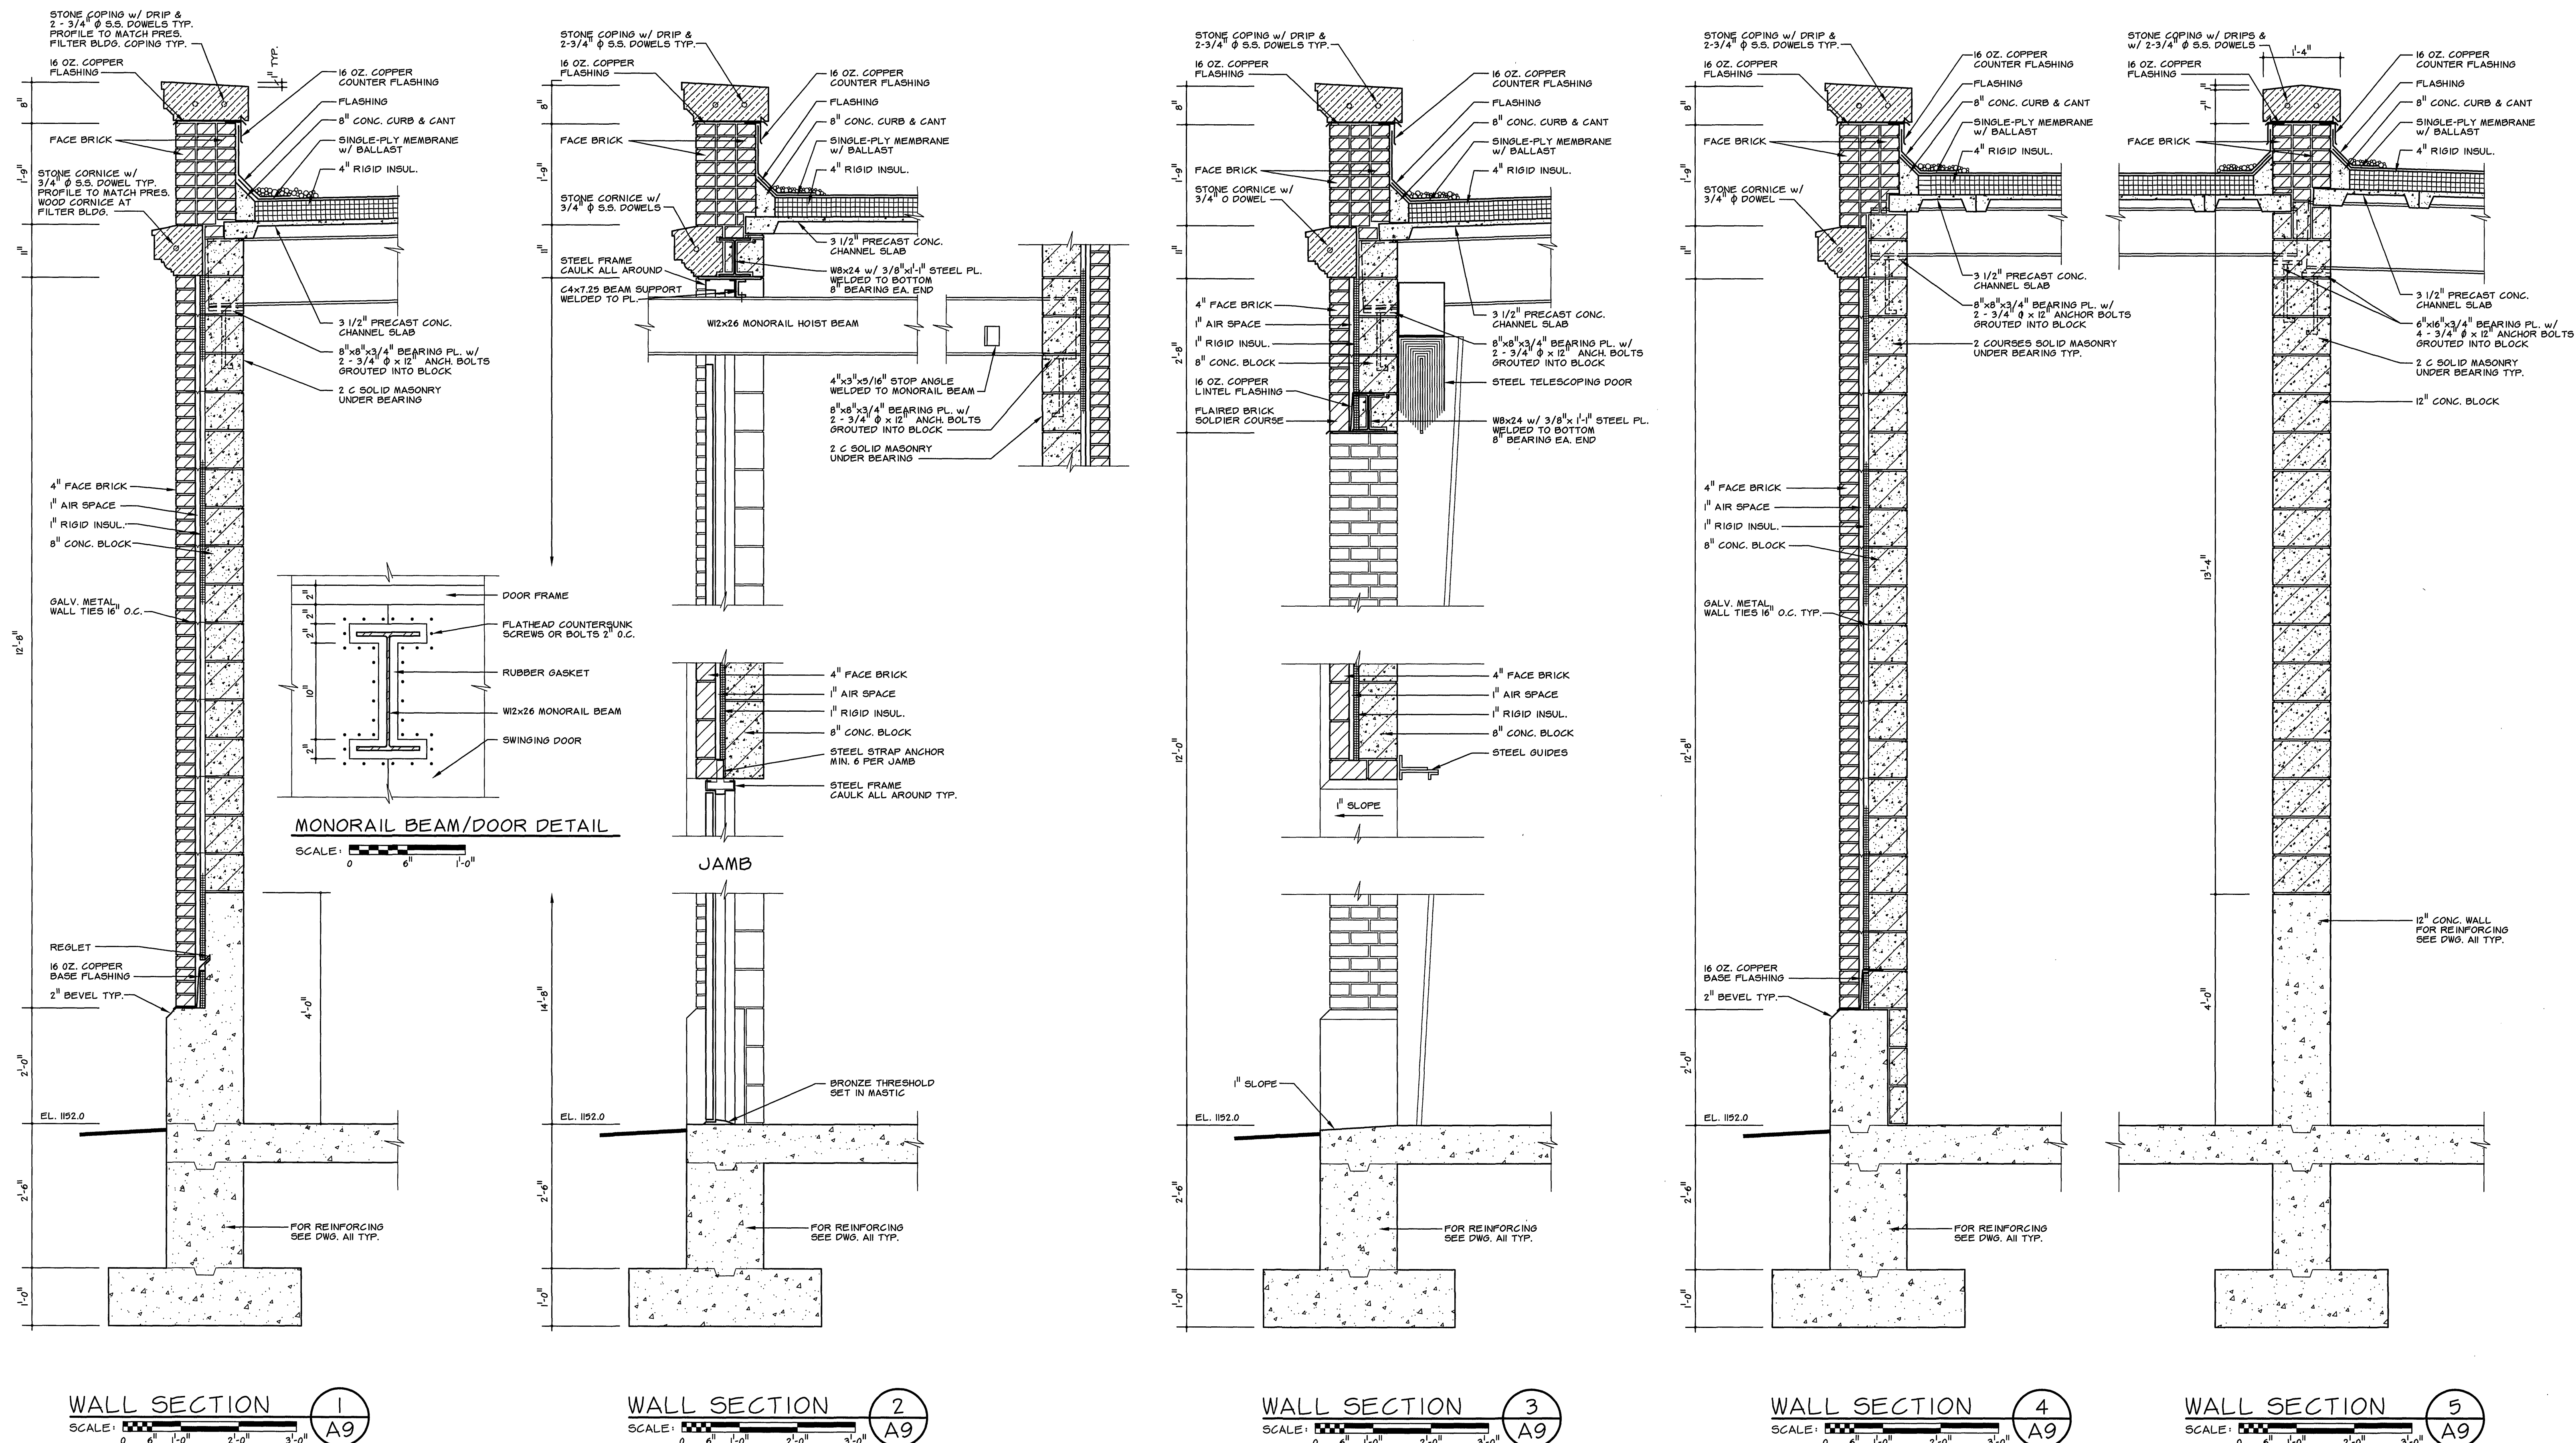

DRAWING OF RECORD
DATE: SEP 30 1997

MATTERN & CRAIG CONSULTING ENGINEERS • SURVEYORS ROANOKE VIRGINIA	DESIGNED:		REV.	DATE	DESCRIPTION	BY	APP.	CARVINS COVE FILTER PLANT IMPROVEMENTS – PHASE I ROANOKE, VIRGINIA	DATE APRIL 1992
	DRAWN:								
ALVORD, BURDICK & HOWSON ENGINEERS CHICAGO	CHECKED:								CHEMICAL BUILDING 1 WALL SECTIONS & DETAILS