


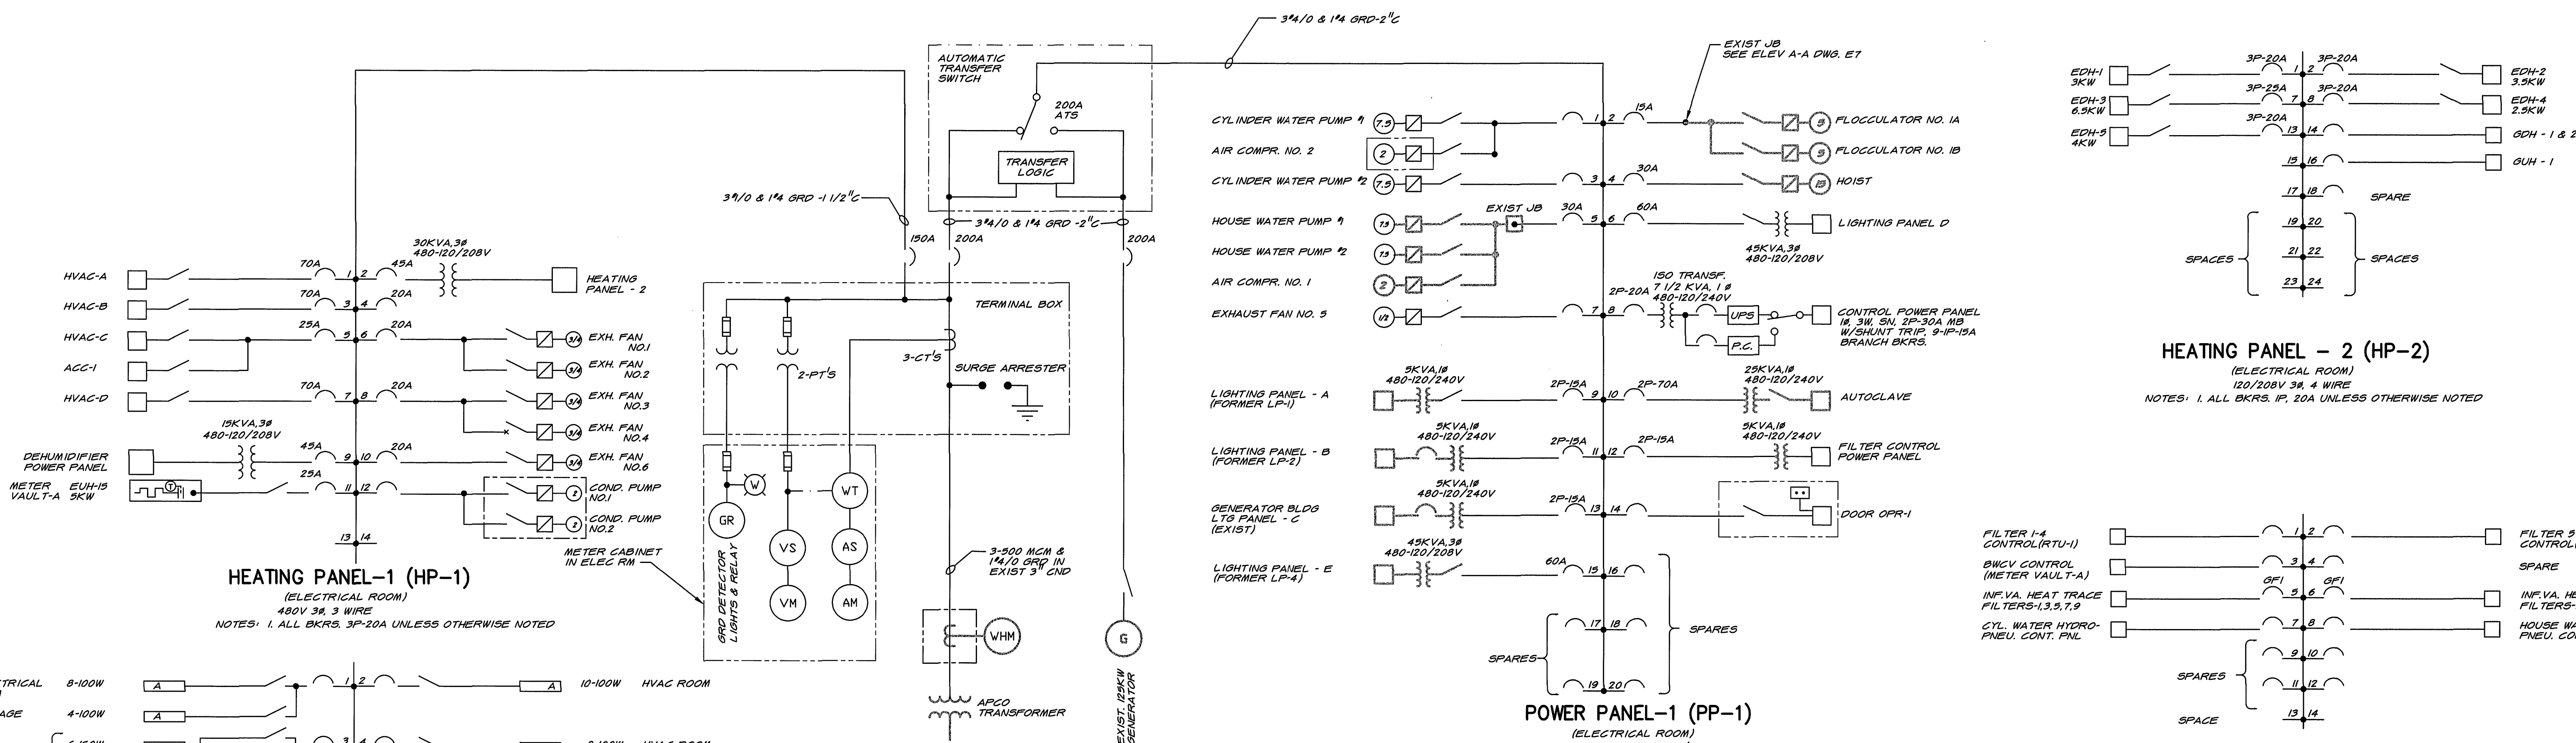

DRAWING OF RECORD
DATE: SEP 30 1997

NOTE:
PANELBOARDS, CIRCUIT BREAKERS
TRANSFORMERS AND OTHER EQUIPMENT
SHOWN IN LIGHTLY SHADED LINES ARE EXISTING.

MATTEN & CRAIG CONSULTING ENGINEERS • SURVEYORS ROANOKE VIRGINIA	DESIGNED: KCC/RRA		REV.	DATE	DESCRIPTION	BY	APP.	CARVINS COVE FILTER PLANT IMPROVEMENTS – PHASE I ROANOKE, VIRGINIA	DATE APRIL 1992
	DRAWN: KGP								
ALVORD, BURDICK & HOWSON ENGINEERS CHICAGO	CHECKED: RRA							ADMINISTRATION & FILTER BUILDING ELECTRICAL ONE LINE DIAGRAM	SHEET E2