


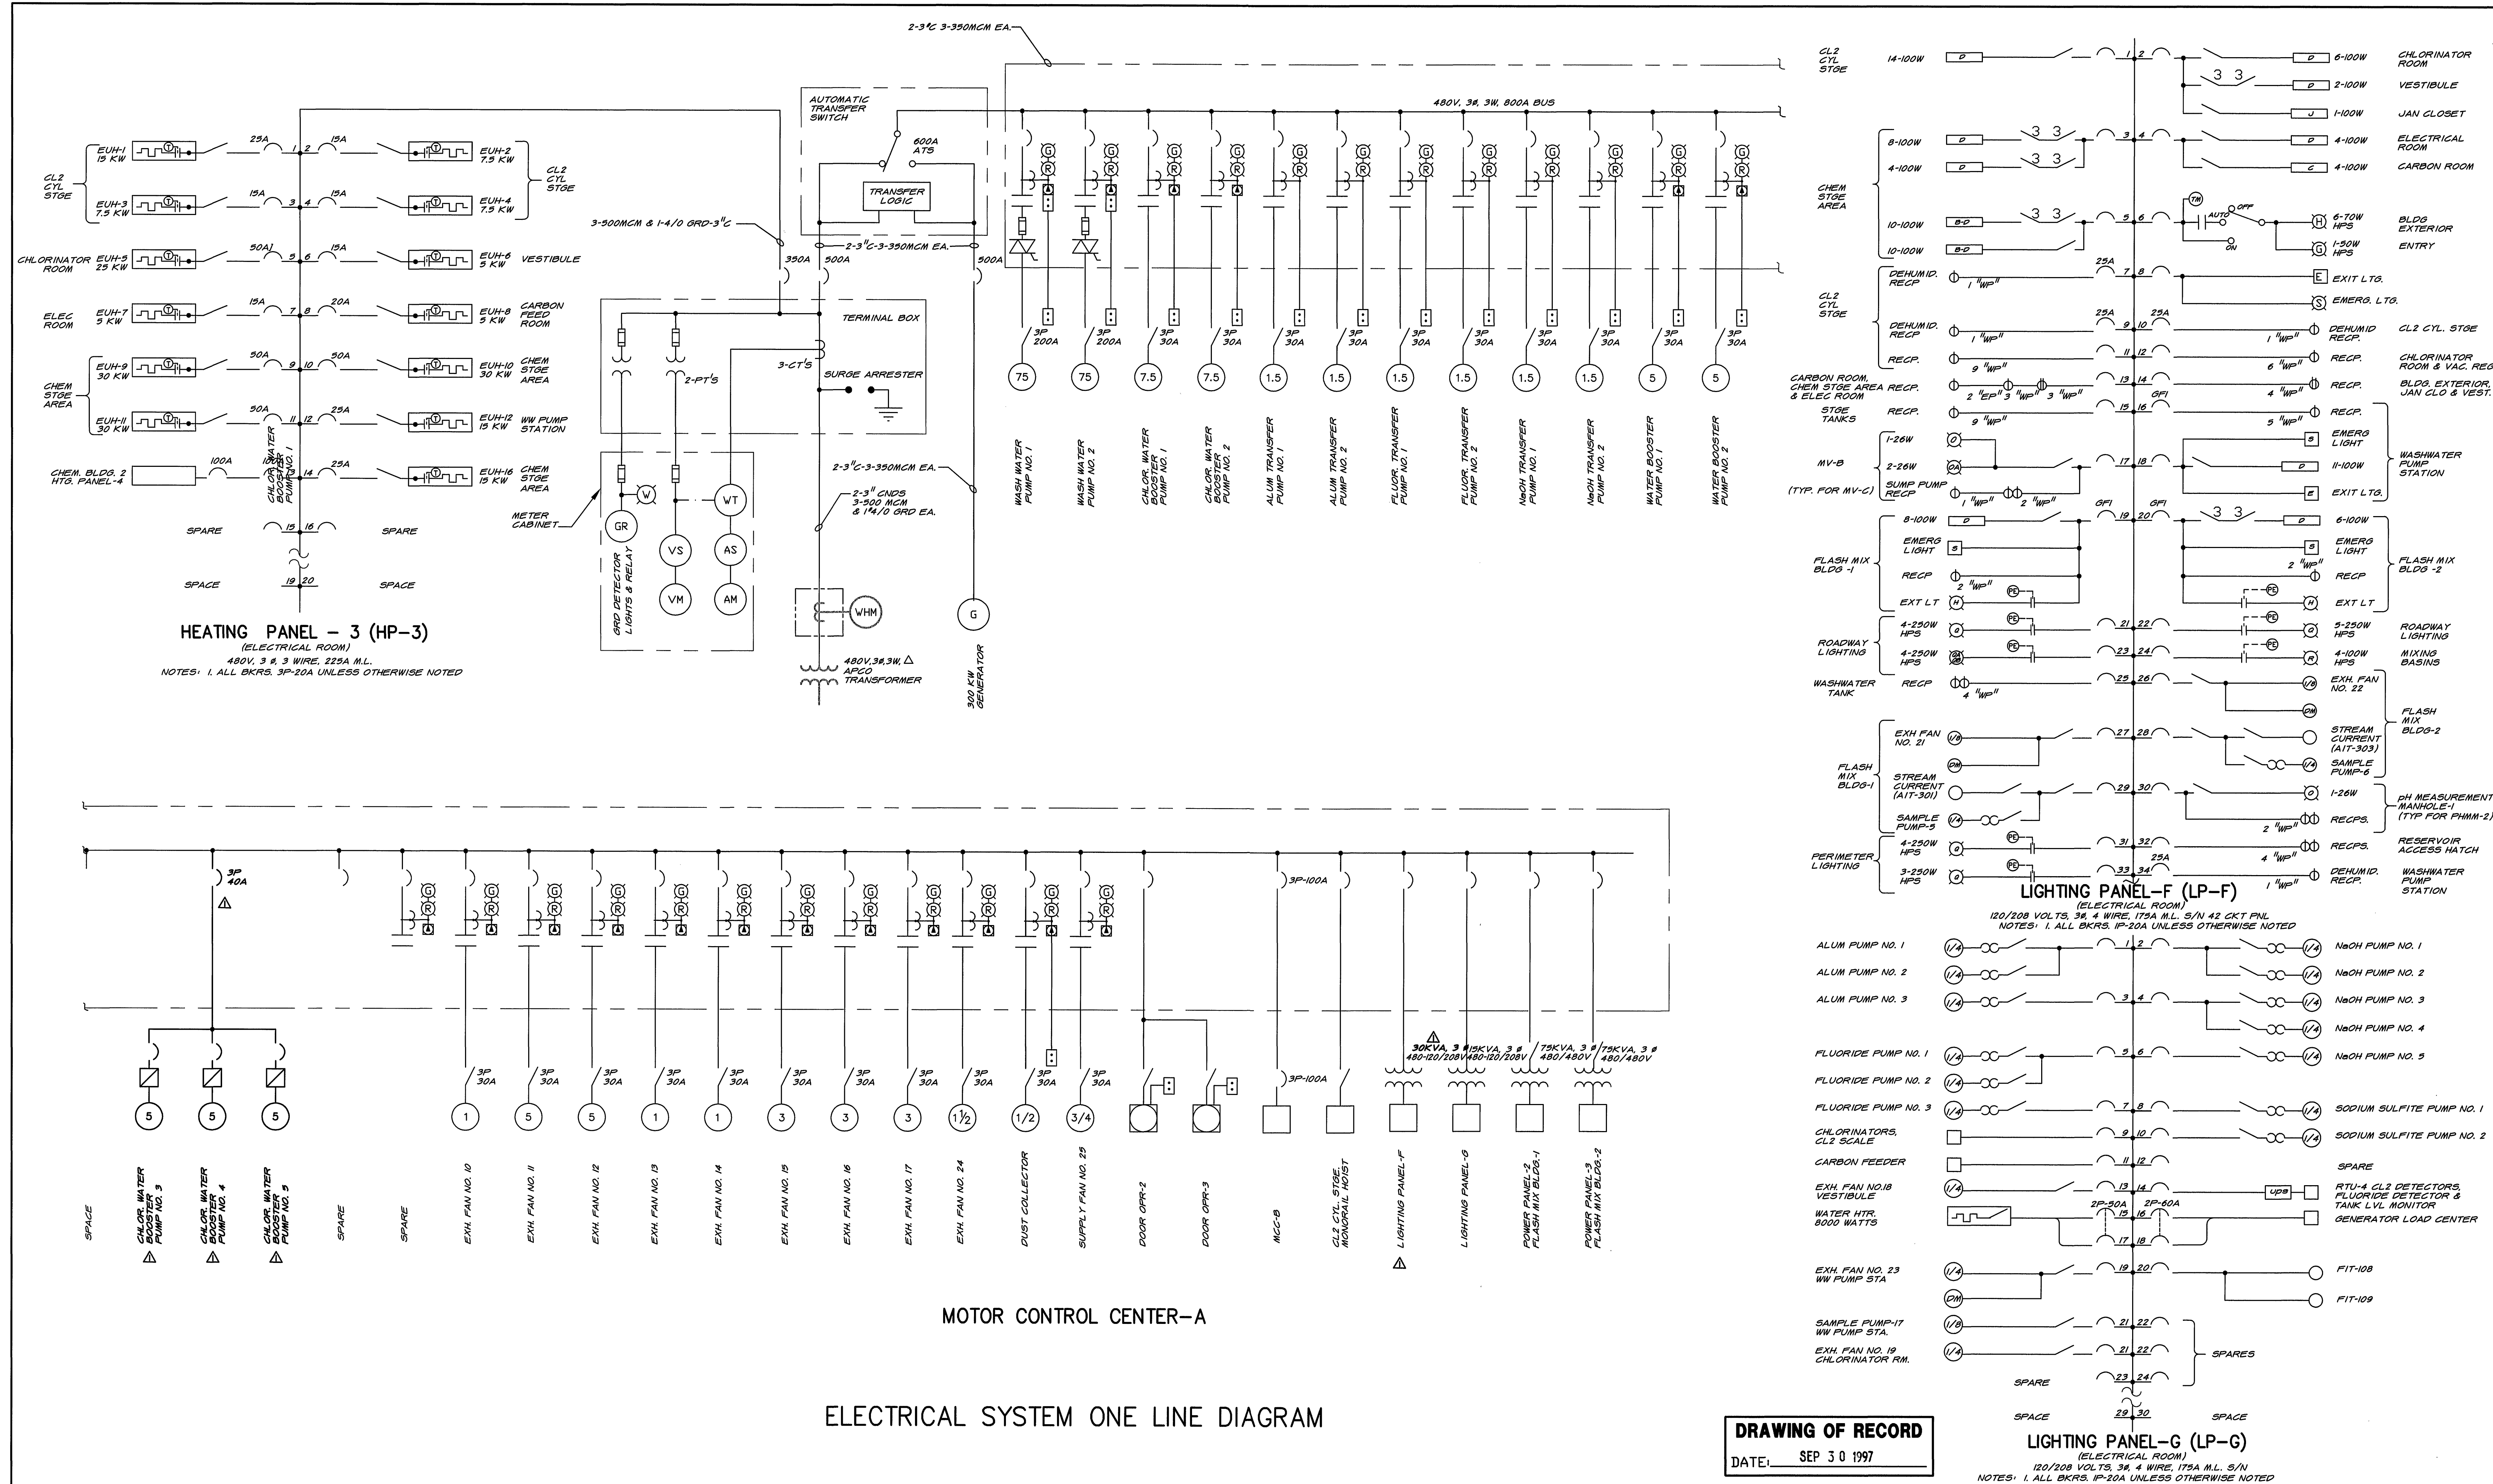

MATTEN & CRAIG CONSULTING ENGINEERS • SURVEYORS ROANOKE VIRGINIA		DESIGNED: KCC/RRR		REV.	DATE	DESCRIPTION	BY	APP.	CARVINS COVE FILTER PLANT IMPROVEMENTS – PHASE I ROANOKE, VIRGINIA		DATE APRIL 1992
ALVORD, BURDICK & HOWSON ENGINEERS CHICAGO		DRAWN: KGP		Δ	5-12-93	ADDED EQUIPMENT FOR PRECHLORINATION SYSTEM	KCC		CHEMICAL BUILDING 1 ELECTRICAL ONE LINE DIAGRAM		COMM. NO. 9130
		CHECKED: RRR									SHEET E3