




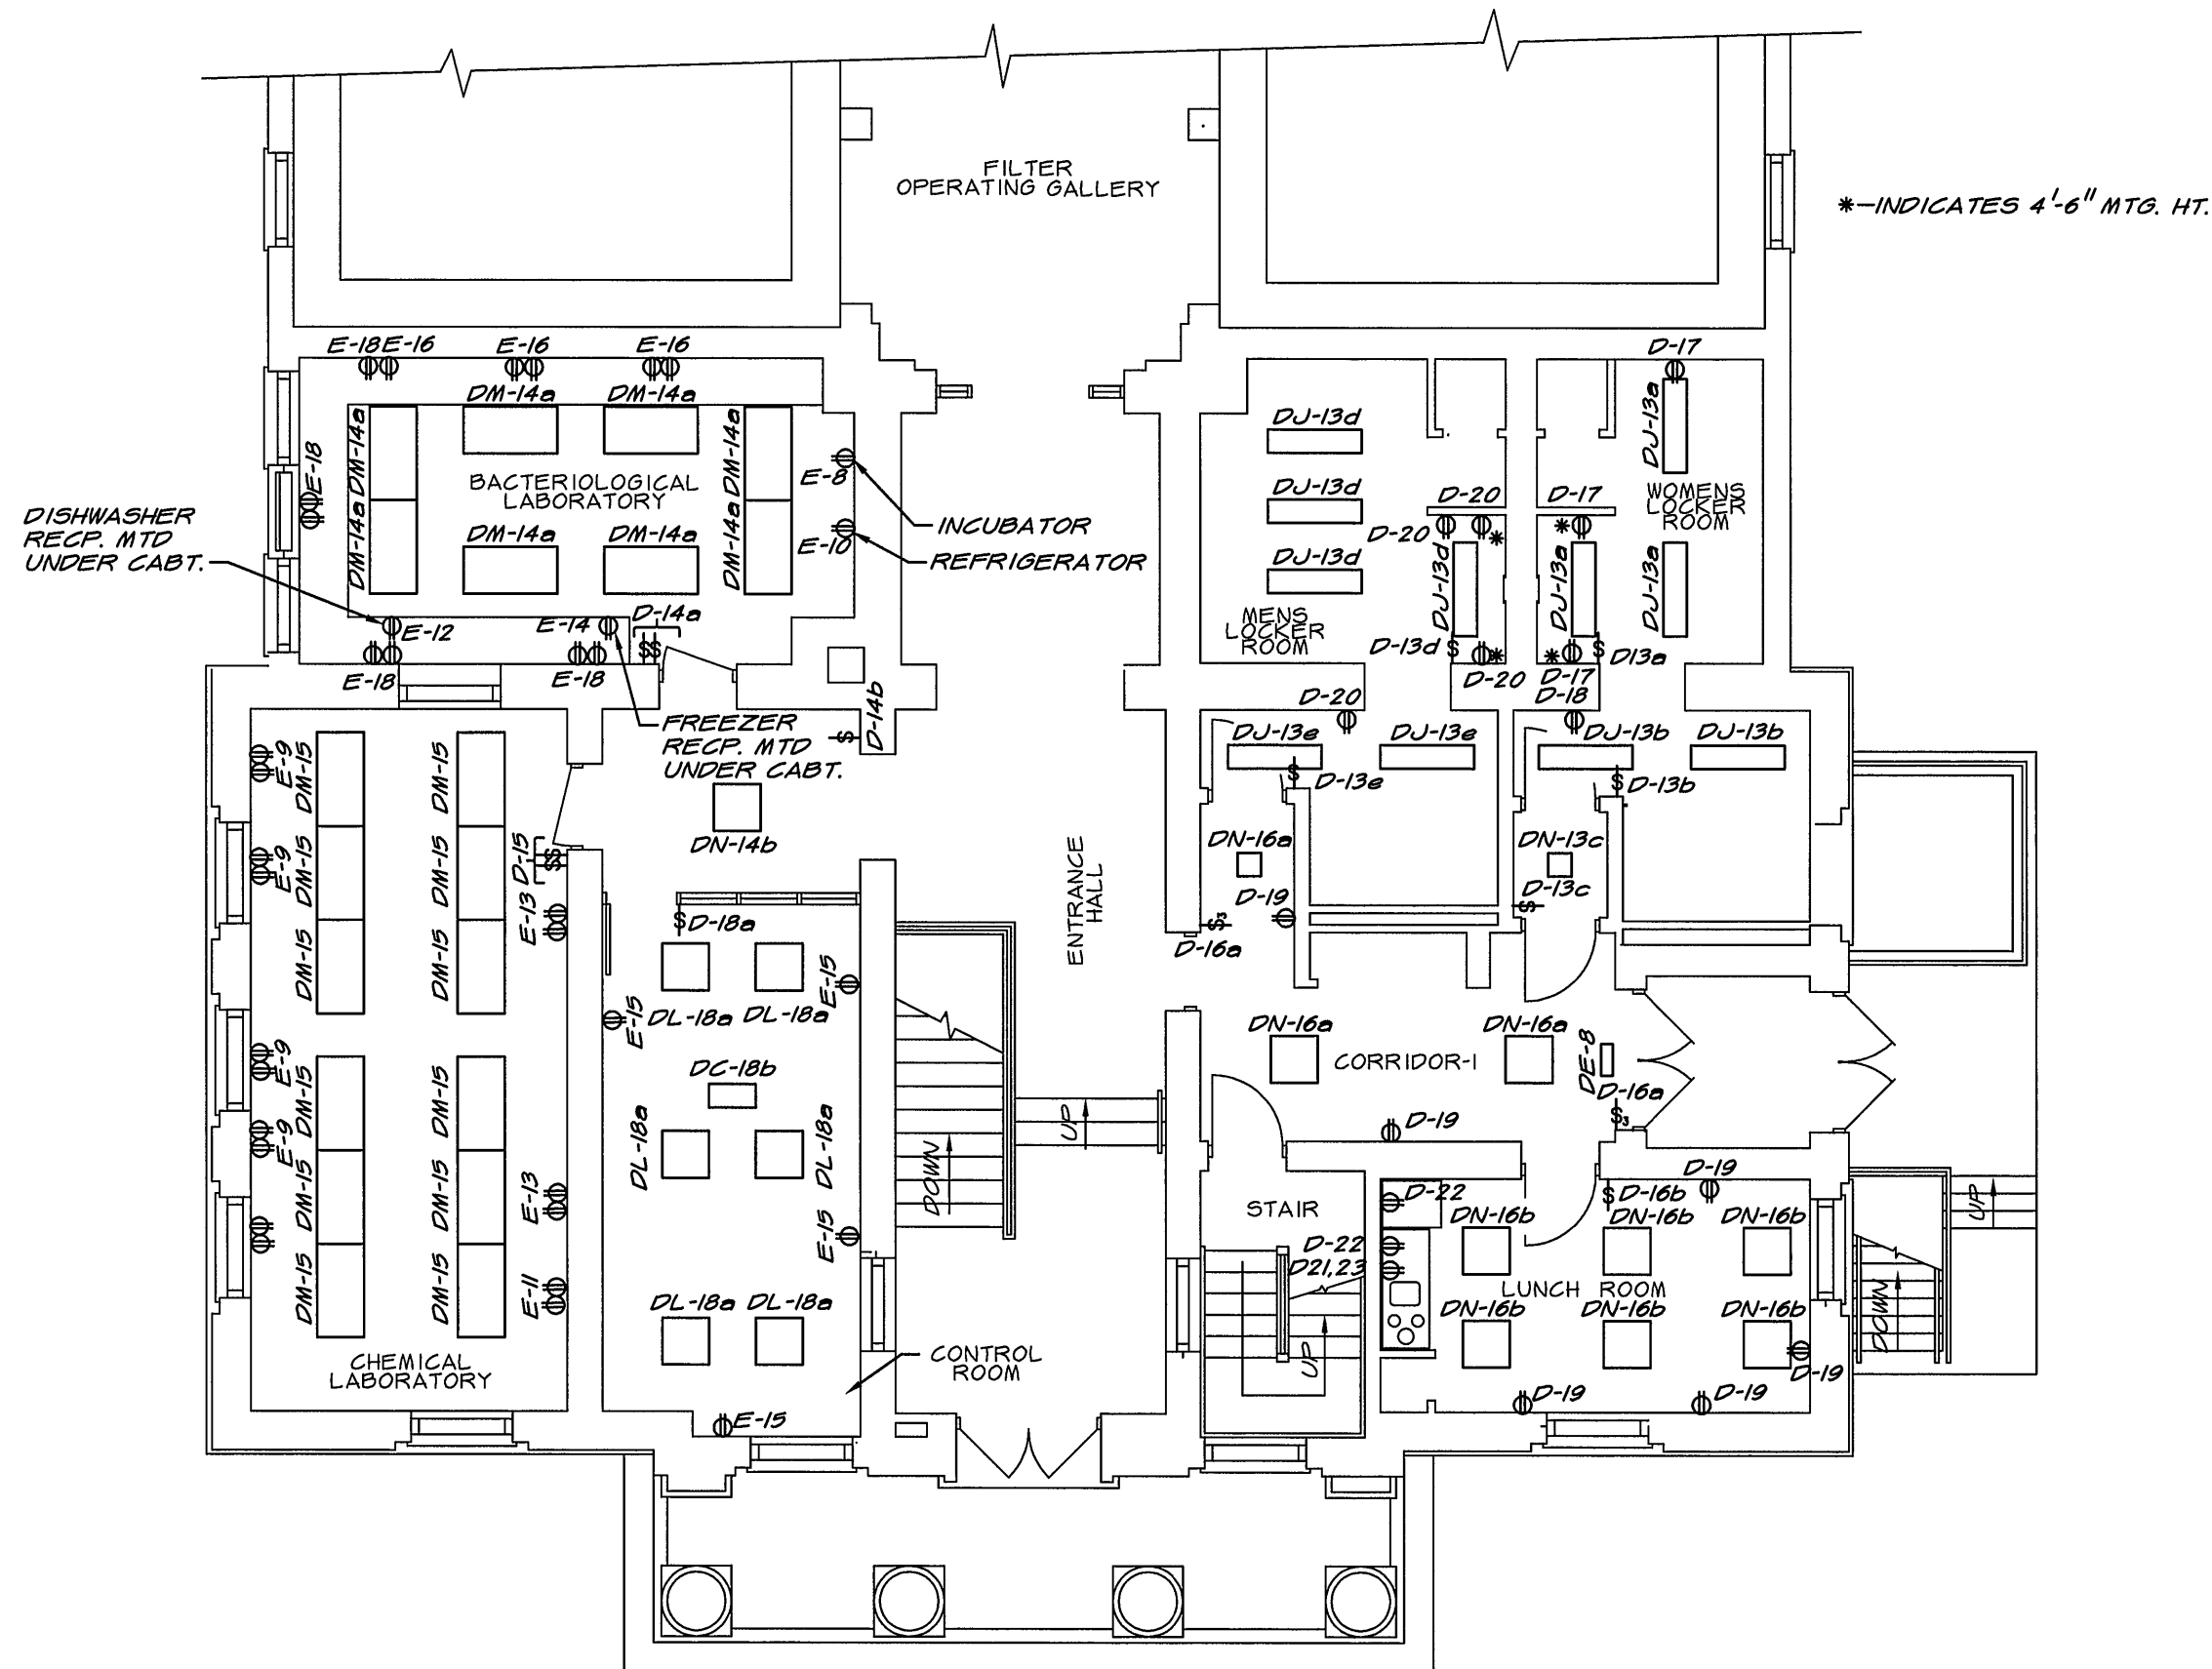

PLAN - MAIN FLOOR
SCALE OF DRAWING 1/8" = 1'-0"

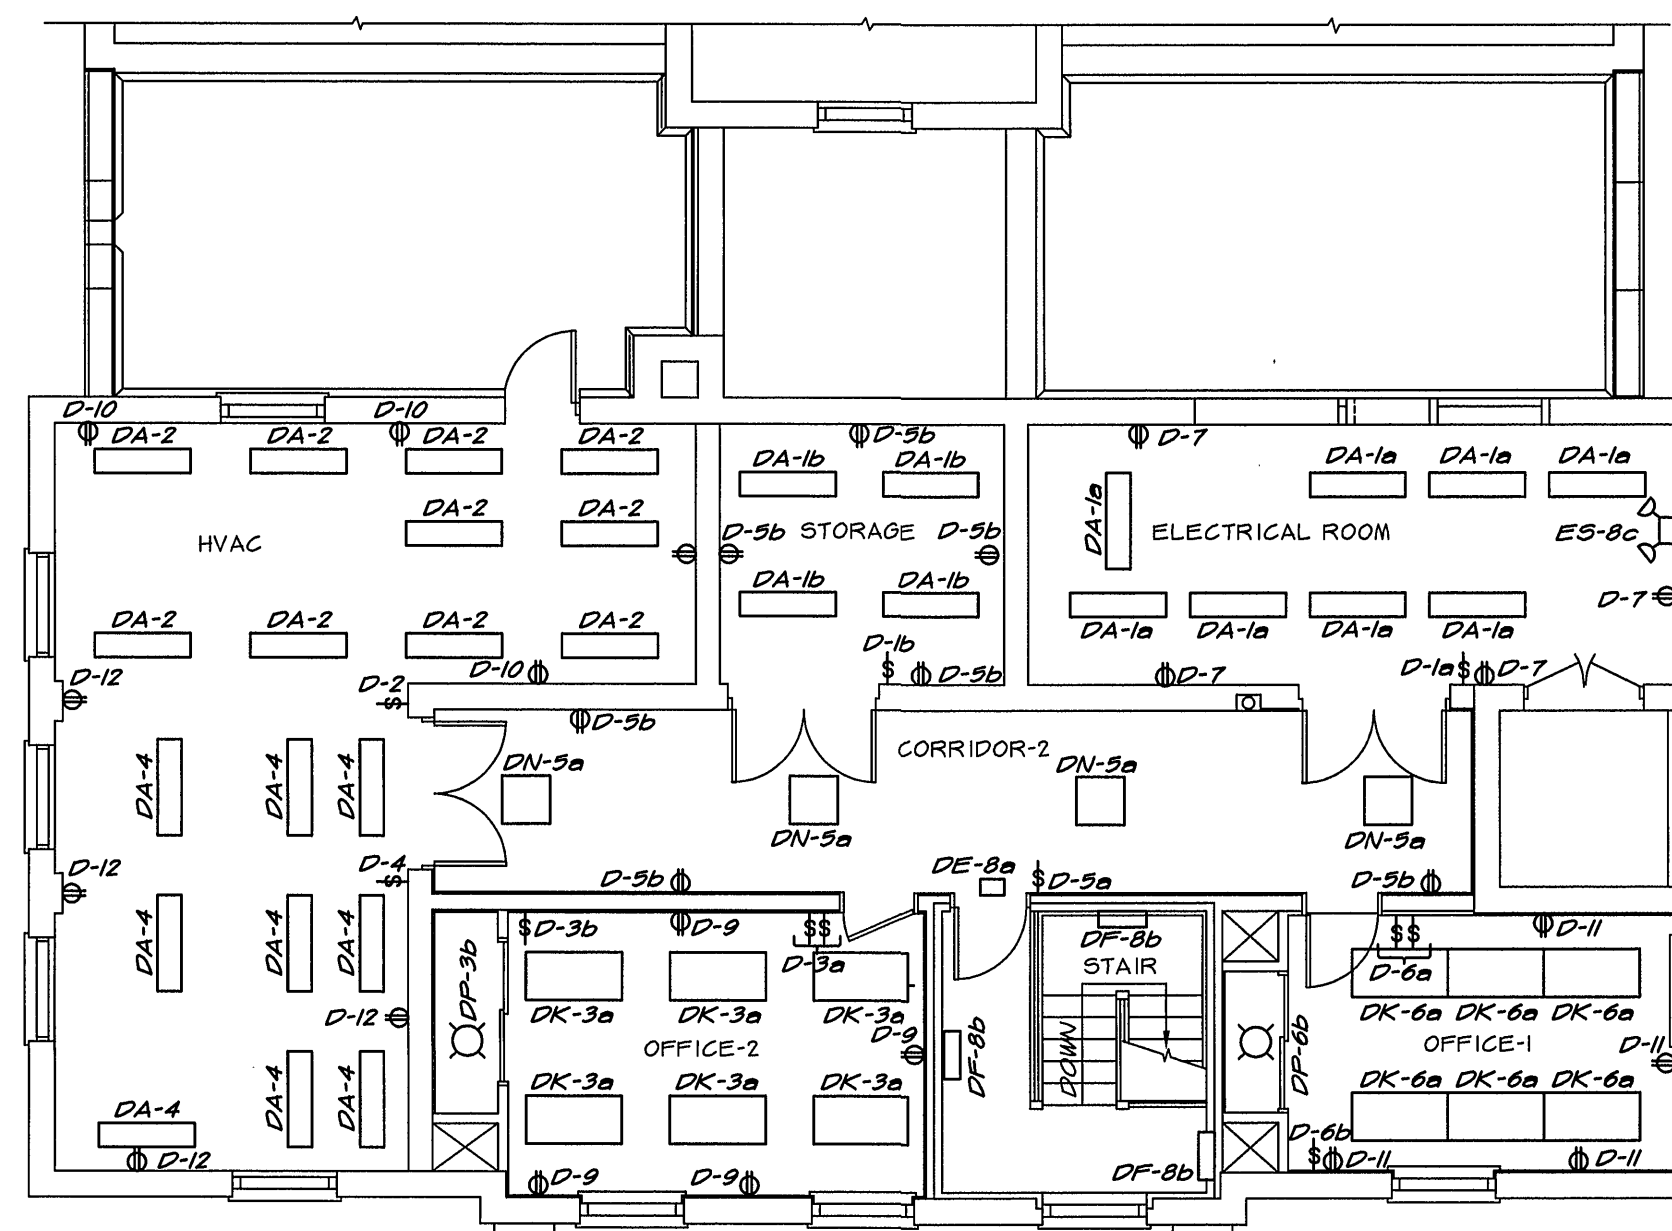

PLAN - SECOND FLOOR
SCALE OF DRAWING 1/8" = 1'-0"

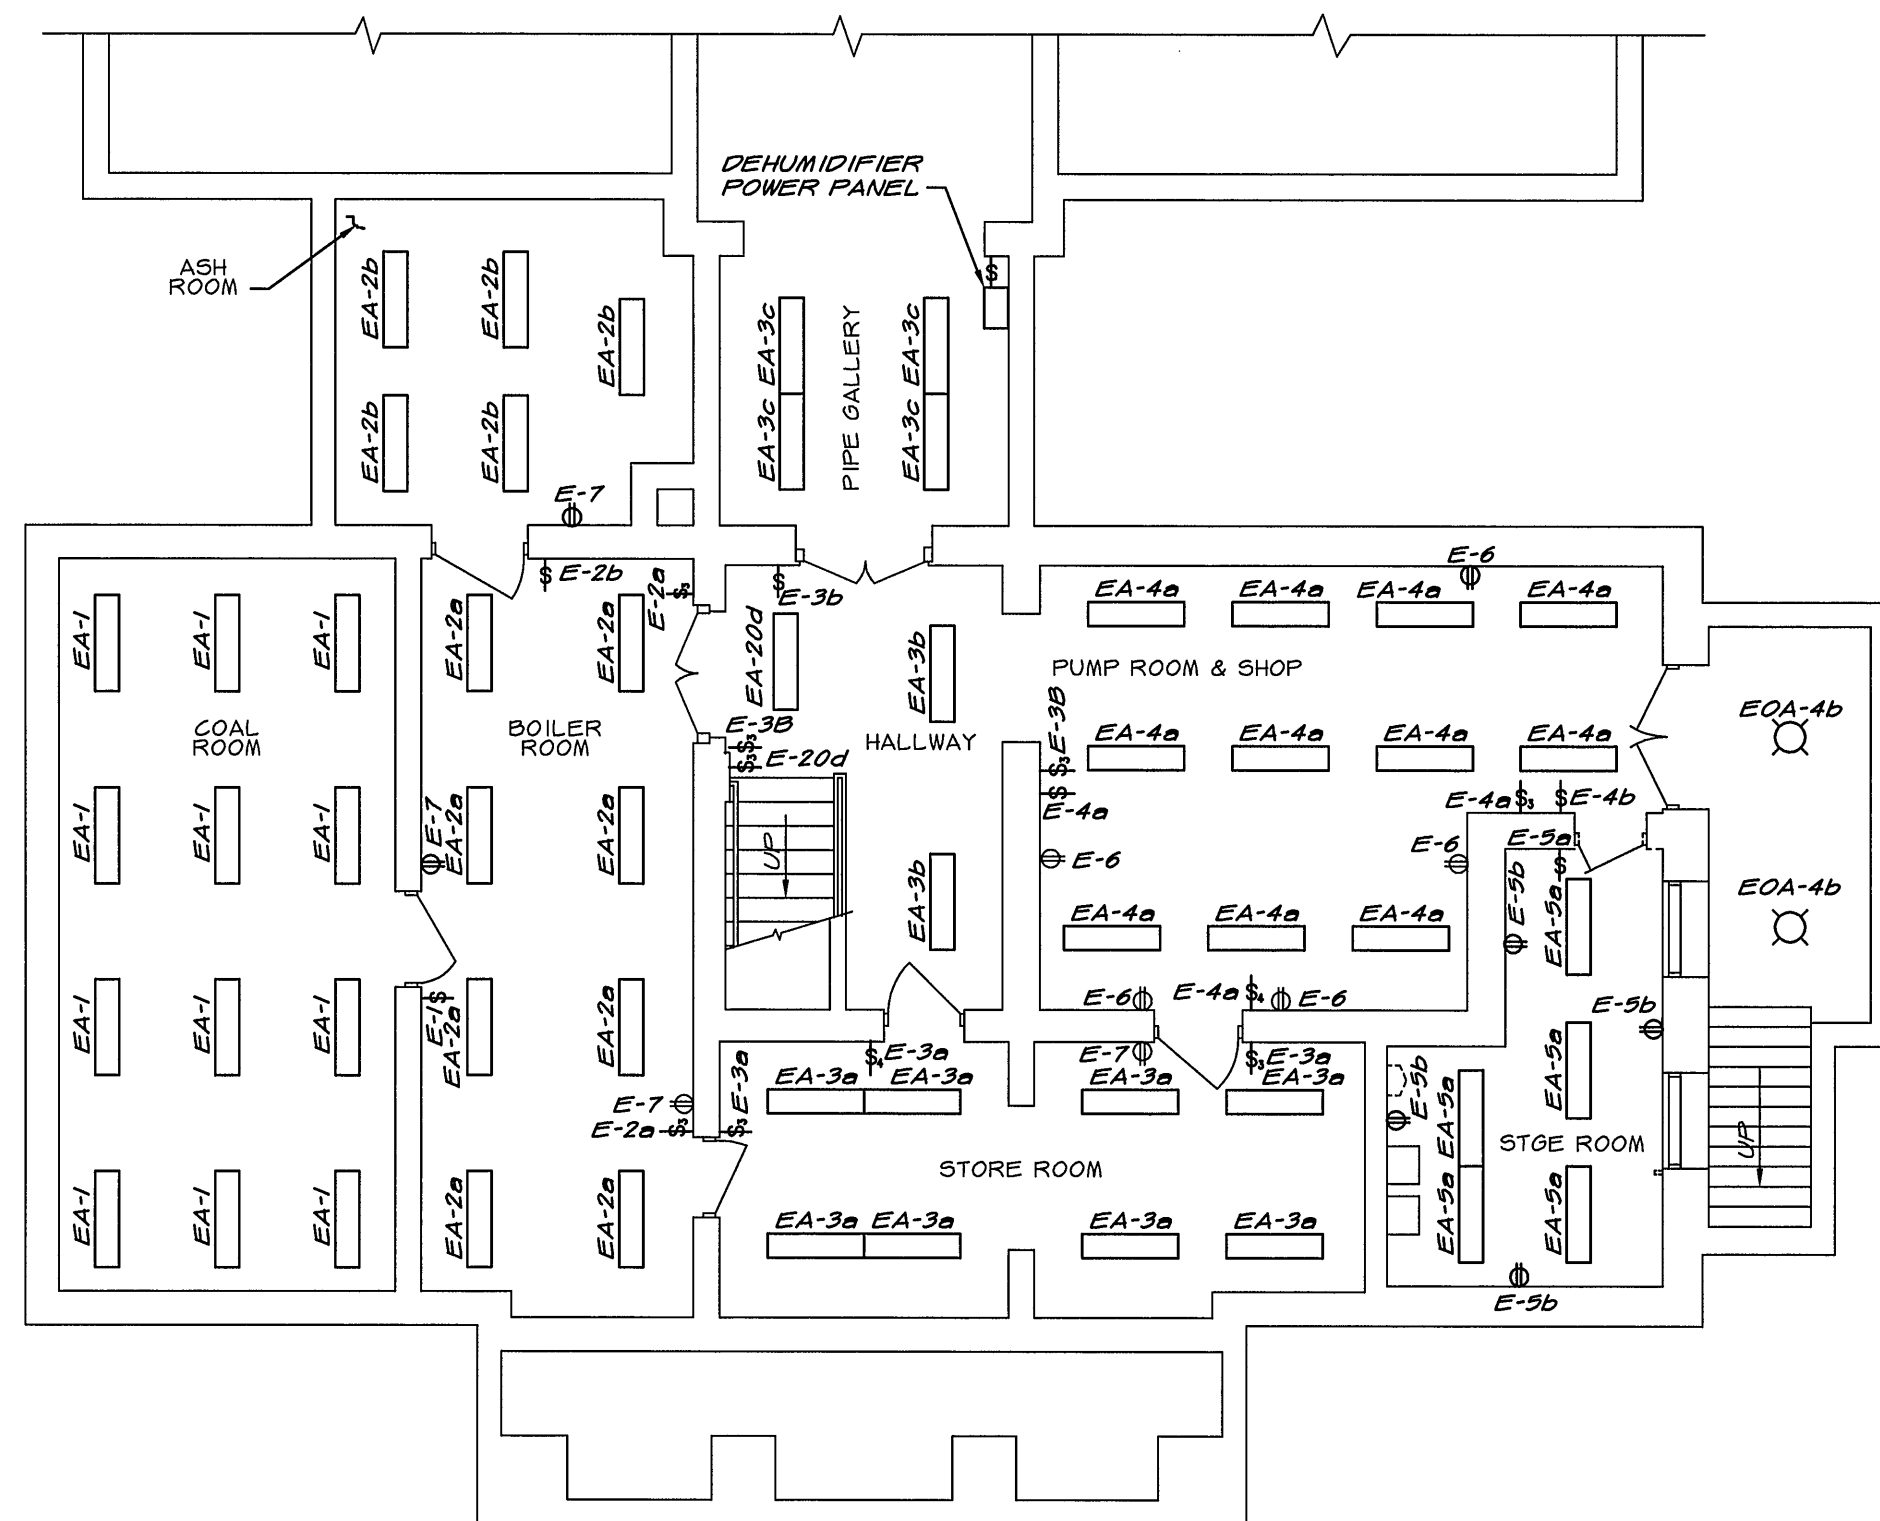

PLAN - BASEMENT
SCALE OF DRAWING 1/8" = 1'-0"

LIGHTING FIXTURE SCHEDULE

TYPE	LAMPS	MOUNTING	DESCRIPTION
A	2 F40CW/RS/EW-II	CEILING/ PENDANT	BENJAMIN ELEG. LITE-LINE FIXT. CAT. NO. FL-1024-4U
B	2 F40CW/RS/EW-II	SURFACE/ WALL	BENJAMIN ANGLE VAPOR TITE UNIT CORROSION RESISTANT CAT. NO. F22224-4
C	2-TW TUNGSTEN/HALOGEN	CEILING	CHLORIDE C-LING LITE FOR GRID CEILING W/NI-CAD BATTERY CAT. NO. CLB-N4-M5-2
D	2 F40CW/RS/EW-II	SURFACE/ WALL	DAYBRITE VAPORLUME WET LOCATION TYPE 4' FIXT. CAT. NO. VR2-4W
DA	2 F20T12/CW	SURFACE/ WALL	DAYBRITE VAPORLUME WET LOCATION TYPE 2' FIXT. CAT. NO. VT2-2W
E	2 FT6	WALL/ CEILING	CHLORIDE REFERENCE SERIES, SELF POWERED FLUOR. EXIT SIGN, RED LETTERS, DARK BRONZE FINISH & NI-CAD BATTERY
F	1 F20T12/CW	WALL	HOLOPHANE LENSARE EMERGENCY LIGHT SECURITY VERSION, CAT. NO. EC-24-FR15H
G	1 T0W/HPS/B-17	RECESSED	MCPHILBIN 4A LINE RECESSED SQUARE DOWNLIGHT W/PLAT. CONTROL LENS CAT. NO. 4A-3262F-MB
H	1 T0W/HPS/B-17	WALL	MCPHILBIN 6 LINE WALL MTD DOWNLIGHT CAT. NO. 6W-2864-MB-TI
J	2 F49CW/RS/EW-II	RECESSED	COLUMBIA 5000+ SERIES, 1'X4' FIXT. W/PLASTER FRAME CAT. NO. 5F566F-32-142
K	3 F40CW/RS/EW-II	RECESSED	LITHONIA OPTIMAX PARABOLIC 2'X4' FIXT. CAT. NO. 2FMO-G-B-3-40-2TL5-120-ES
L	3 F8031/T8	RECESSED	LITHONIA OPTIMAX PARABOLIC 2'X2' FIXT. CAT. NO. 2FMO-G-B-3U3H-12LS-120-EU
M	3 F40CW/RS/EW-II	RECESSED	COLUMBIA 5000+ SERIES 2'X4' FIXT. CAT. NO. 5F566-32-243
N	2 F840CW/6	RECESSED	COLUMBIA 5000+ SERIES 2'X2' FIXT. CAT. NO. 5F566-32-142
O	2 PL-13	WALL	RUUD WALL DOWNLIGHT CUTOFF CAT. NO. E4226-1 AND SURFACE MOUNTING BOX ESB-7
OA	2 PL-13	WALL	RUUD TRANSLUCENT LENS CAT. NO. E1226-1 AND SURFACE MOUNTING BOX ESB-7
P	1 32W. CIRCLELINE	CEILING	LIGHTOLIER LUMIDISC CAT. NO. 6791
Q	1 250W/HPS	ROUND POLE	KIM ARCHETYPE AR MODEL, POLE MTD, LTS, FIXT. CAT. NO. 1A-AR3-250HPS120-DBP MTD ON A 25' ROUND STL NON TAPERED POLE TYPE PRS
QA	1 250W/HPS	ROUND POLE	KIM ARCHETYPE AR MODEL, POLE MTD, LTS, FIXT. CAT. NO. 1A-AR4-250HPS120-DBP MTD ON A 25' ROUND STL NON TAPERED POLE TYPE PRS
QB	1 250W/HPS	ROUND POLE	KIM ARCHETYPE AR MODEL, POLE MTD, LTS, FIXT. CAT. NO. 1A-AR5-250HPS120-DBP MTD ON A 25' ROUND STL NON TAPERED POLE TYPE PRS
R	1 100W/HPS	ROUND POLE	KIM OUTDOOR TUBE SYSTEM MTD ON 12' POLE CAT. NO. 1A-OTS600-100HPS120-CB-E-FBTS12-6188
S	2 PAR-36/18W INC.	WALL	HOLOPHANE GASKETED INDUSTRIAL EMERGENCY LIGHT CAT. NO. EH-12-2A


DRAWING OF RECORD
DATE: SEP 30 1997

MATTERN & CRAIG
CONSULTING ENGINEERS • SURVEYORS
ROANOKE VIRGINIA

DESIGNED: RRA

DRAWN: KGP

CHECKED: RRA

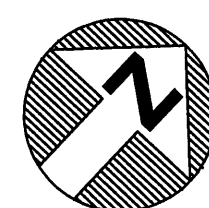

REV.	DATE	DESCRIPTION	BY	APP.

CARVINS COVE FILTER PLANT IMPROVEMENTS - PHASE I

ROANOKE, VIRGINIA

ADMINISTRATION BUILDING
LIGHTING PLANS

DATE
APRIL 1992
COMM. NO.
9130
SHEET
E8