


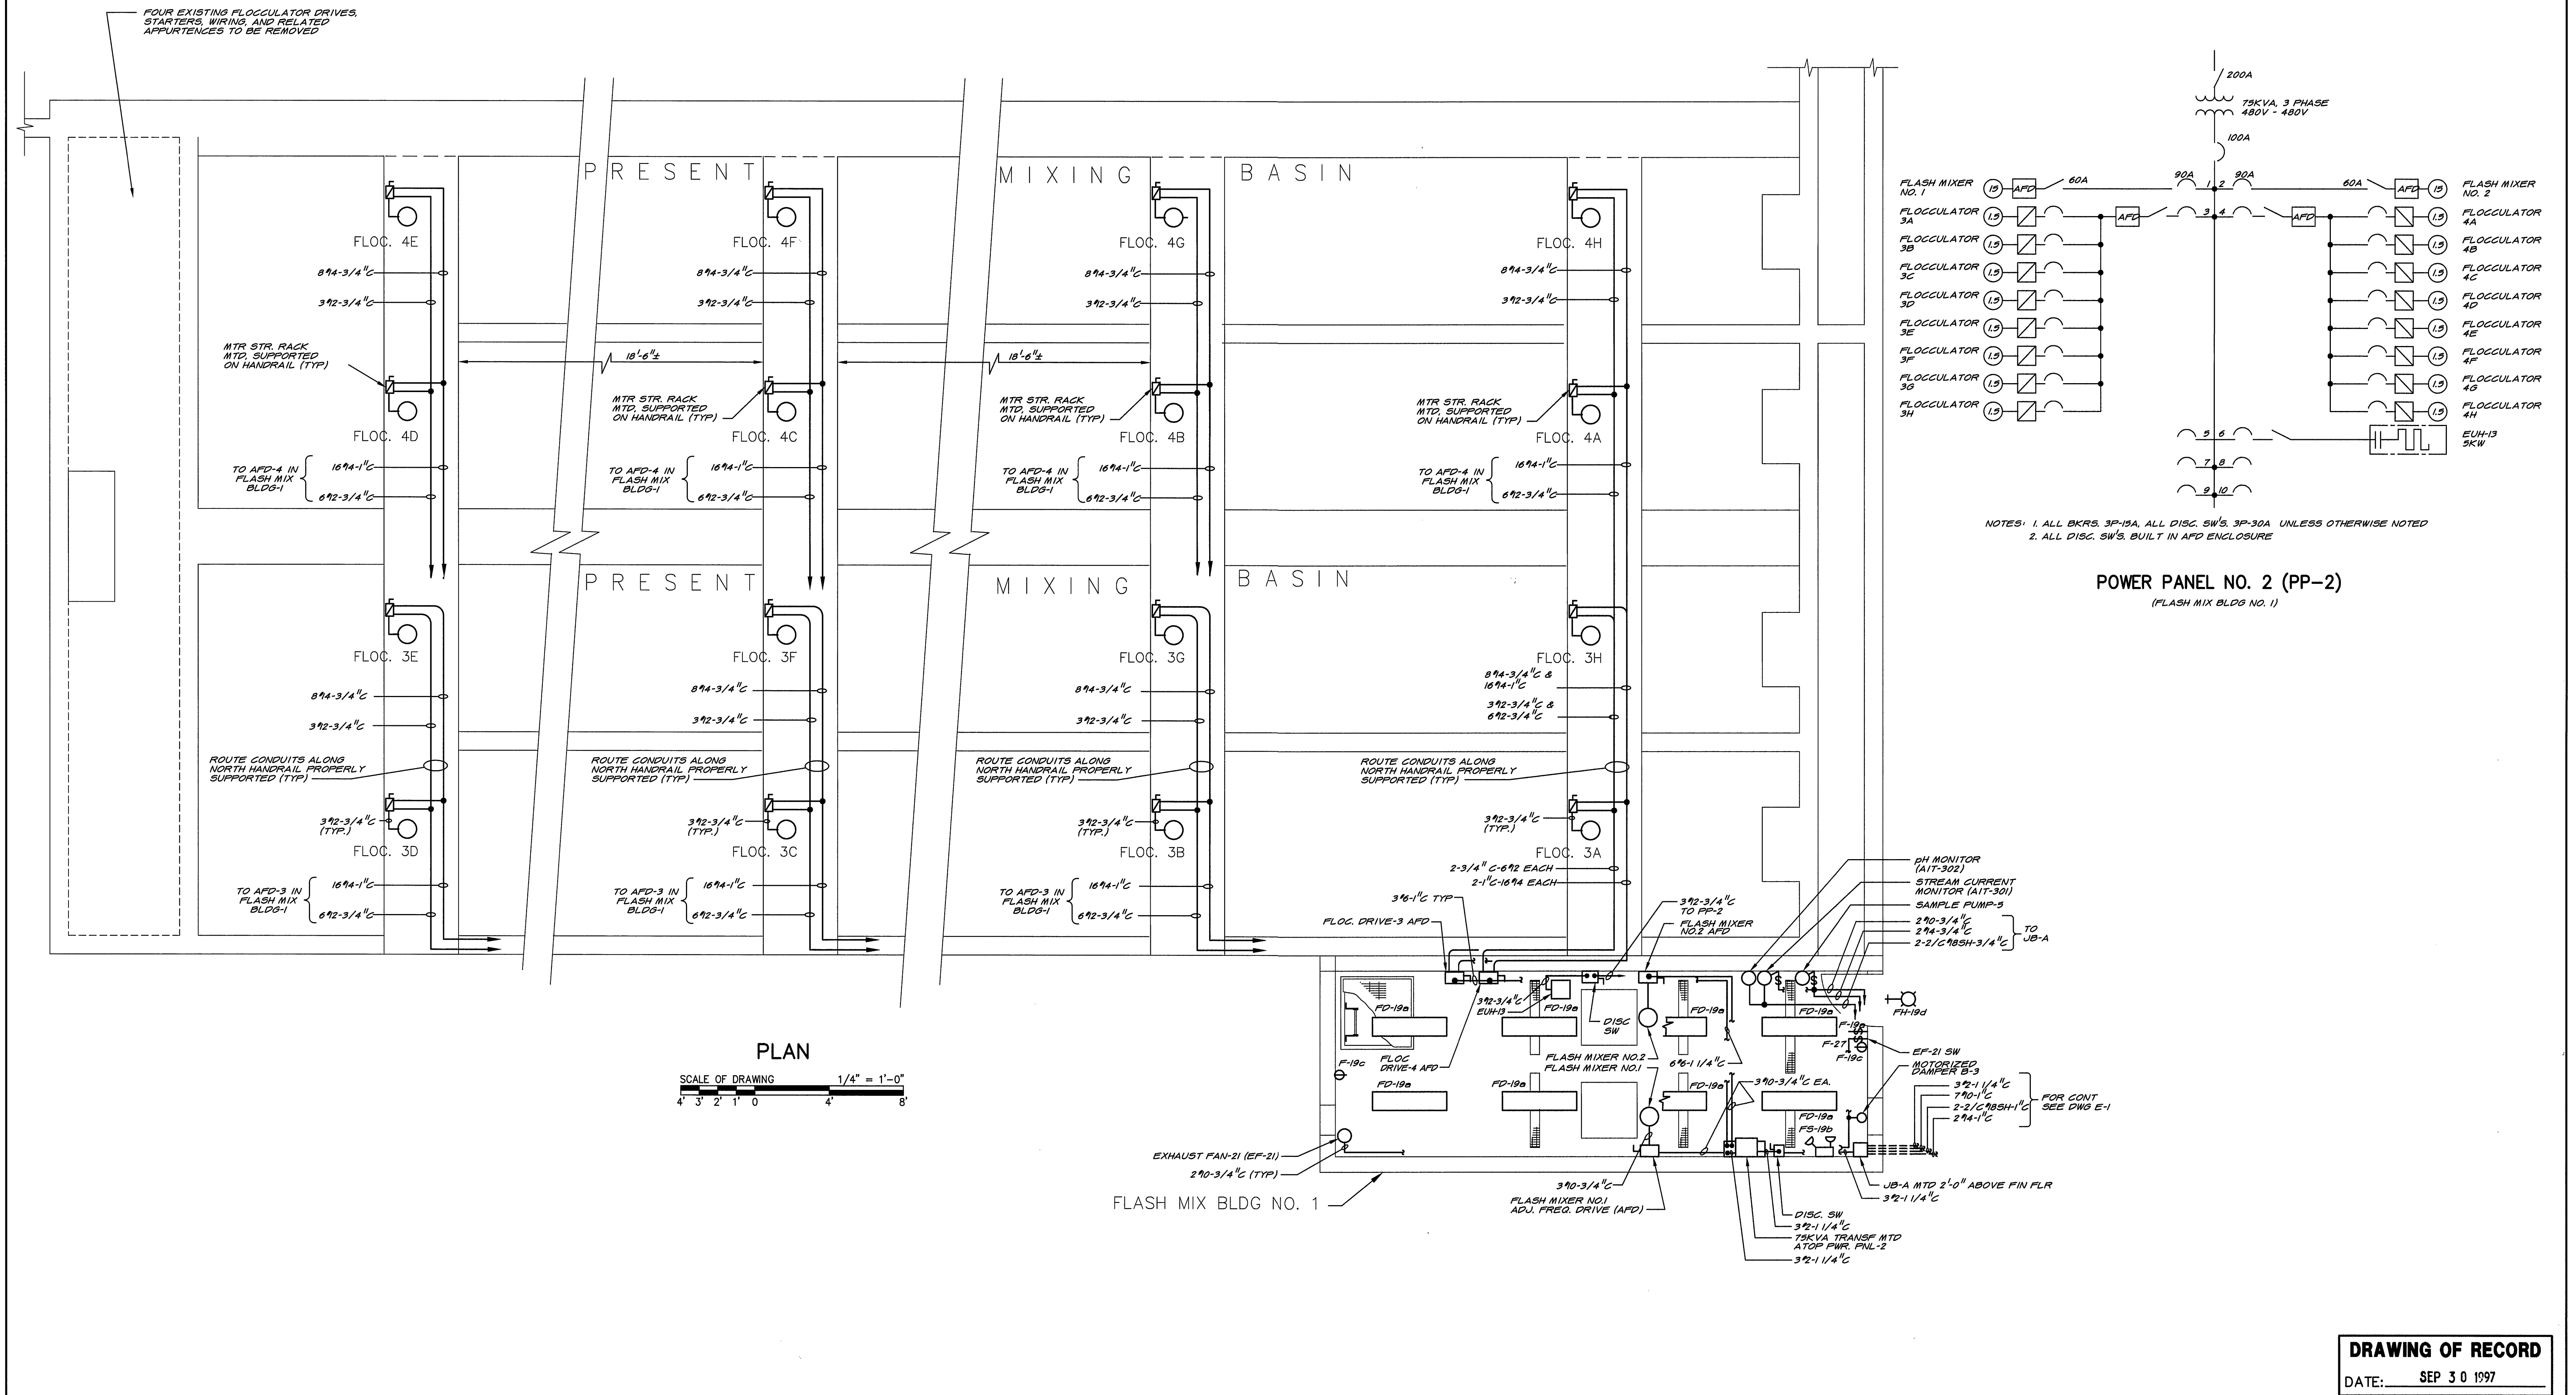

MATTERN & CRAIG CONSULTING ENGINEERS • SURVEYORS ROANOKE VIRGINIA		DESIGNED: KGG/RRA DRAWN: KGP CHECKED: RRA		 		<table><tr><th>REV.</th><th>DATE</th><th>DESCRIPTION</th><th>BY</th><th>APP.</th></tr><tr><td> </td><td> </td><td> </td><td> </td><td> </td></tr><tr><td> </td><td> </td><td> </td><td> </td><td> </td></tr><tr><td> </td><td> </td><td> </td><td> </td><td> </td></tr><tr><td> </td><td> </td><td> </td><td> </td><td> </td></tr><tr><td> </td><td> </td><td> </td><td> </td><td> </td></tr><tr><td> </td><td> </td><td> </td><td> </td><td> </td></tr><tr><td> </td><td> </td><td> </td><td> </td><td> </td></tr></table>					REV.	DATE	DESCRIPTION	BY	APP.																																				CARVINS COVE FILTER PLANT IMPROVEMENTS – PHASE I ROANOKE, VIRGINIA		DATE APRIL 1992 COMM. NO. 9130 SHEET E13	
REV.	DATE	DESCRIPTION	BY	APP.																																																		
ALVORD, BURDICK & HOWSON ENGINEERS CHICAGO		1954 BASINS – ELECTRICAL PLAN																																																				