


 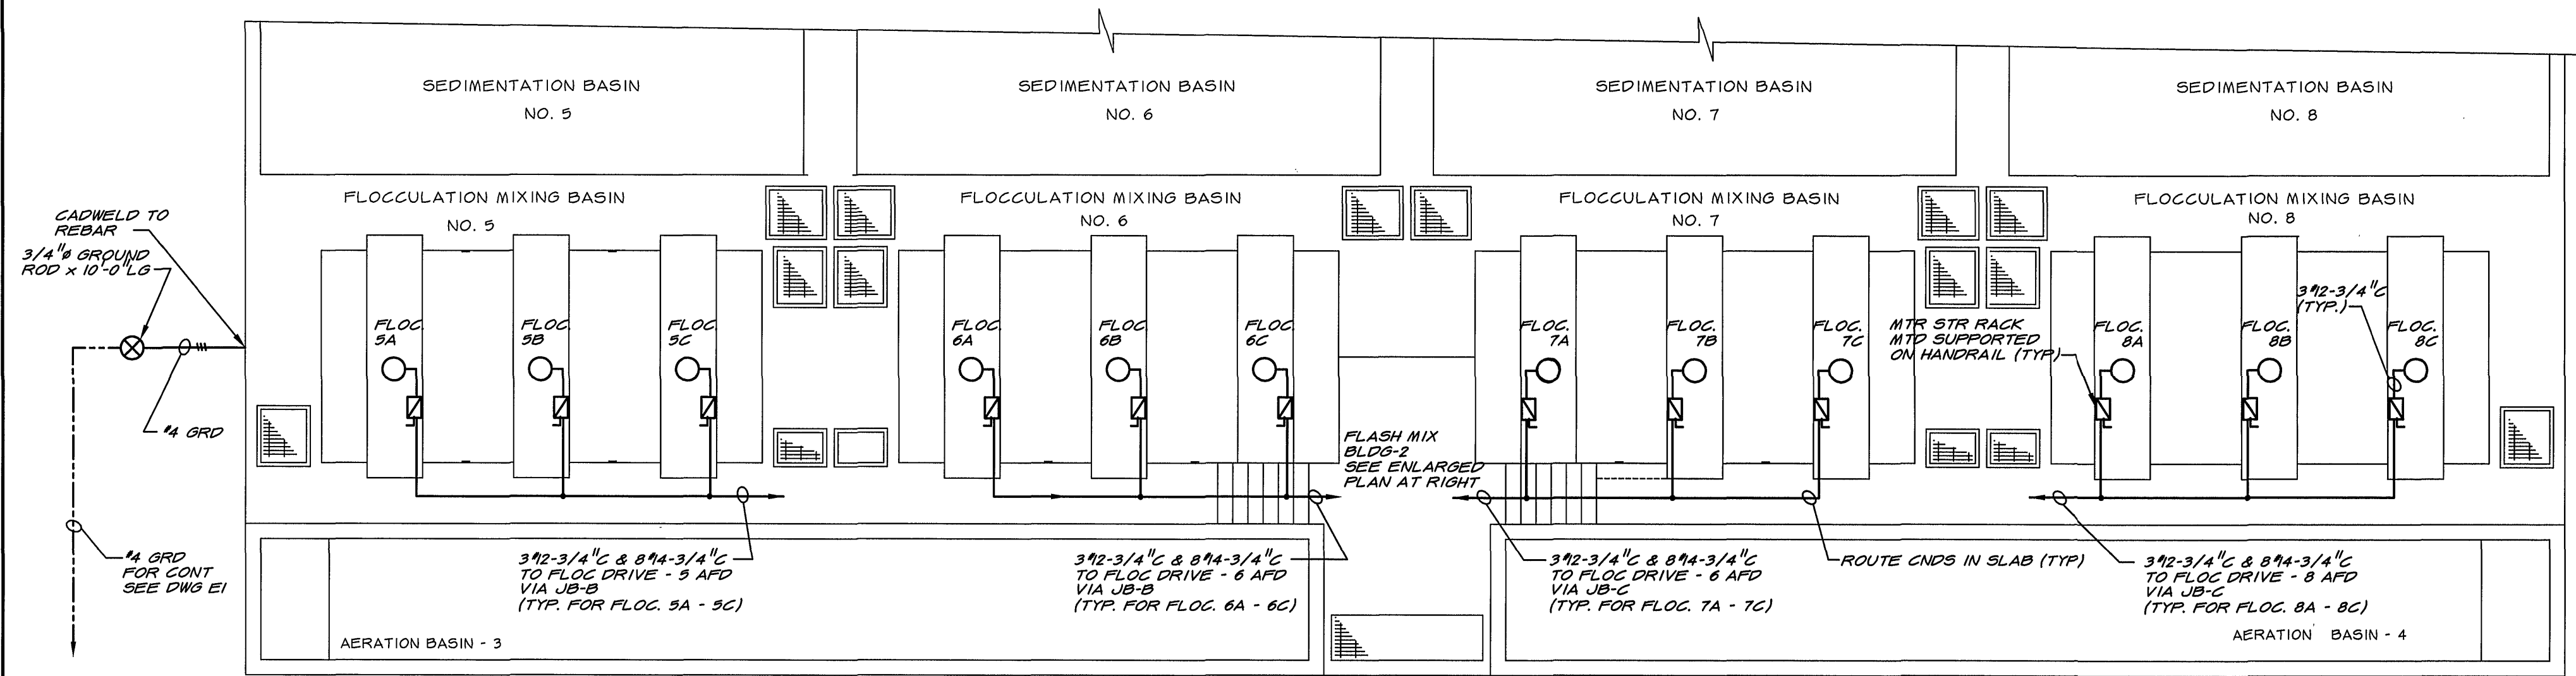


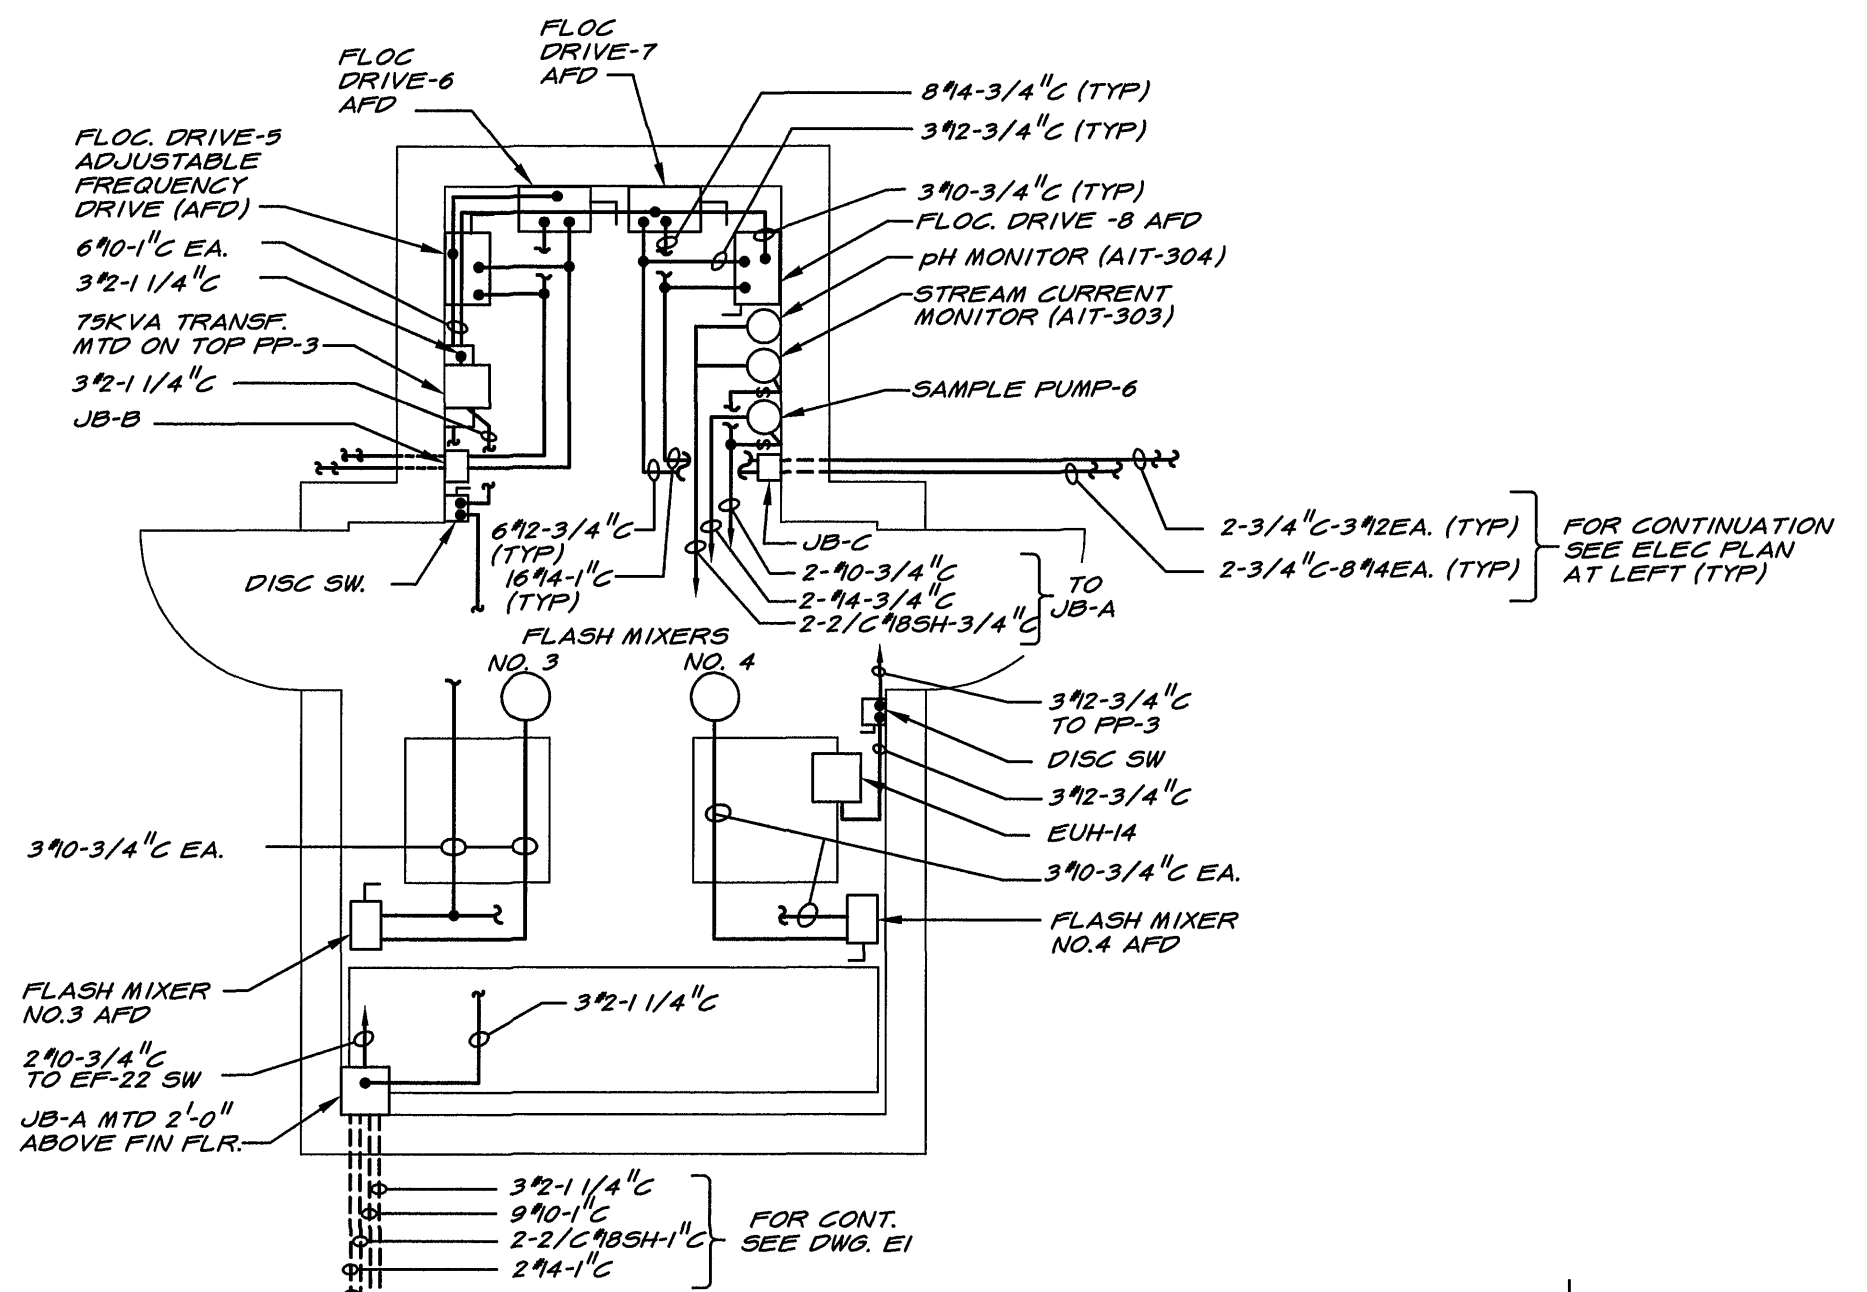


12MGD PRETREATMENT BASIN - ELECTRICAL PLAN

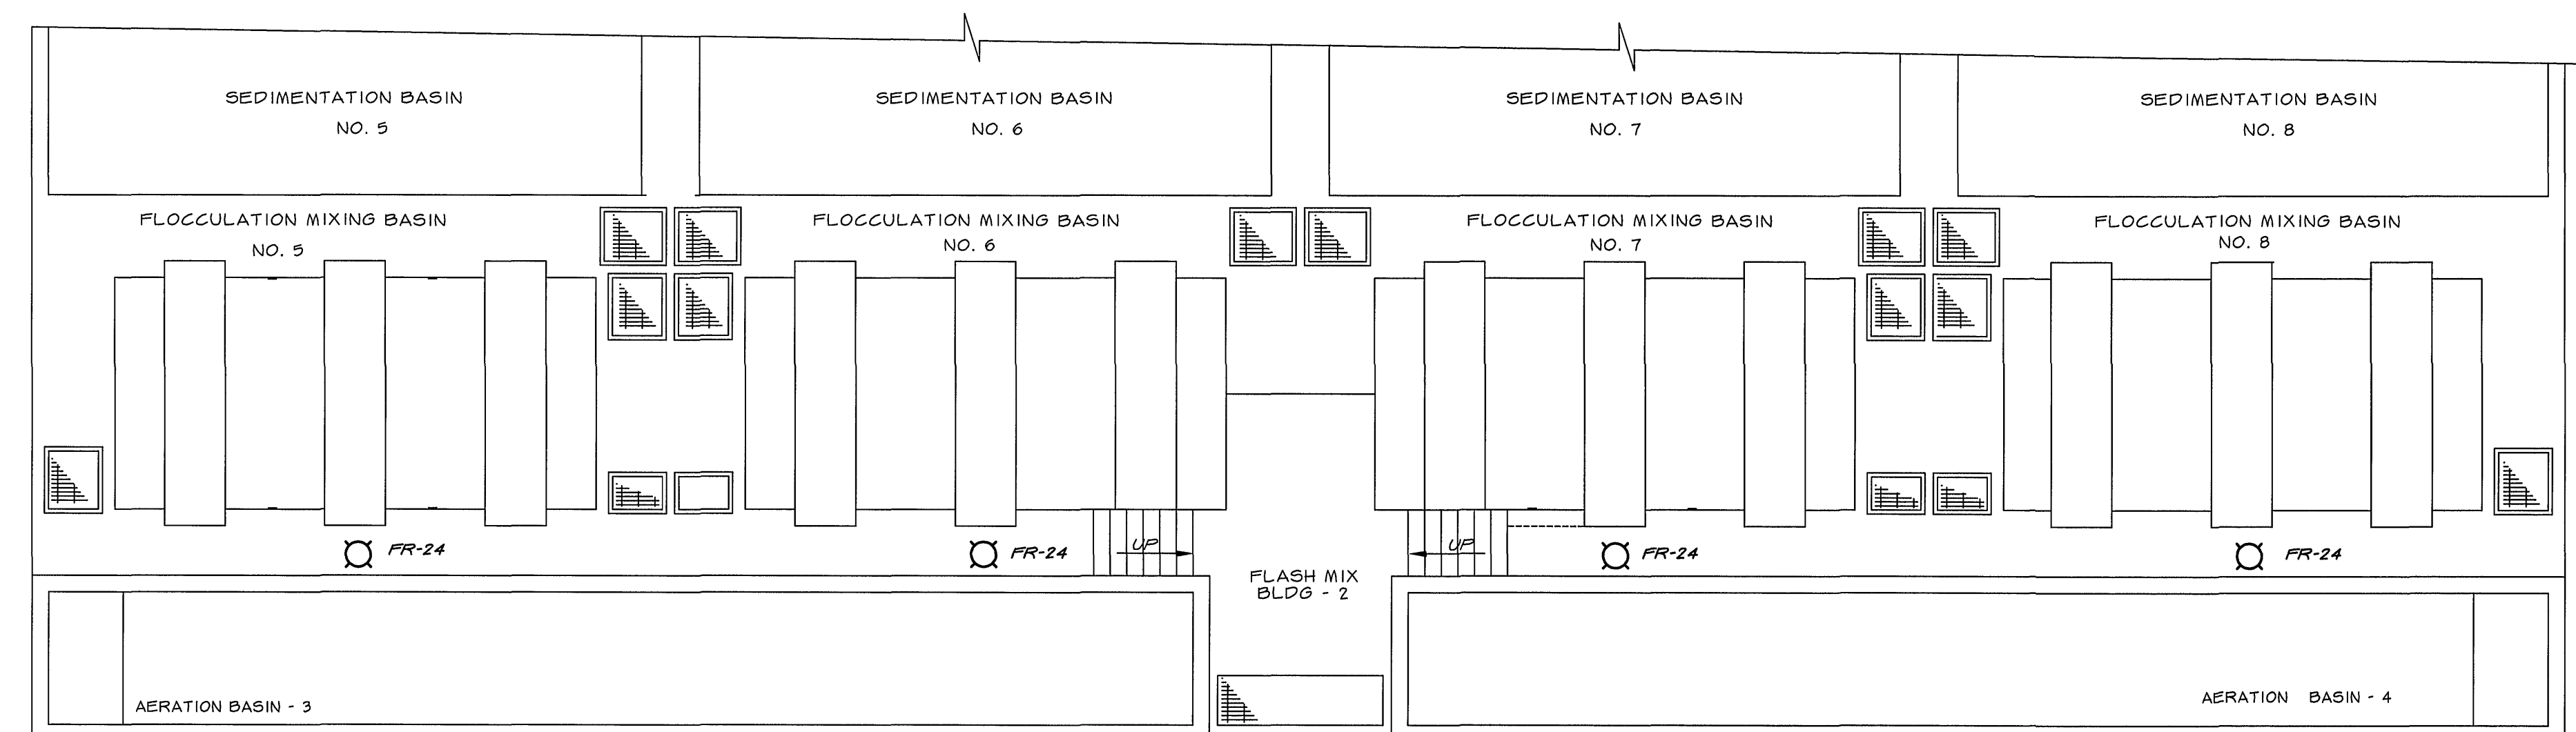

FLASH MIX BLDG-2, ELECTRICAL PLAN




12MGD PRETREATMENT BASIN - LIGHTING PLAN

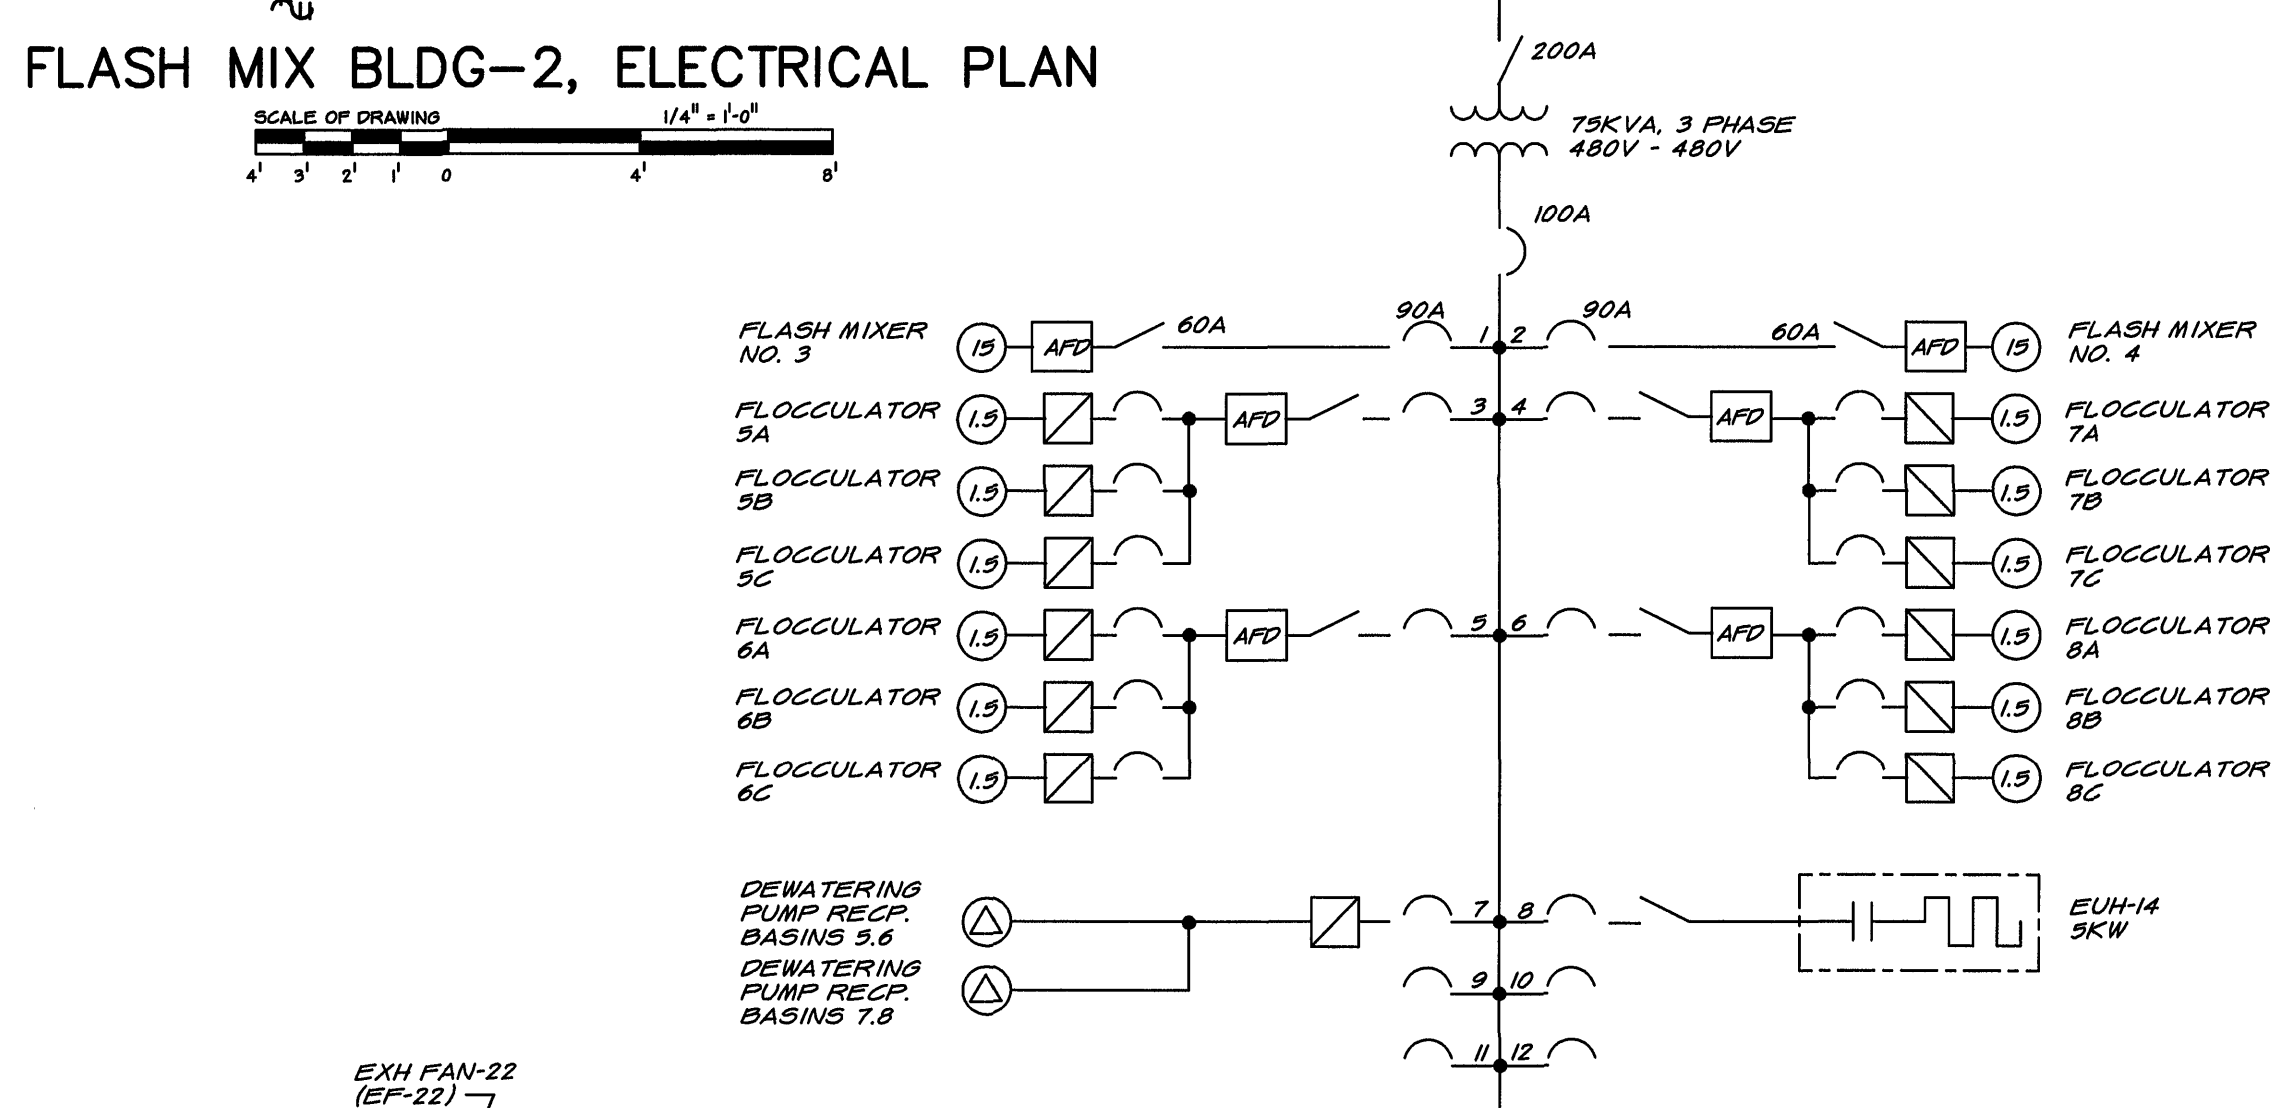


NOTES: 1. ALL BKRS. 3P-15A, ALL DISC. SW'S. 3P-30A UNLESS OTHERWISE NOTED
2. ALL DISC. SW'S. BUILT IN APD ENCLOSURE

POWER PANEL NO. 3 (PP-3)
(FLASH MIX BLDG - 2)

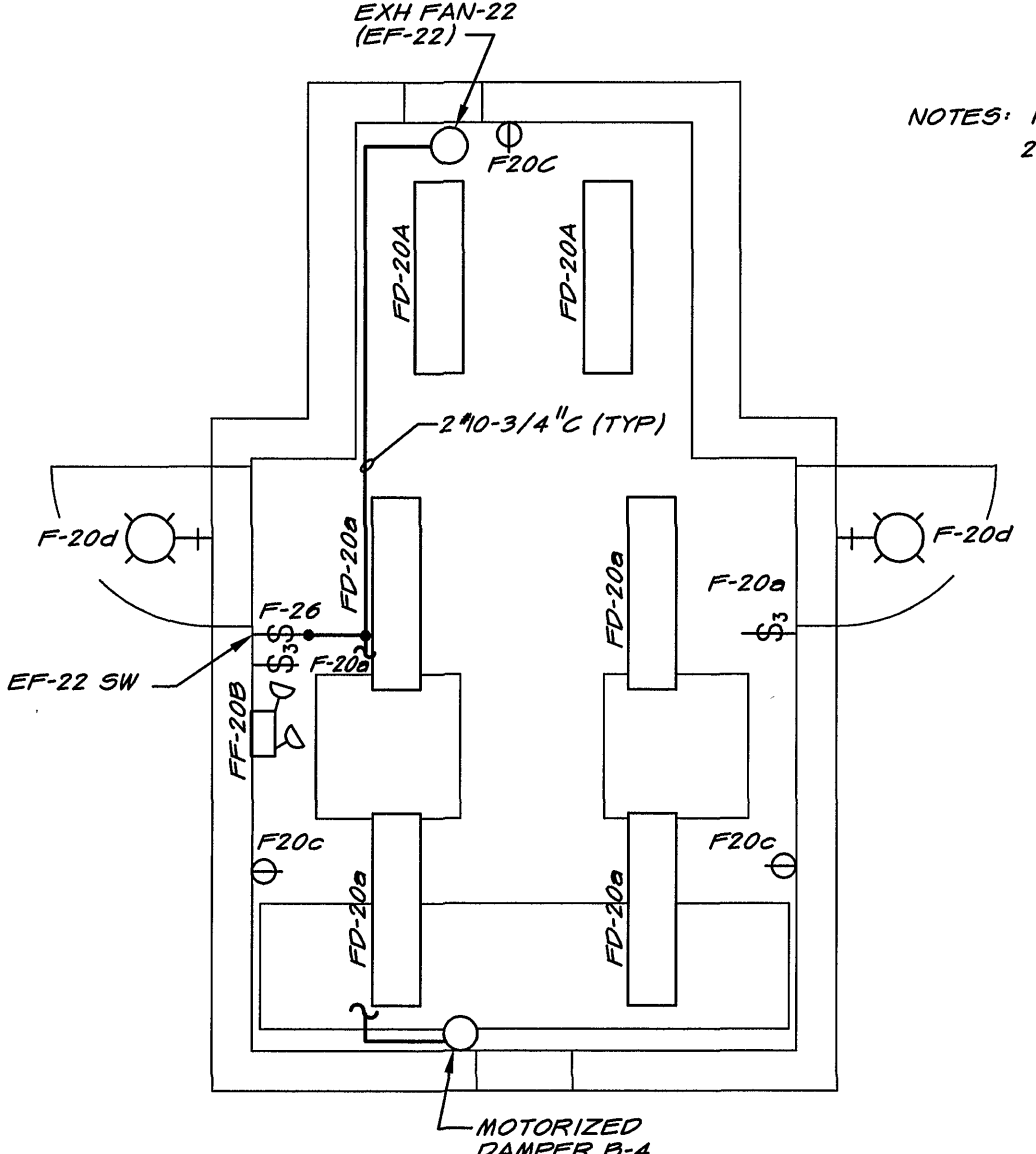

FLASH MIX BLDG-2, LIGHTING PLAN


 


DRAWING OF RECORD
DATE: SEP 30 1997

MATTERN & CRAIG
CONSULTING ENGINEERS • SURVEYORS
ROANOKE VIRGINIA

ALVORD, BURDICK & HOWSON
ENGINEERS CHICAGO

DESIGNED: KCC/RRA
DRAWN: KGP
CHECKED: RRA

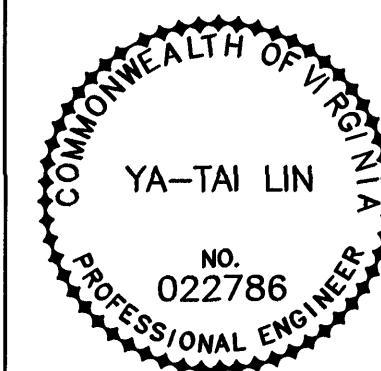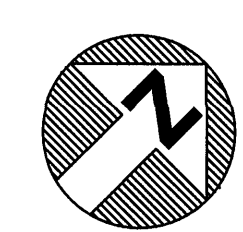

REV.	DATE	DESCRIPTION	BY	APP.

CARVINS COVE FILTER PLANT IMPROVEMENTS - PHASE I
ROANOKE, VIRGINIA

12 MGD PRETREATMENT BASINS - ELECTRICAL PLANS

DATE: APRIL 1992
COMM. NO. 9130
SHEET E14