



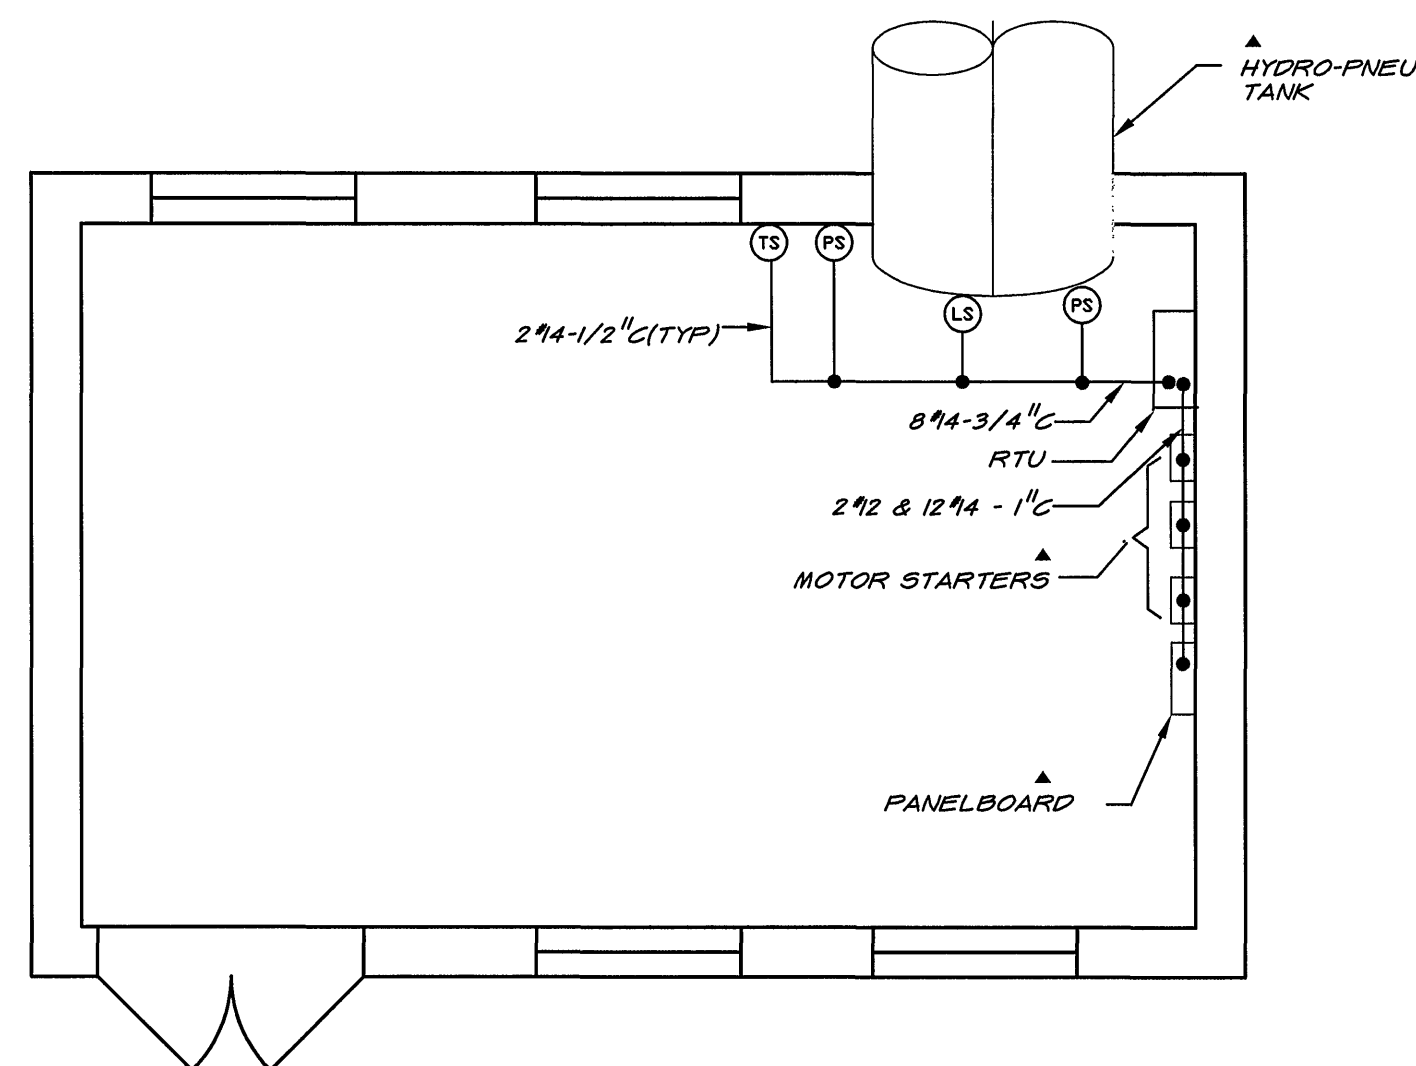


PLAN - PEAKWOOD BOOSTER STATION

SCALE OF DRAWING 1/4" = 1'-0"
4' 3' 2' 1' 0' 4' 8'

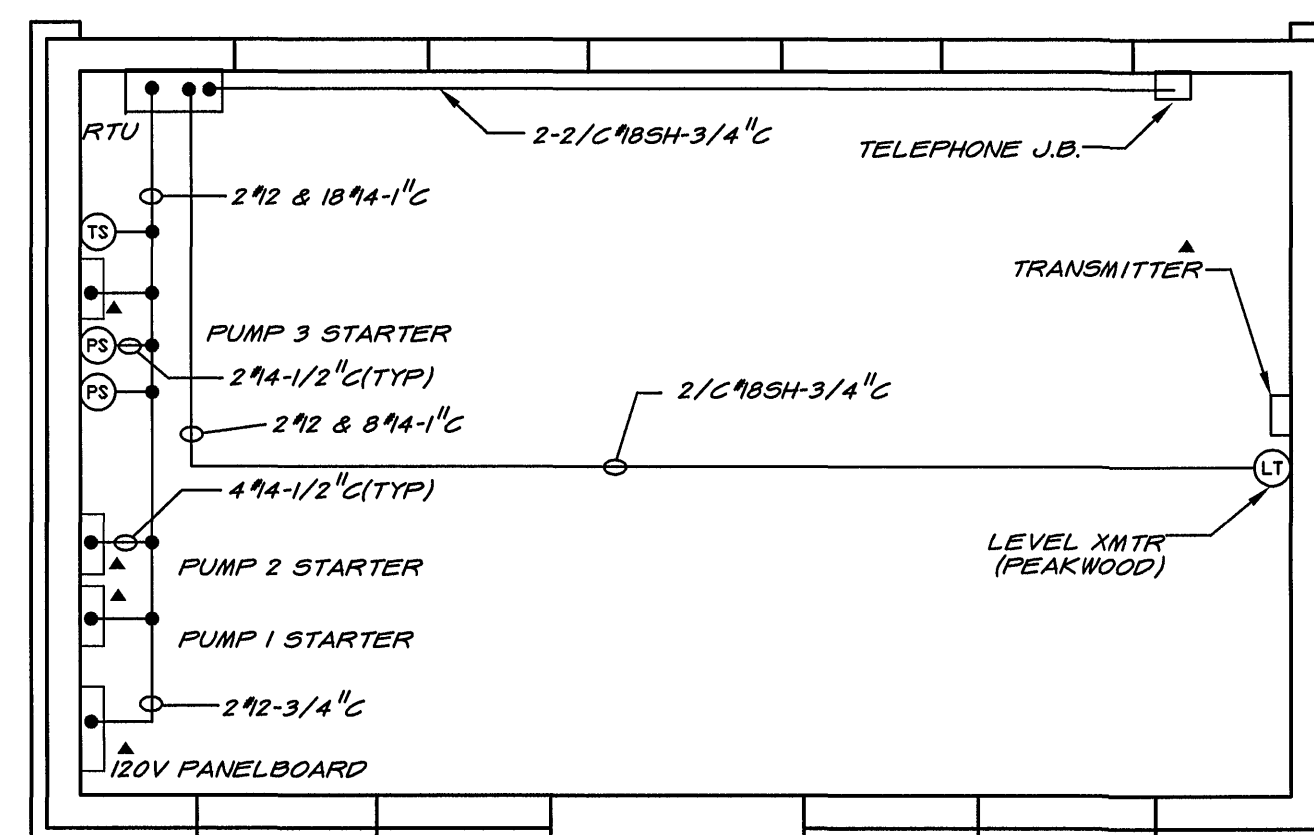


GROUND FLOOR PLAN

SCALE OF DRAWING 1/4" = 1'-0"
4' 3' 2' 1' 0' 4' 8'

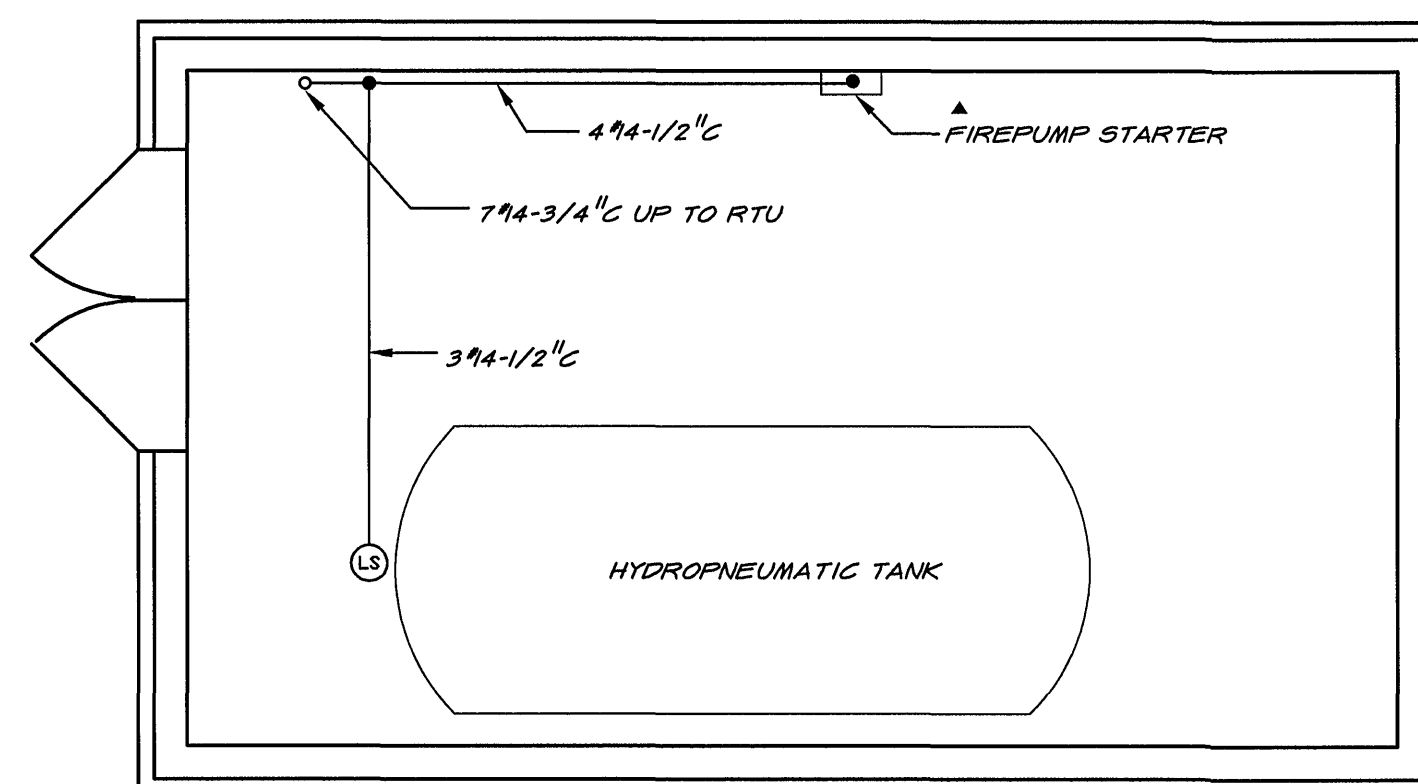


BASEMENT PLAN
CHAPEL FOREST BOOSTER STATION


SCALE OF DRAWING 1/4" = 1'-0"
4' 3' 2' 1' 0' 4' 8'

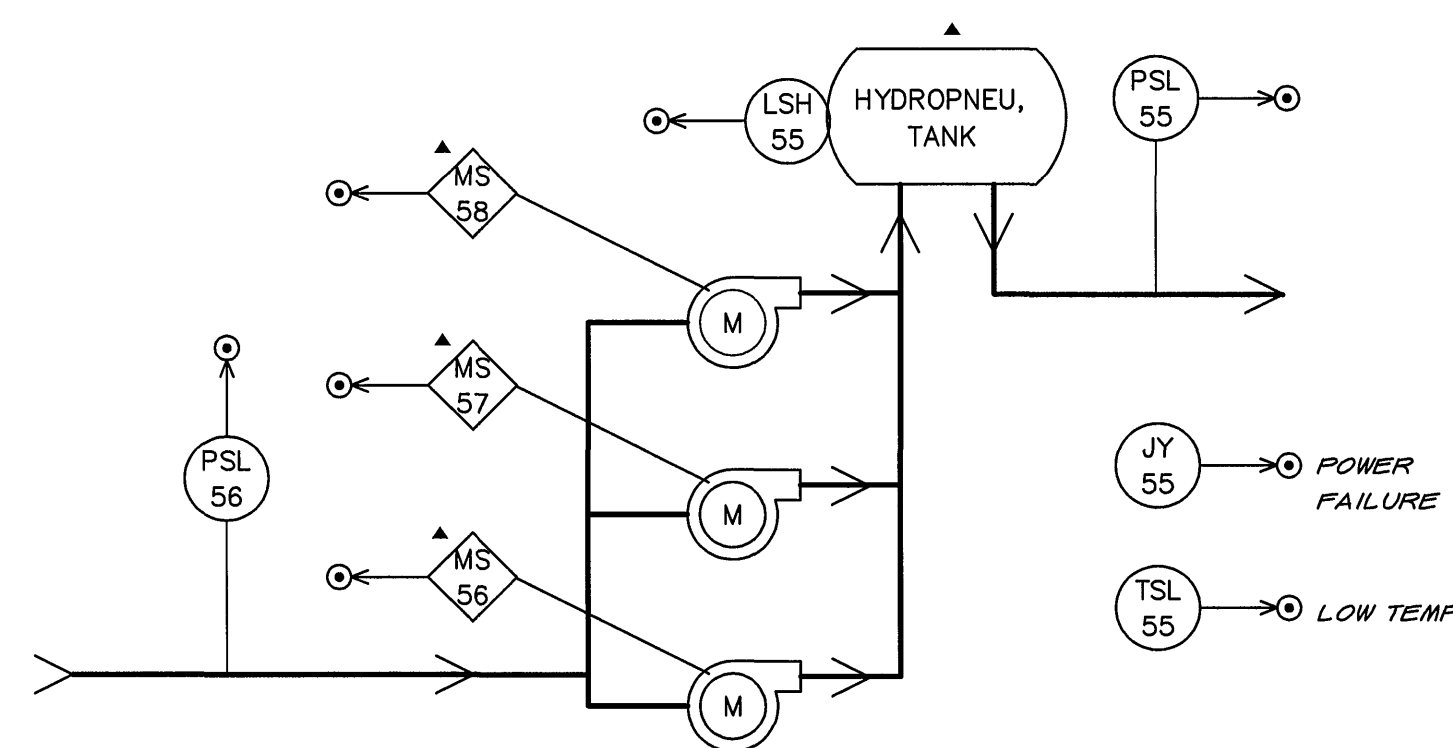

PEAKWOOD BOOSTER STATION

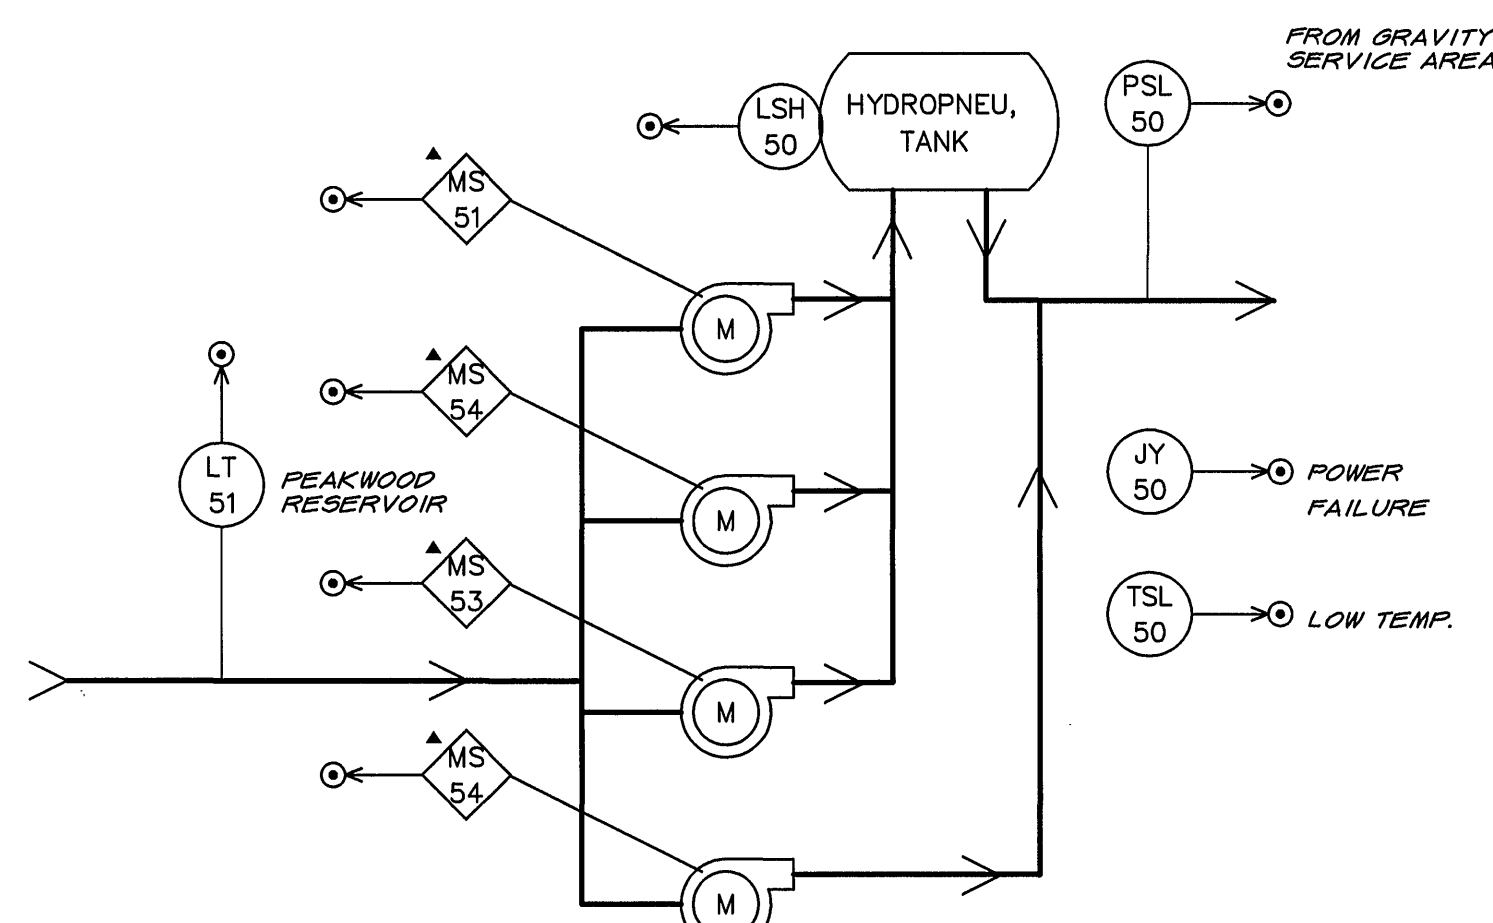


CHAPEL FOREST BOOSTER STATION

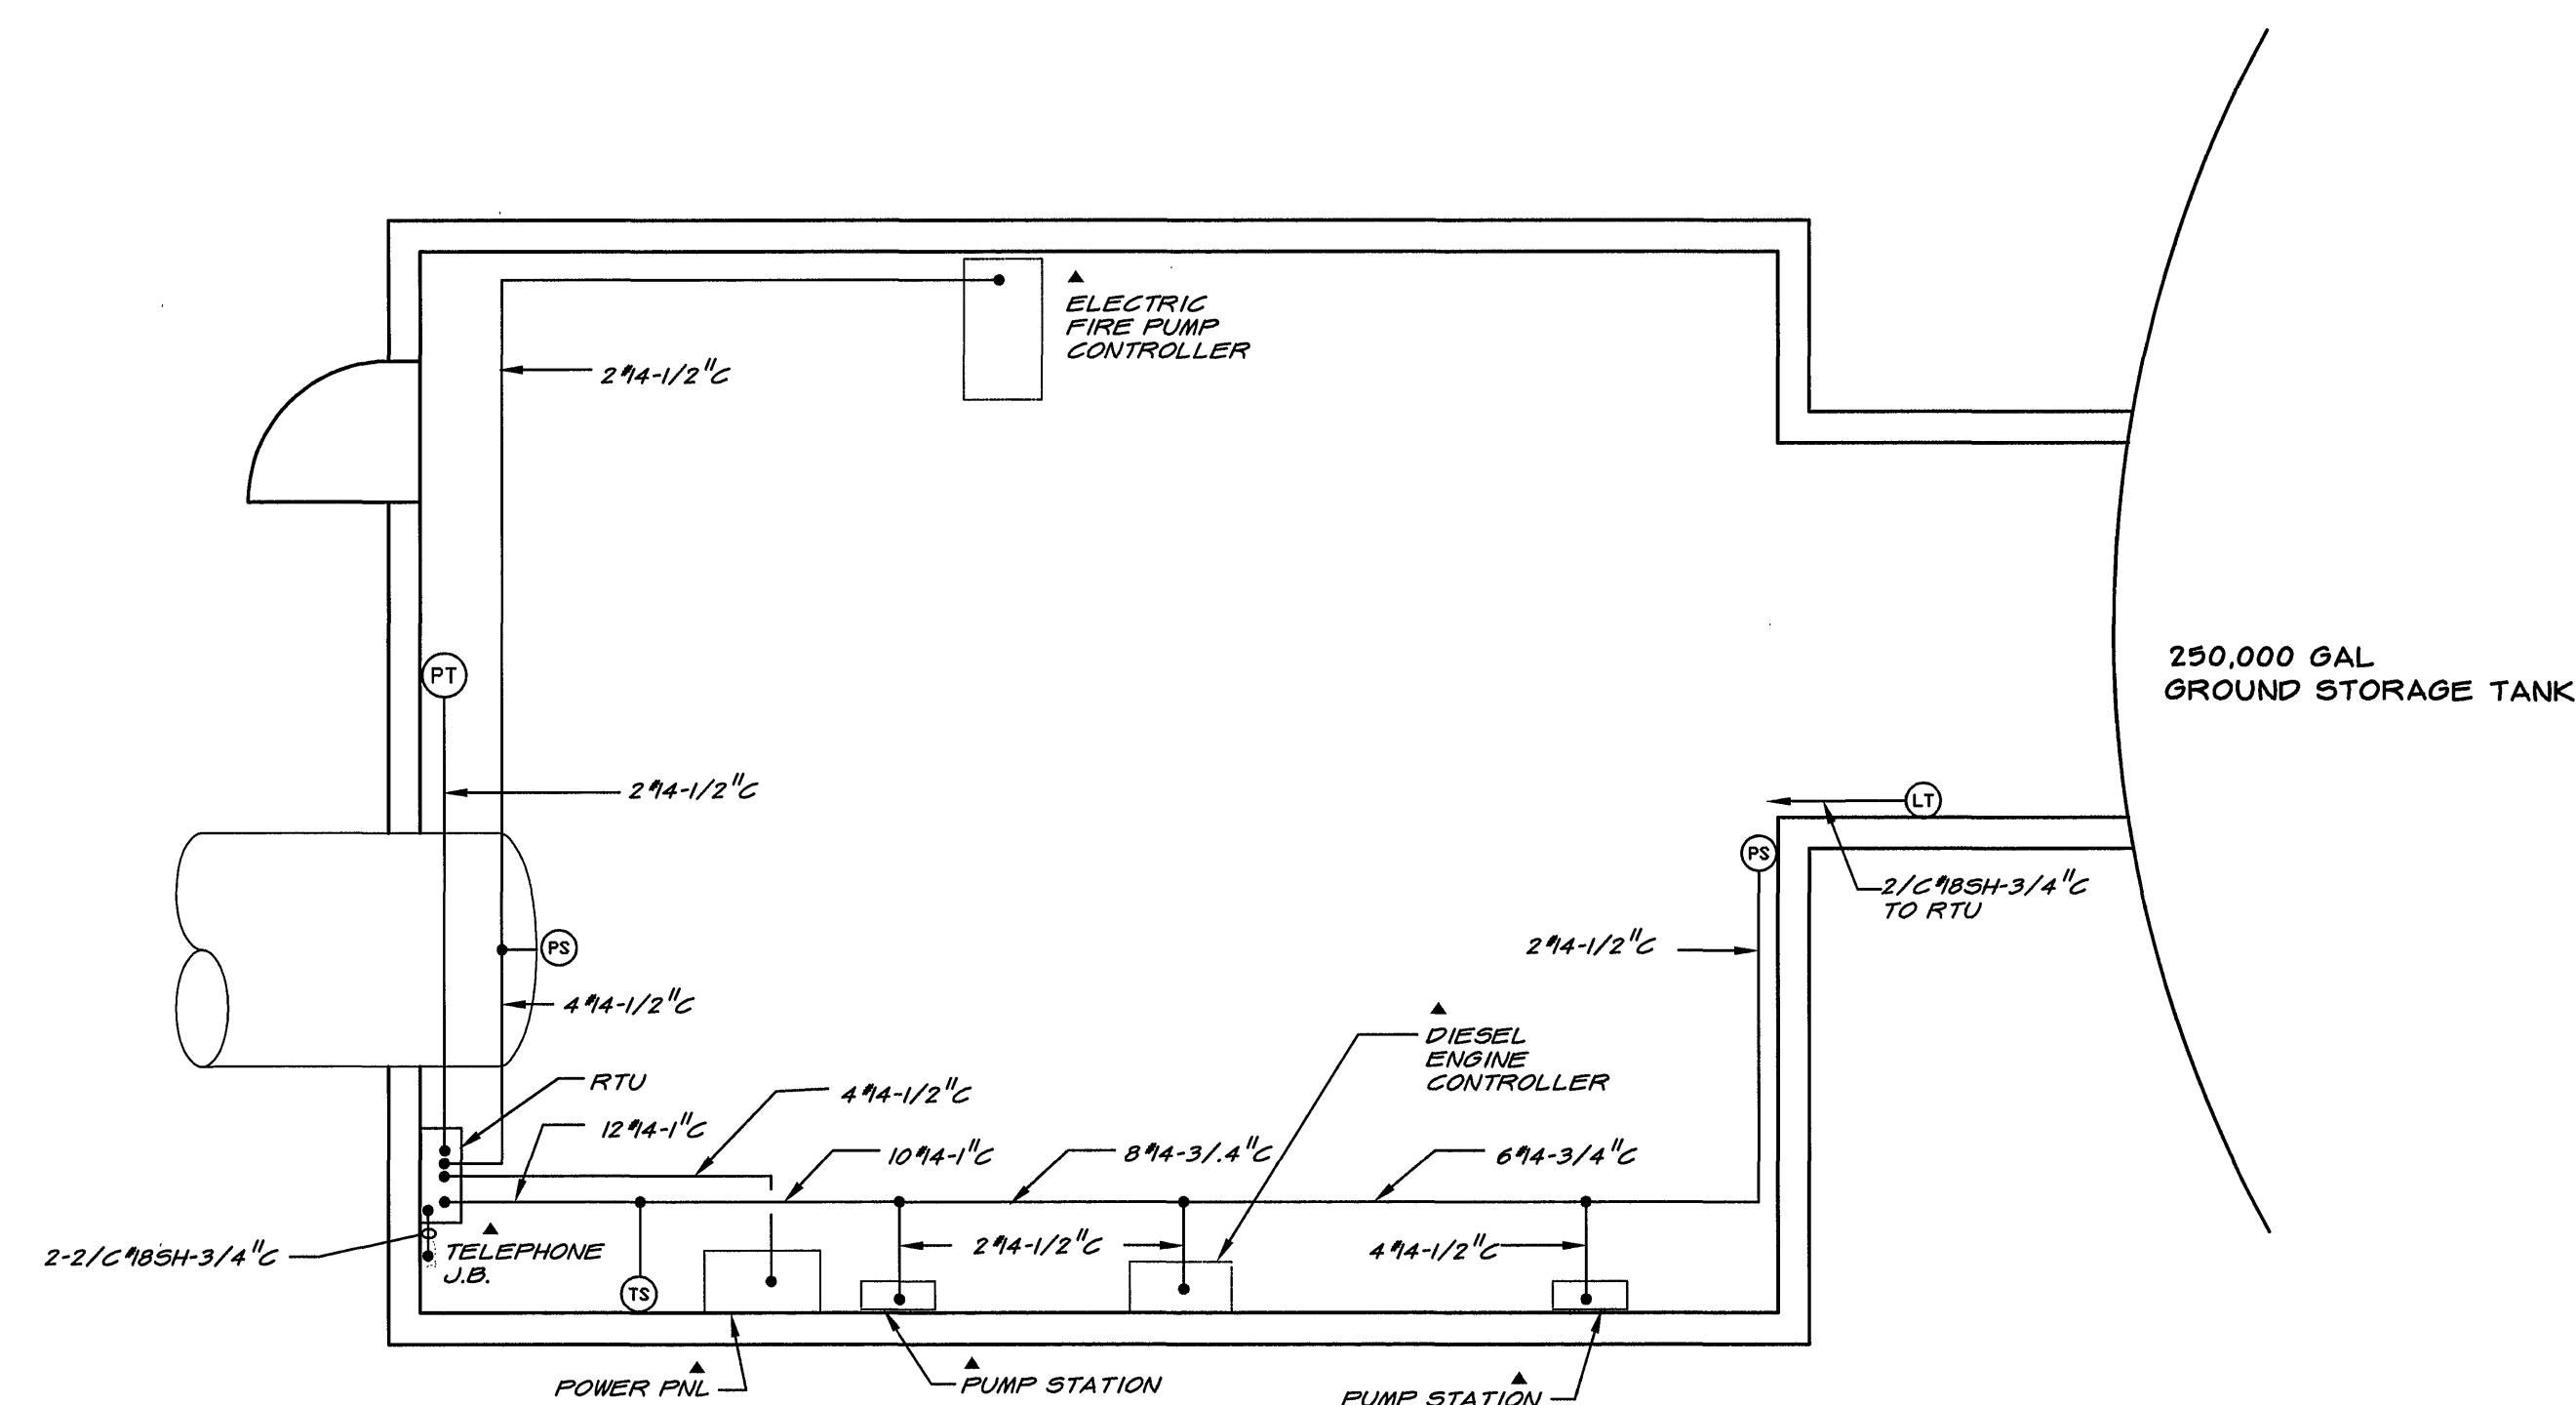

PLAN - STATESMAN PARK BOOSTER STATION

SCALE OF DRAWING 1/4" = 1'-0"
4' 3' 2' 1' 0' 4' 8'

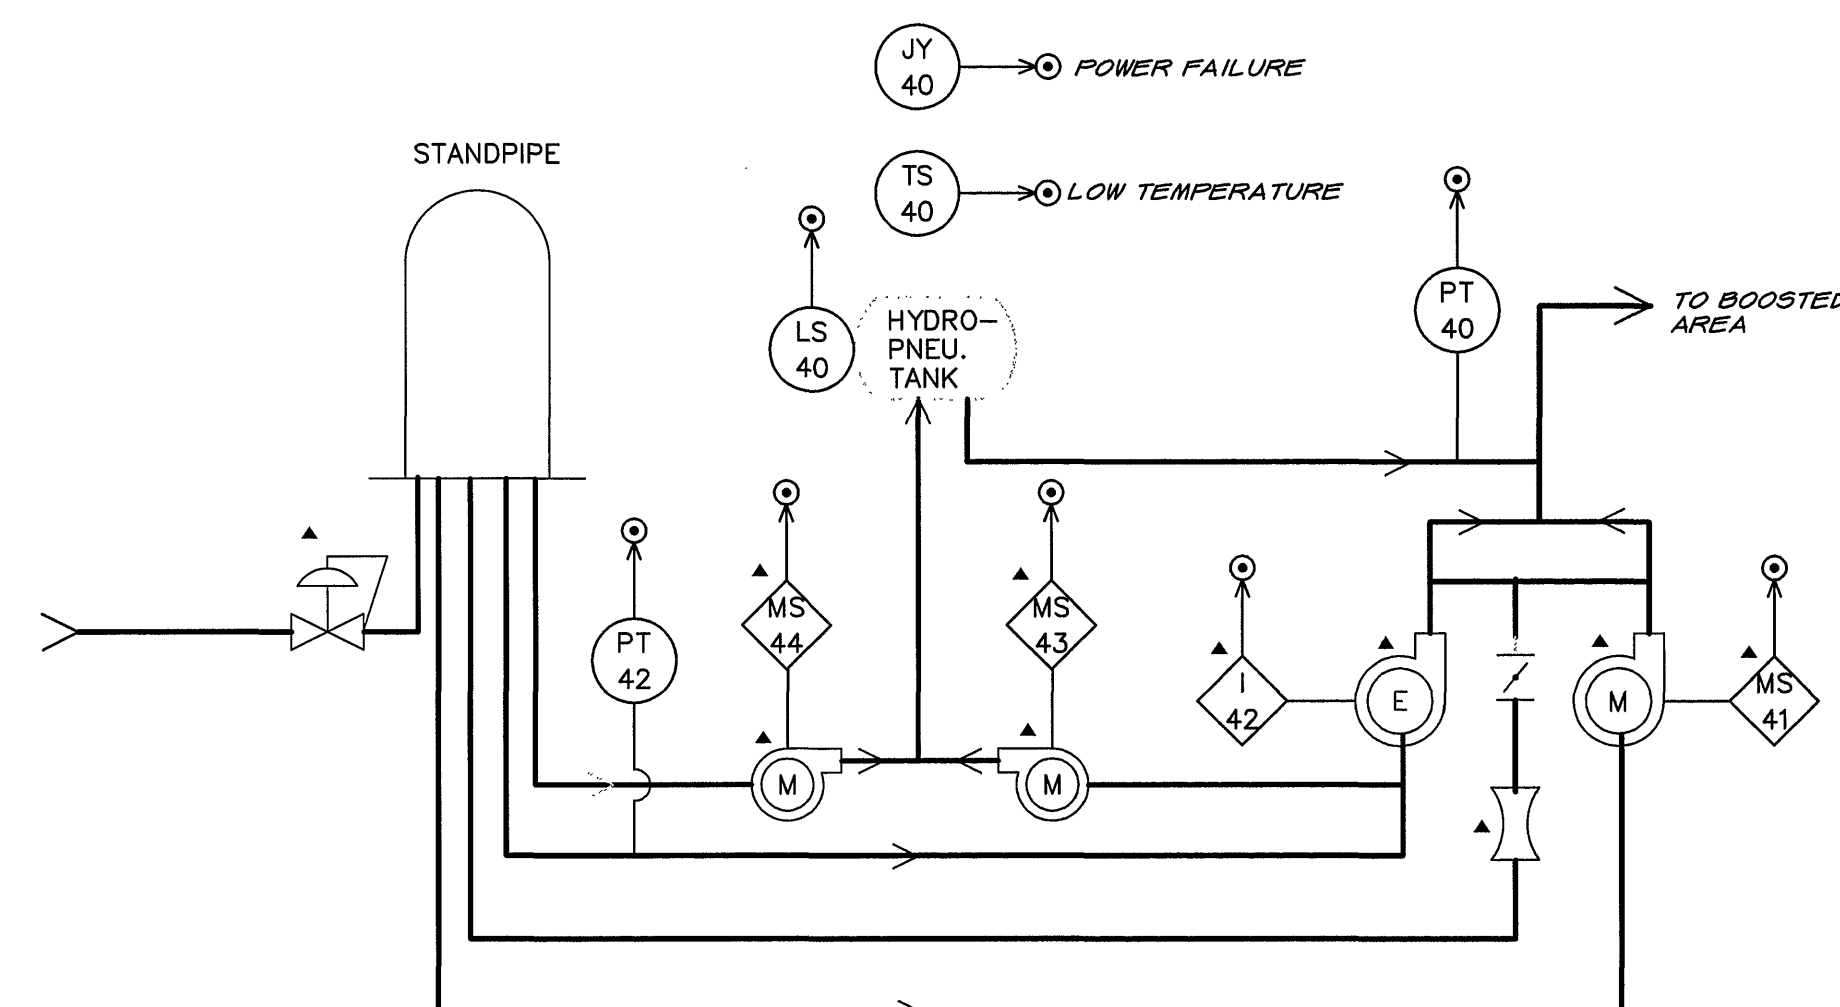

STATESMAN PARK BOOSTER STATION

▲ DENOTES EXISTING EQUIPMENT

DRAWING OF RECORD
DATE: SEP 30 1997

MATTERN & CRAIG
CONSULTING ENGINEERS • SURVEYORS
ROANOKE VIRGINIA

DESIGNED: KCC

DRAWN: KCC

CHECKED: KCC



REV.	DATE	DESCRIPTION	BY	APP.

CARVINS COVE FILTER PLANT IMPROVEMENTS - PHASE I

ROANOKE, VIRGINIA

CHAPEL FOREST, PEAKWOOD & STATESMAN PARK
PUMPING STATIONS

DATE
APRIL 1992
COMM. NO.
9130
SHEET
SR5