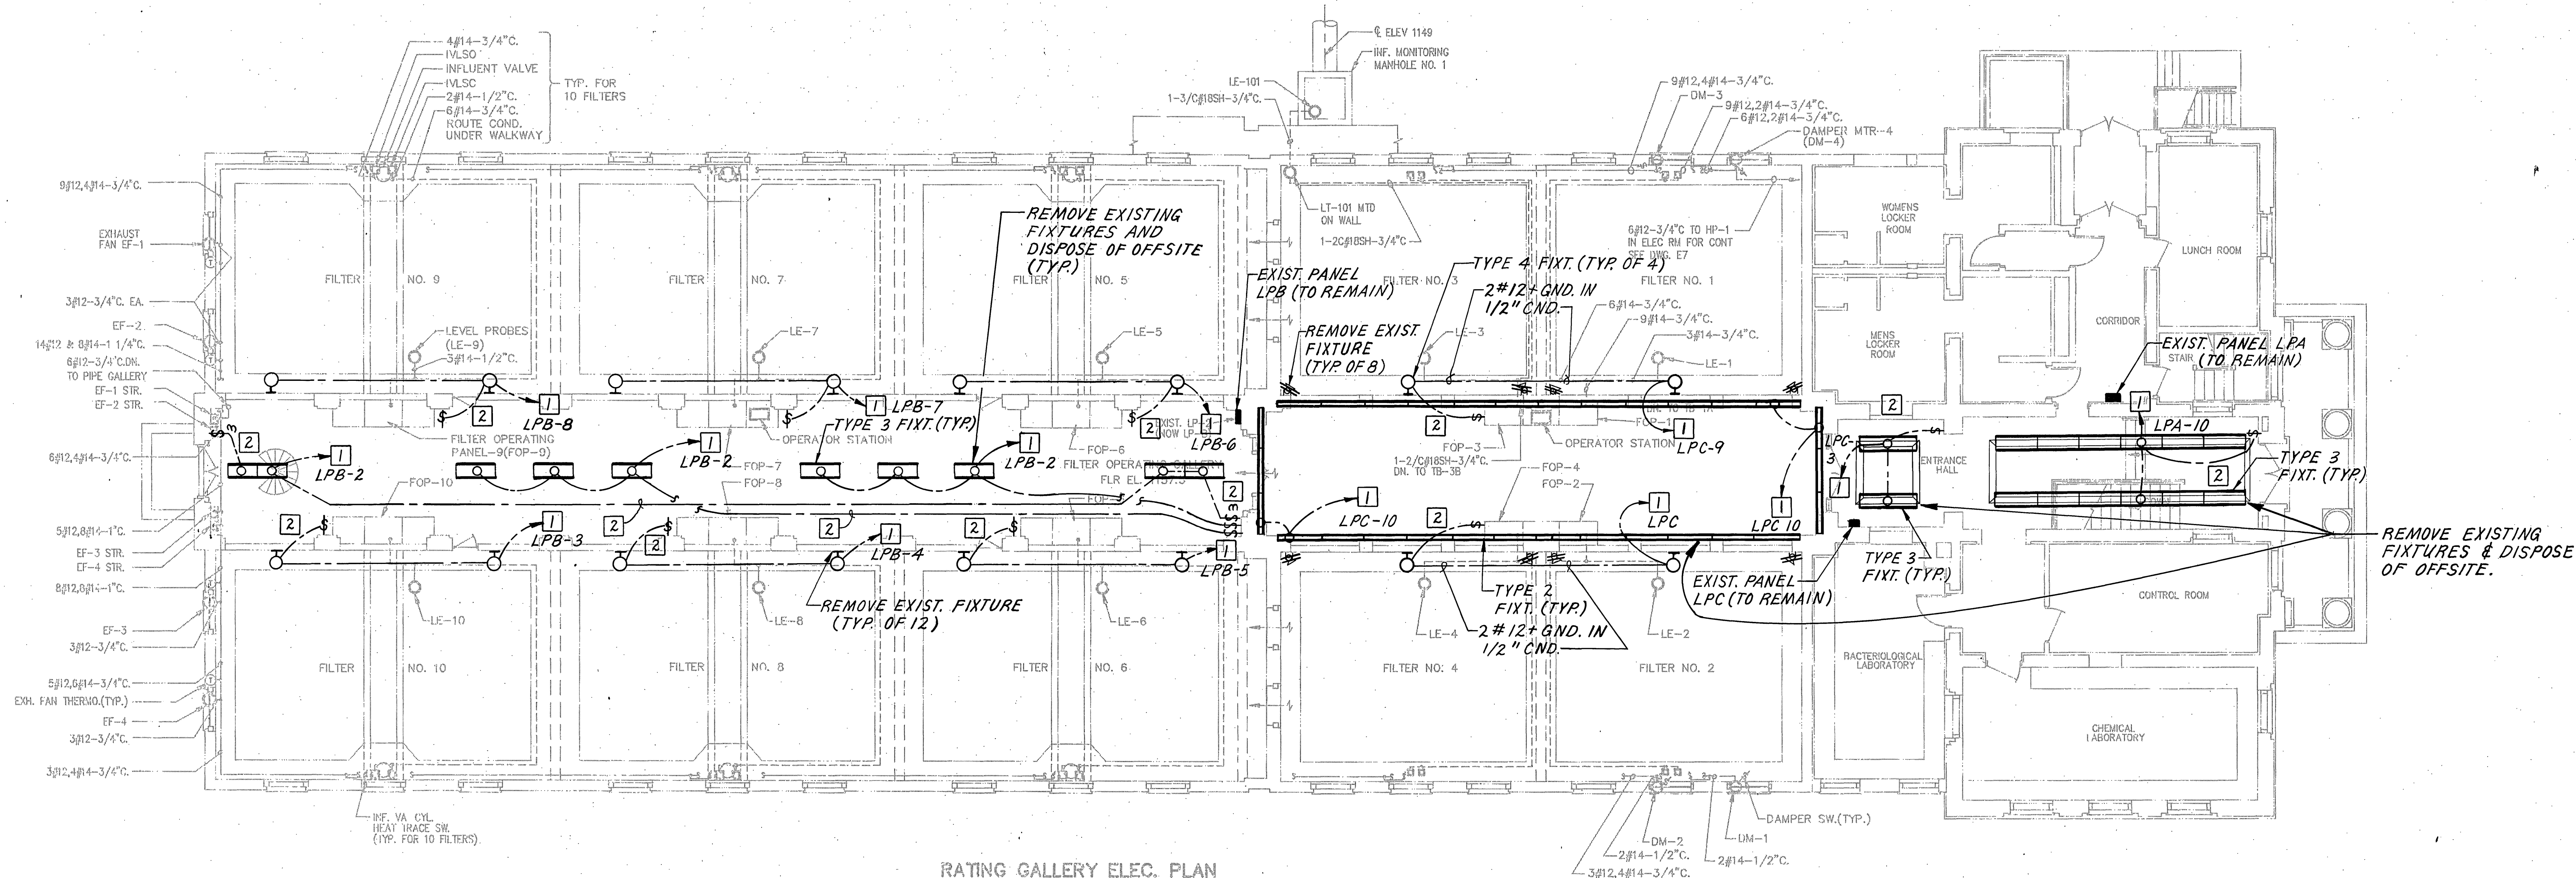




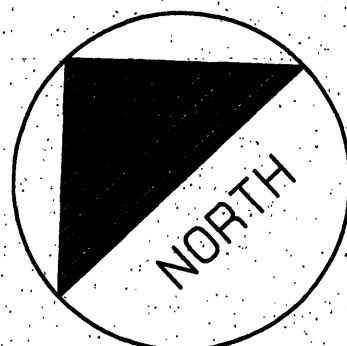
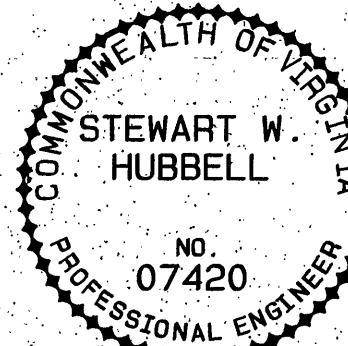
RATING GALLERY ELEC. PLAN
 SCALE OF DRAWING 1/8" = 1'-0"
 0 2 4 6 8 10 12 14 16

- NOTES:**
1. INSTALL NEW CONDUCTORS IN EXISTING CONDUIT TO EXISTING CIRCUIT BREAKER (NO. 12 AWG).
 2. REPLACE EXISTING SWITCHES (SPEC. GRADE) AND EXISTING SWITCH CONDUCTORS IN EXISTING CONDUIT.
 3. CONTRACTOR TO REMOVE ALL EXISTING CONDUIT THAT IS NOT USED. CONTRACTOR SHALL PROVIDE ANY ADDITIONAL CONDUIT THAT MAY BE REQUIRED. CONDUIT SHALL BE PAINTED TO MATCH THE SURFACE TO WHICH IT IS ATTACHED. REMOVED CONDUIT SHALL BE DISPOSED OF OFFSITE.

LIGHTING FIXTURE SCHEDULE				
TYPE DESIGNATION	MFG. & CAT. NO.	TYPE / MOUNTING	LAMPS	REMARKS
1	LIGHTOLIER 6580	FLUOR. / WALL	1-13WTT	SAME HEIGHT AS EXIST.
2	LIGHTOLIER STG 232RS	FLUOR. / COVE	2-F32T8	ELECTRONIC BALLAST
3	LIGHTOLIER DPB2S12LS232	FLUOR. / CEIL	2-F32T8	ELECTRONIC BALLAST
4	WIDELIGHT 333175MA	MH / WALL	1-175WMH	SAME HEIGHT AS EXIST.

4. CONTRACTOR SHALL MAKE ANY REPAIRS NECESSARY TO CEILINGS OR WALLS THAT WILL NOT BE COVERED BY NEW FIXTURES, AND SHALL PAINT TO MATCH SURROUNDING SURFACE.

CONTRACT BID ITEM 8

MATTERN & CRAIG CONSULTING ENGINEERS • SURVEYORS ROANOKE VIRGINIA	DESIGNED:			REV	DATE	DESCRIPTION	BY	APP.	CARVINS COVE FILTER PLANT IMPROVEMENTS - PHASE I	DATE	
	DRAWN:									SEPT. 1994	
ALVORD, BURDICK & HOWSON ENGINEERS CHICAGO	CHECKED:								ELECTRICAL	COMM. NO.	
										1138CO	
										SHEET	
										C07	