



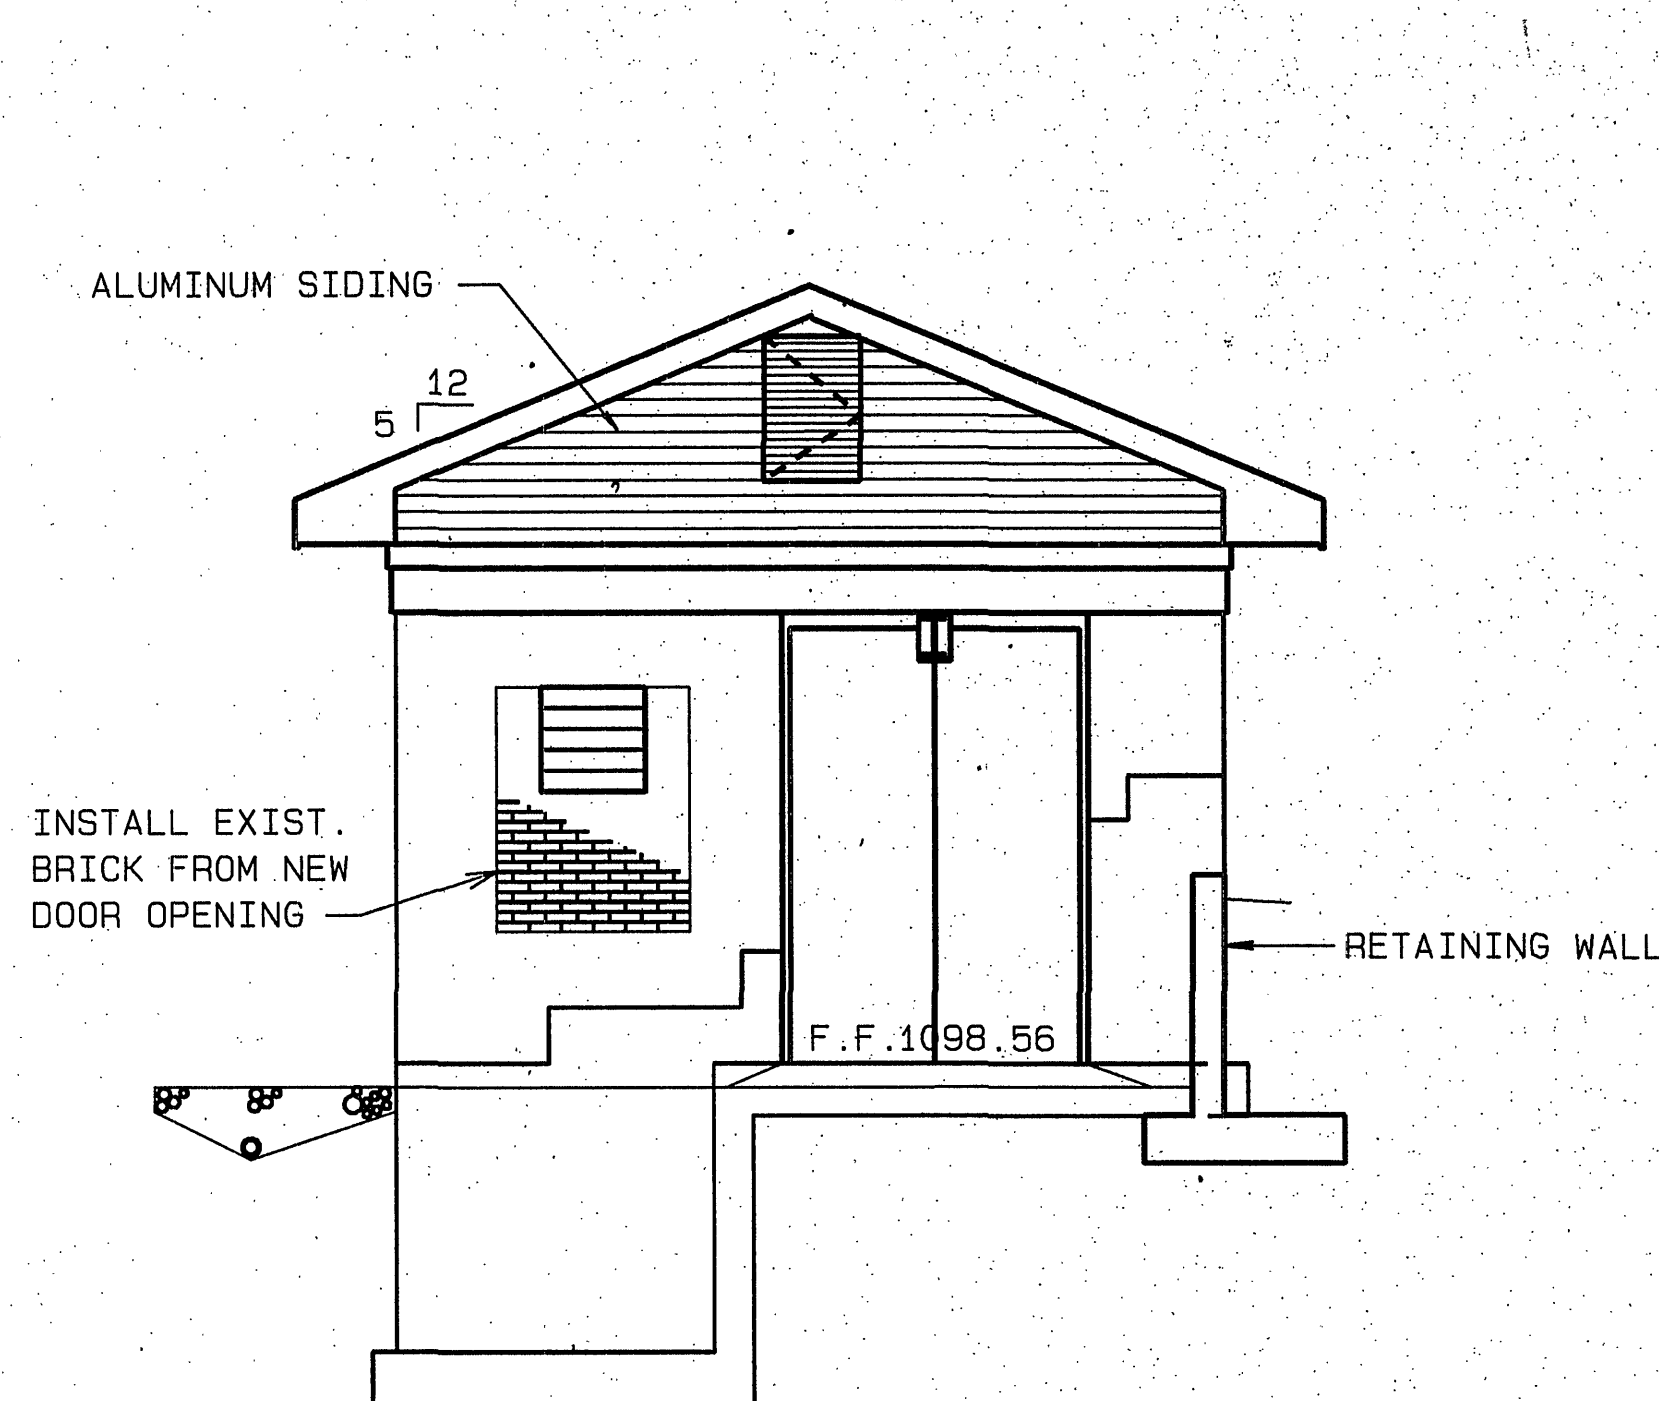

NORTH ELEVATION
SCALE: 1/4"=1'-0"

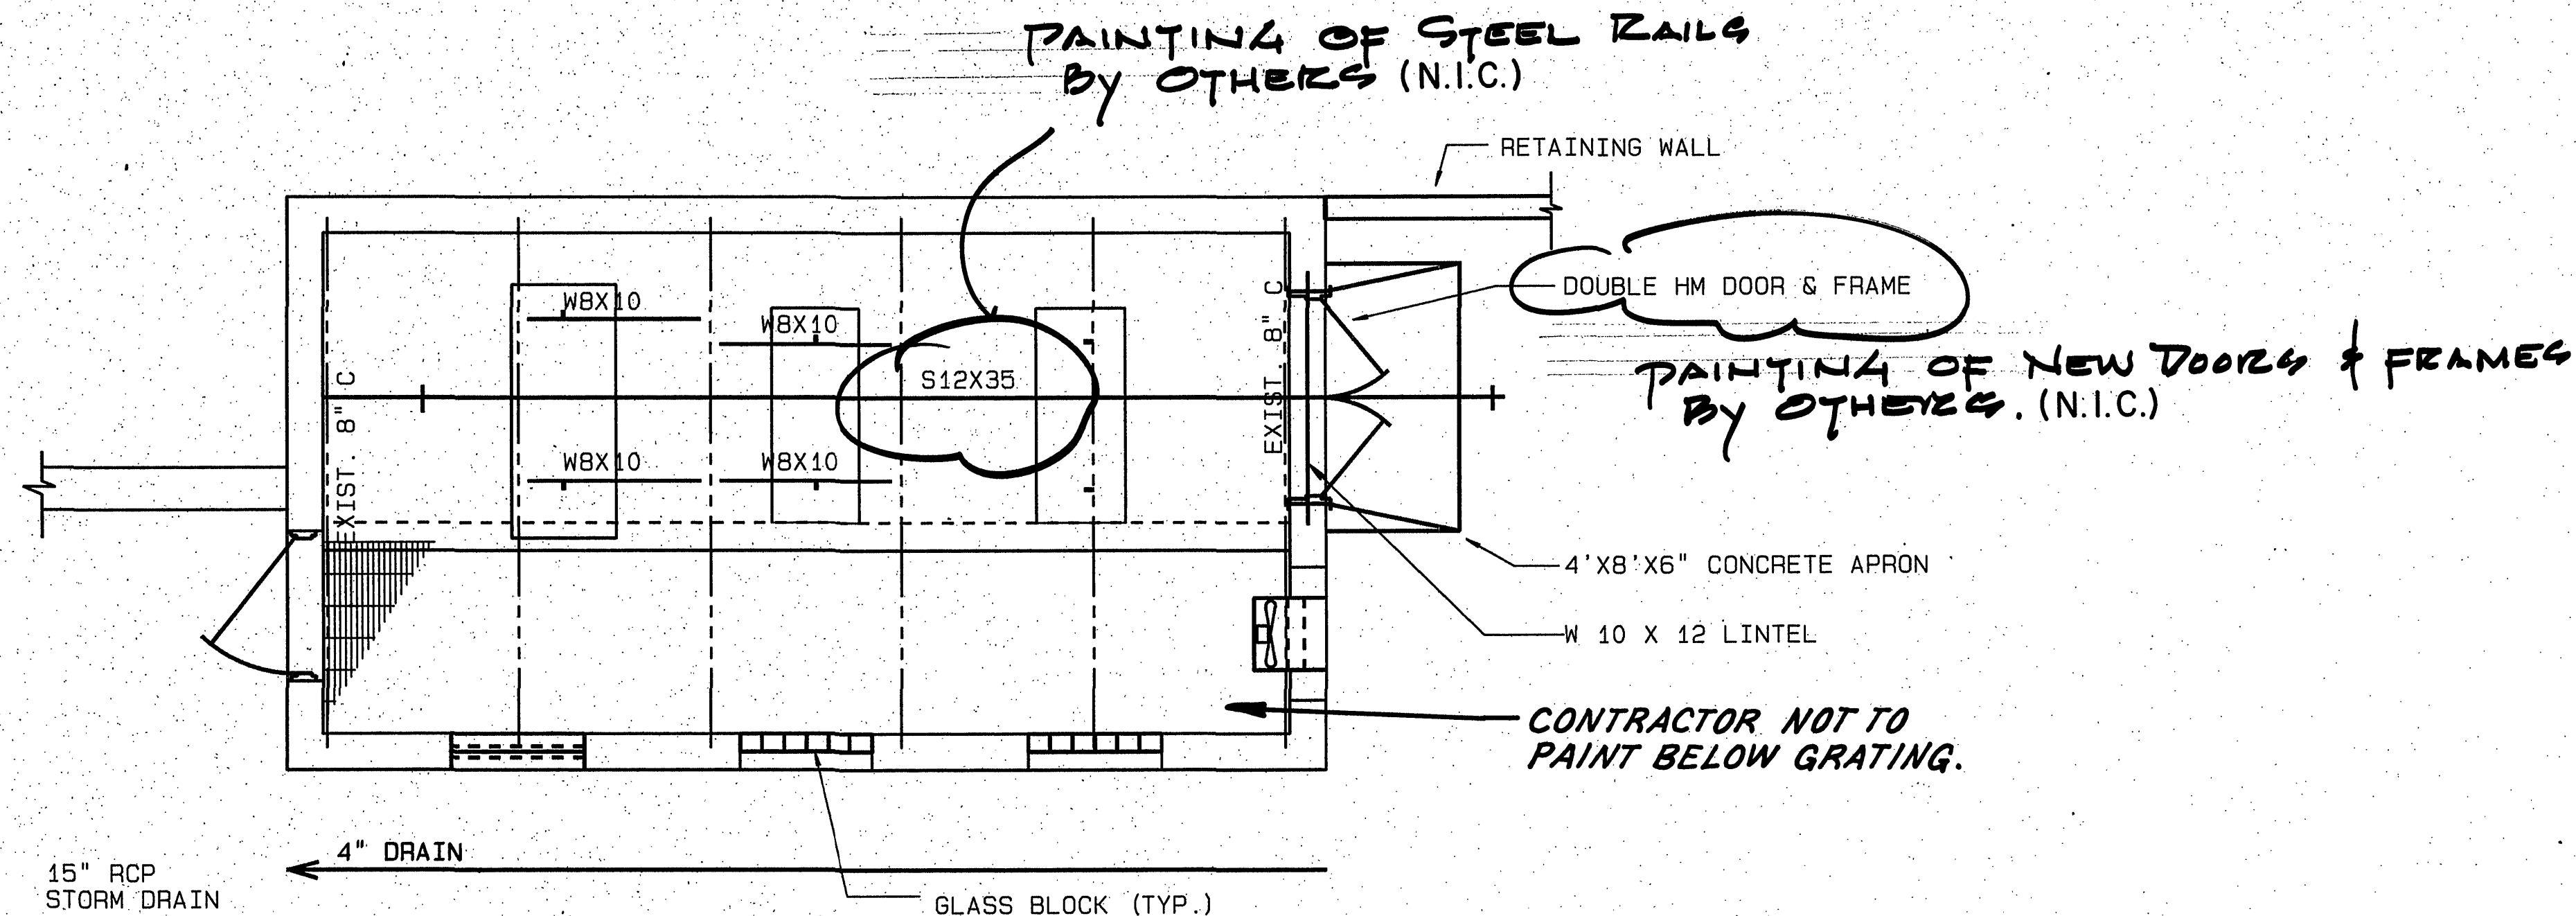

PLAN
SCALE: 1/4"=1'-0"

ALL INTERIOR WALLS (INCLUDING CONDUITS ON WALLS & CEILING, BUT DOES NOT INCLUDE PANELS) SHALL BE CLEANED, PRIMED IF REQUIRED AND PAINTED ONE COAT GLOSS ENAMEL.

CONTRACT BID ITEM 5

MATTERN & CRAIG CONSULTING ENGINEERS • SURVEYORS ROANOKE VIRGINIA	DESIGNED: RFP			REV	DATE	DESCRIPTION	BY	APP.	CARVINS COVE FILTER PLANT IMPROVEMENTS - PHASE I ROANOKE, VIRGINIA	DATE SEPT. 1994
	DRAWN: TAM						DSG	RWB		COMM. NO. 1138C0
ALVORD, BURDICK & HOWSON ENGINEERS CHICAGO	CHECKED: SWH								PAINTING TO EXISTING LOW LIFT PUMP STATION	SHEET
										COII