



- NOTES:
1. ALL CONDUIT SHALL BE SCHEDULE 80 PVC. CONDUIT SHALL BE LISTED TO UL-651.
 2. FLOAT LEVEL SWITCH IS LOCATED 6" ABOVE THE BOTTOM OF SUMP.

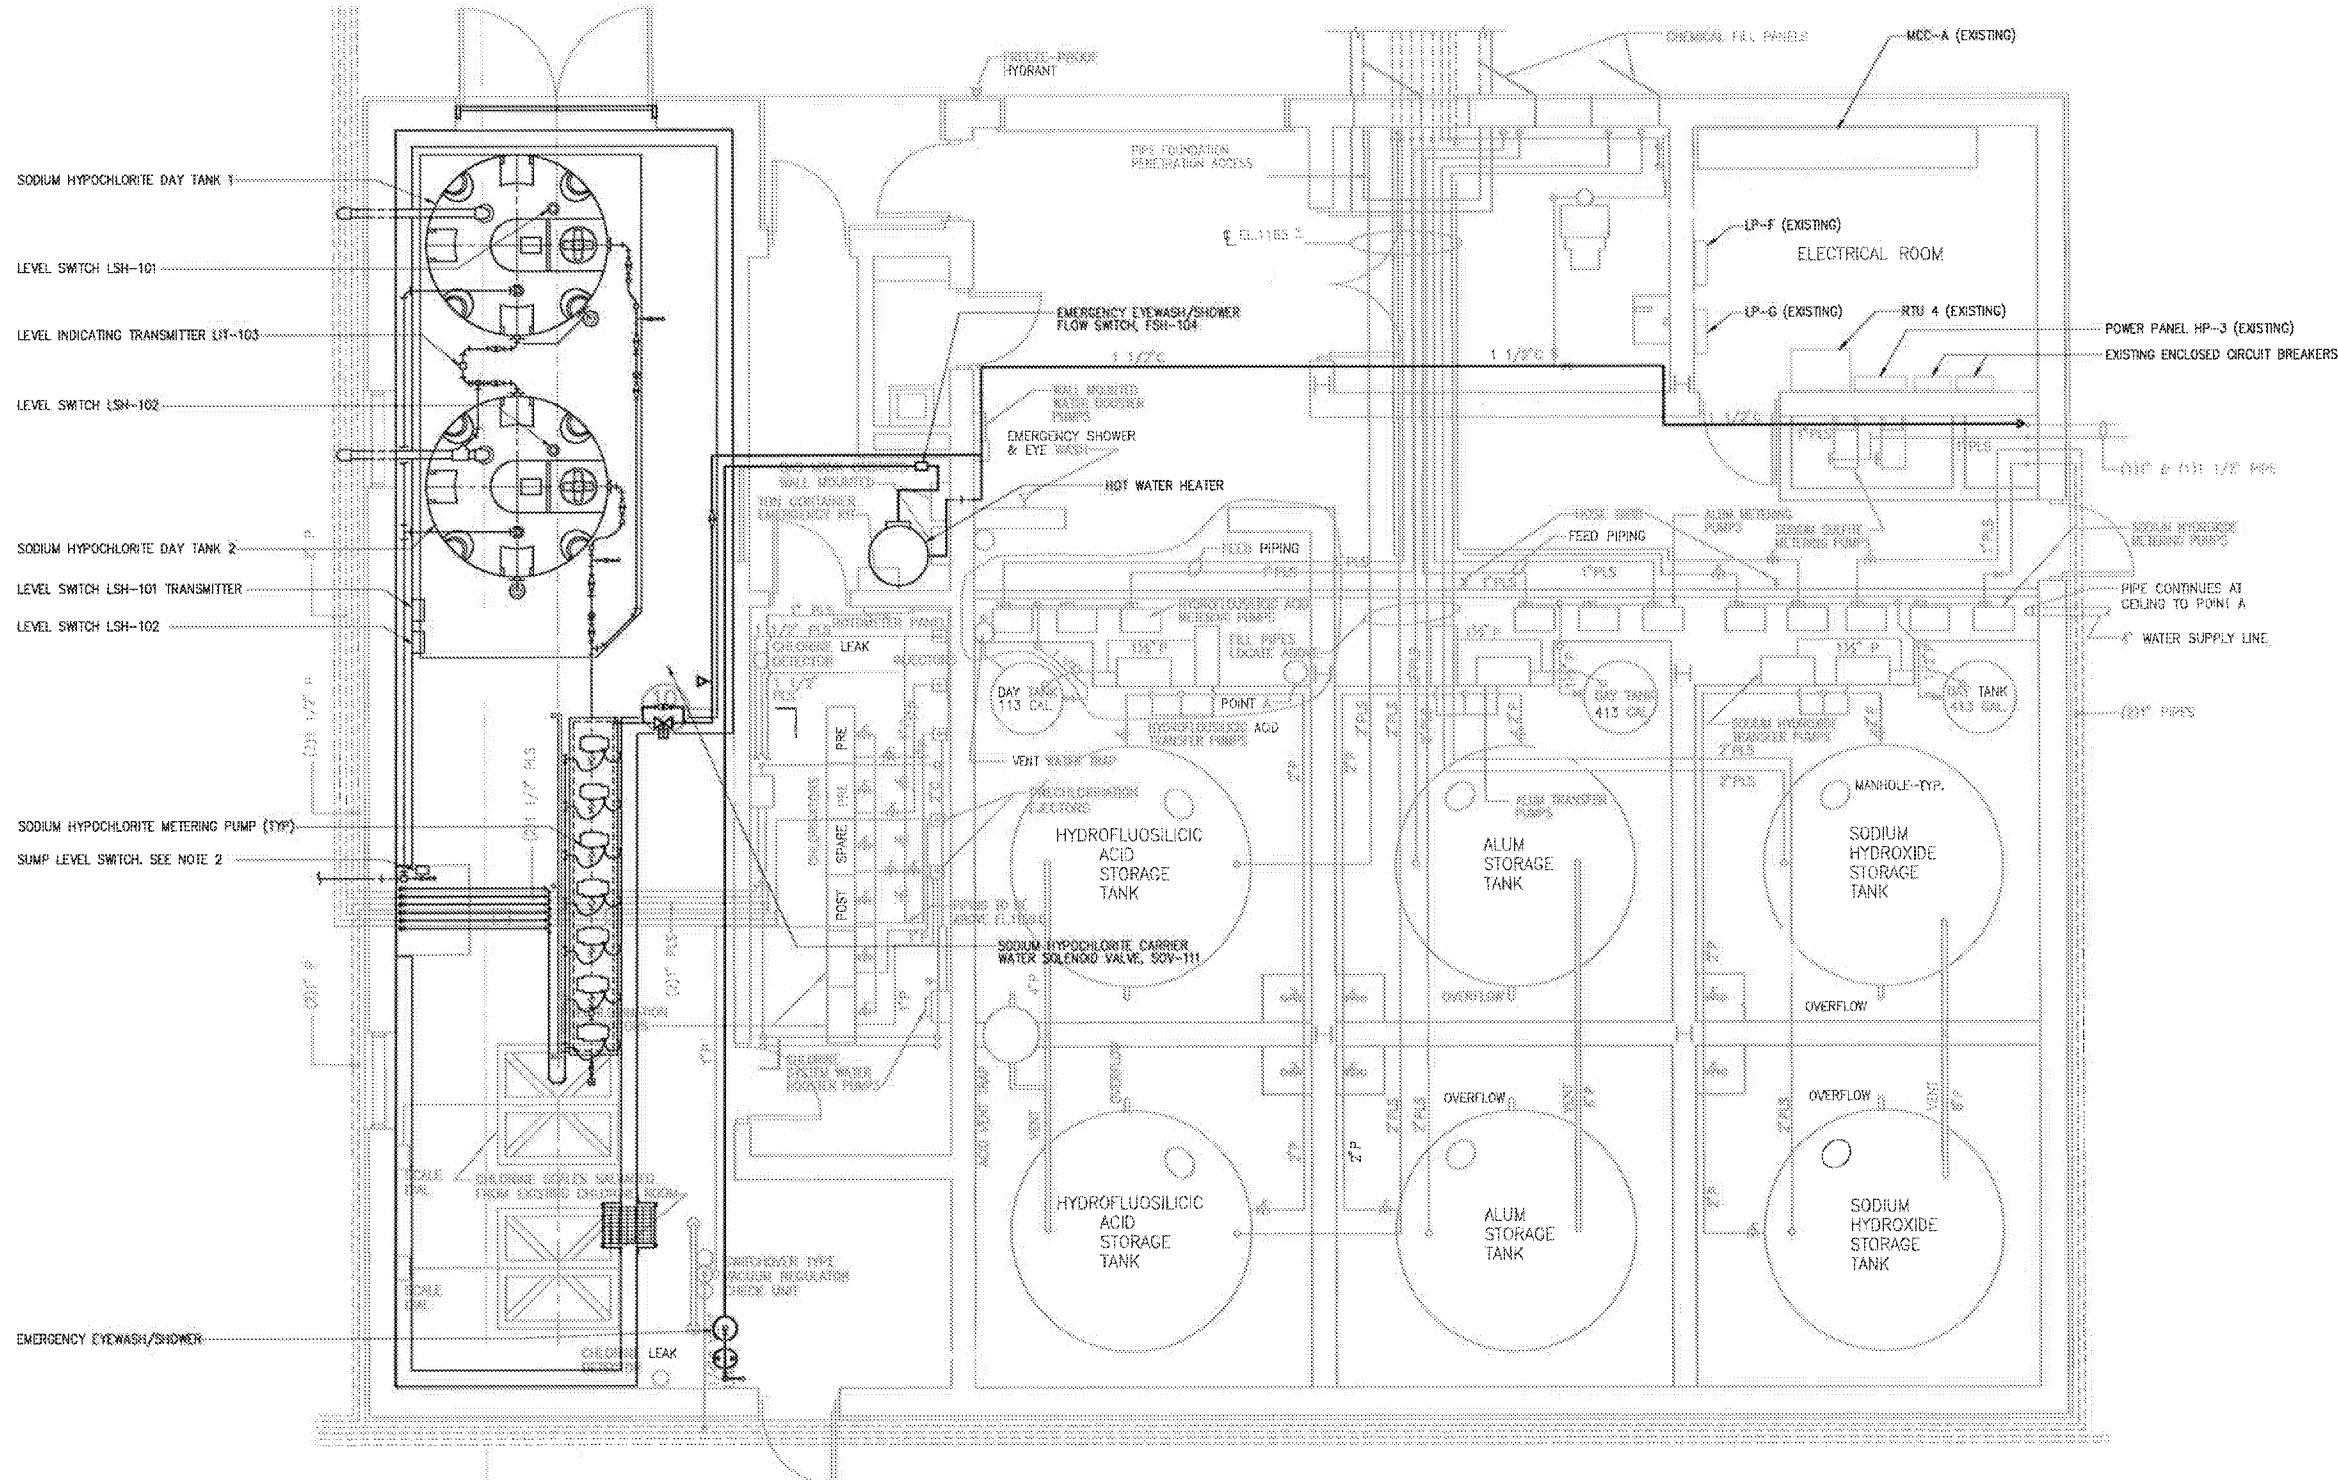

POWER PLAN
1/4"=1'-0"

File: C:\197-00\197-00\Drawings\197-00\197-00.dwg Plot Date: 4/2/2015 8:11 AM
User: JAD
Printer: HP DesignJet 5000

NO.	RECORD DRAWINGS	DATE	BY	APPROVED
2	RECORD DRAWINGS	04/2015	ALS	
1	FINAL DESIGN	09/2014	ALS	

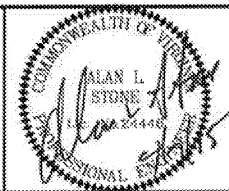

RECORD DRAWING
THIS DRAWING HAS BEEN MODIFIED TO REFLECT FIELD CHANGES REPORTED BY THE CONTRACTOR OR ANOTHER PARTY, BUT NOT VERIFIED BY THE CERTIFYING ENGINEER.

THIS DOCUMENT ORIGINALLY ISSUED FOR CONSTRUCTION AND SEALED BY JASON A. DAVIS, LIC NUMBER 052009

HAZEN AND SAWYER
Environmental Engineers & Scientists
4011 WestChase Boulevard, Suite 500
Raleigh, North Carolina 27607
License No. : C-0381

WESTERN VIRGINIA WATER AUTHORITY
ROANOKE, VIRGINIA

CARVINS COVE WATER TREATMENT FACILITY
DISINFECTION IMPROVEMENTS

ELECTRICAL
CHEMICAL BUILDING 1 POWER PLAN

THE SCALE BAR SHOWN BELOW MEASURES ONE INCH LONG ON THE ORIGINAL DRAWING.	DATE OCTOBER 2014	H&S JOB NUMBER 31197-000
	CONTRACT NUMBER 1	DRAWING NUMBER E100

RECORD DRAWINGS