


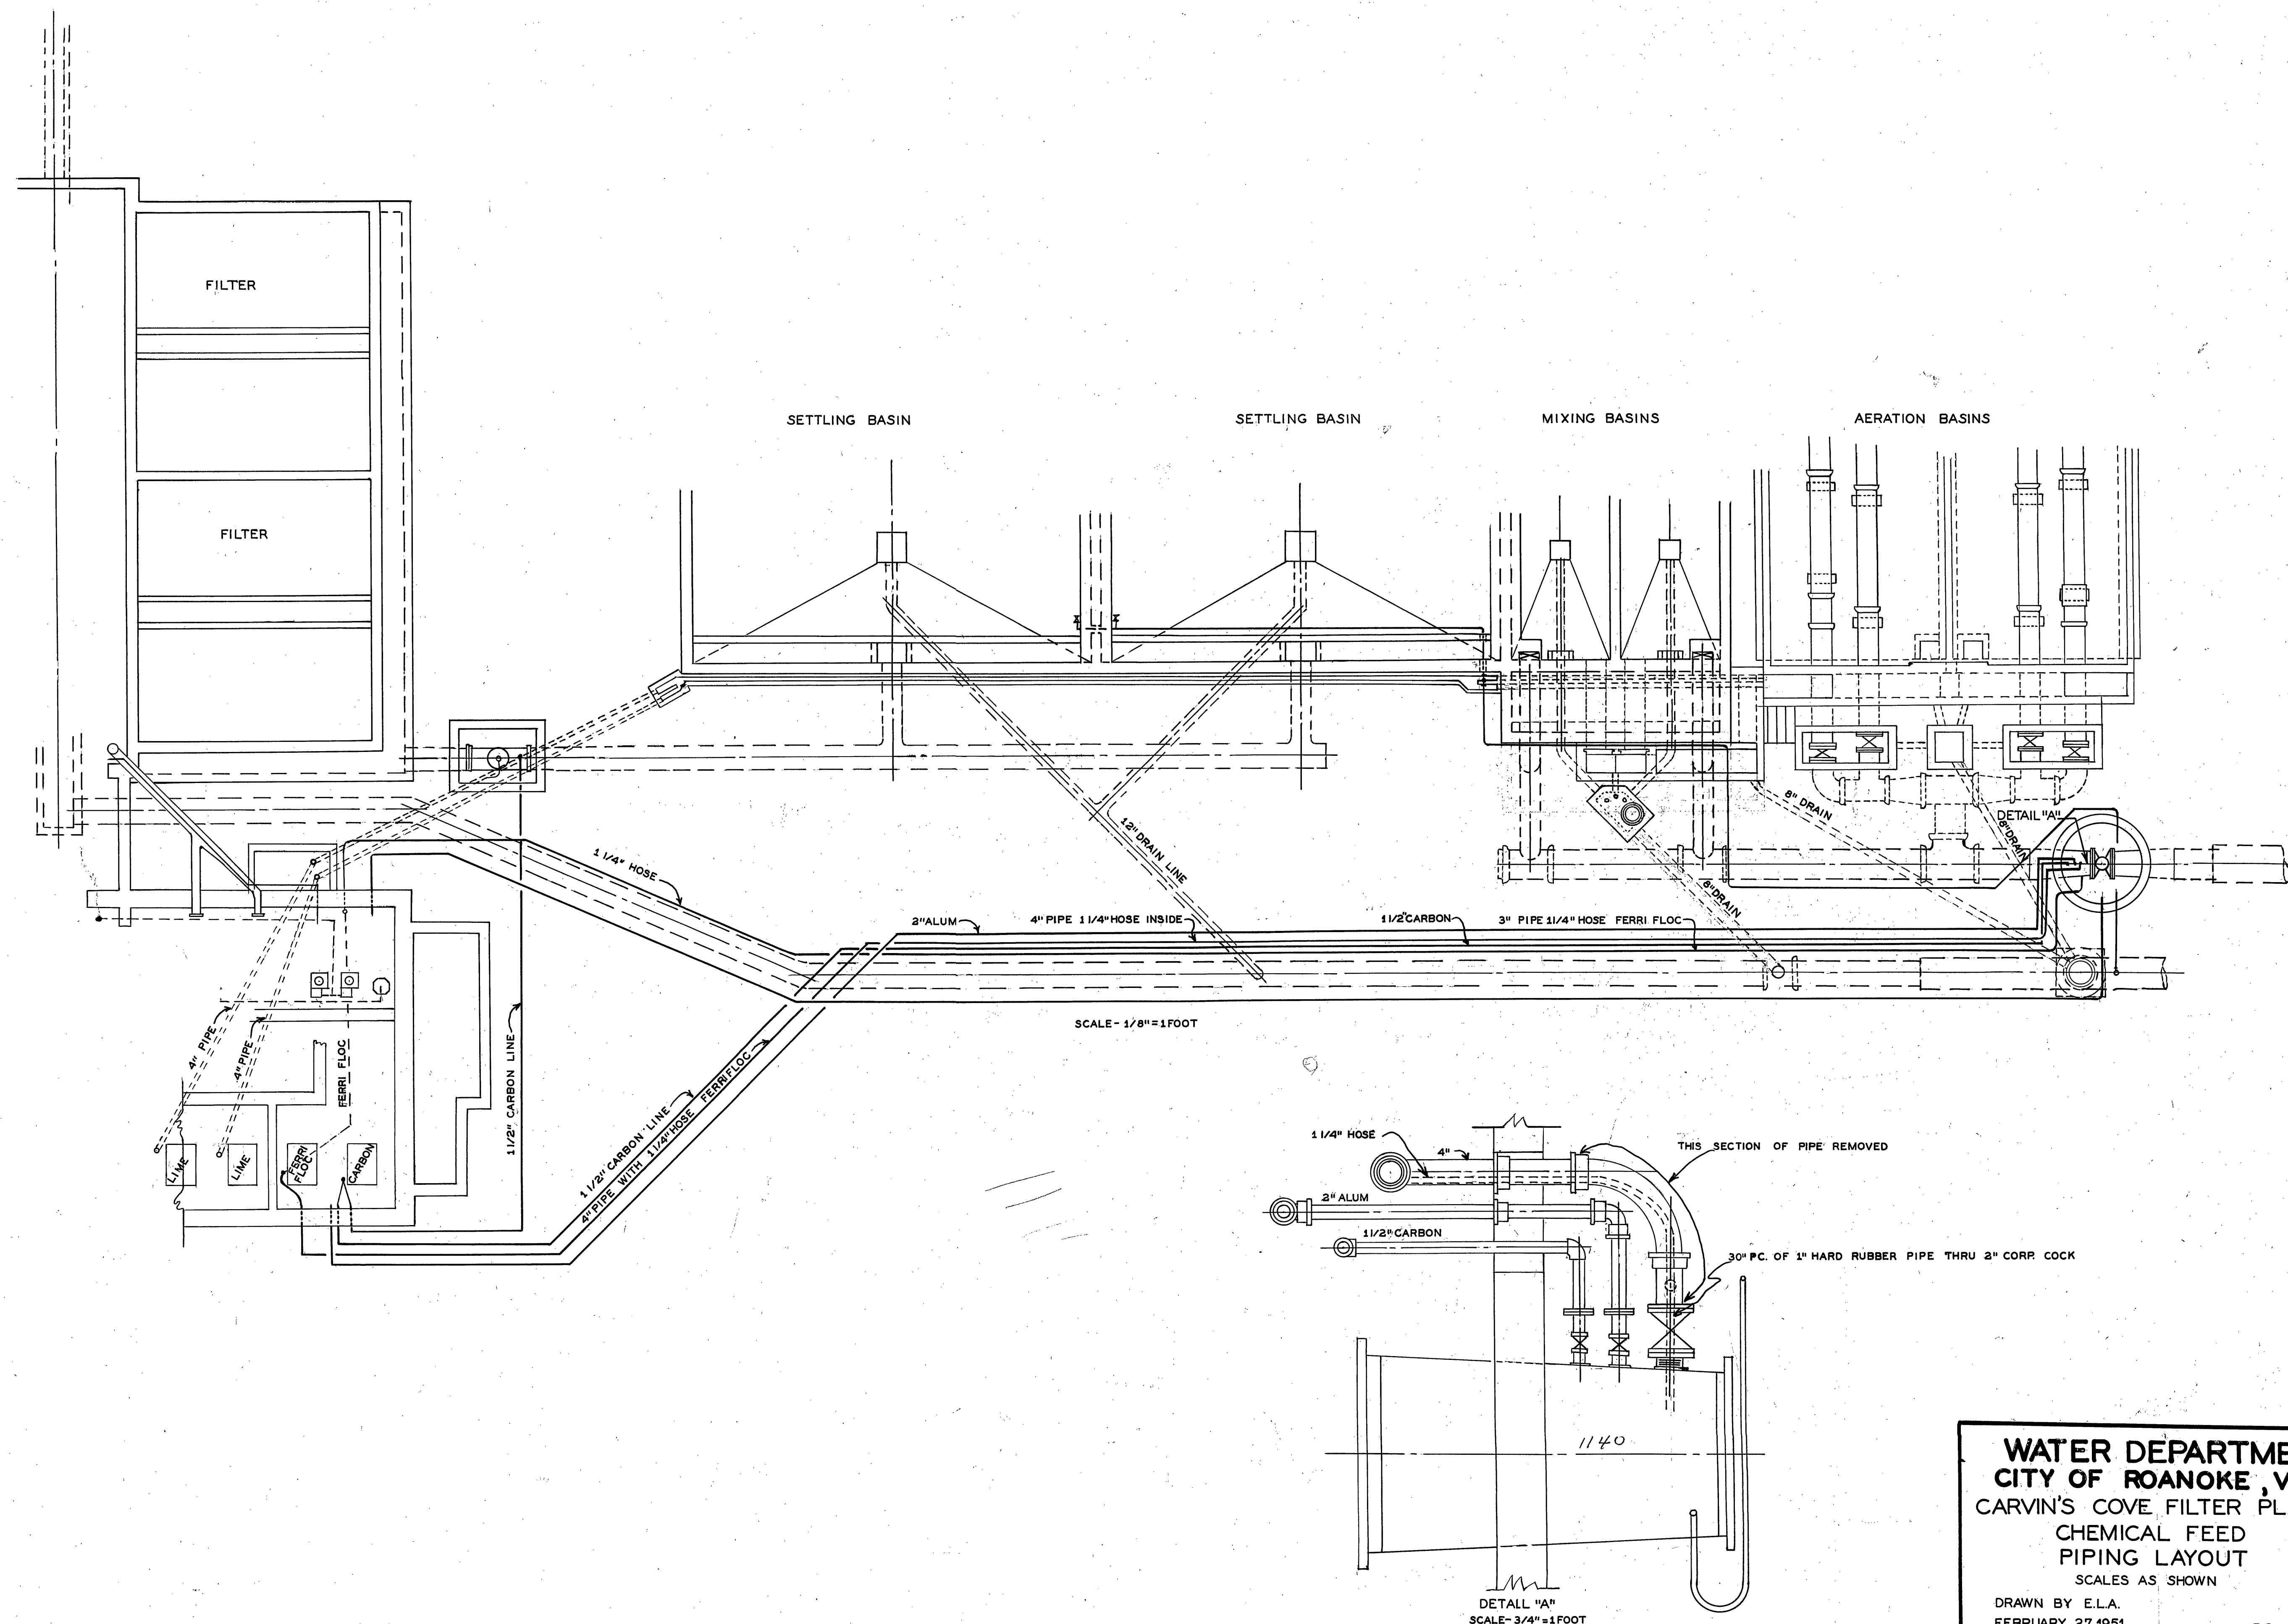

WATER DEPARTMENT
CITY OF ROANOKE, VA.
 CARVIN'S COVE FILTER PLANT
 CHEMICAL FEED
 PIPING LAYOUT
 SCALES AS SHOWN

DRAWN BY E.L.A.
 FEBRUARY, 27, 1951