


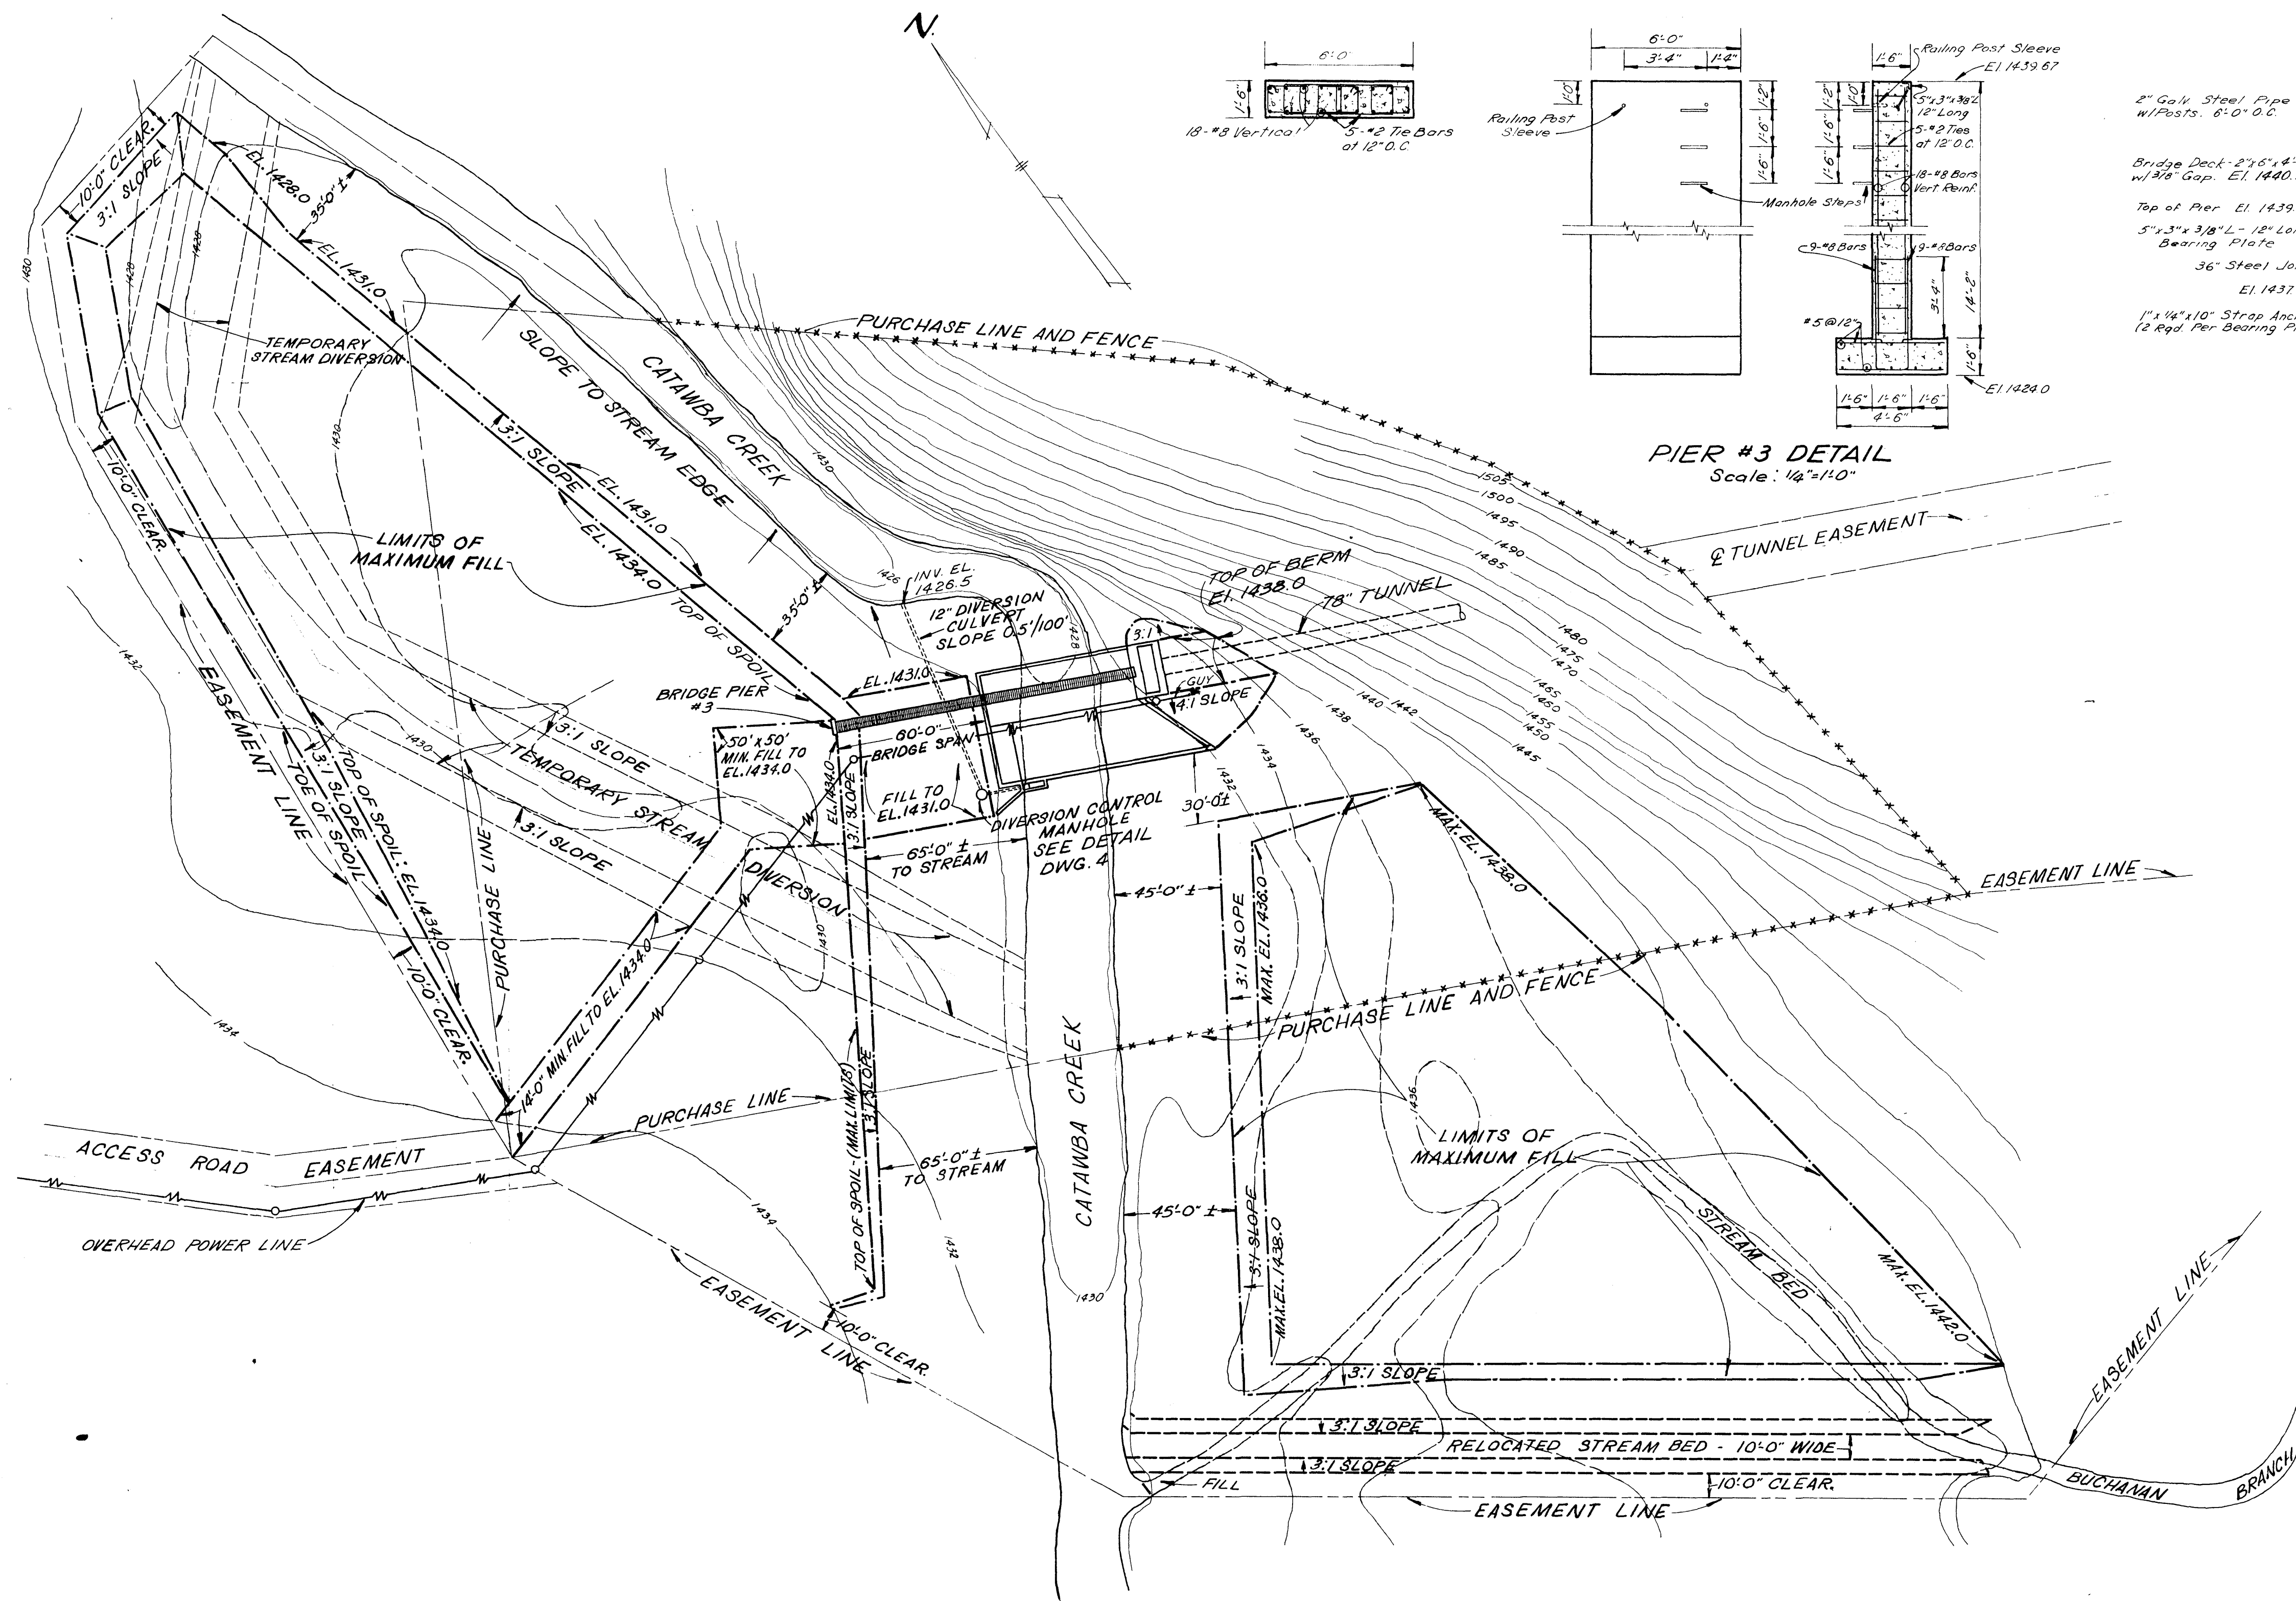
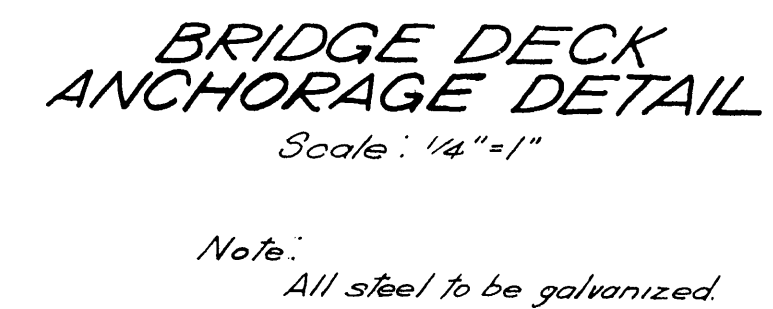
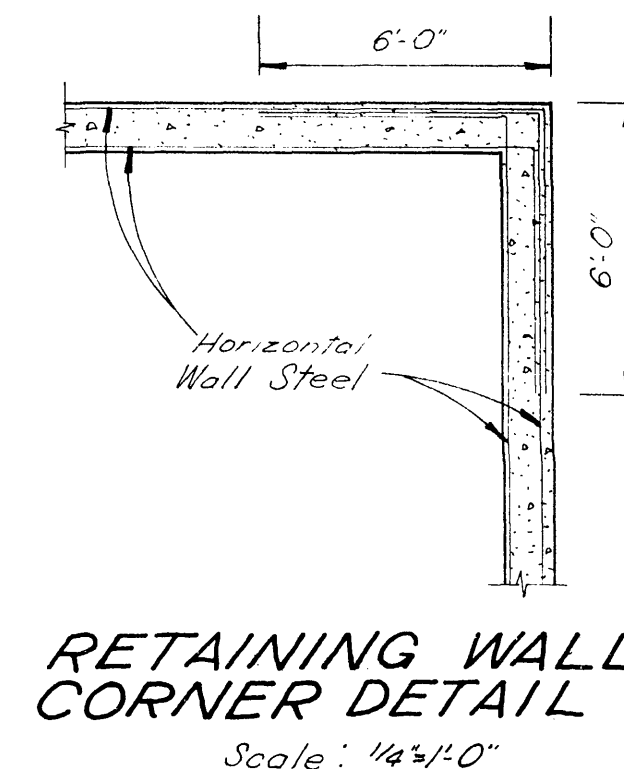
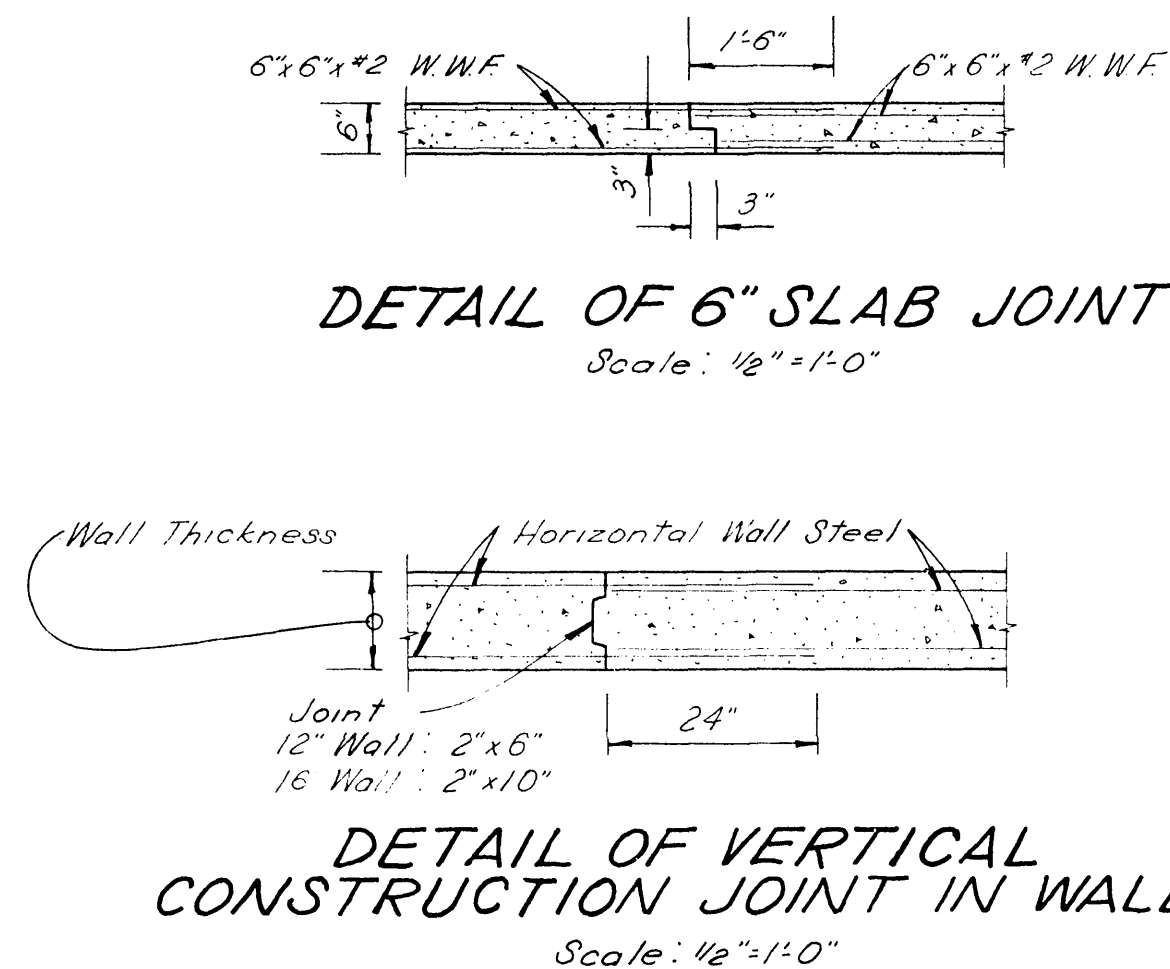


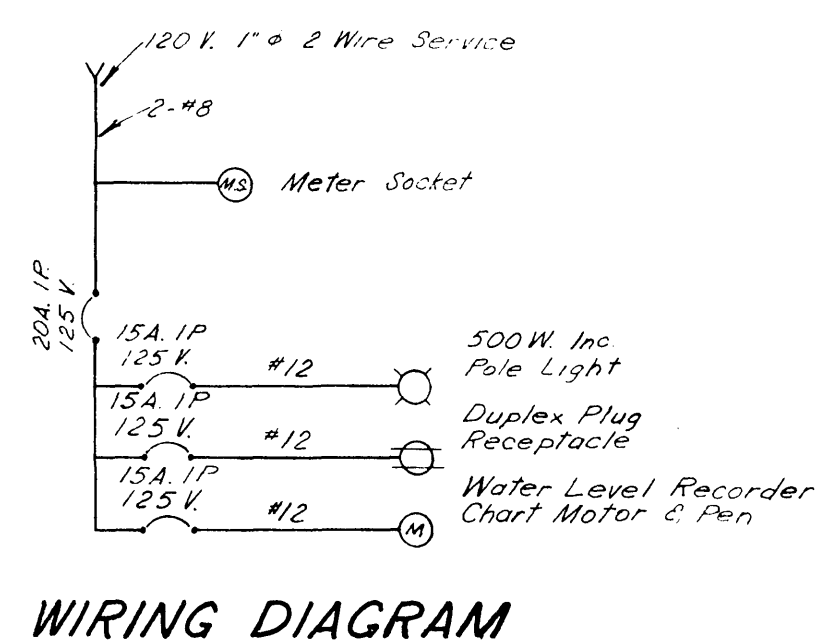






STREAM DIVERSION AND TUNNEL SPOIL FILL AREA PLAN
SCALE: 1"=40'

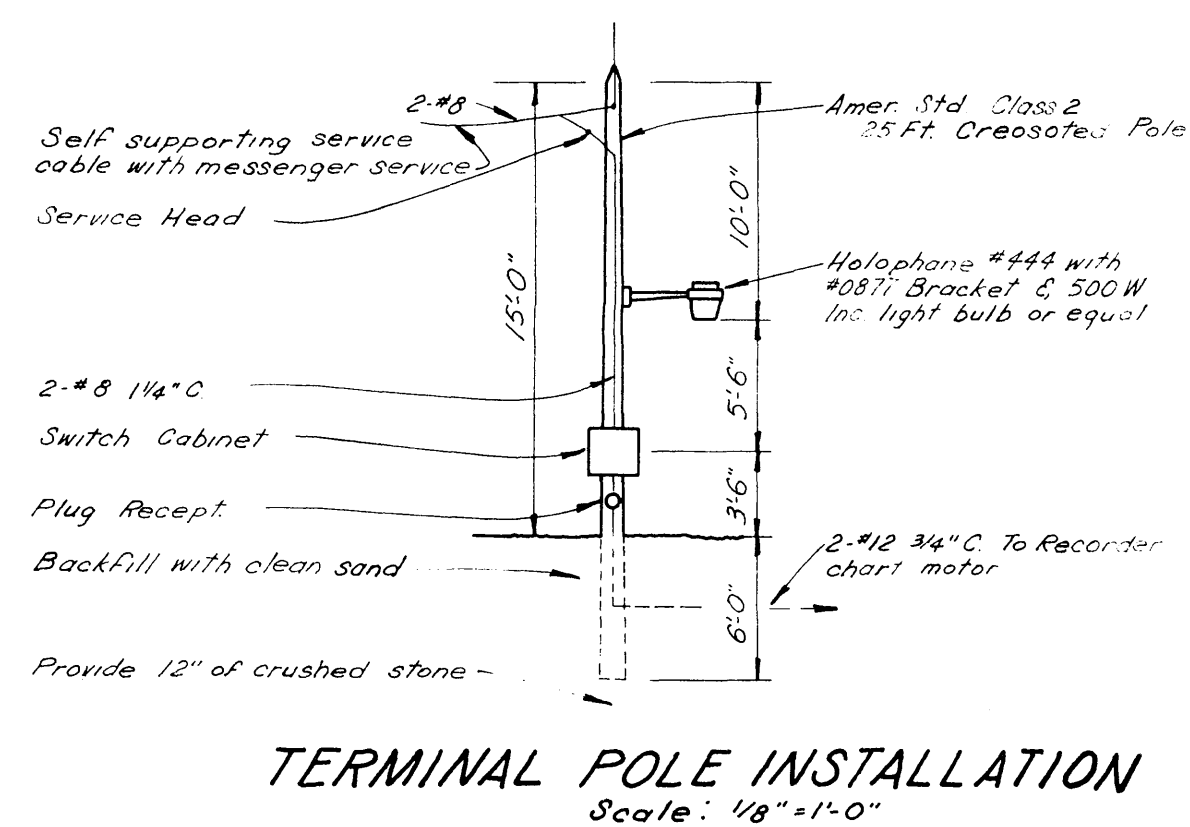

DETAIL PIER #1
Scale: 1/4"=1'-0"

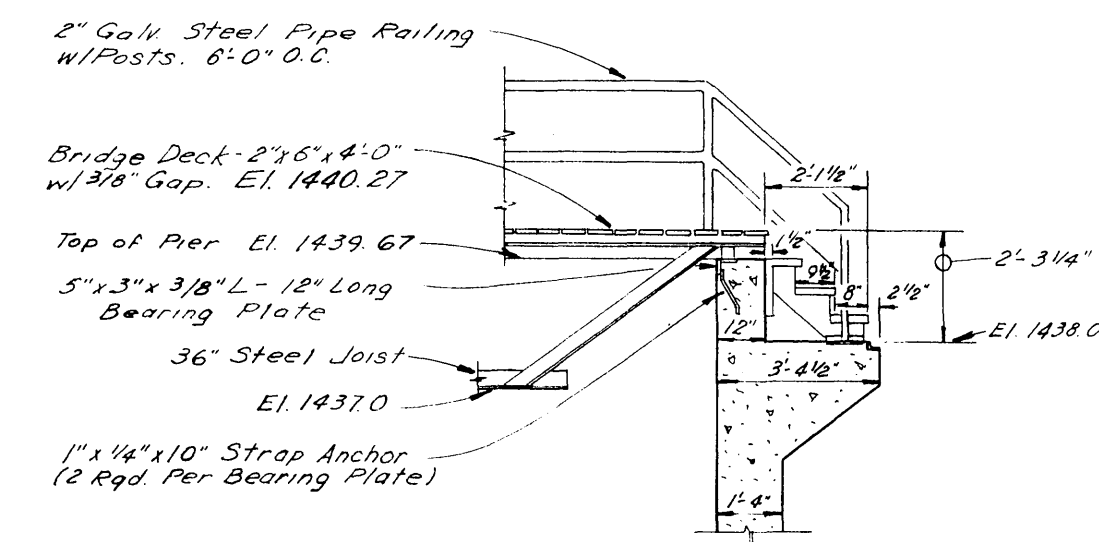

DETAIL PIER #3
Scale: 1/4"=1'-0"

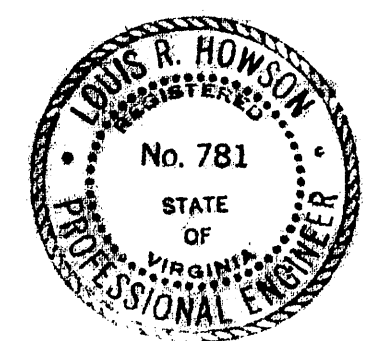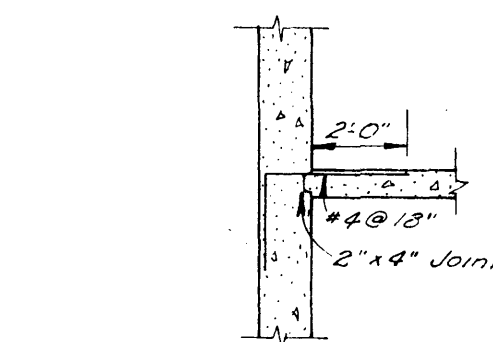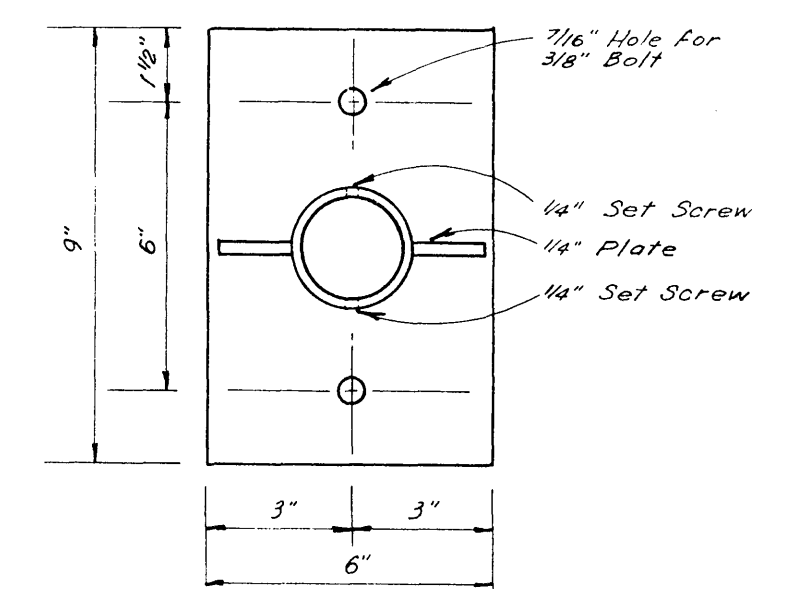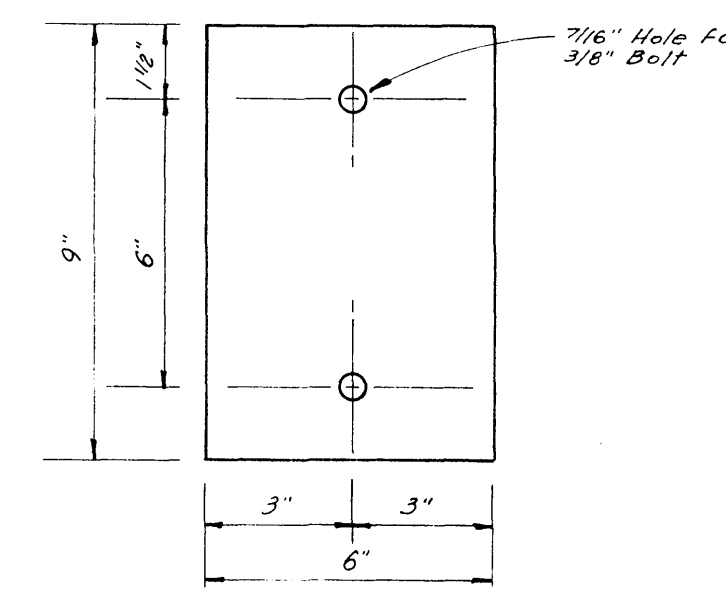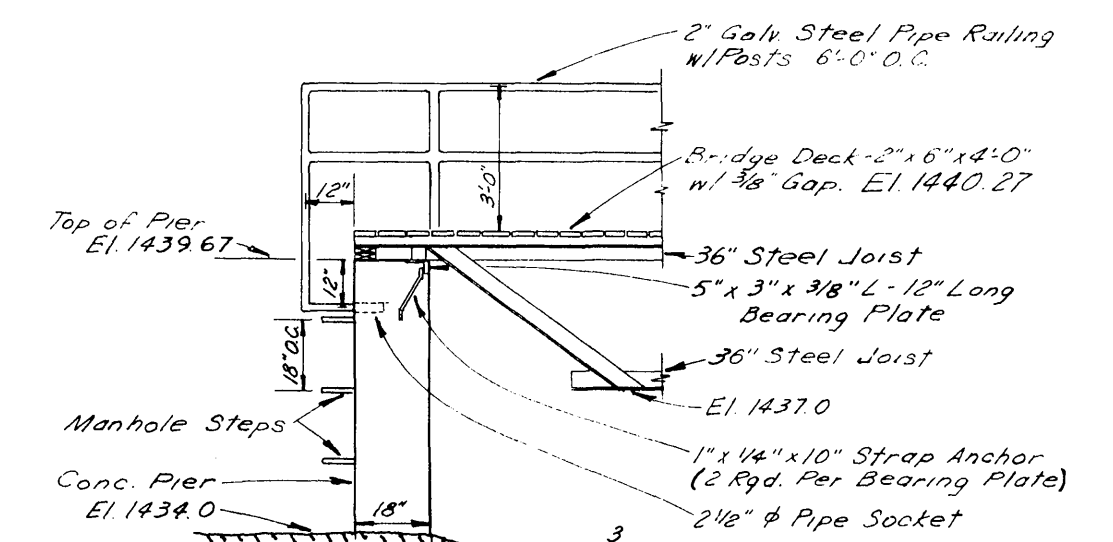

**CATAWBA CREEK
DIVERSION PROJECT
INTAKE STRUCTURE
GRADING PLAN
& BRIDGE DETAILS**
CITY OF ROANOKE WATER DEPT.
ROANOKE, VIRGINIA

ALYORD BURDICK & HOWSON
ENGINEERS CHICAGO
1970

3