



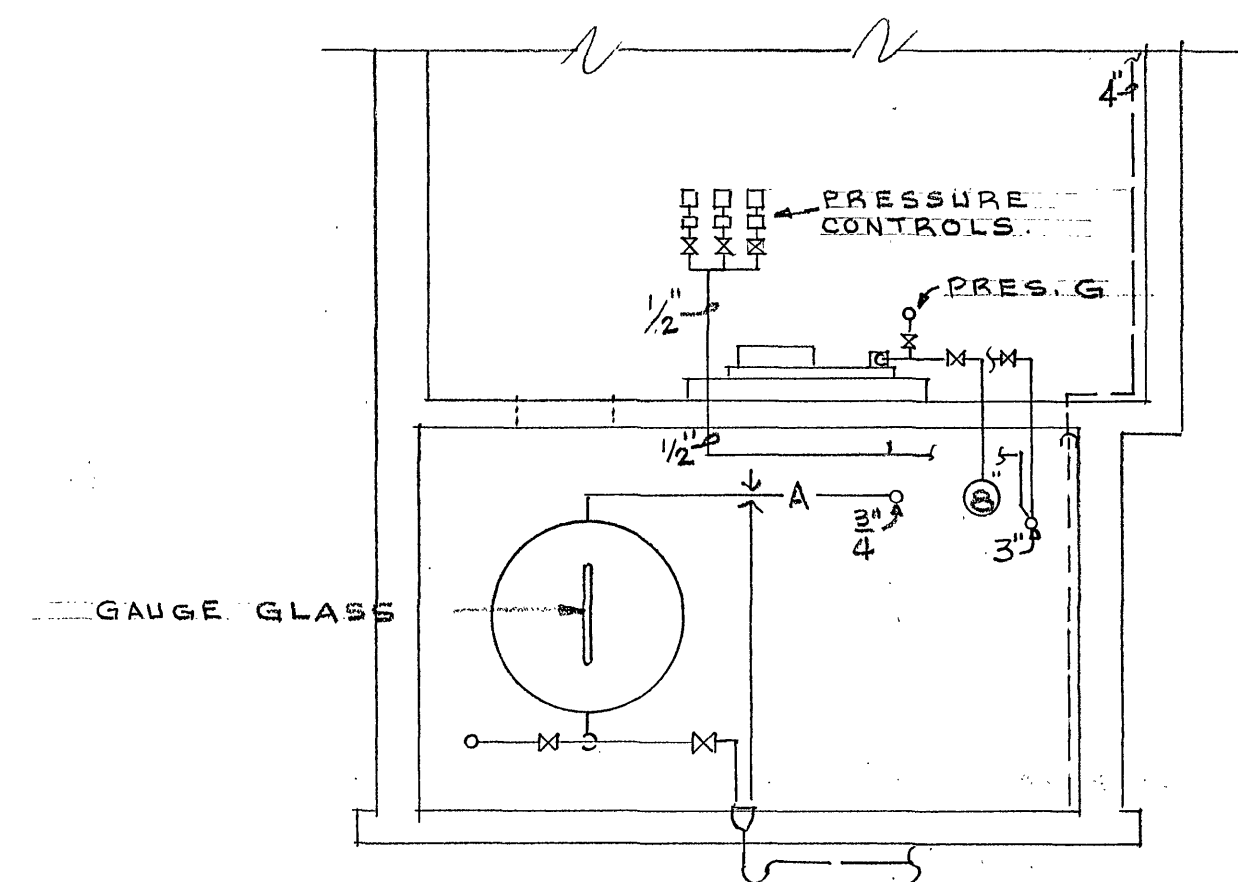


SECTION A-A
SCALE: 1/4" = 1'-0"

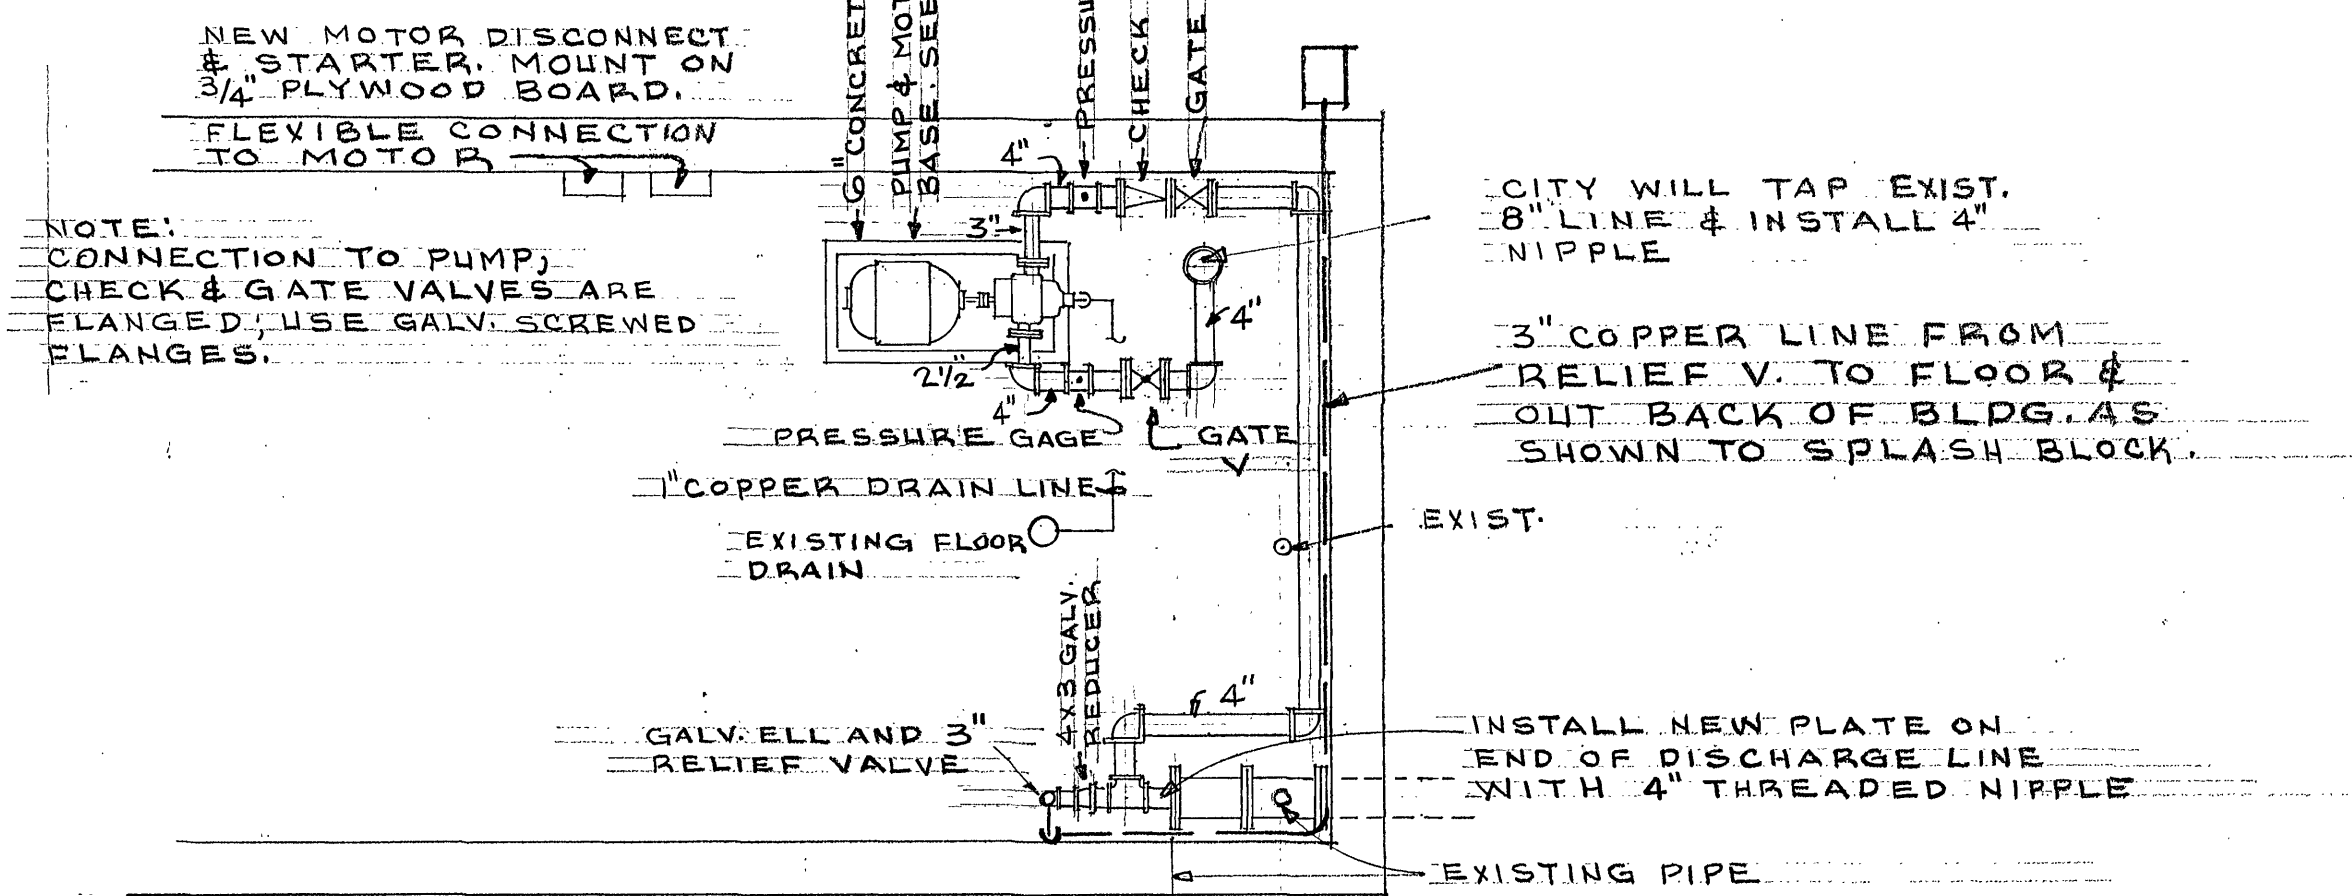


PARTIAL GROUND FLOOR PLAN
SCALE: 1/4" = 1'-0"


PIPING FOR PUMP AND MOTOR DIAGRAMATIC ONLY.
LOCATE PUMP AND MOTOR AS NEAR 8" LINE AS POSSIBLE.

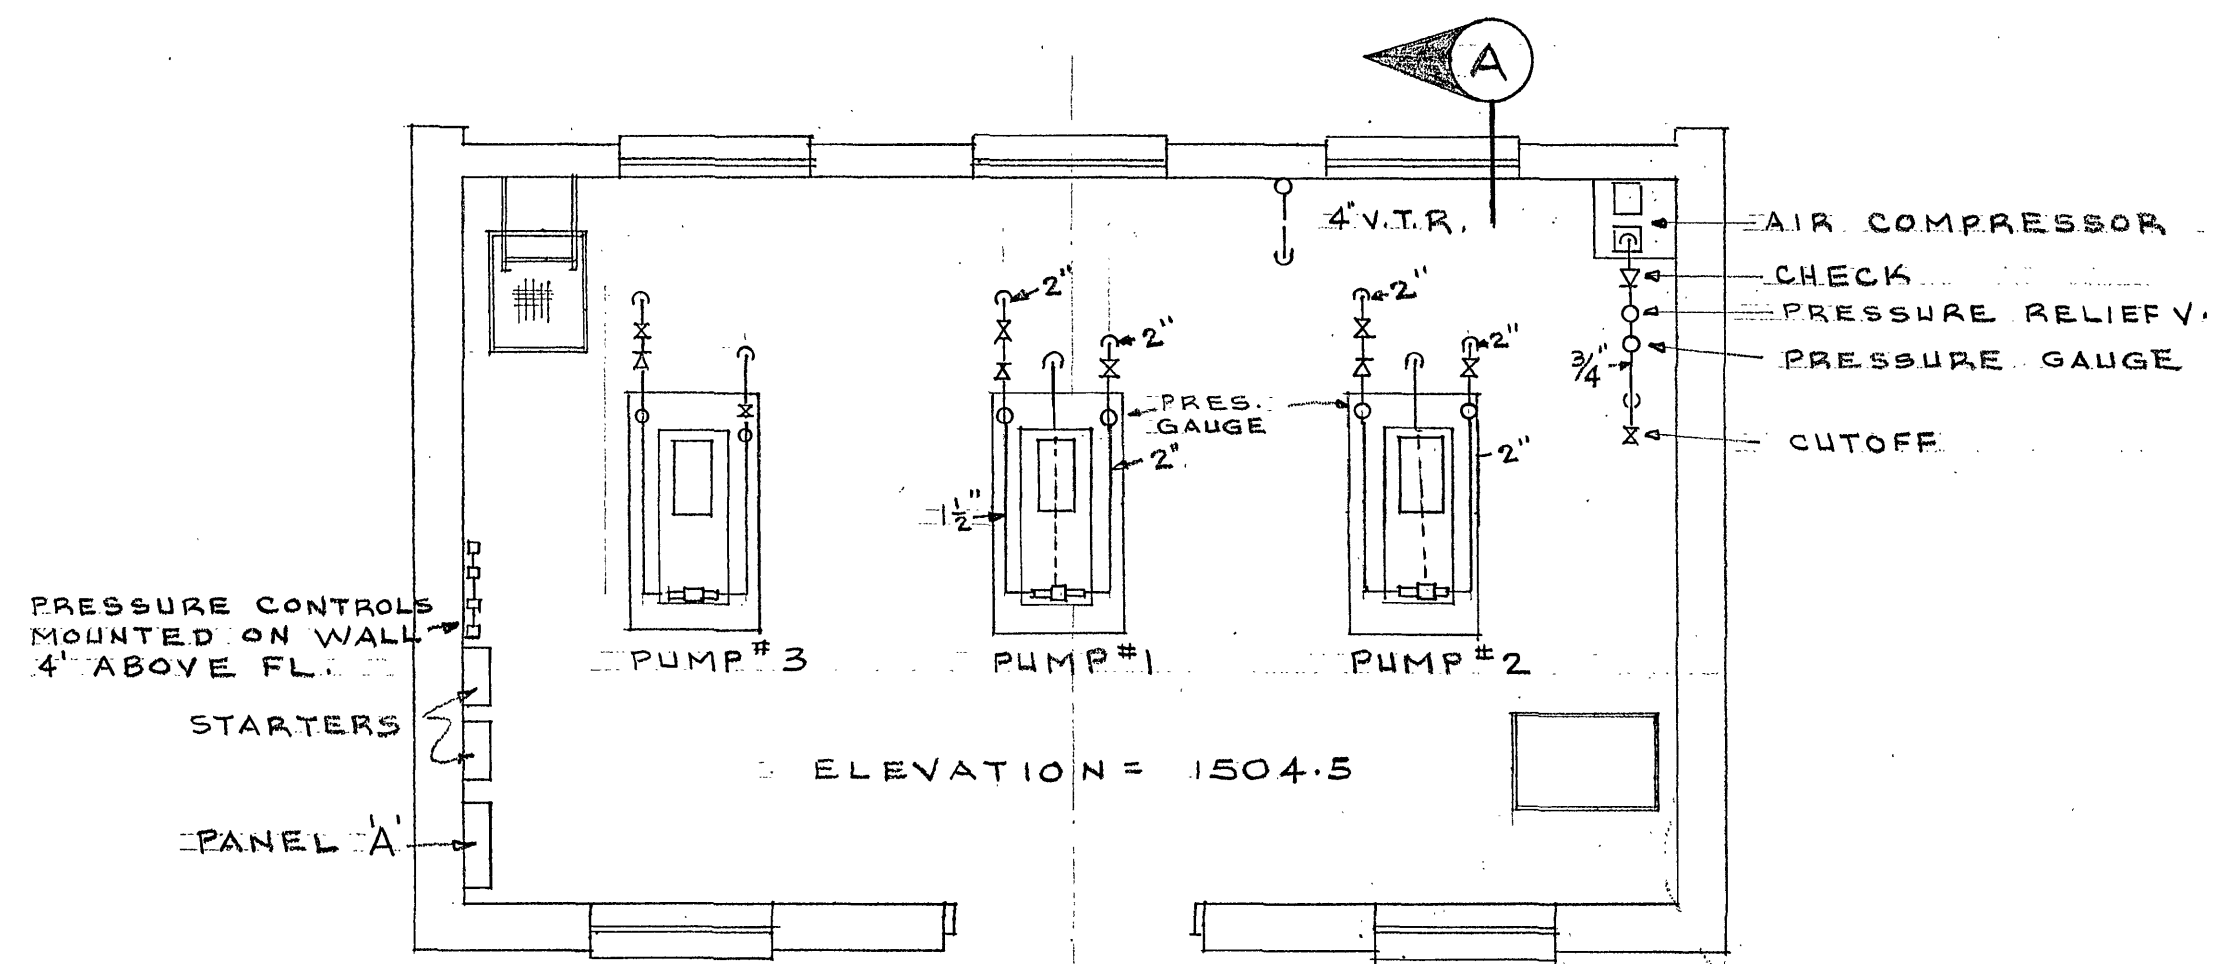

PLUMBING
FIRST FLOOR PLAN
SCALE: 1/4" = 1'-0"

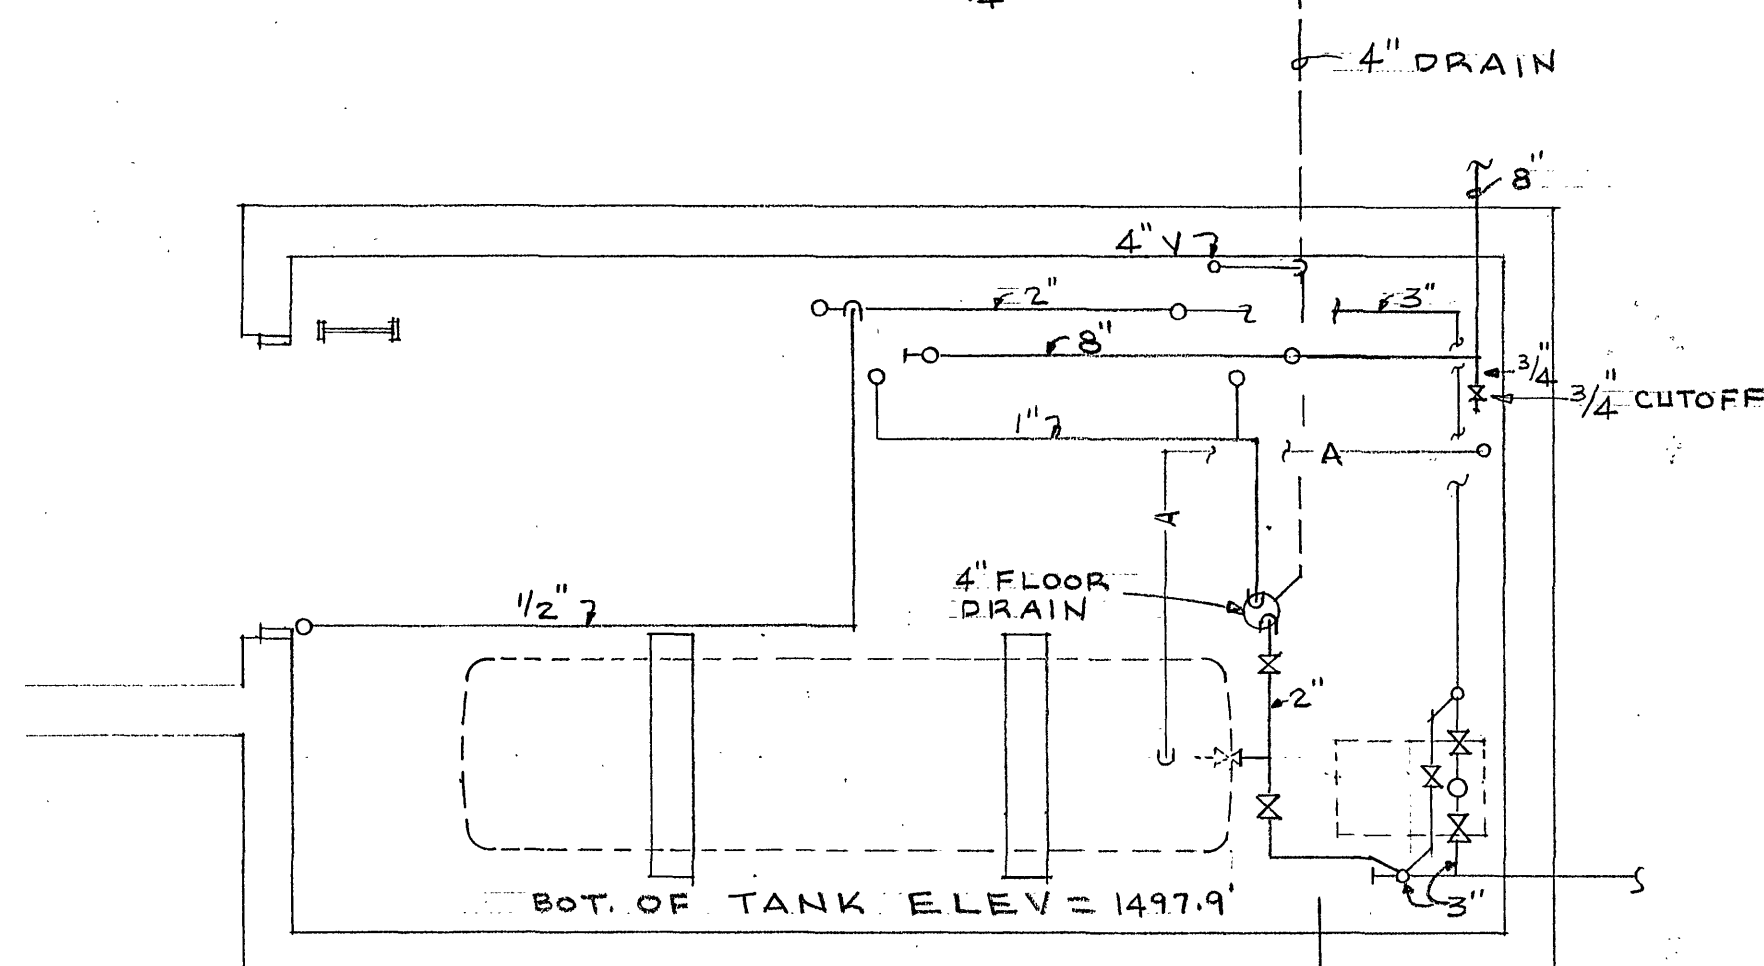

PLUMBING
GROUND FLOOR PLAN
SCALE: 1/4" = 1'-0"

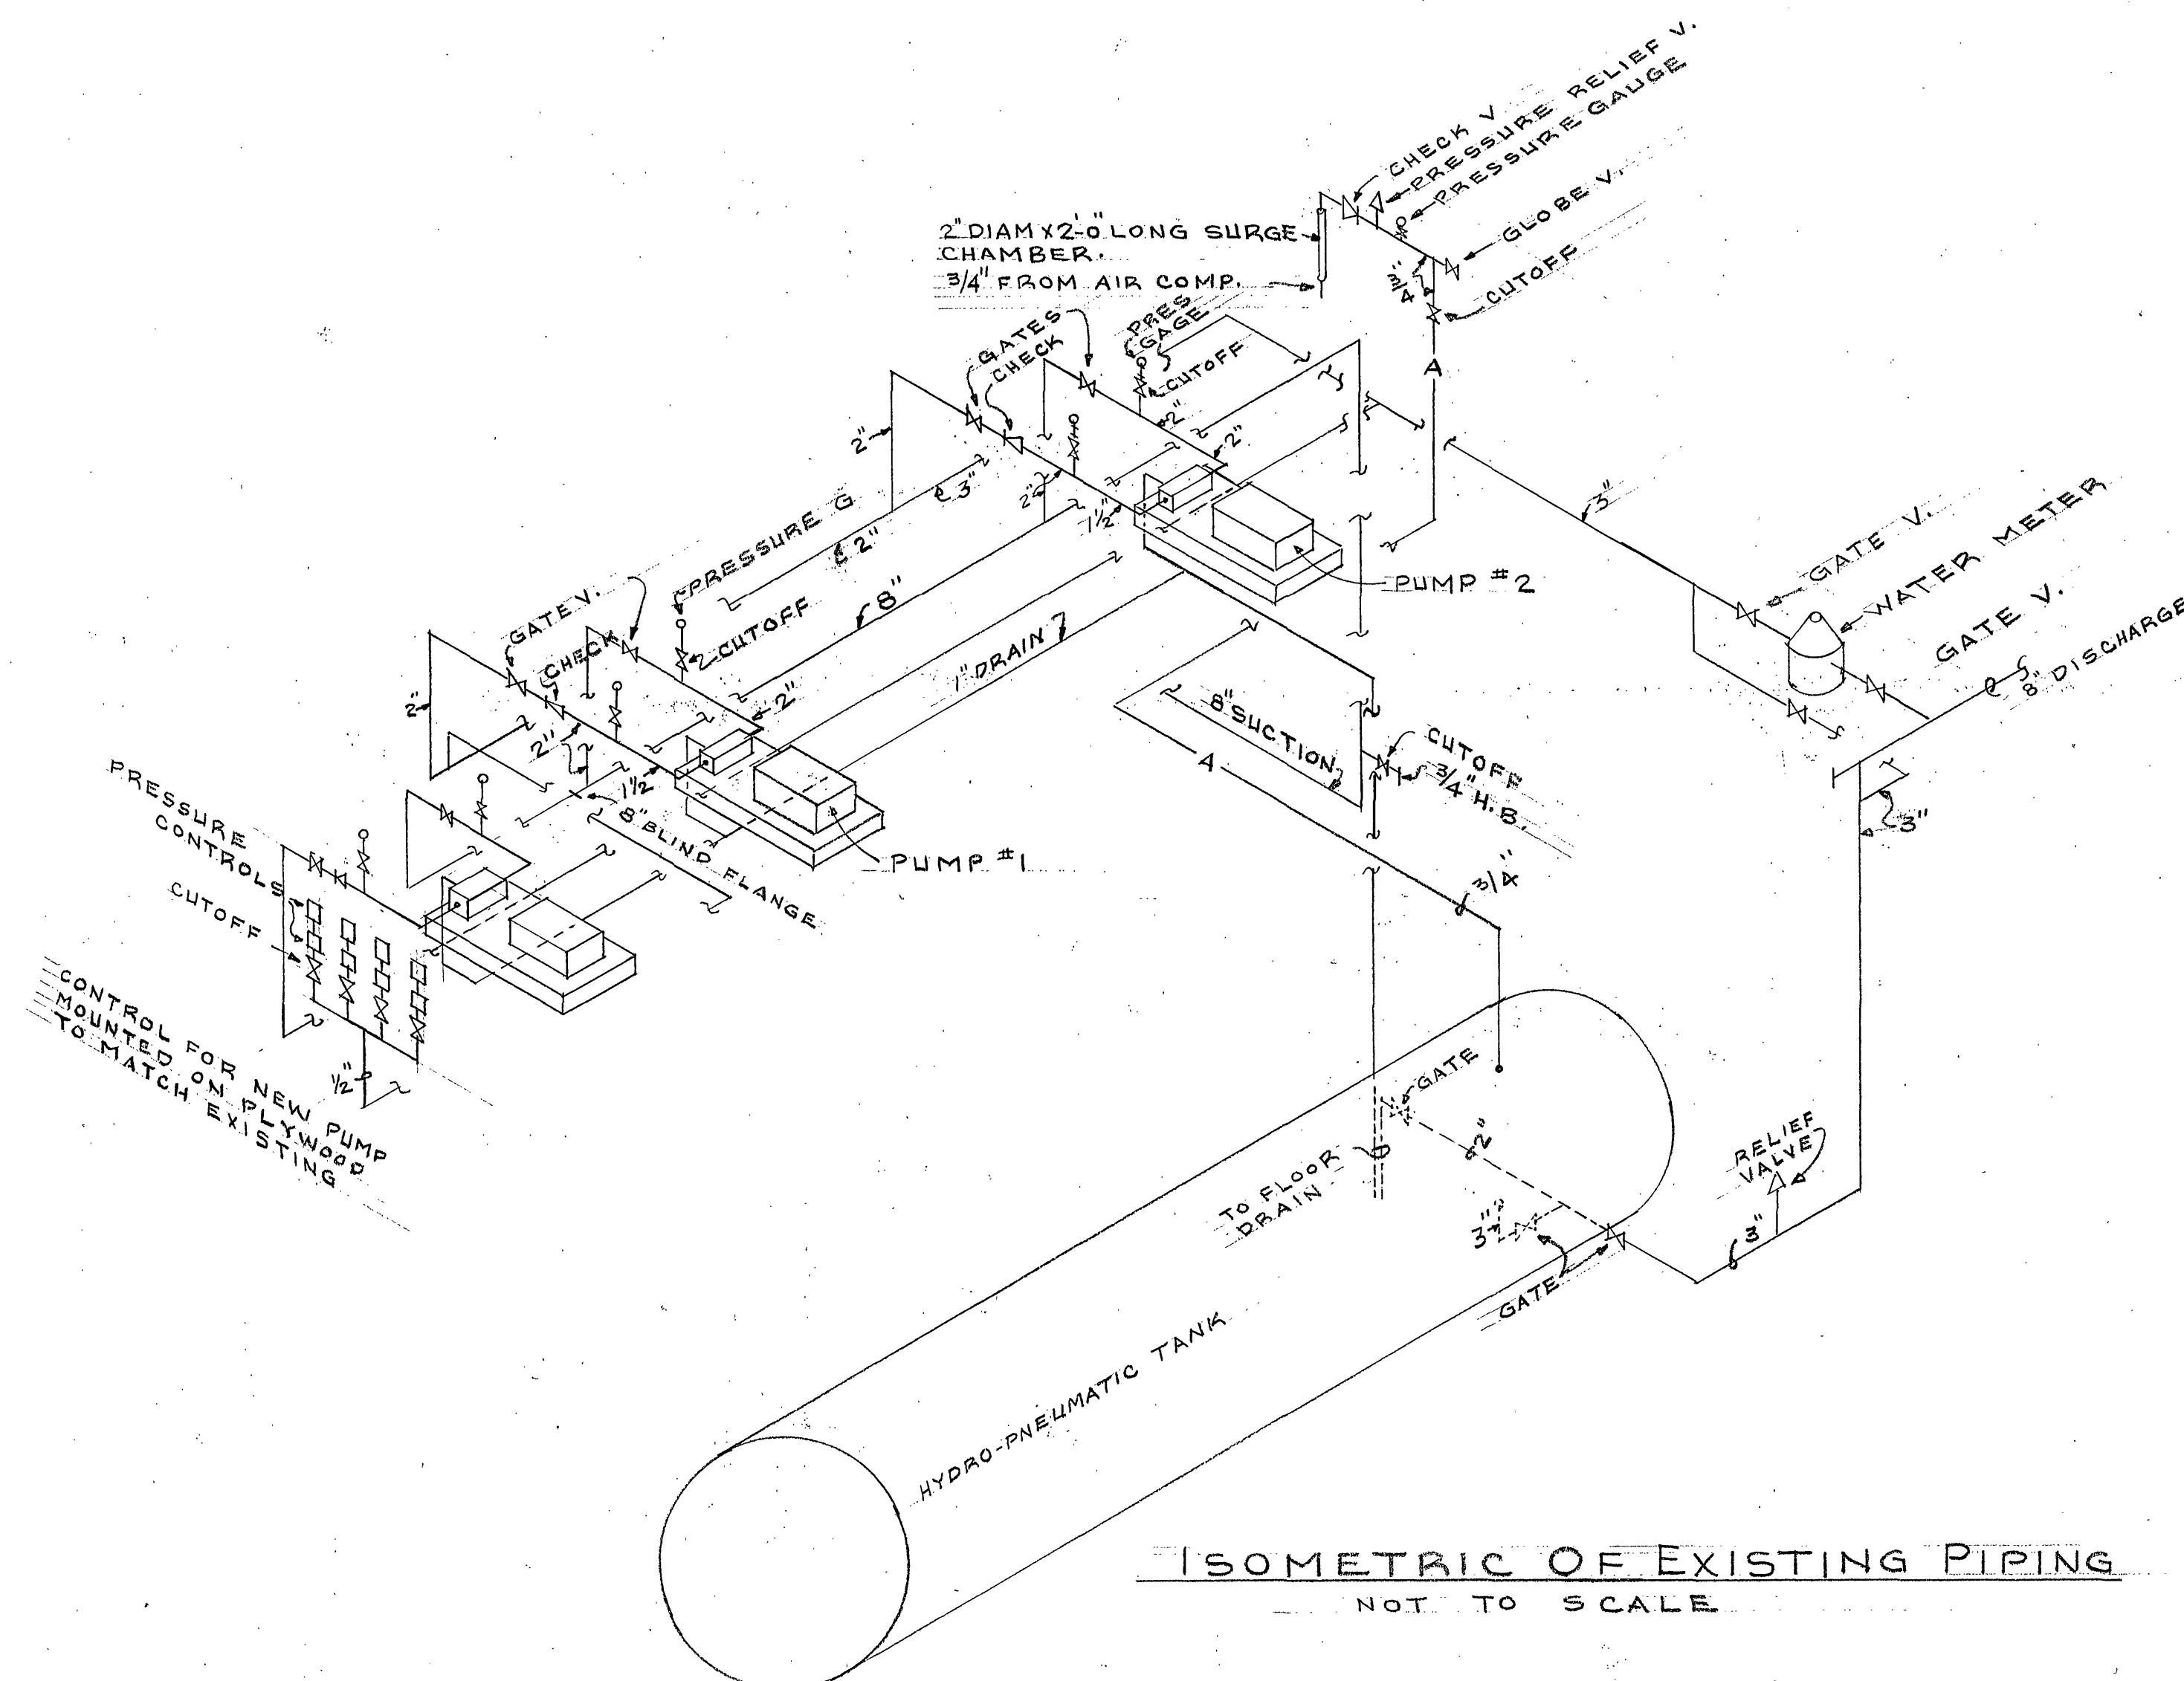

ISOMETRIC OF EXISTING PIPING
NOT TO SCALE

DATE	REV.	DESCRIPTION	BY
		Thomas F. Bandy	CITY ENGINEER
		ALTERATIONS & ADDITIONS	DRAWN L.B.C.
		CHAPEL FOREST	CHECKED
		PUMP STATION	APP'D
		ROANOKE, VA.	DATE 8-5-76
		CITY OF ROANOKE	SHEET NO. 5519
		OFFICE OF CITY ENGINEER	SHEET 2
		ROANOKE, VIRGINIA	OF 2
		CONTRACTOR MUST VERIFY ALL DIMENSIONS AT PROJECT BEFORE PROCEEDING WITH WORK	