




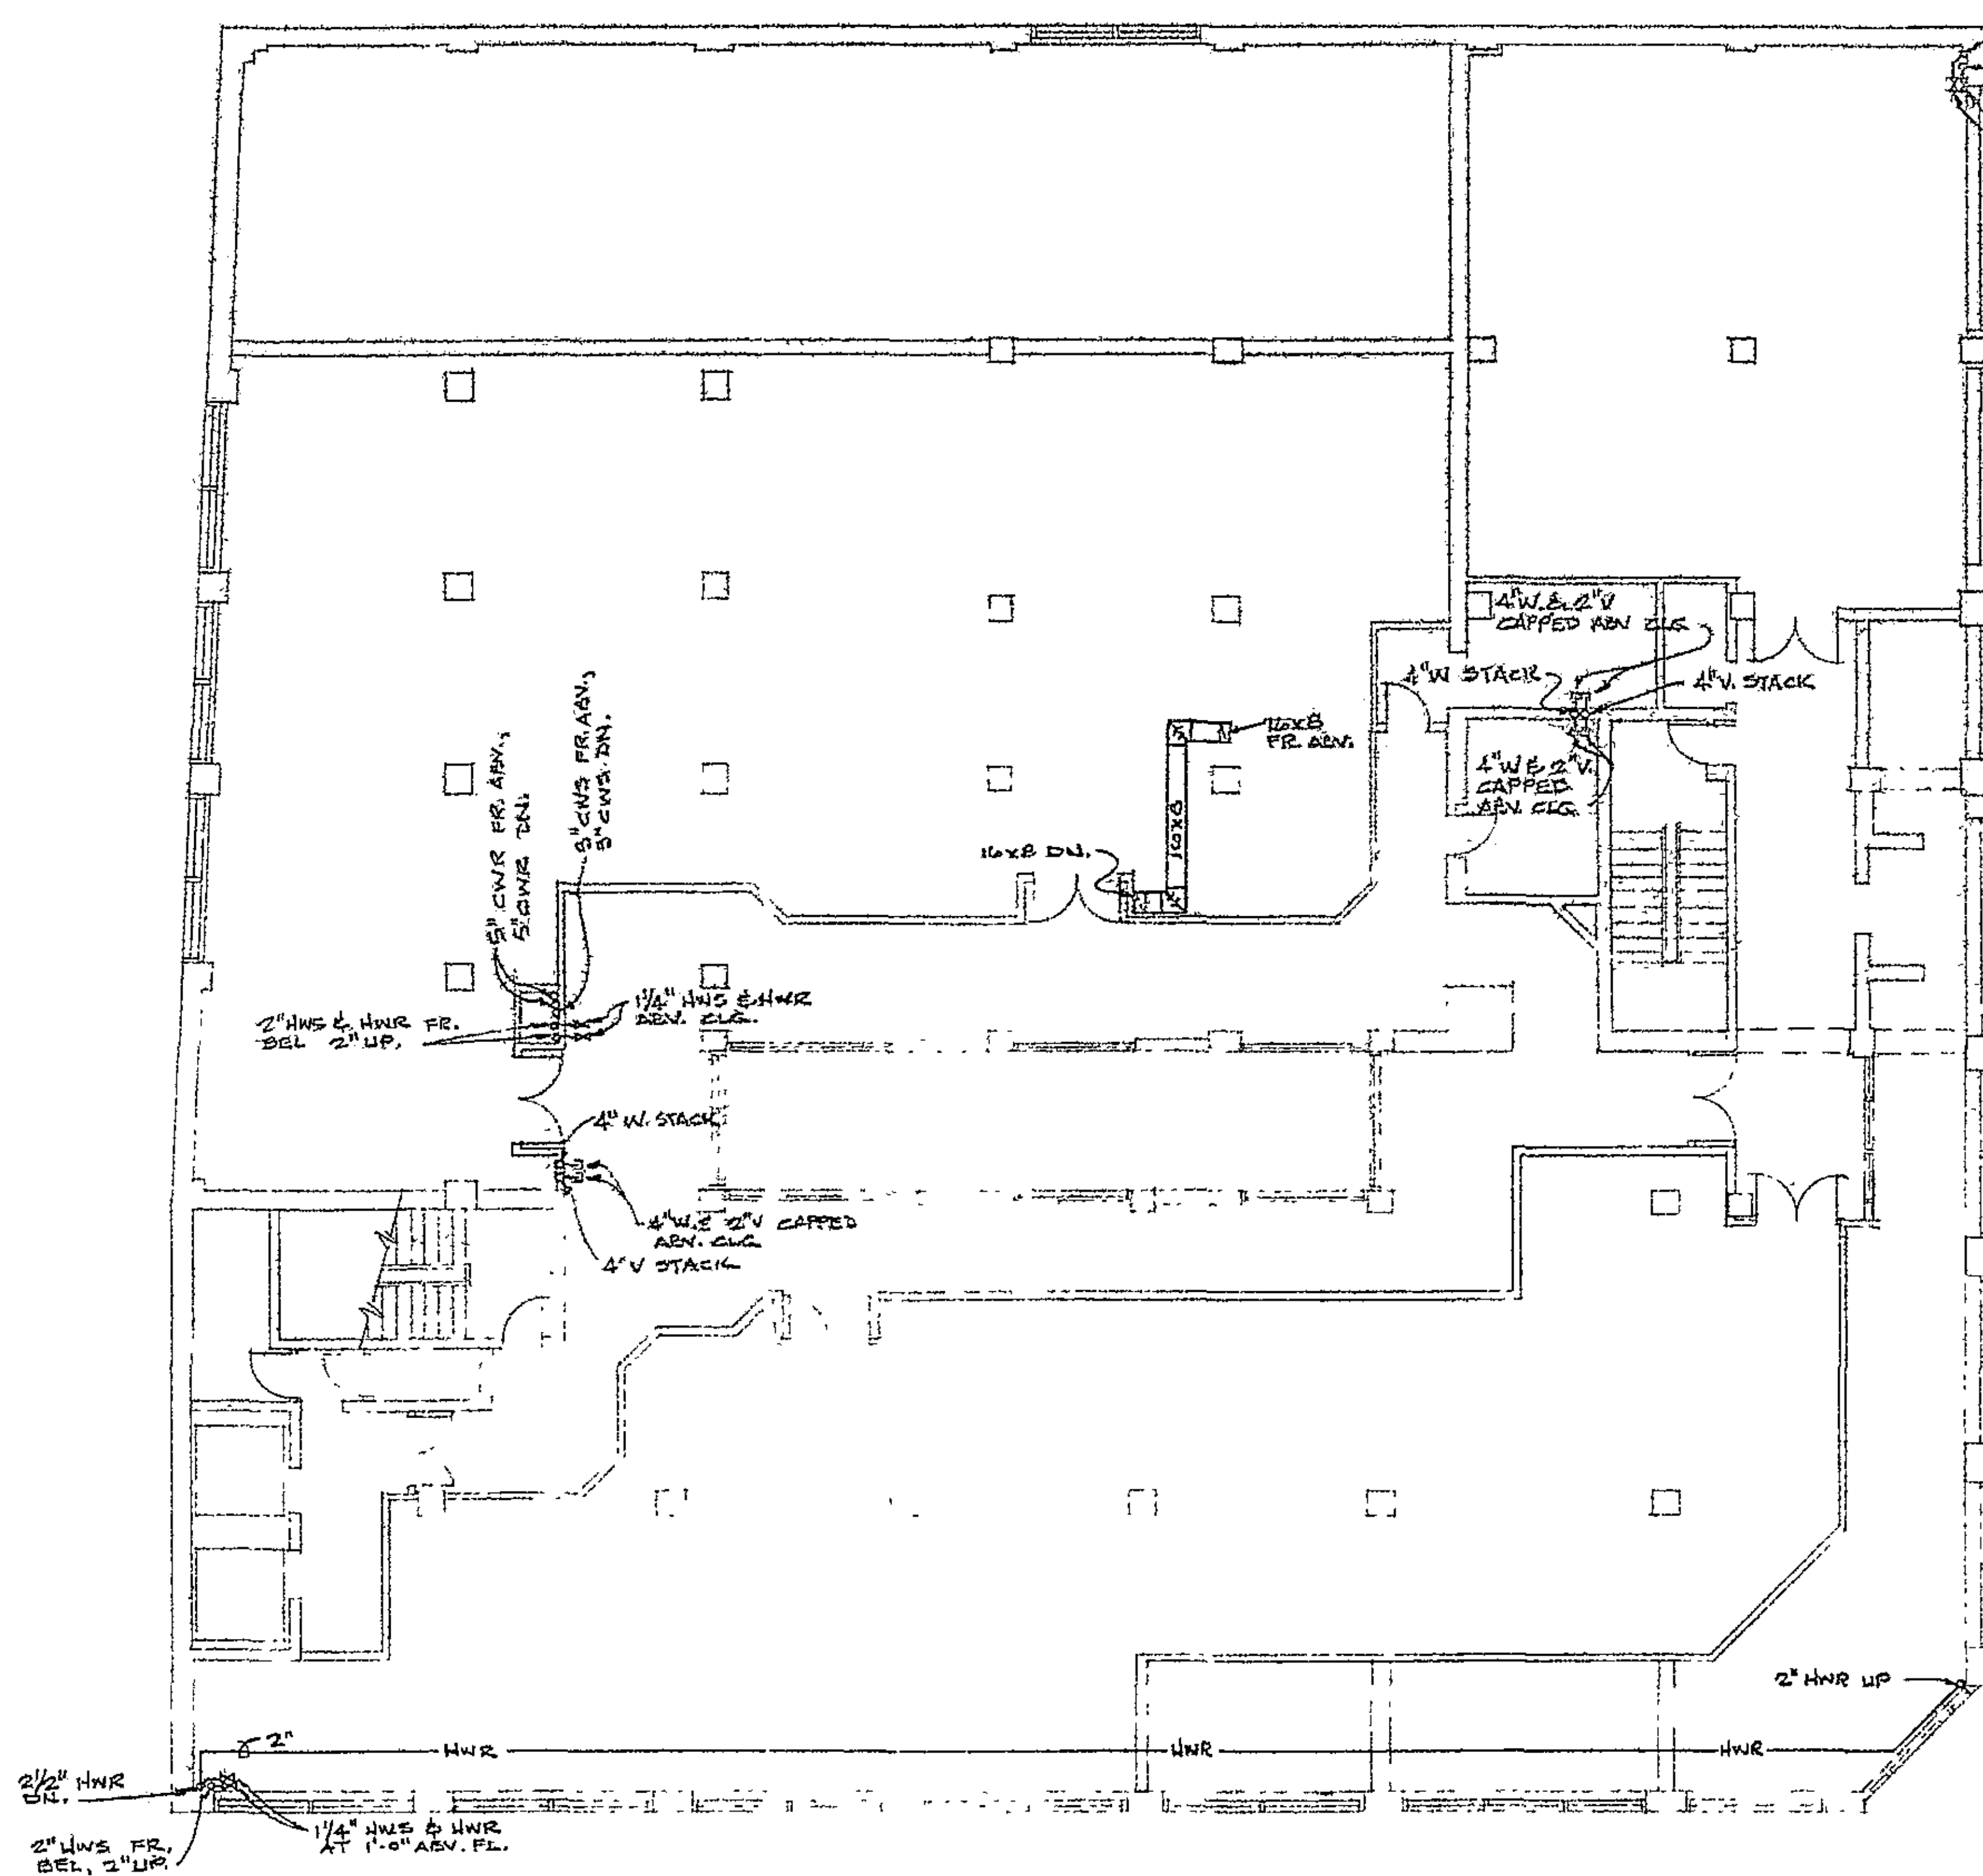


SECOND FLOOR PLAN
SCALE: 1/8" = 1'-0"

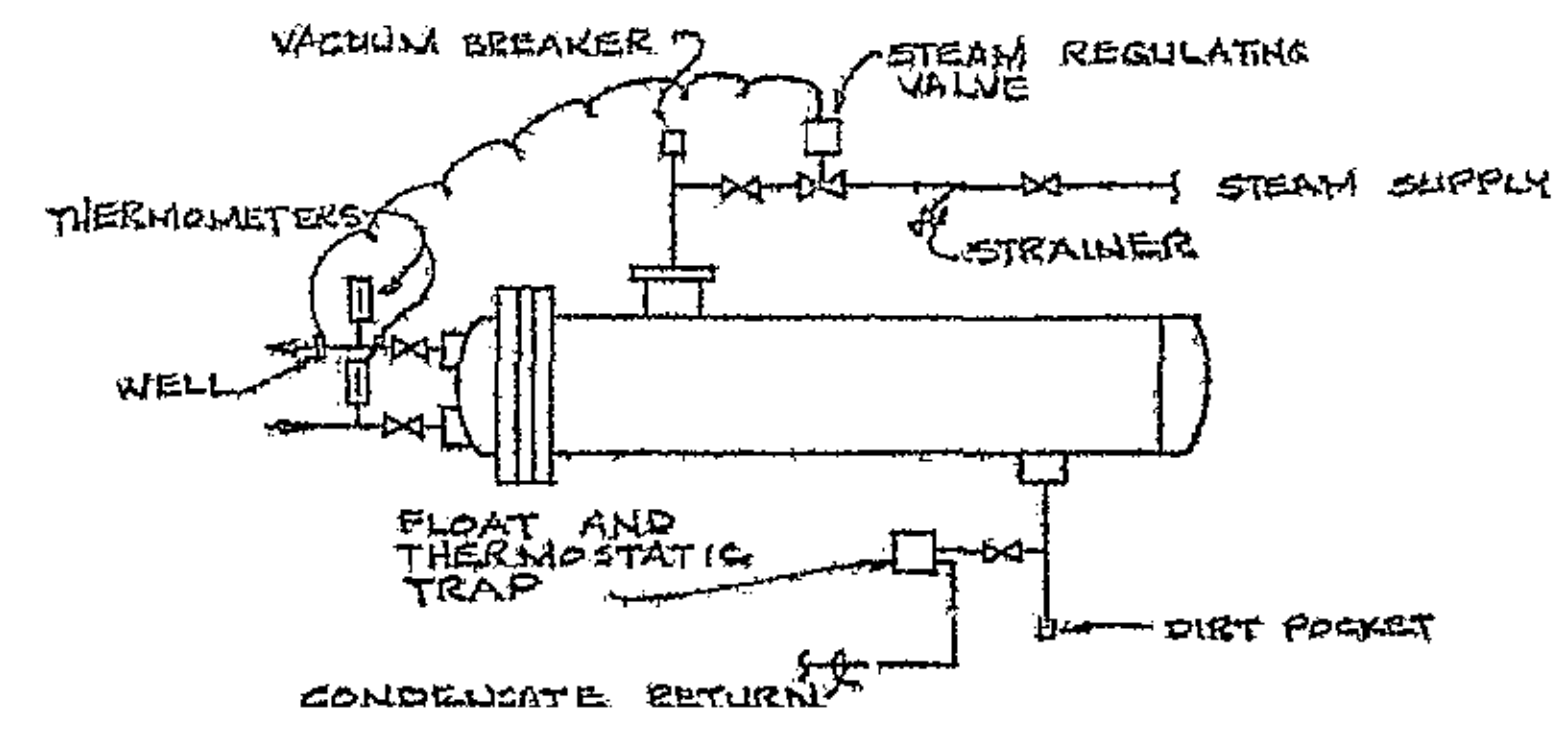


CONVERTER CONNECTION DETAIL
SCHEMATIC

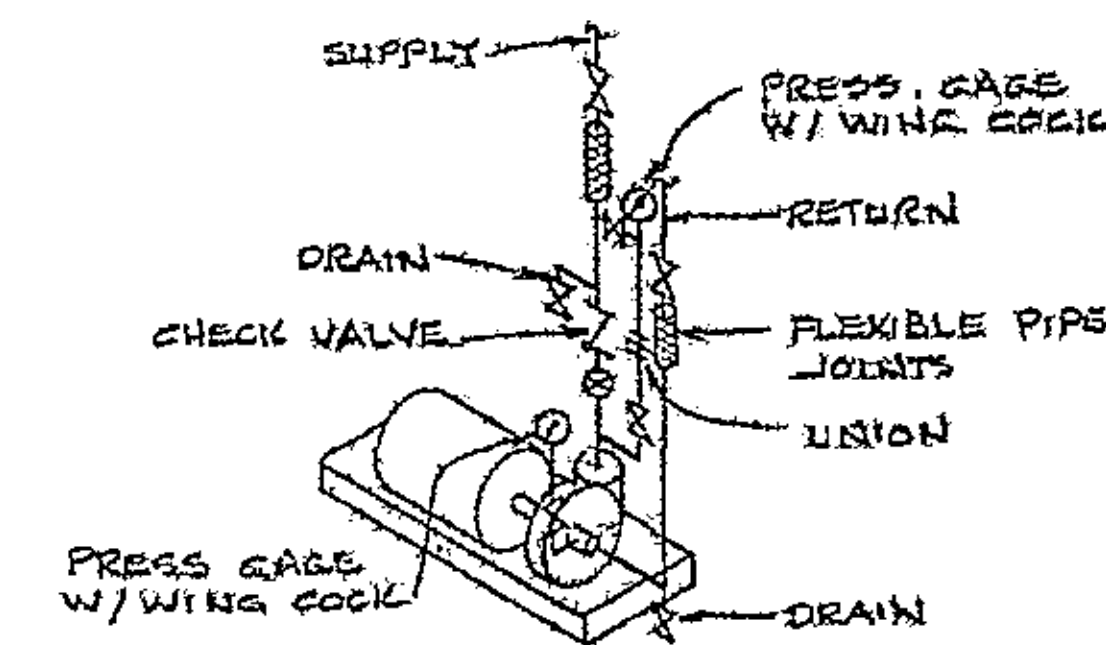

PUMP CONNECTION DETAIL
SCHEMATIC

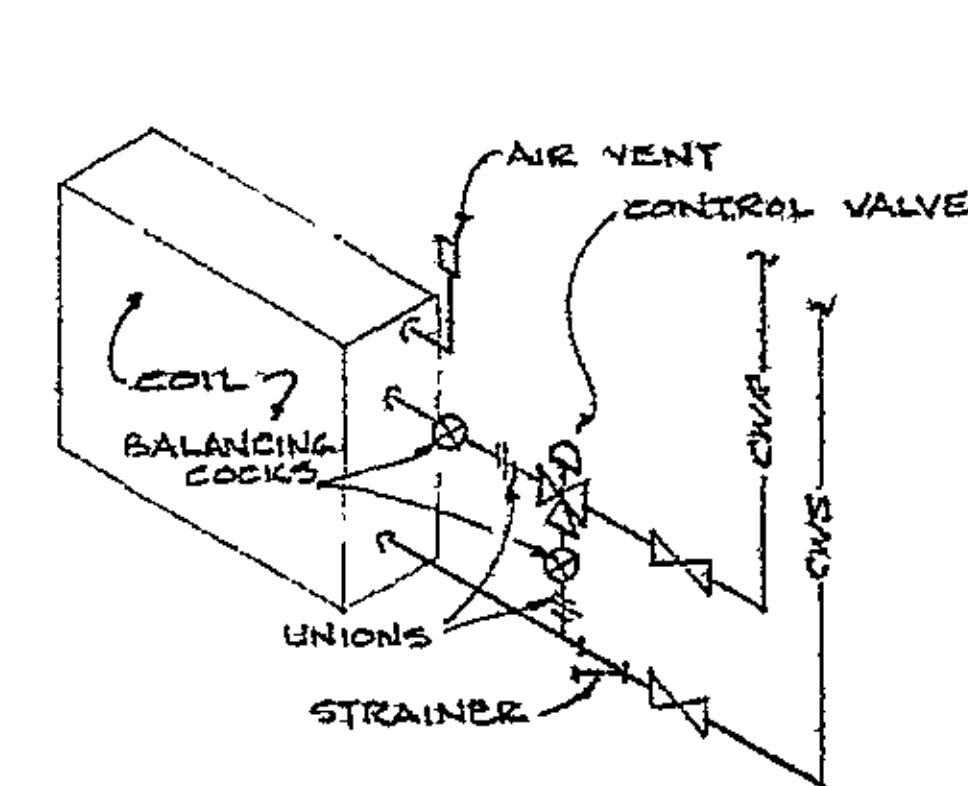

COOLING

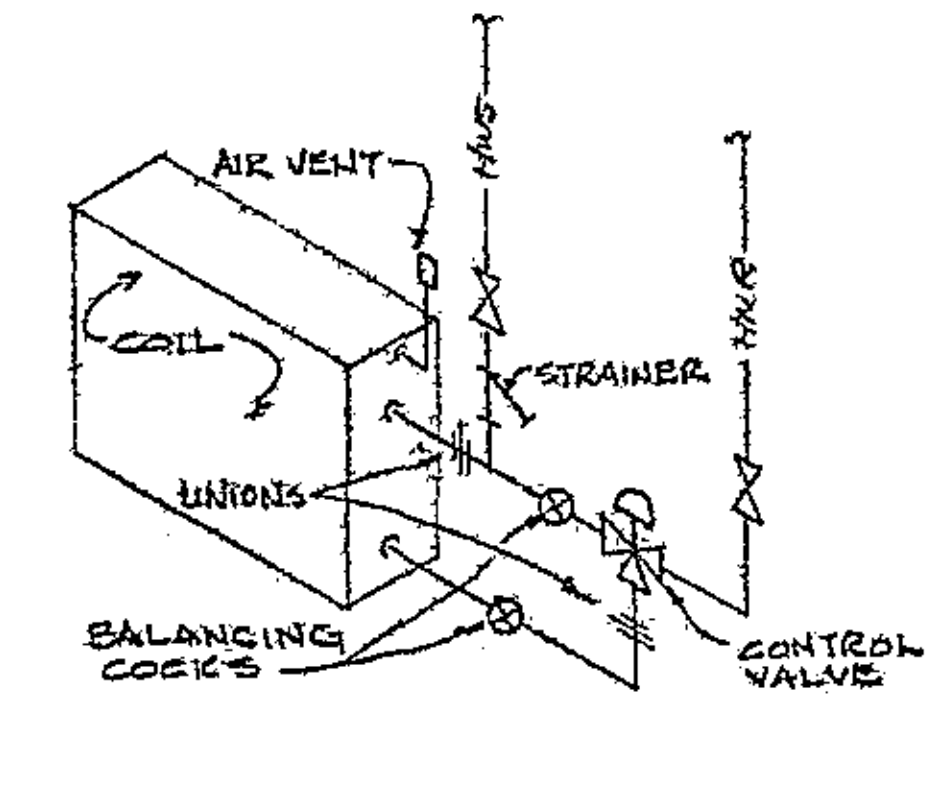

HEAT RE

COIL CONNECTION DETAILS
SCHEMATIC

REVISIONS	BY

RENOVATIONS & ALTERATIONS TO
COULTER BLDG. & NATL. BUS. COL. BLDG.
JEFFERSON ST. AT FRANKLIN RD. ROANOKE, VIRGINIA

CHARLES D. KELLER, II
Consulting Engineer
Roanoke, Virginia

MECHANICAL SECOND FLOOR PLAN

COMMONWEALTH OF VIRGINIA
Charles D. Keller, II
Professional Engineer
4250

DRAWN	CUD/CDK
CHECKED	CDK
DATE	JULY 25, 1986
SCALE	AS NOTED
NO. NO.	BL-05
SHEET	ONE
M-2	
OF	6 SHEETS