


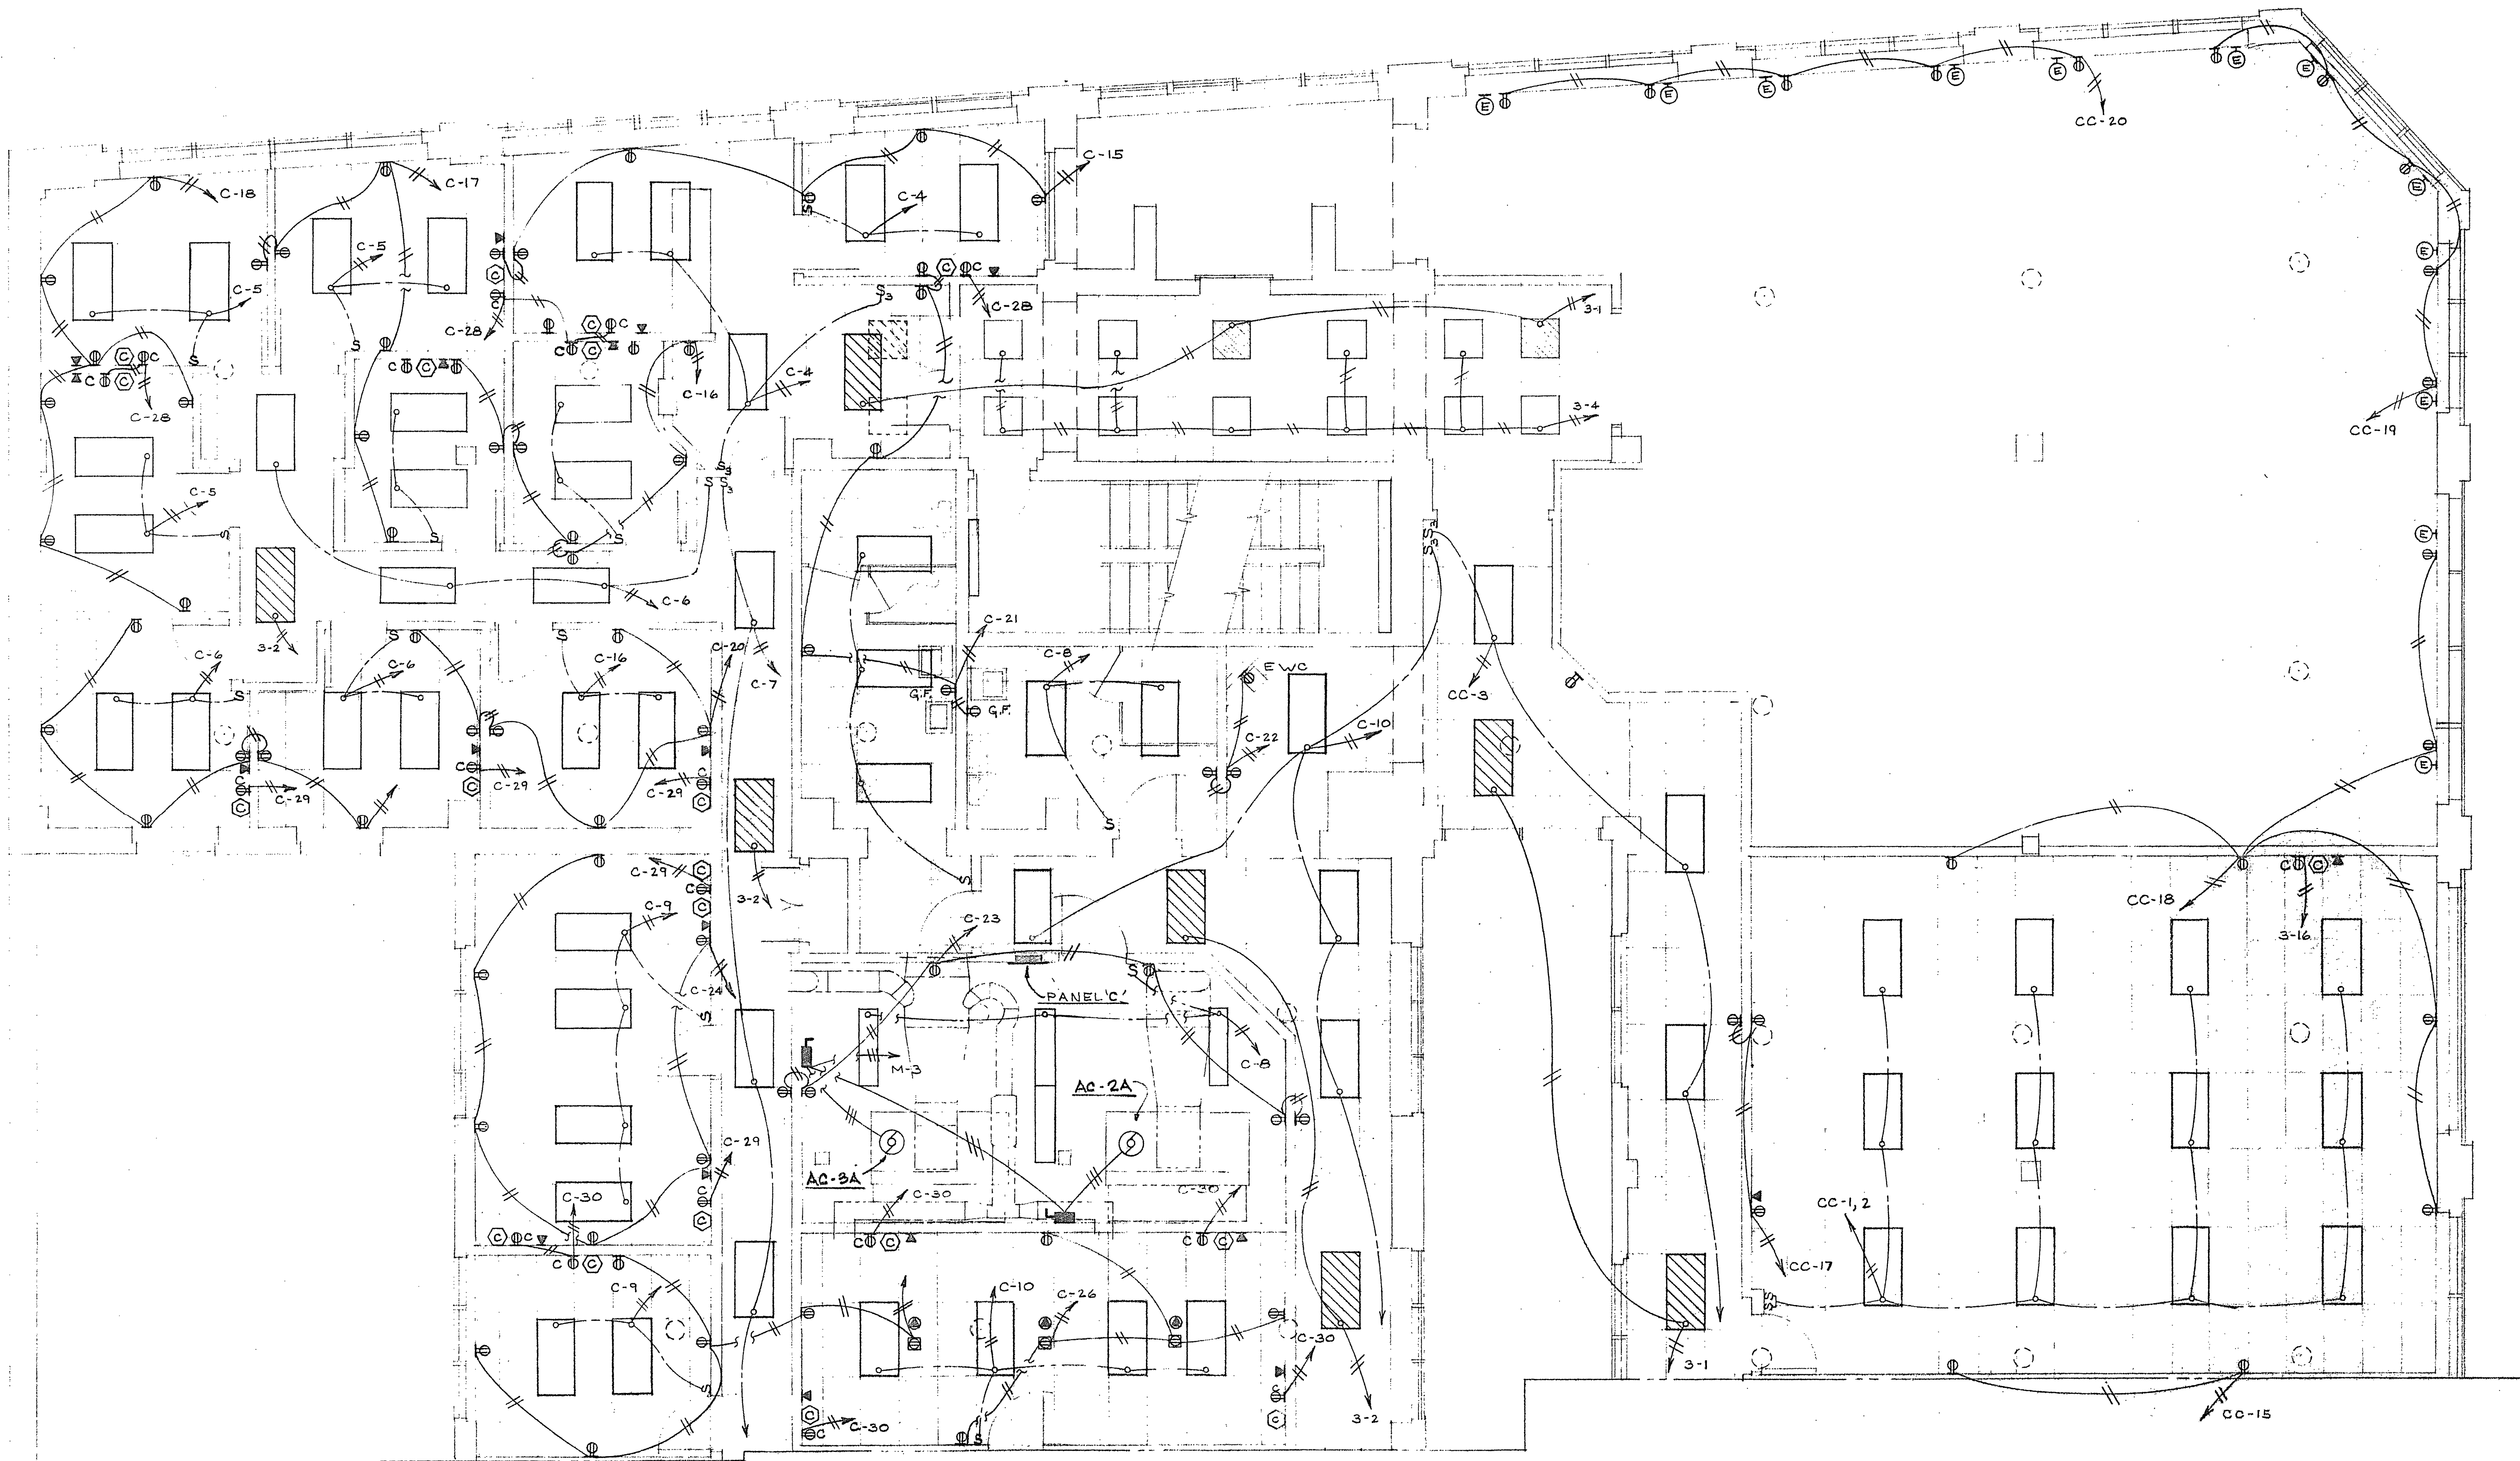

THIRD FLOOR PLAN - NORTH

SCALE 1/4" = 1'-0"

ELECTRICAL

CHARLES D. KEEFER, II - CONSULTING ENGINEER Roanoke Virginia	
RENOVATION & ALTERATIONS TO COUTLER BLDG & NATL. BUSINESS COL JEFFERSON ST. AT FRANKLIN RD, ROANOKE, VA.	DATE 30 JAN 87
MARTIN BROS, CONTRACTORS, INC. ROANOKE VIRGINIA	SHEET M.3c