

DATE:	March 22, 2005
ISSUED	May 3, 2005
REVISION	
REVISION	
REVISION	
REVISION	
REVISION	

HUGHES
ASSOCIATES
ARCHITECTS

Architecture • Planning • Consulting

656 ELM AVENUE, S.W.
P.O. BOX 1034
ROANOKE, VIRGINIA 24005-1034

TEL (540) 342-4002
FAX (540) 342-2060
www.HughesArchitects.com

ALTERATIONS TO
WESTERN VIRGINIA
WATER AUTHORITY
COULTER BUILDING

601 South Jefferson Street
Roanoke, Virginia

BASEMENT
FLOOR
PLAN
(TELEPHONE,
DATA,
POWER &
ELECTRICAL)


PHASE 1

COMMISSION No.
04102
SHEET
E1-1

No. 2 of 13
COPYRIGHT 2005
HUGHES ASSOCIATES ARCHITECTS
A PROFESSIONAL CORPORATION

FRANKLIN ROAD

JEFFERSON STREET

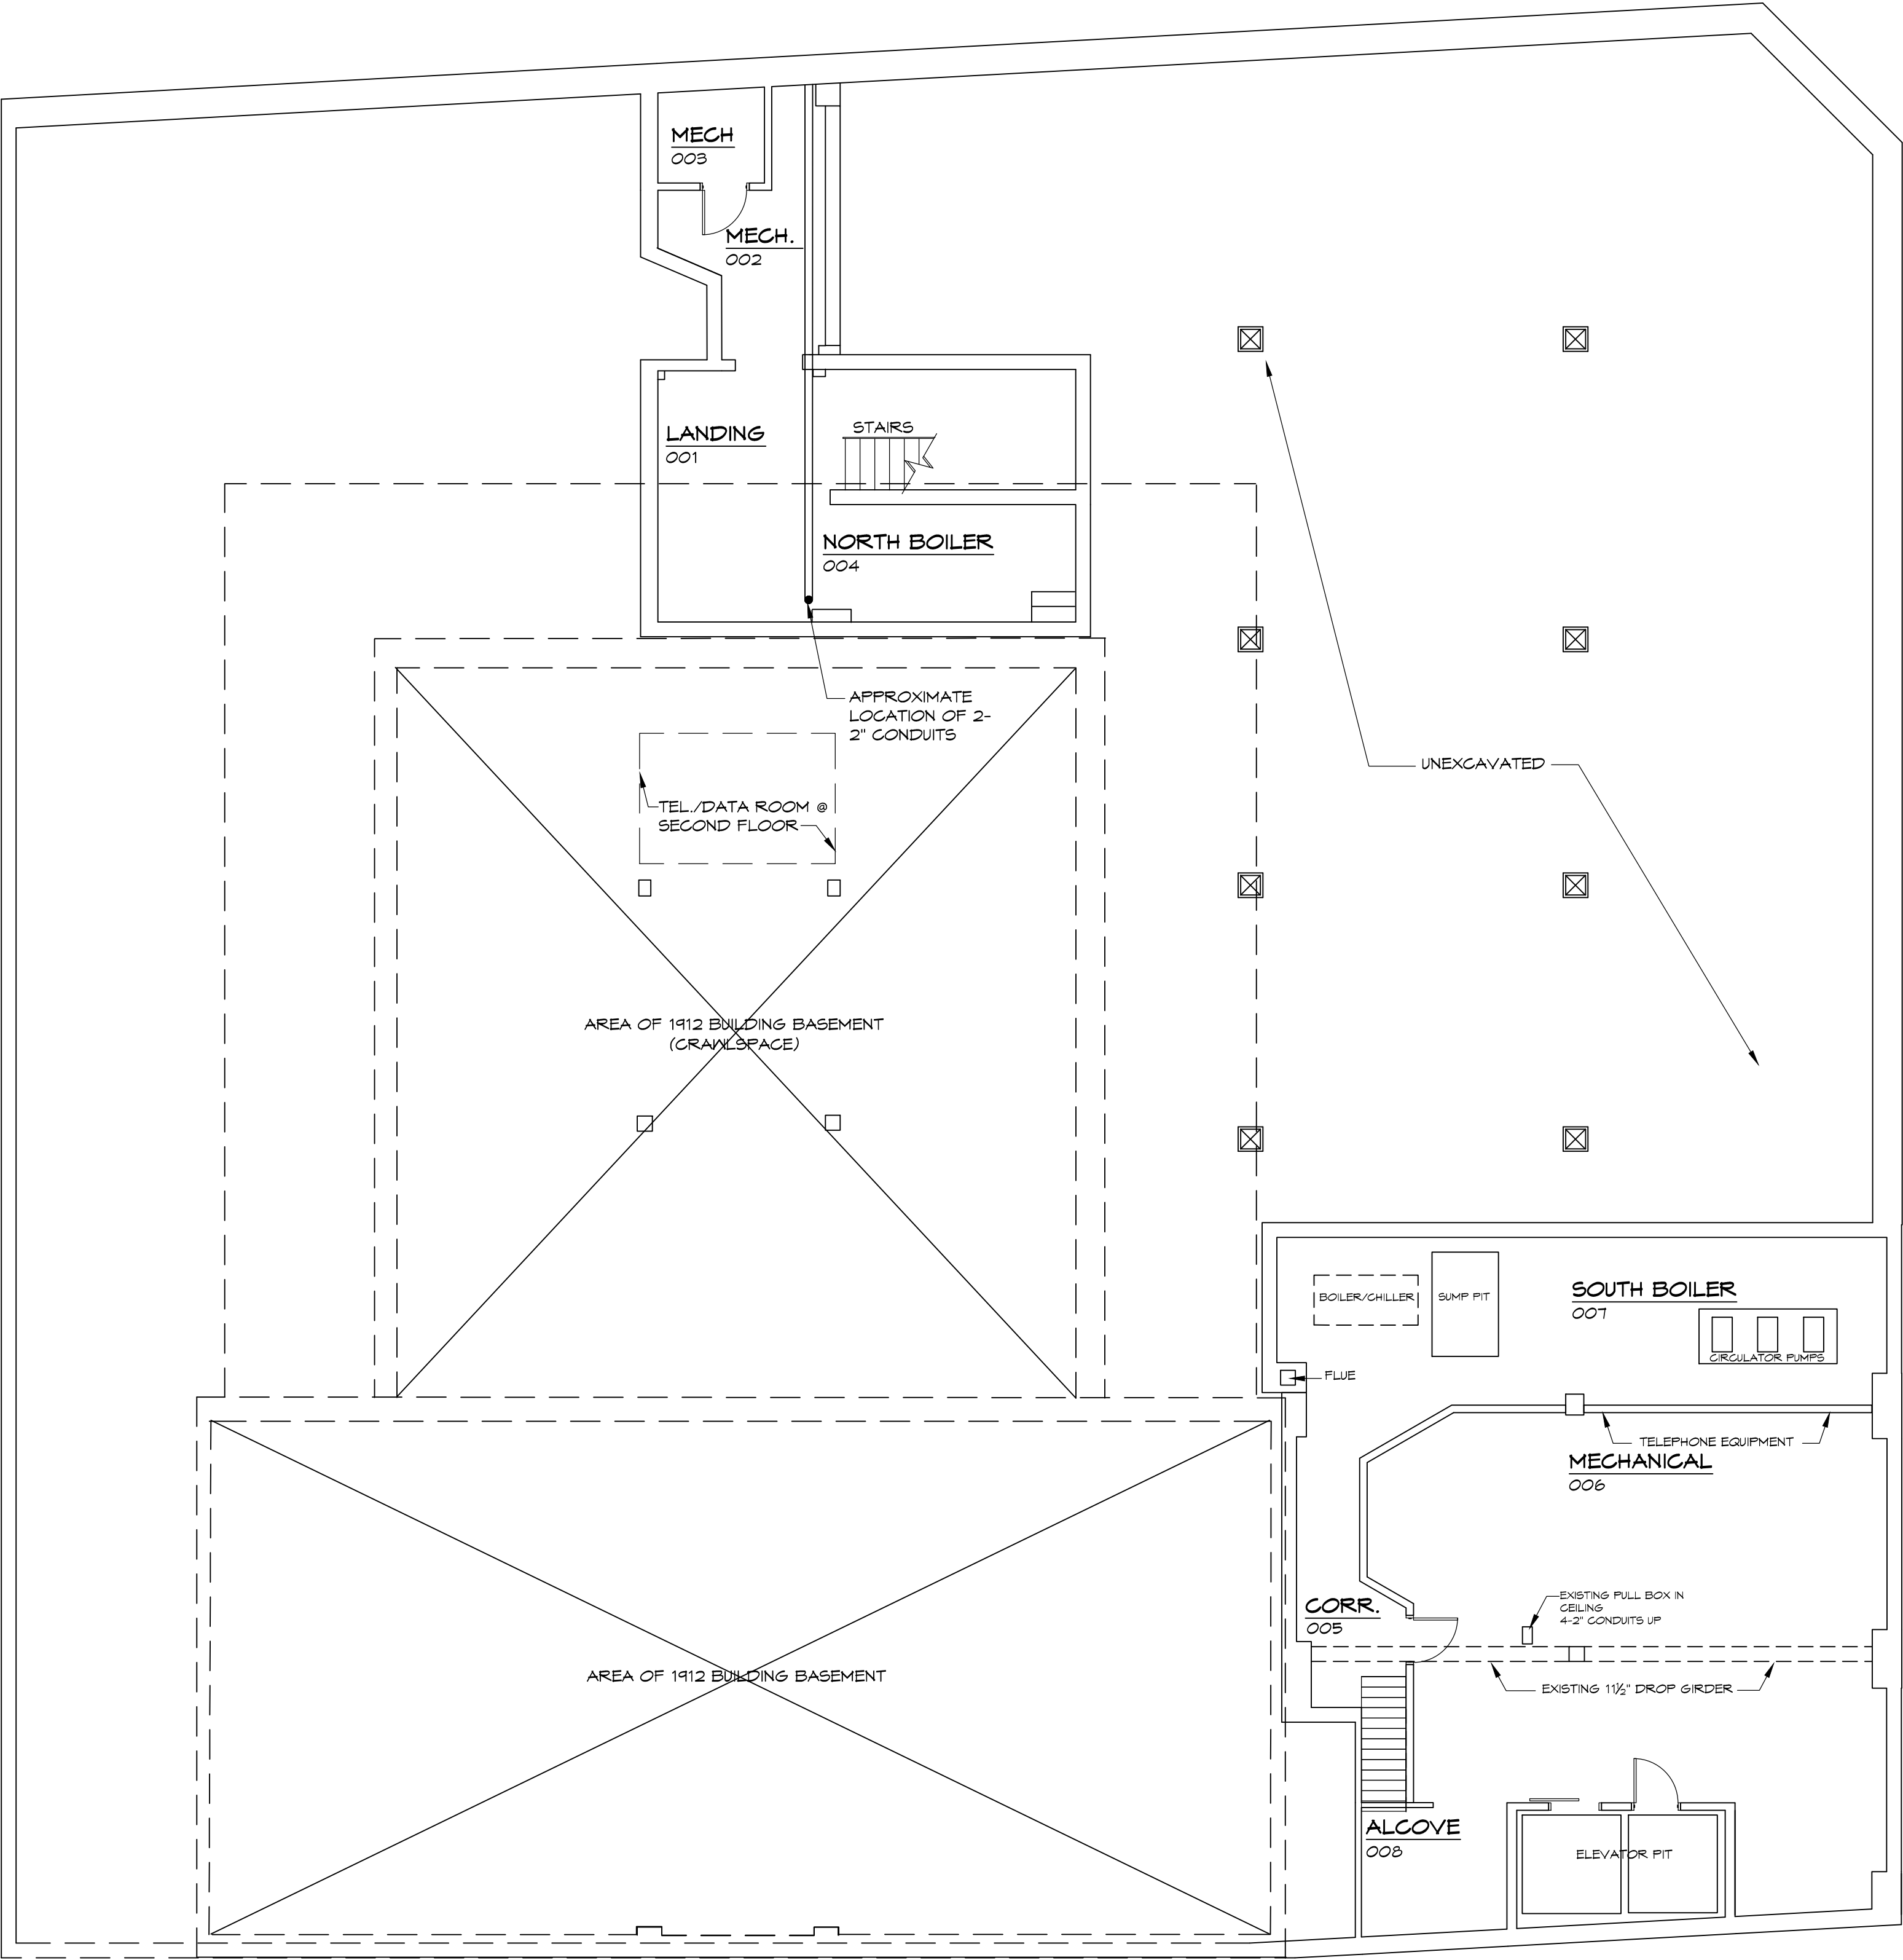

BASEMENT FLOOR PLAN
SCALE: 1/8" = 1'-0"

WIRING LEGEND

- | | |
|-----------|------------|
| DATA | WALL |
| TELEPHONE | DATA |
| COAXIAL | TELEPHONE |
| CABLE | ELECTRICAL |
| | REC. |
-
- NEW RECEPTACLE ON NEW 40A CIRCUIT WITH ISOLATION GROUND
 - NEW 2- 2" CONDUITS
 - EXISTING RECEPTACLE TO REMAIN
 - EXISTING PHONE JACK
 - EXISTING DATA PORT
 - EXISTING TOKEN RING PORT

