


FRANKLIN ROAD

E1-4.1
E1-2
PHASE 1

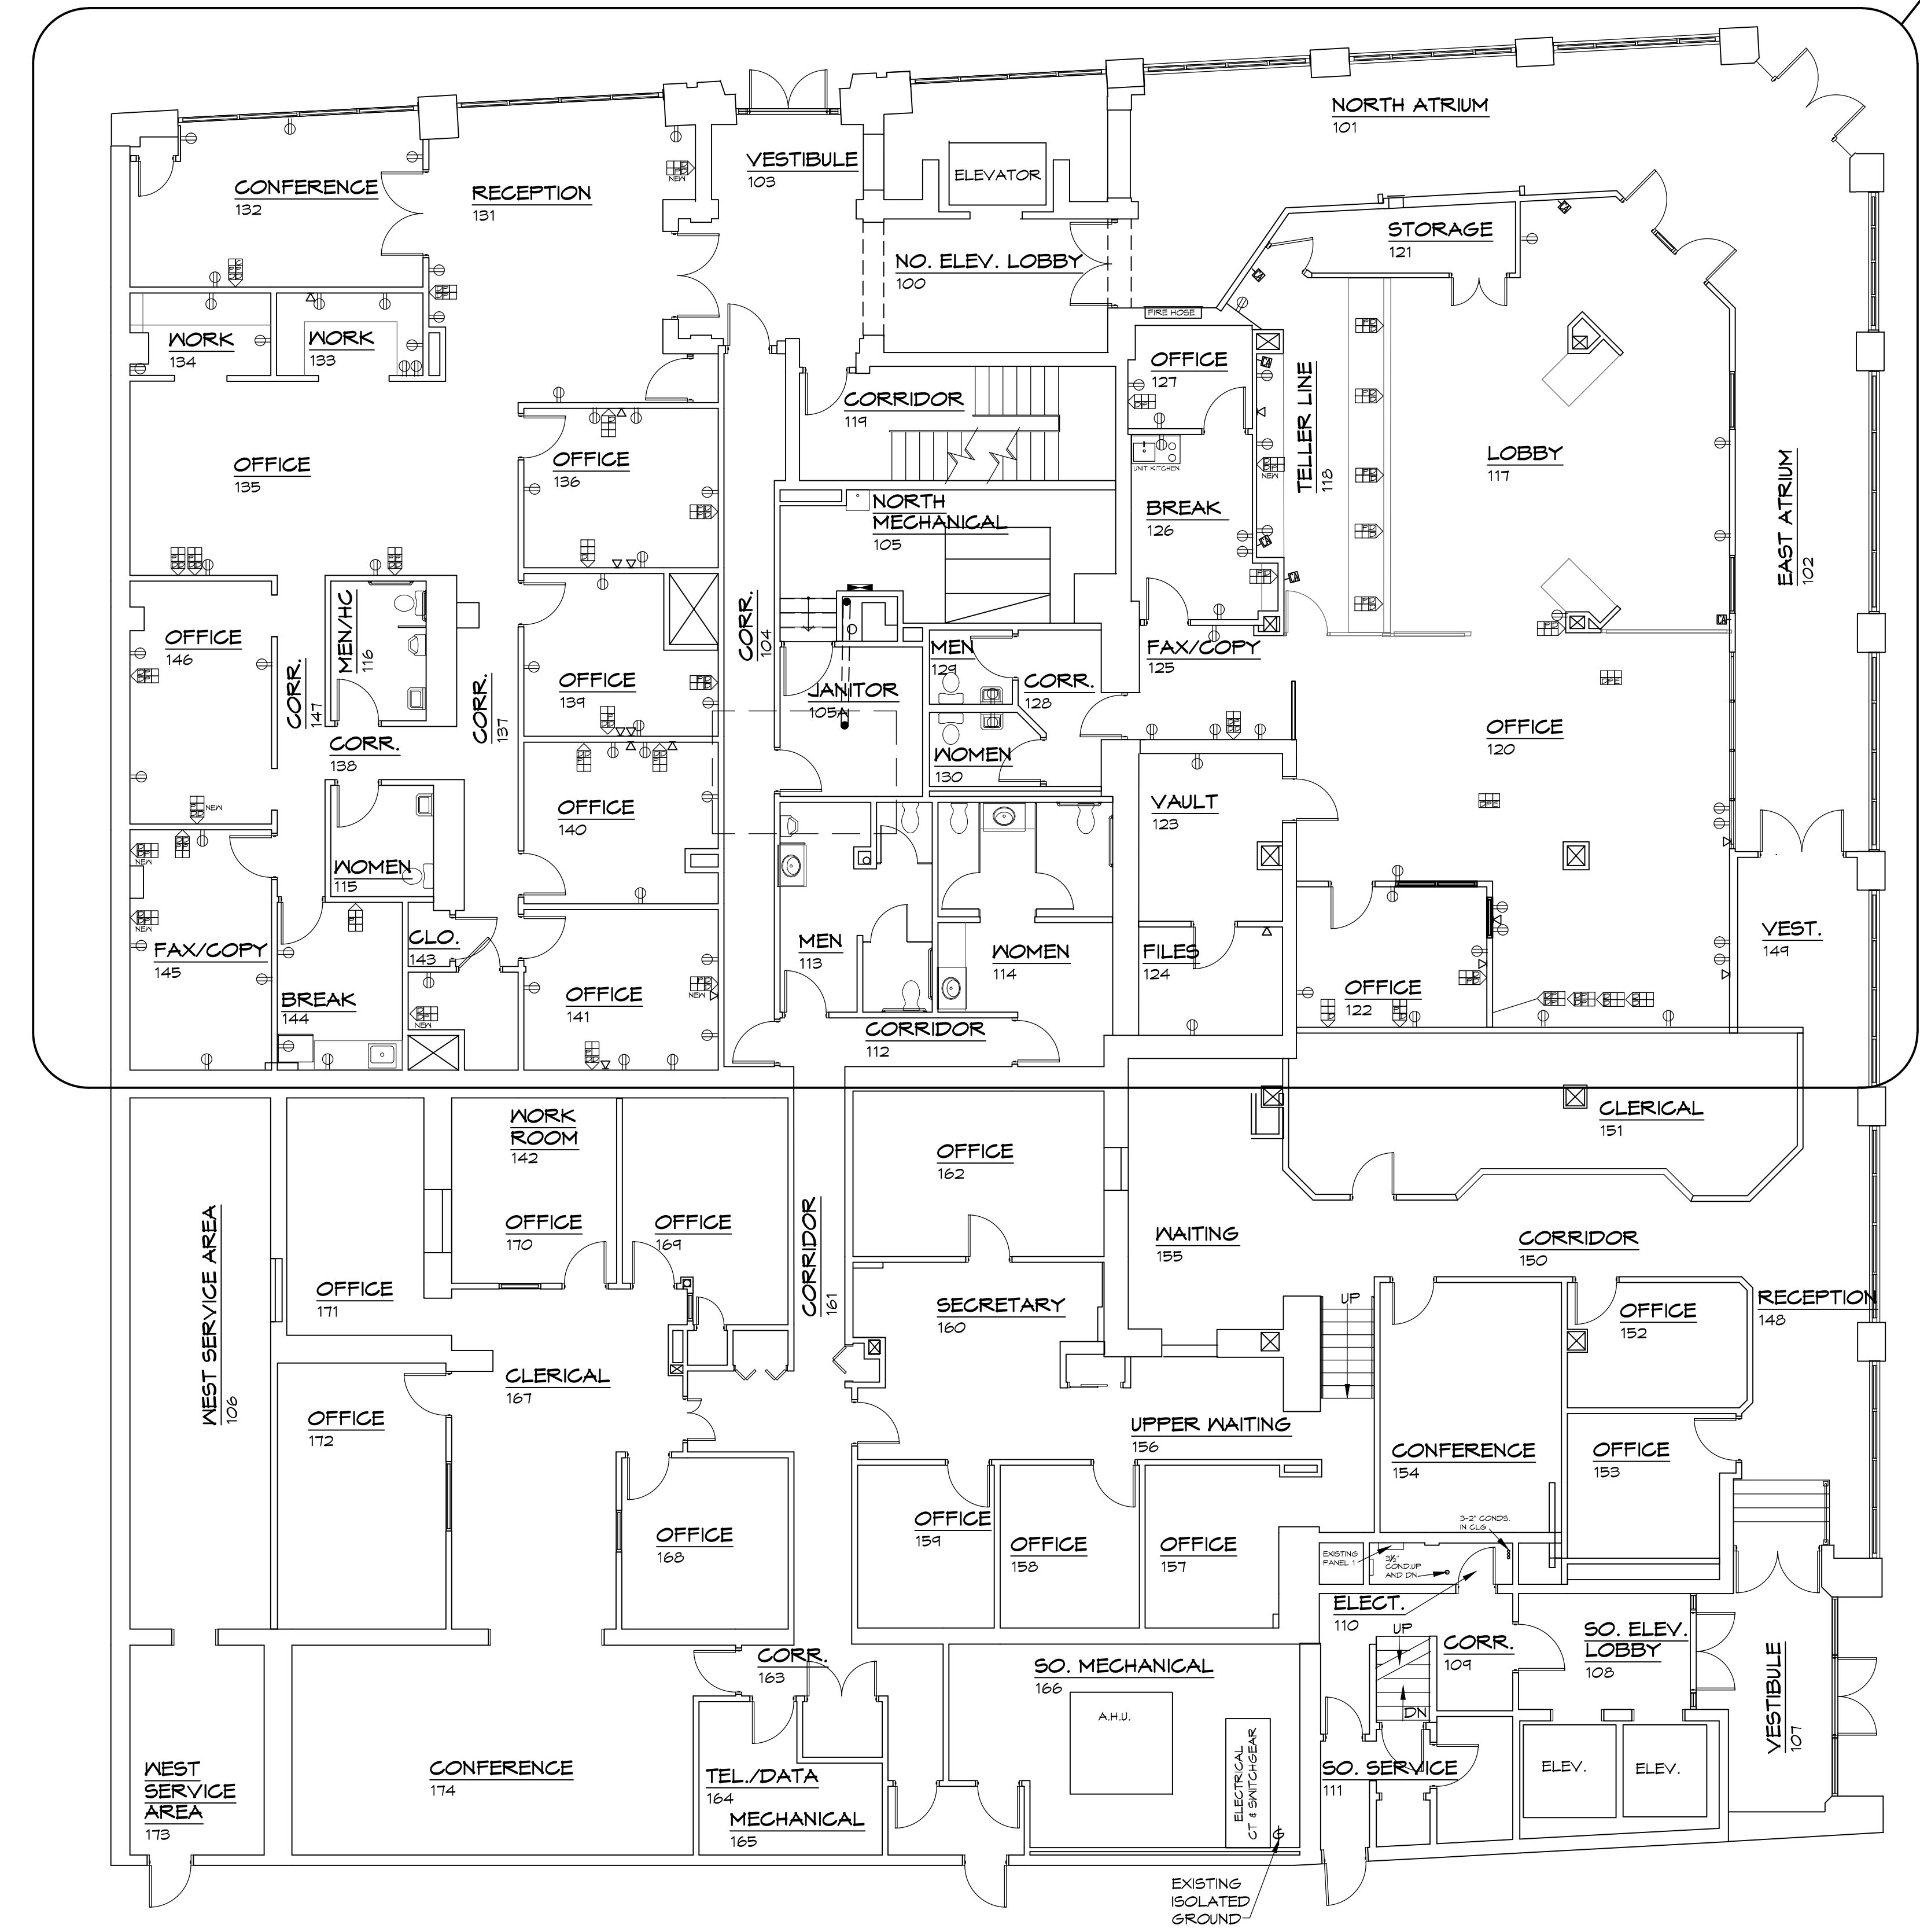

FIRST FLOOR PLAN
SCALE: 1/8" = 1'-0"

WIRING LEGEND

- DATA TELEPHONE COAXIAL CABLE
- WALL DATA TELEPHONE ELECTRICAL REC.
- NEW RECEPTACLE ON NEW 40A CIRCUIT WITH ISOLATION GROUND
- NEW 2- 2" CONDUITS
- EXISTING RECEPTACLE TO REMAIN
- EXISTING PHONE JACK
- EXISTING DATA PORT
- EXISTING TOKEN RING PORT