


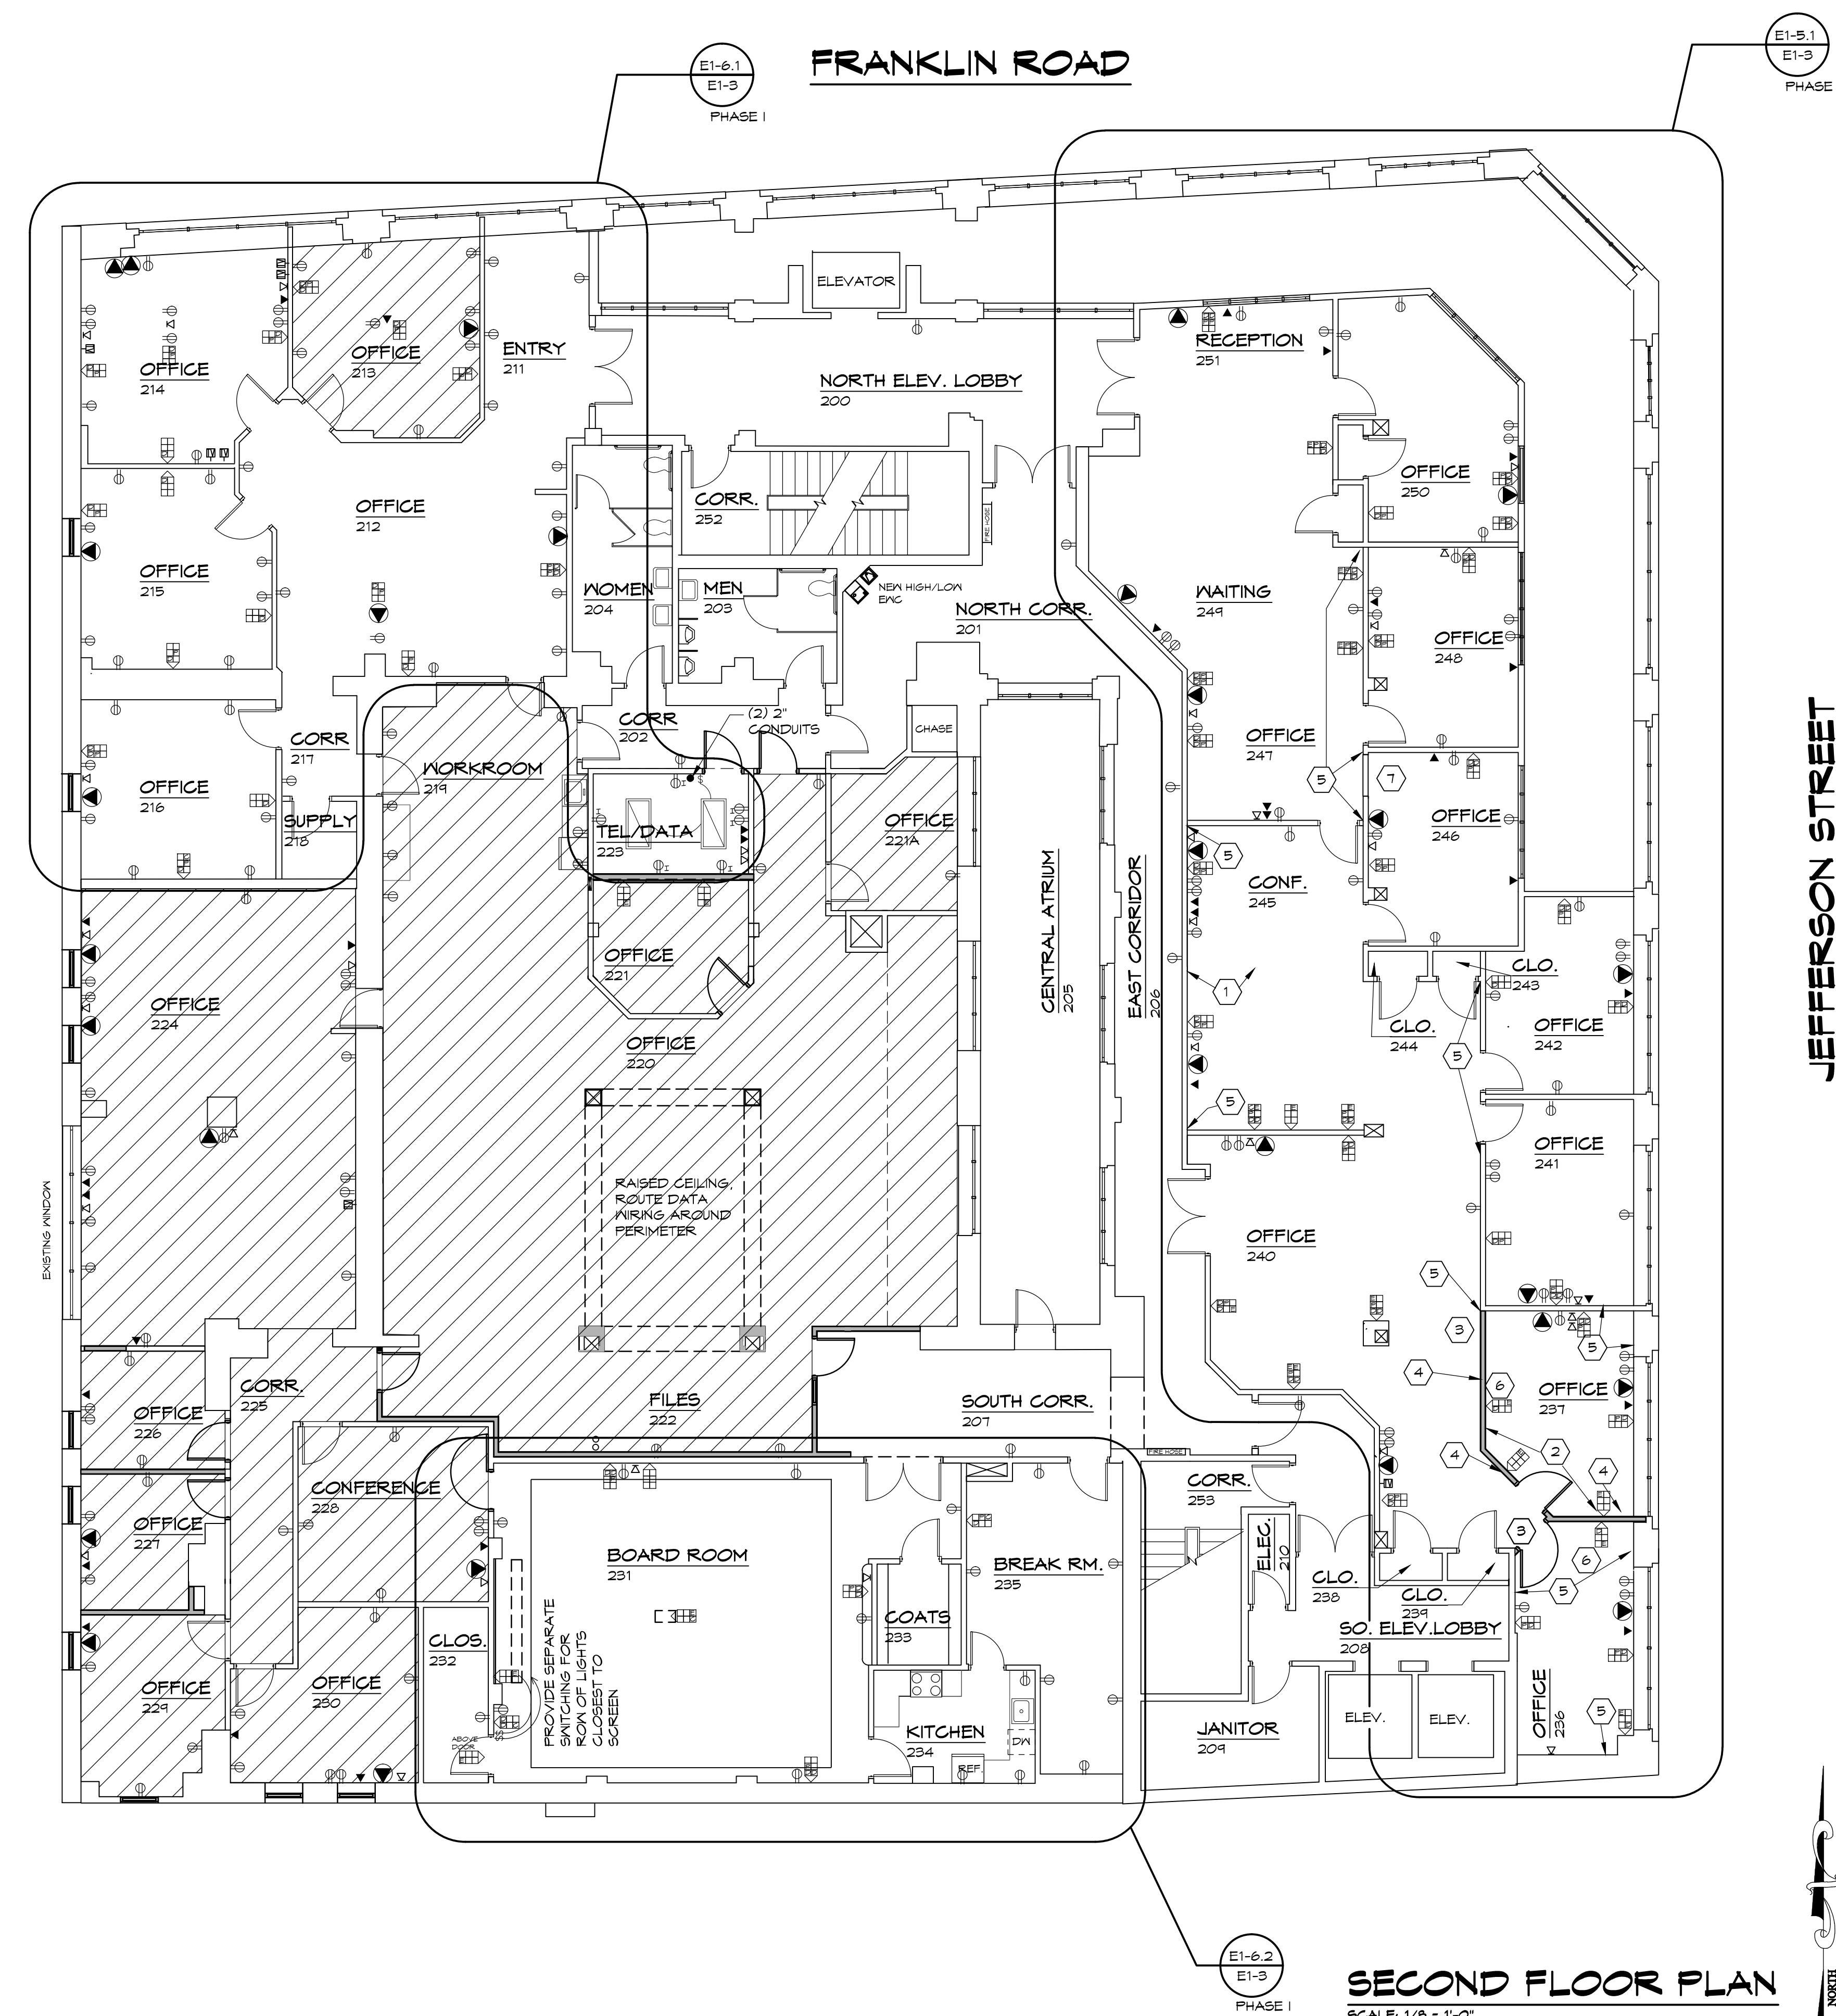

WIRING LEGEND

DATA	WALL DATA
TELEPHONE	TELEPHONE
COAXIAL	ELECTRICAL
CABLE	REC.

⊕	NEW RECEPTACLE ON NEW 40A CIRCUIT WITH ISOLATION GROUND
●	NEW 2" - 2" CONDUITS
⊕	EXISTING RECEPTACLE TO REMAIN
⏏	EXISTING PHONE JACK
⬤	EXISTING DATA PORT
D	EXISTING TOKEN RING PORT

SECOND FLOOR PLAN
SCALE: 1/8" = 1'-0"