


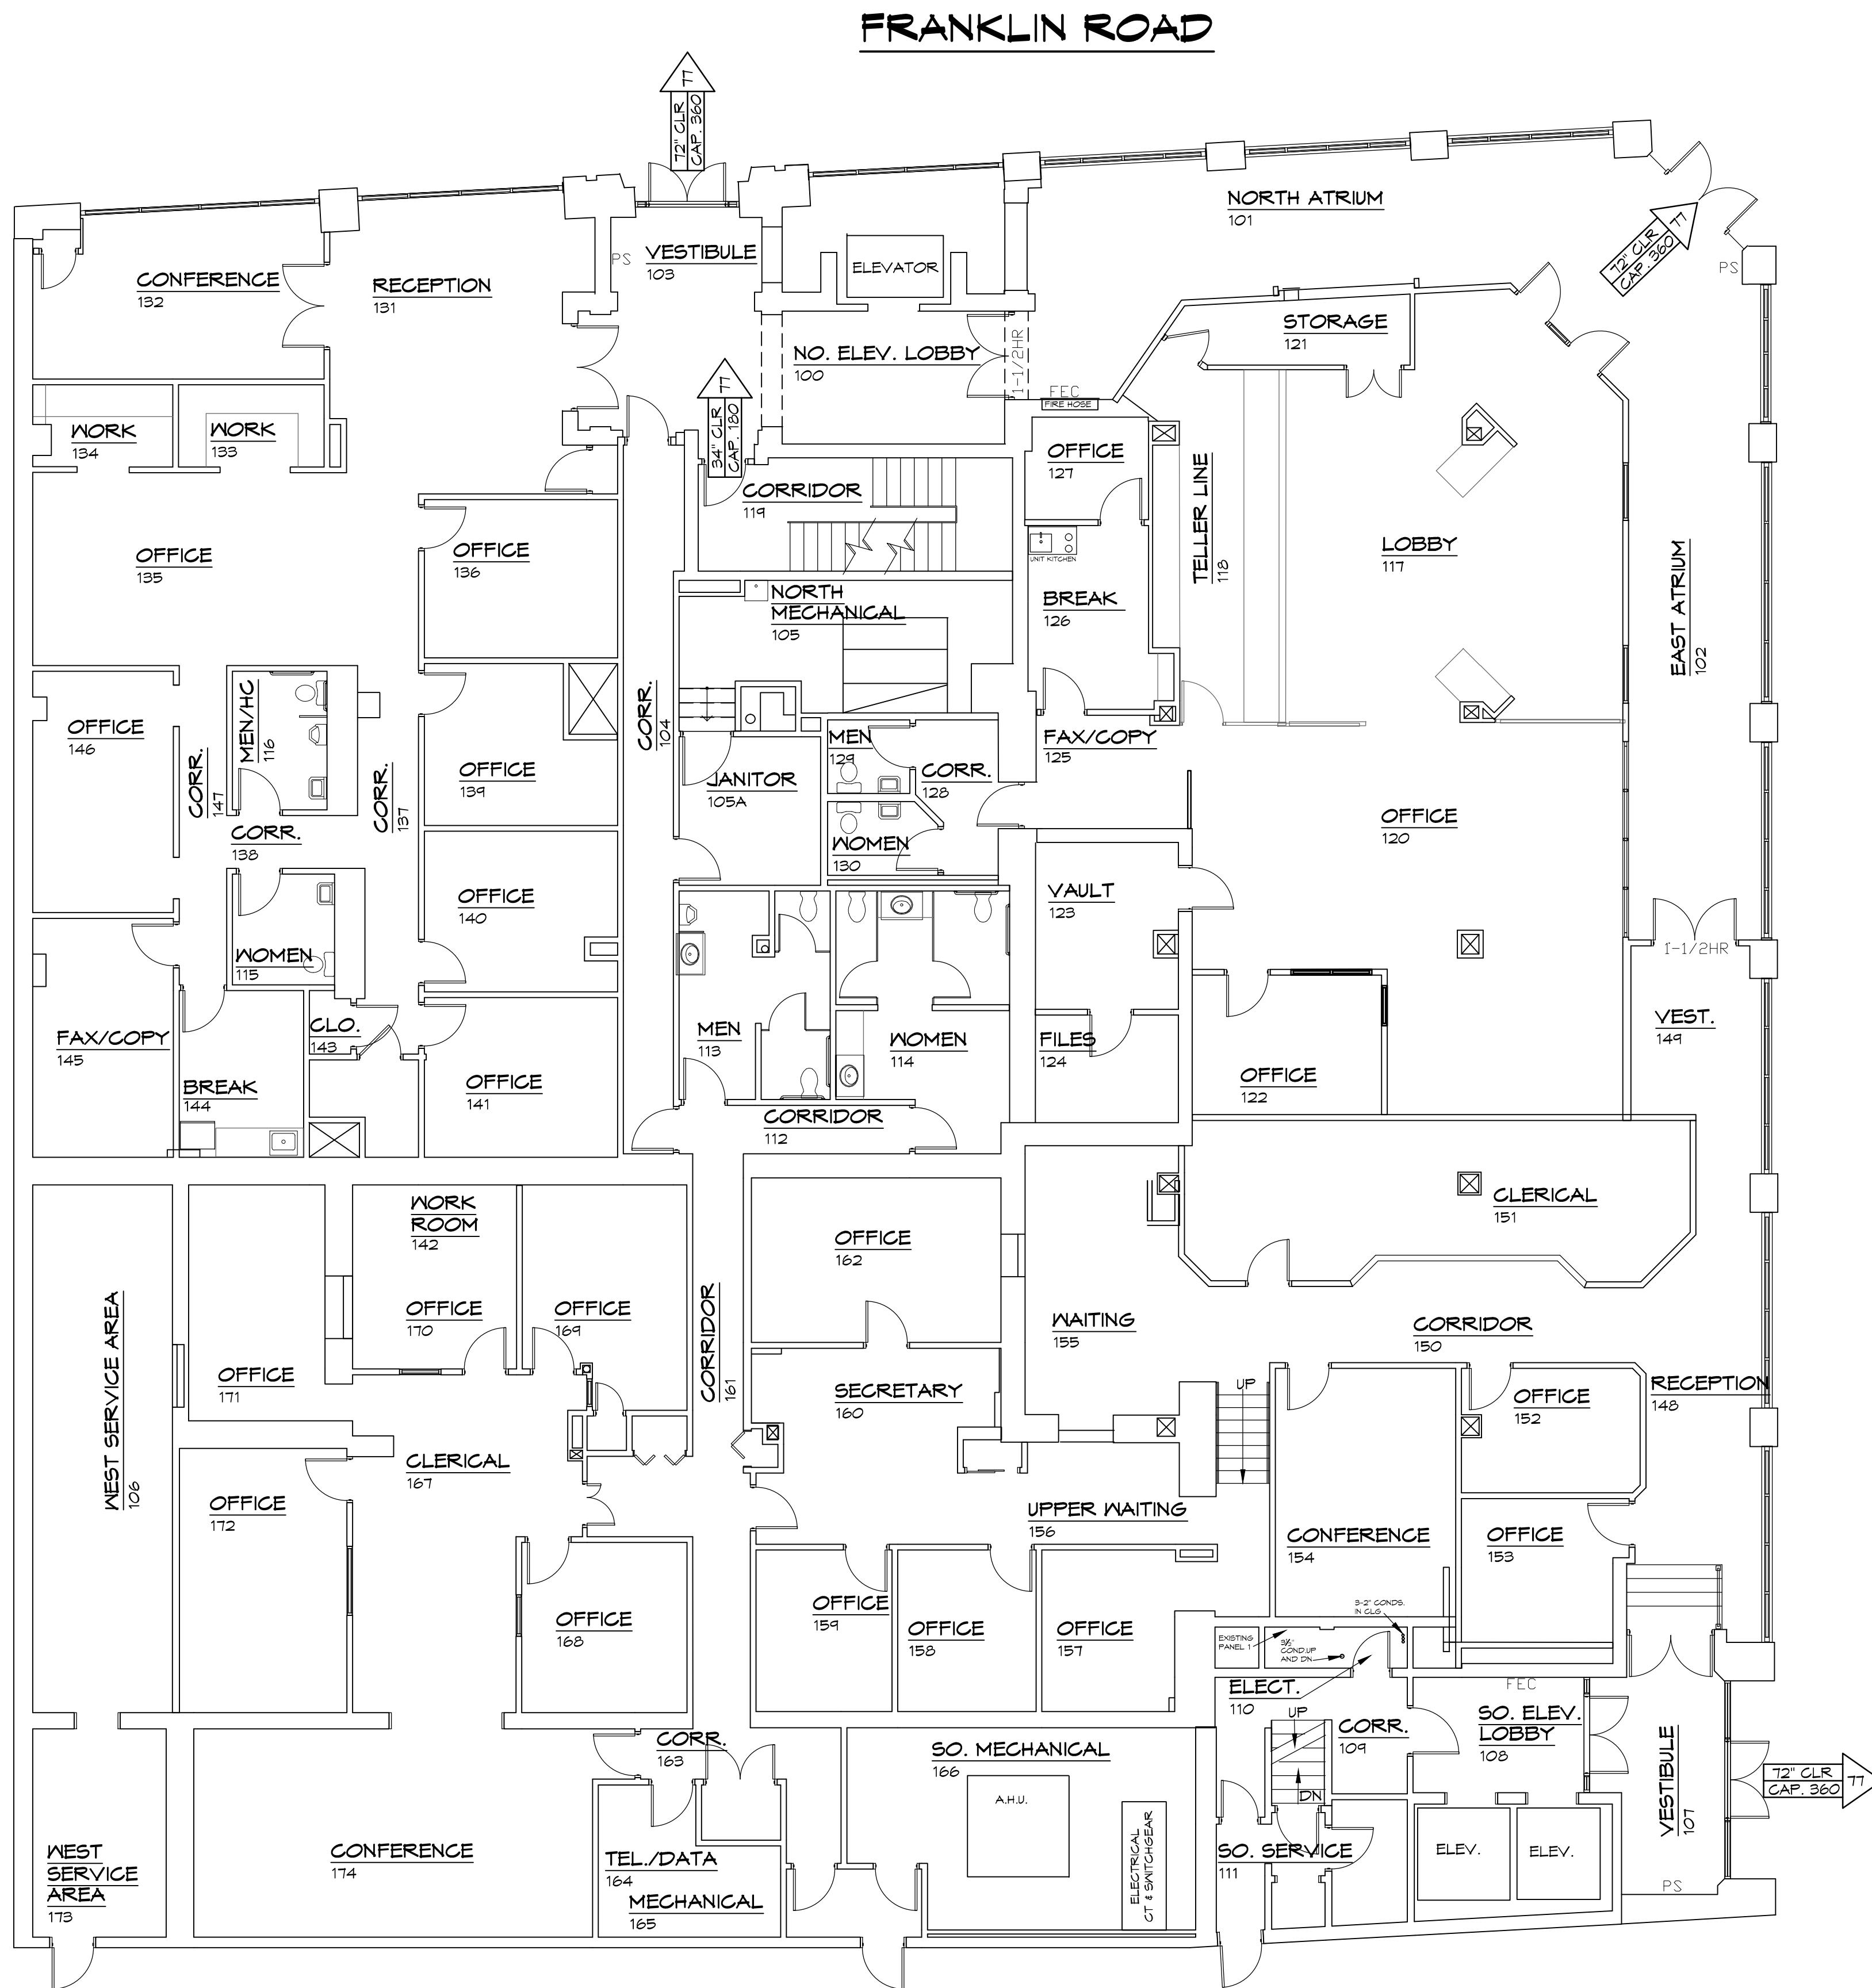

FIRST FLOOR PLAN

SCALE: 1/8" = 1'-0"

WIRING LEGEND

- DATA: WALL DATA
TELEPHONE: TELEPHONE
COAXIAL: ELECTRICAL
CABLE: REC.
- NEW RECEPTACLE ON NEW 40A CIRCUIT WITH ISOLATION GROUND
- NEW 2- 2" CONDUITS
- EXISTING RECEPTACLE TO REMAIN
- EXISTING PHONE JACK
- EXISTING DATA PORT
- EXISTING TOKEN RING PORT
- EXISTING WALL MOUNTED EMERGENCY LIGHT
- EXISTING CEILING MOUNTED EMERGENCY LIGHT
- EXISTING EXIT SIGN
- EXISTING FIRE ALARM PULL STATION
- NEW EXIT SIGN
- NEW LAY-IN FLUORESCENT WITH EMERGENCY BACK-UP