

DATE: March 22, 2005
REVISIONS
1
2
3
100

HUGHES
ASSOCIATES
ARCHITECTS
Architecture • Planning • Consulting

656 ELM AVENUE, S.W.
P.O. BOX 1034
ROANOKE, VIRGINIA 24005-1034

TEL (540) 342-4002
FAX (540) 342-2060
www.HughesArchitects.com




ALTERATIONS TO
WESTERN VIRGINIA
WATER AUTHORITY
COULTER BUILDING
601 South Jefferson Street Roanoke, Virginia

LIFE SAFETY
SECOND
FLOOR
PLAN

PHASE 1

COMMISSION No.
04102
SHEET
LS1-3
No. 4 of 13
COPYRIGHT 2005
HUGHES ASSOCIATES ARCHITECTS
A PROFESSIONAL CORPORATION

FRANKLIN ROAD

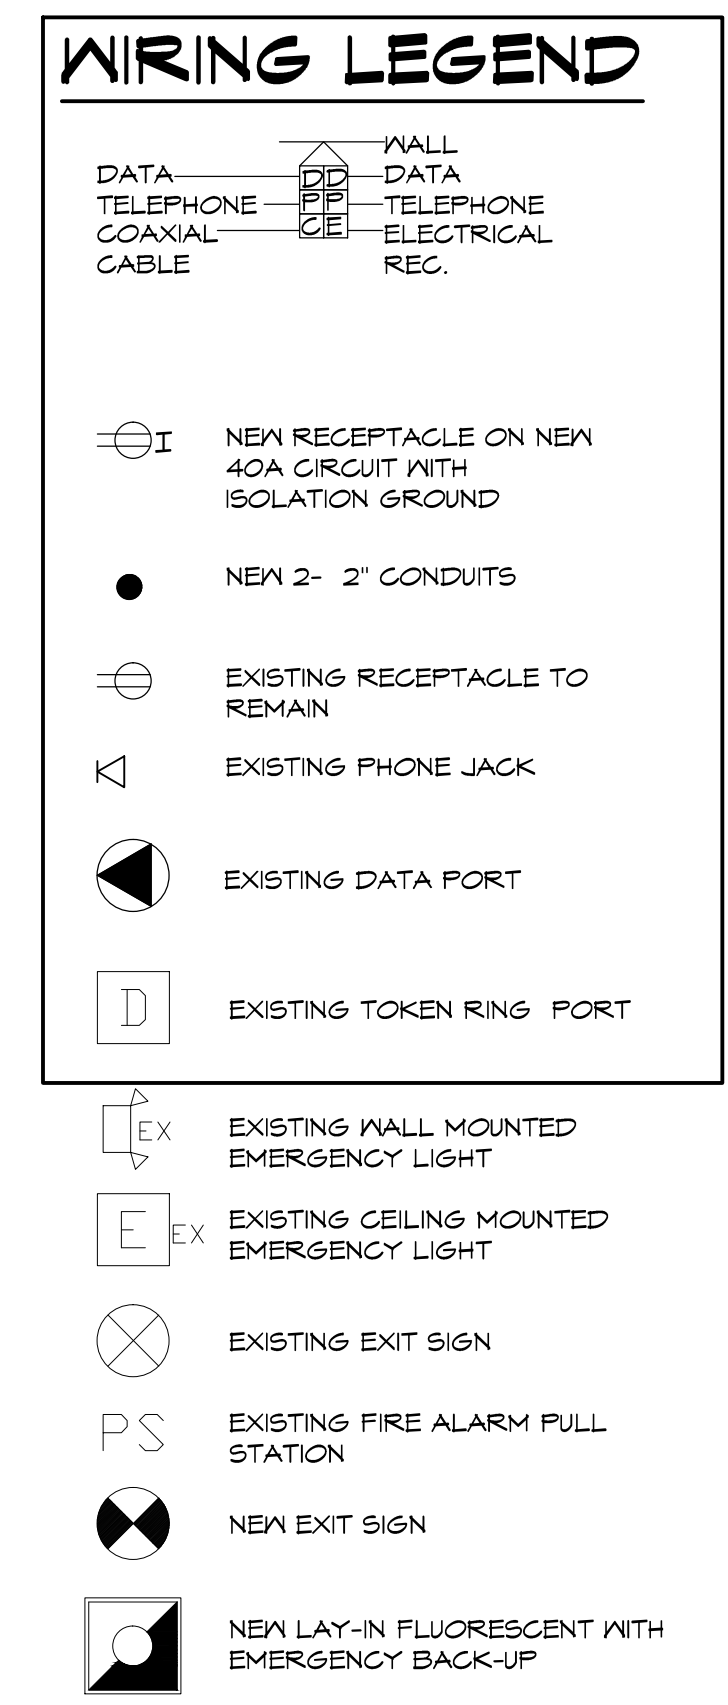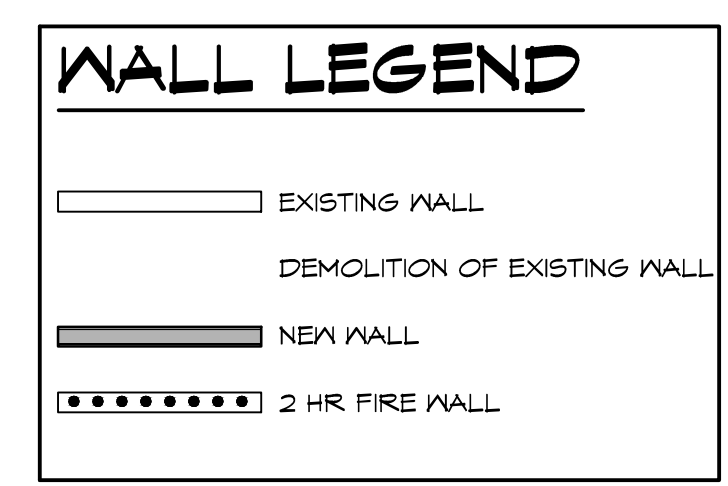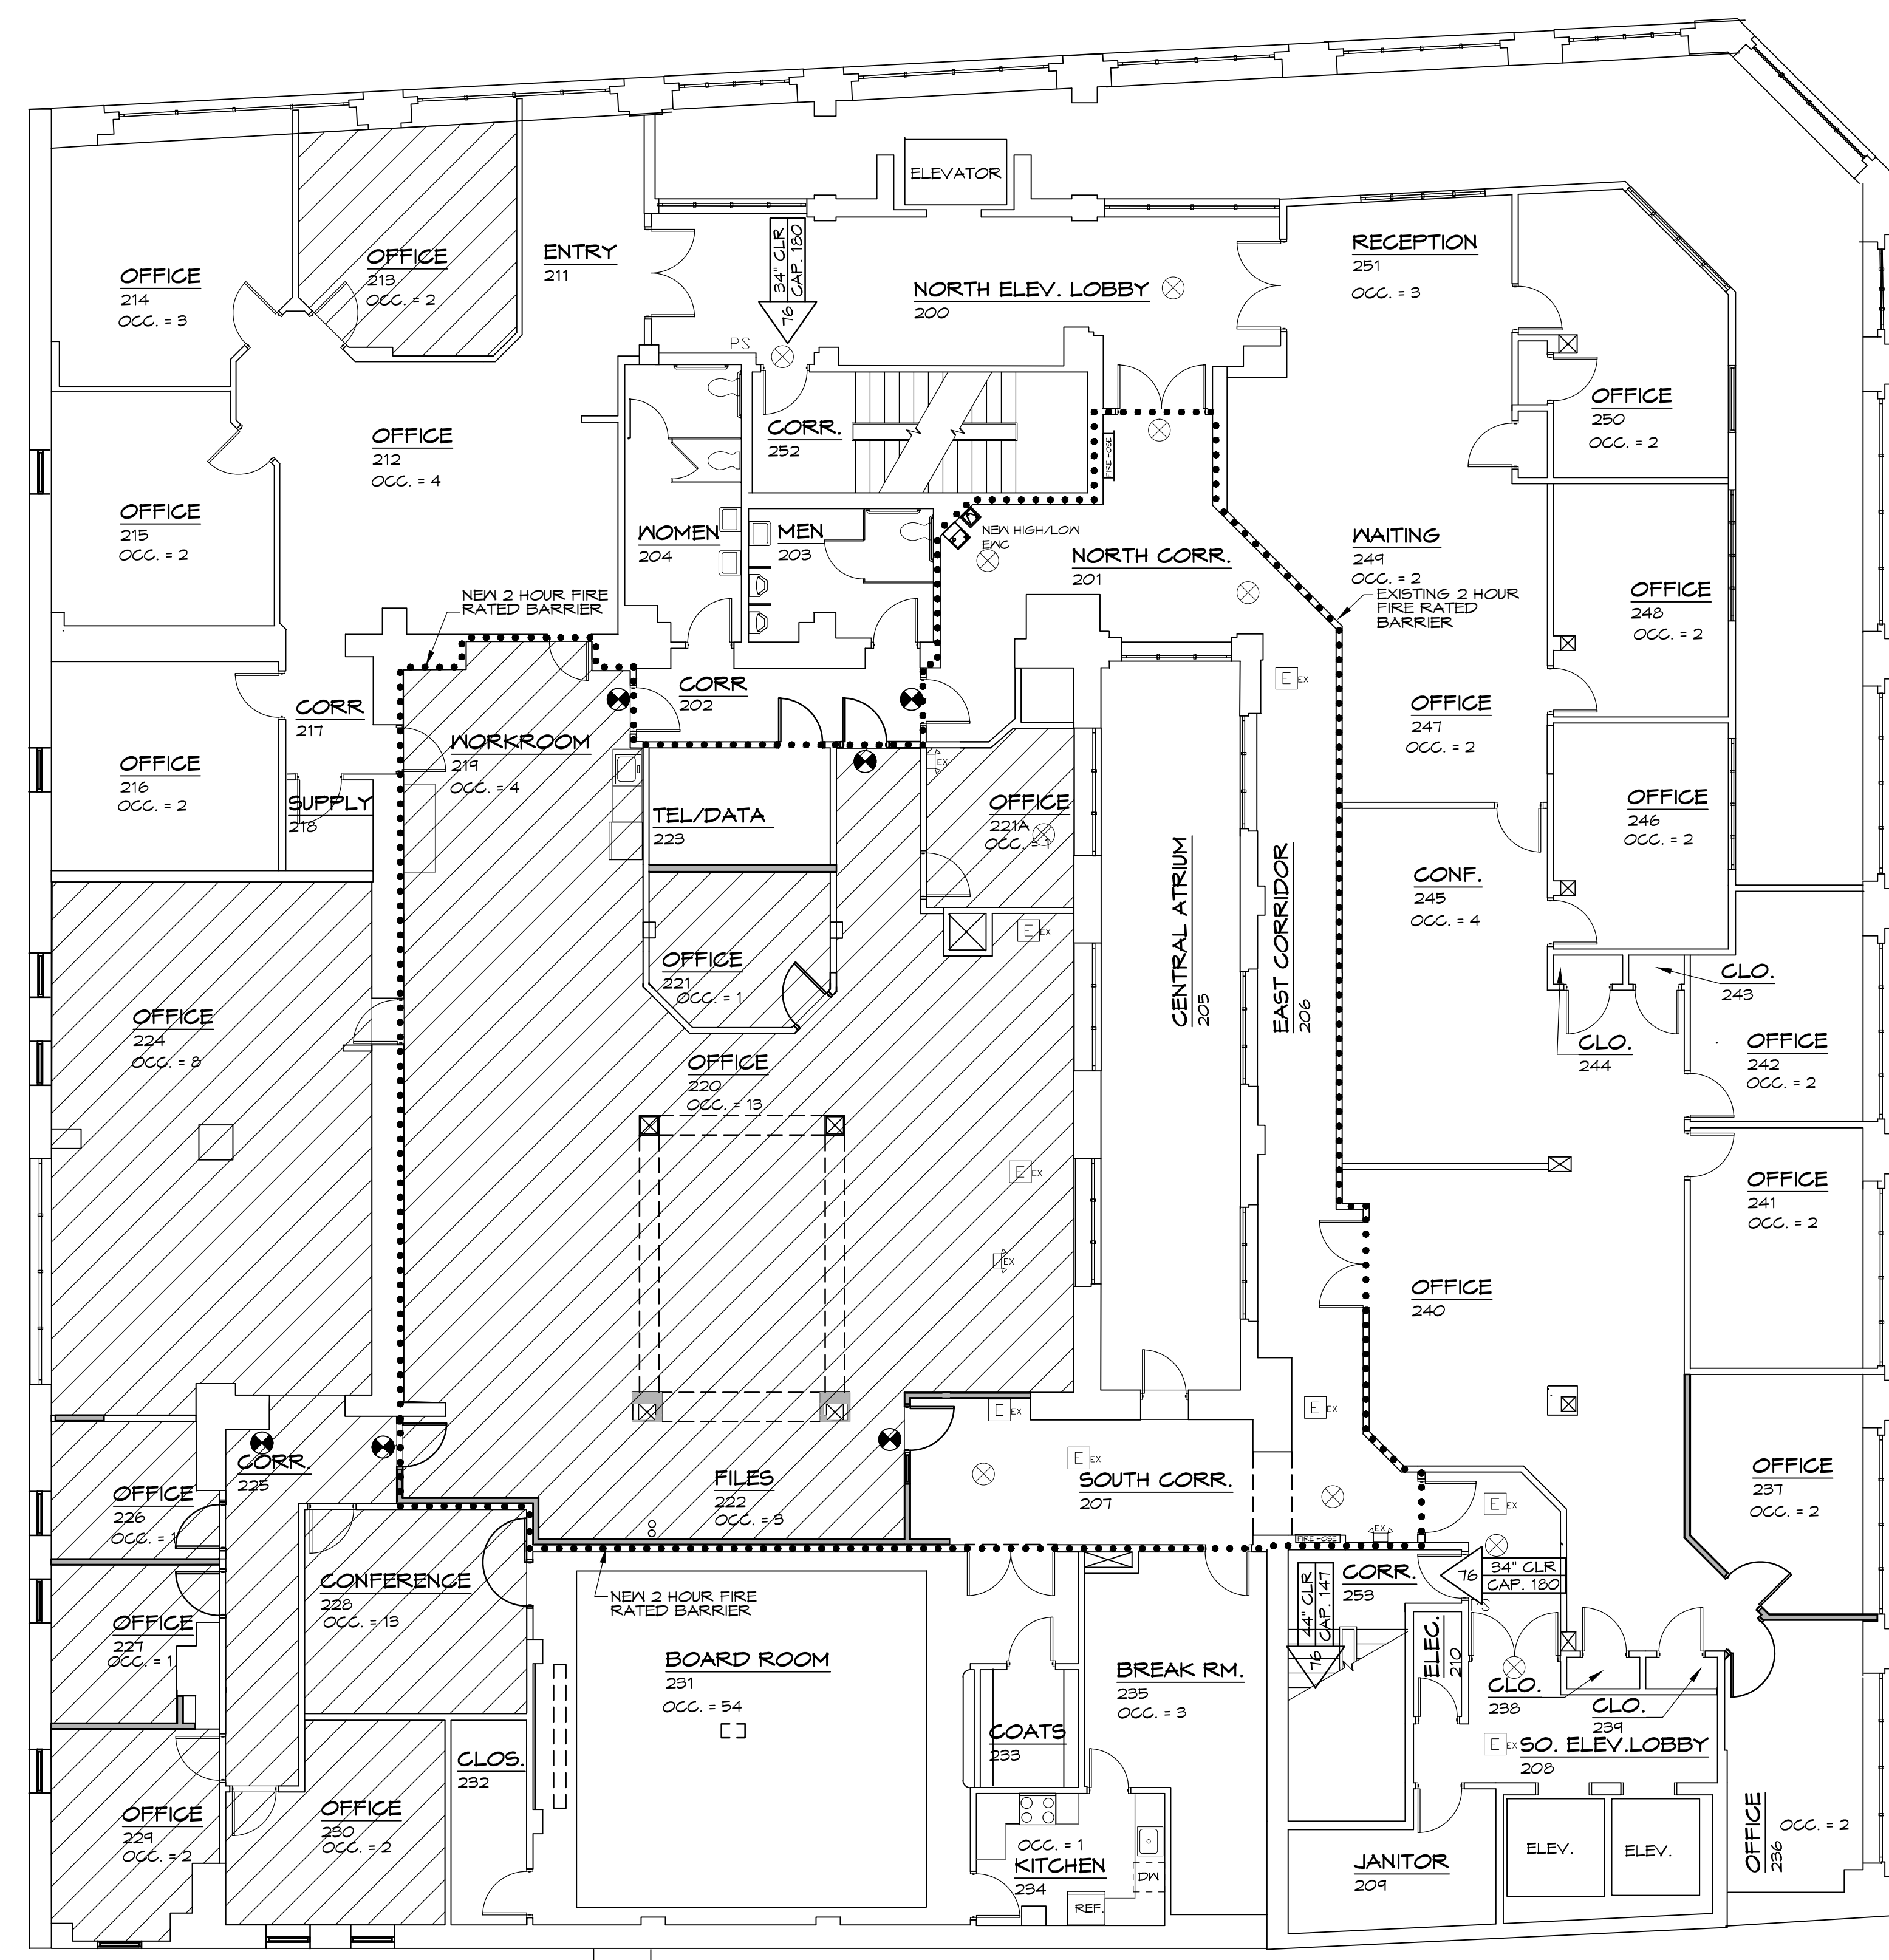

SECOND FLOOR PLAN
SCALE: 1/8" = 1'-0"

