

DATE:	March 22, 2005
DESIGNED BY:	△ May 3, 2005
CHECKED BY:	△
IN CHARGE:	△
REVISIONS:	△
BY:	△
DATE:	△

HUGHES ASSOCIATES ARCHITECTS
Architecture • Planning • Consulting

656 ELM AVENUE, S.W.
P.O. BOX 1034
ROANOKE, VIRGINIA 24005-1034

TEL (540) 342-4002
FAX (540) 342-2060
www.HughesArchitects.com


ALTERATIONS TO
**WESTERN VIRGINIA
WATER AUTHORITY
COULTER BUILDING**
601 South Jefferson Street Roanoke, Virginia

BASEMENT
FLOOR
PLAN

PHASE 1

WALL LEGEND	
	EXISTING WALL
	DEMOLITION OF EXISTING WALL
	NEW WALL
	2 HR FIRE WALL

COMMISSION No.
04102
SHEET
A1-1
No. 2 OF 13
© COPYRIGHT 2005
HUGHES ASSOCIATES ARCHITECTS
A PROFESSIONAL CORPORATION

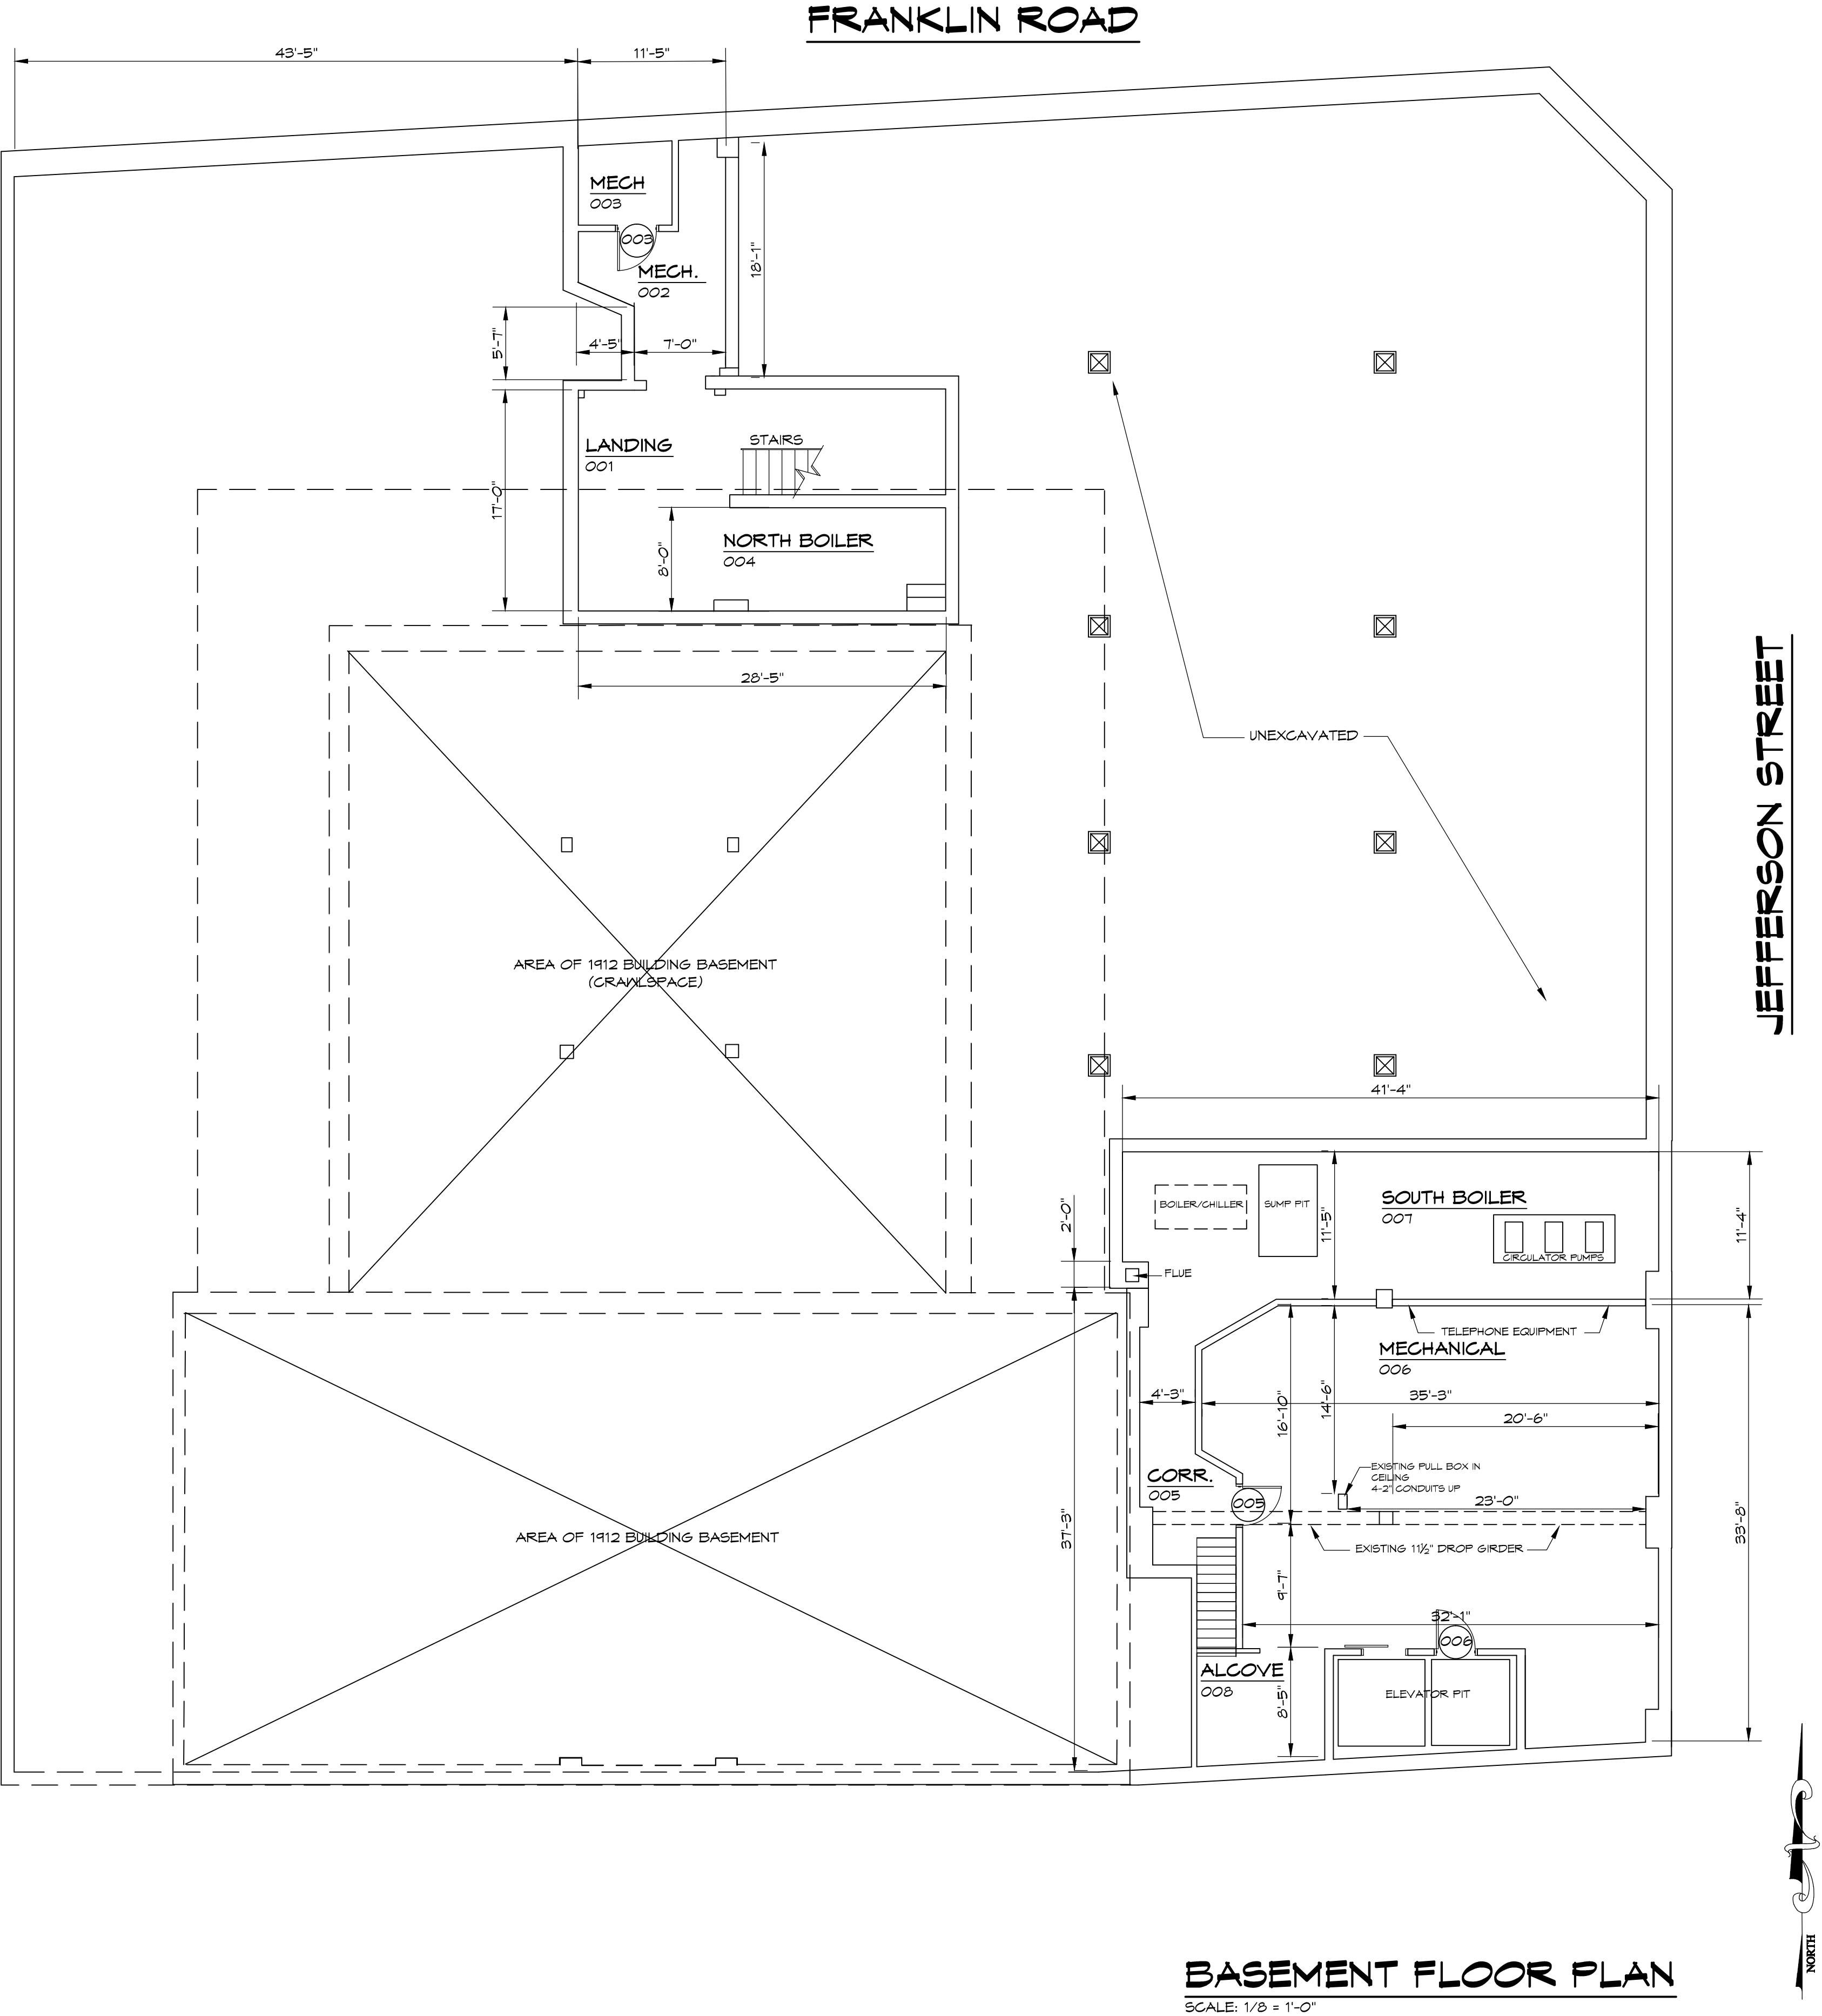

BASEMENT FLOOR PLAN
SCALE: 1/8" = 1'-0"