

DATE: March 18, 2005	
REVISIONS	Δ
	Δ
	Δ
	Δ
	Δ

HUGHES ASSOCIATES ARCHITECTS
 Architecture • Planning • Consulting

656 ELM AVENUE, S.W.
 P.O. BOX 1034
 ROANOKE, VIRGINIA 24005-1034

TEL (540) 342-4002
 FAX (540) 342-2060
 www.HughesArchitects.com

ALTERATIONS TO
 WESTERN VIRGINIA
 WATER AUTHORITY
 COULTER BUILDING
 601 South Jefferson Street Roanoke, Virginia

BASEMENT FLOOR PLAN (TELEPHONE, DATA, POWER & ELECTRICAL)

PHASE I


COMMISSION No.
04102
 SHEET
E1-1

No. 8 OF 13

© COPYRIGHT 2005 HUGHES ASSOCIATES ARCHITECTS & PROFESSIONAL ENGINEERS

FRANKLIN ROAD

JEFFERSON STREET

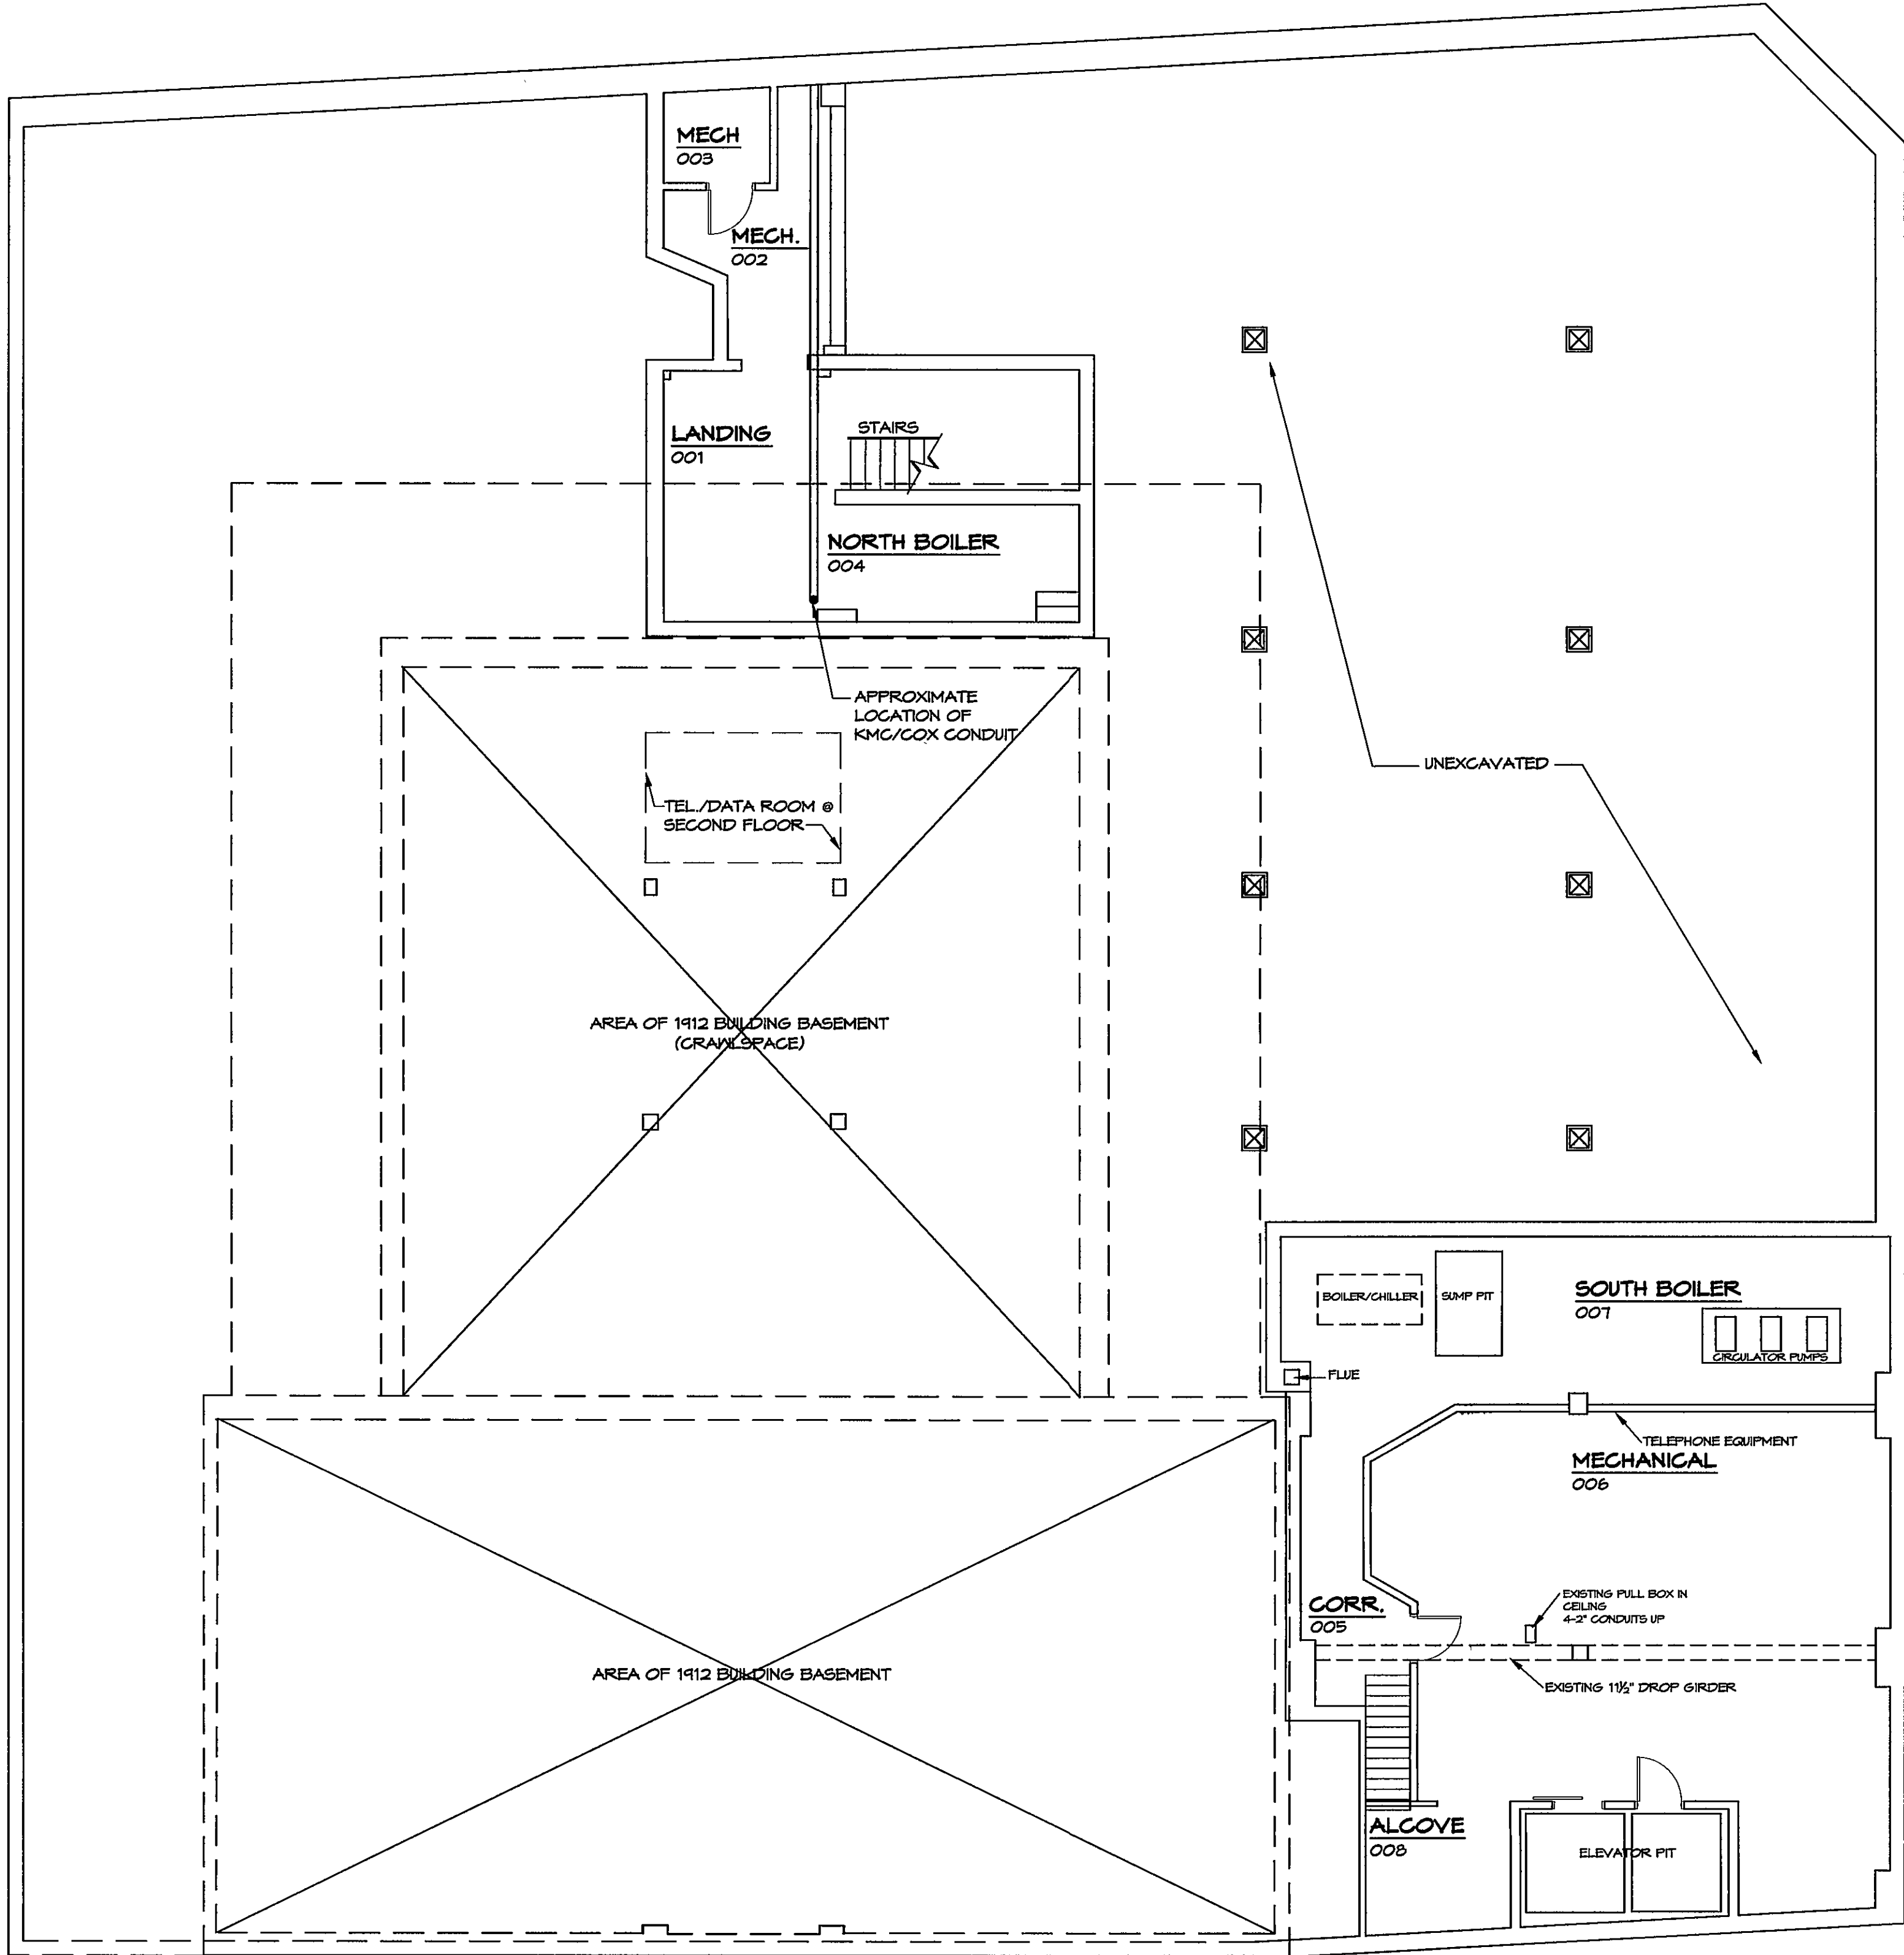

BASEMENT FLOOR PLAN

SCALE: 1/8" = 1'-0"

WIRING LEGEND

DATA ——— DATA
 TELEPHONE ——— TELEPHONE
 COAXIAL ——— COAXIAL
 CABLE ——— CABLE

ON NEW WALLS, PROVIDE 1 BOX FOR EACH OUTLET NOTED. EXTEND A 3/4" CONDUIT FROM THE BOX 6" INTO CEILING WITH A SNEEP 90. TERMINATED IN A BUSHING. WIRING TO BE PROVIDED BY OWNER.

● PROPOSED KMC/COX CONDUITS

⊕ EXISTING RECEPTACLE TO REMAIN

◀ EXISTING PHONE JACK

◐ EXISTING DATA PORT

◑ EXISTING TOKEN RING PORT