

DATE: March 22, 2005

REVISIONS
Δ
Δ
Δ
Δ
Δ

**HUGHES
ASSOCIATES
ARCHITECTS**

Architecture • Planning • Consulting

656 ELM AVENUE, S.W.
P.O. BOX 1034
ROANOKE, VIRGINIA 24005-1034

TEL (540) 342-4002
FAX (540) 342-2060
www.HughesArchitects.com

ALTERATIONS TO
WESTERN VIRGINIA
WATER AUTHORITY
COULTER BUILDING
601 South Jefferson Street Roanoke, Virginia

BASEMENT
FLOOR
PLAN
(TELEPHONE,
DATA,
POWER &
ELECTRICAL)

PHASE I

COMMISSION No.

04102

SHEET


E1-1

No. 2 of 13

COPYRIGHT 2005
HUGHES ASSOCIATES ARCHITECTS
A PROFESSIONAL CORPORATION

FRANKLIN ROAD

JEFFERSON STREET

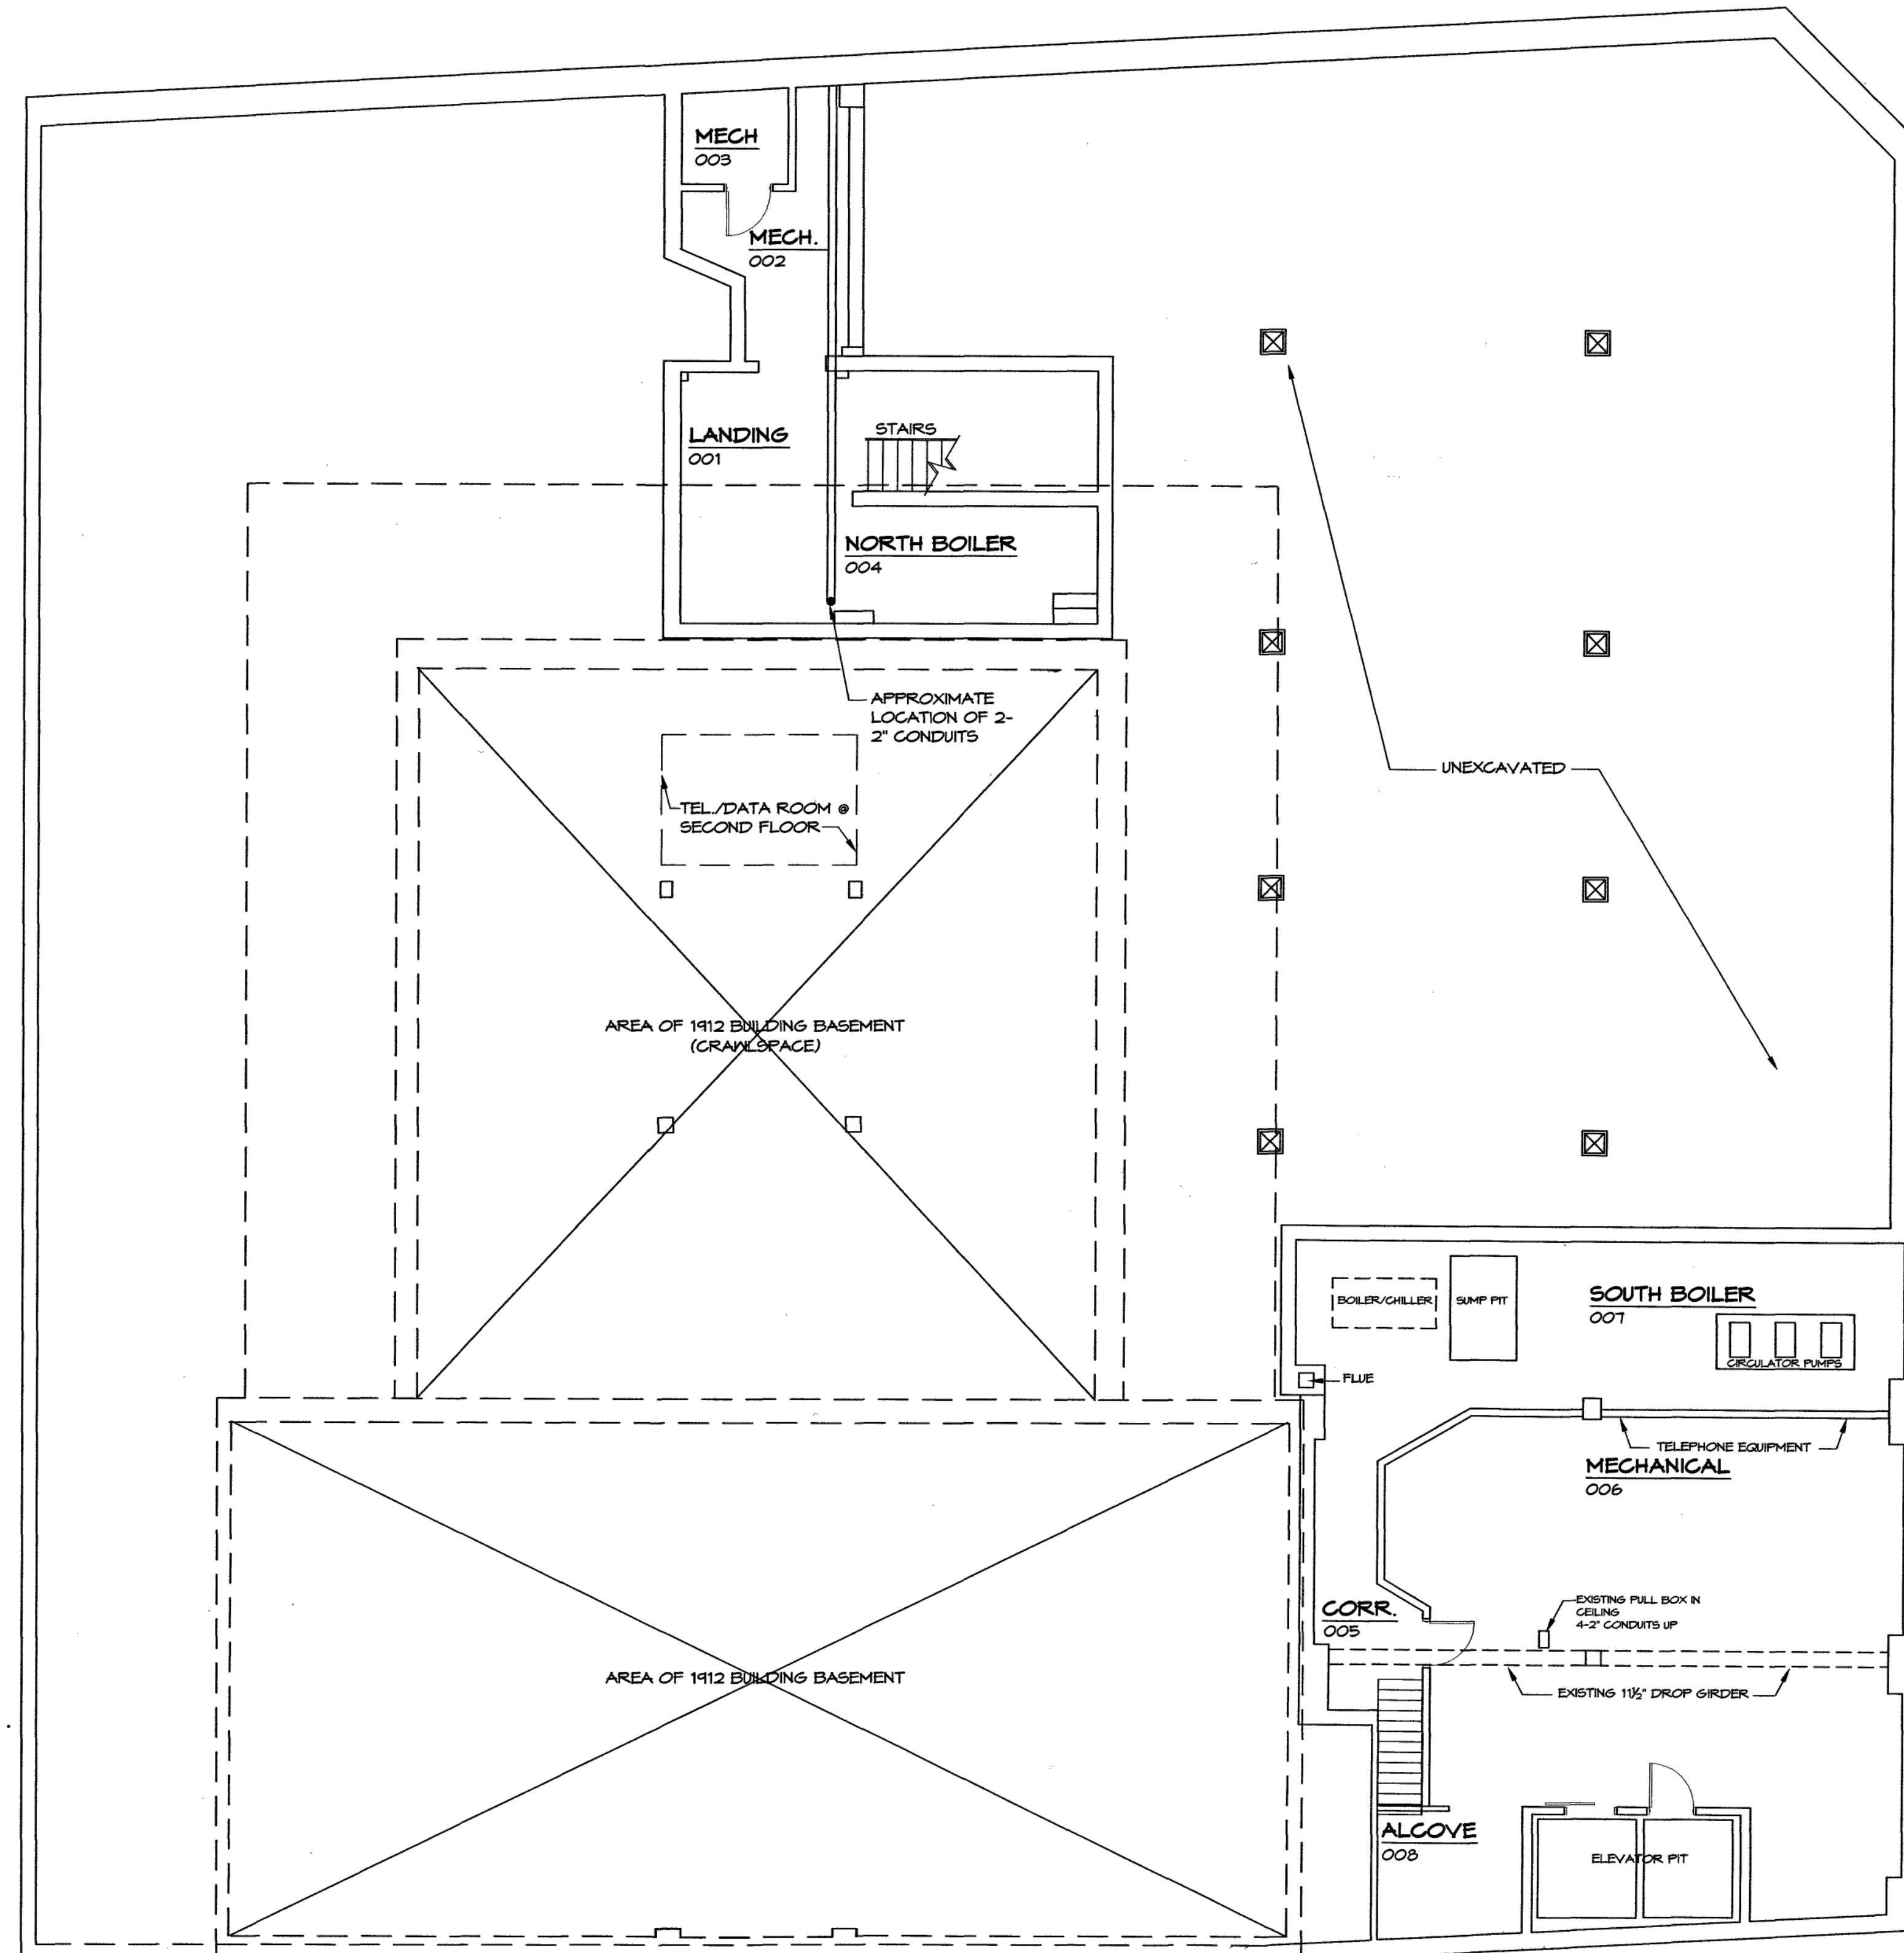

BASEMENT FLOOR PLAN

SCALE: 1/8" = 1'-0"

WIRING LEGEND

DATA
TELEPHONE
COAXIAL
CABLE

WALL
DATA
TELEPHONE
ELECTRICAL
REG.

NEW RECEPTACLE ON NEW
40A CIRCUIT WITH
ISOLATION GROUND

NEW 2- 2" CONDUITS

EXISTING RECEPTACLE TO
REMAIN

EXISTING PHONE JACK

EXISTING DATA PORT

EXISTING TOKEN RING PORT