

ALTERATIONS TO
WESTERN VIRGINIA
WATER AUTHORITY
COULTER BUILDING
601 South Jefferson Street Roanoke, Virginia

FIRST
FLOOR
PLAN
(TELEPHONE,
DATA,
POWER &
ELECTRICAL)


PHASE I

COMMISSION No.
04102
SHEET
E1-2
No. 1 of 13

COPYRIGHT 2005
HUGHES ASSOCIATES ARCHITECTS
& PROFESSIONAL ENGINEERS

FRANKLIN ROAD

E1-1
E1-2
PHASE 1

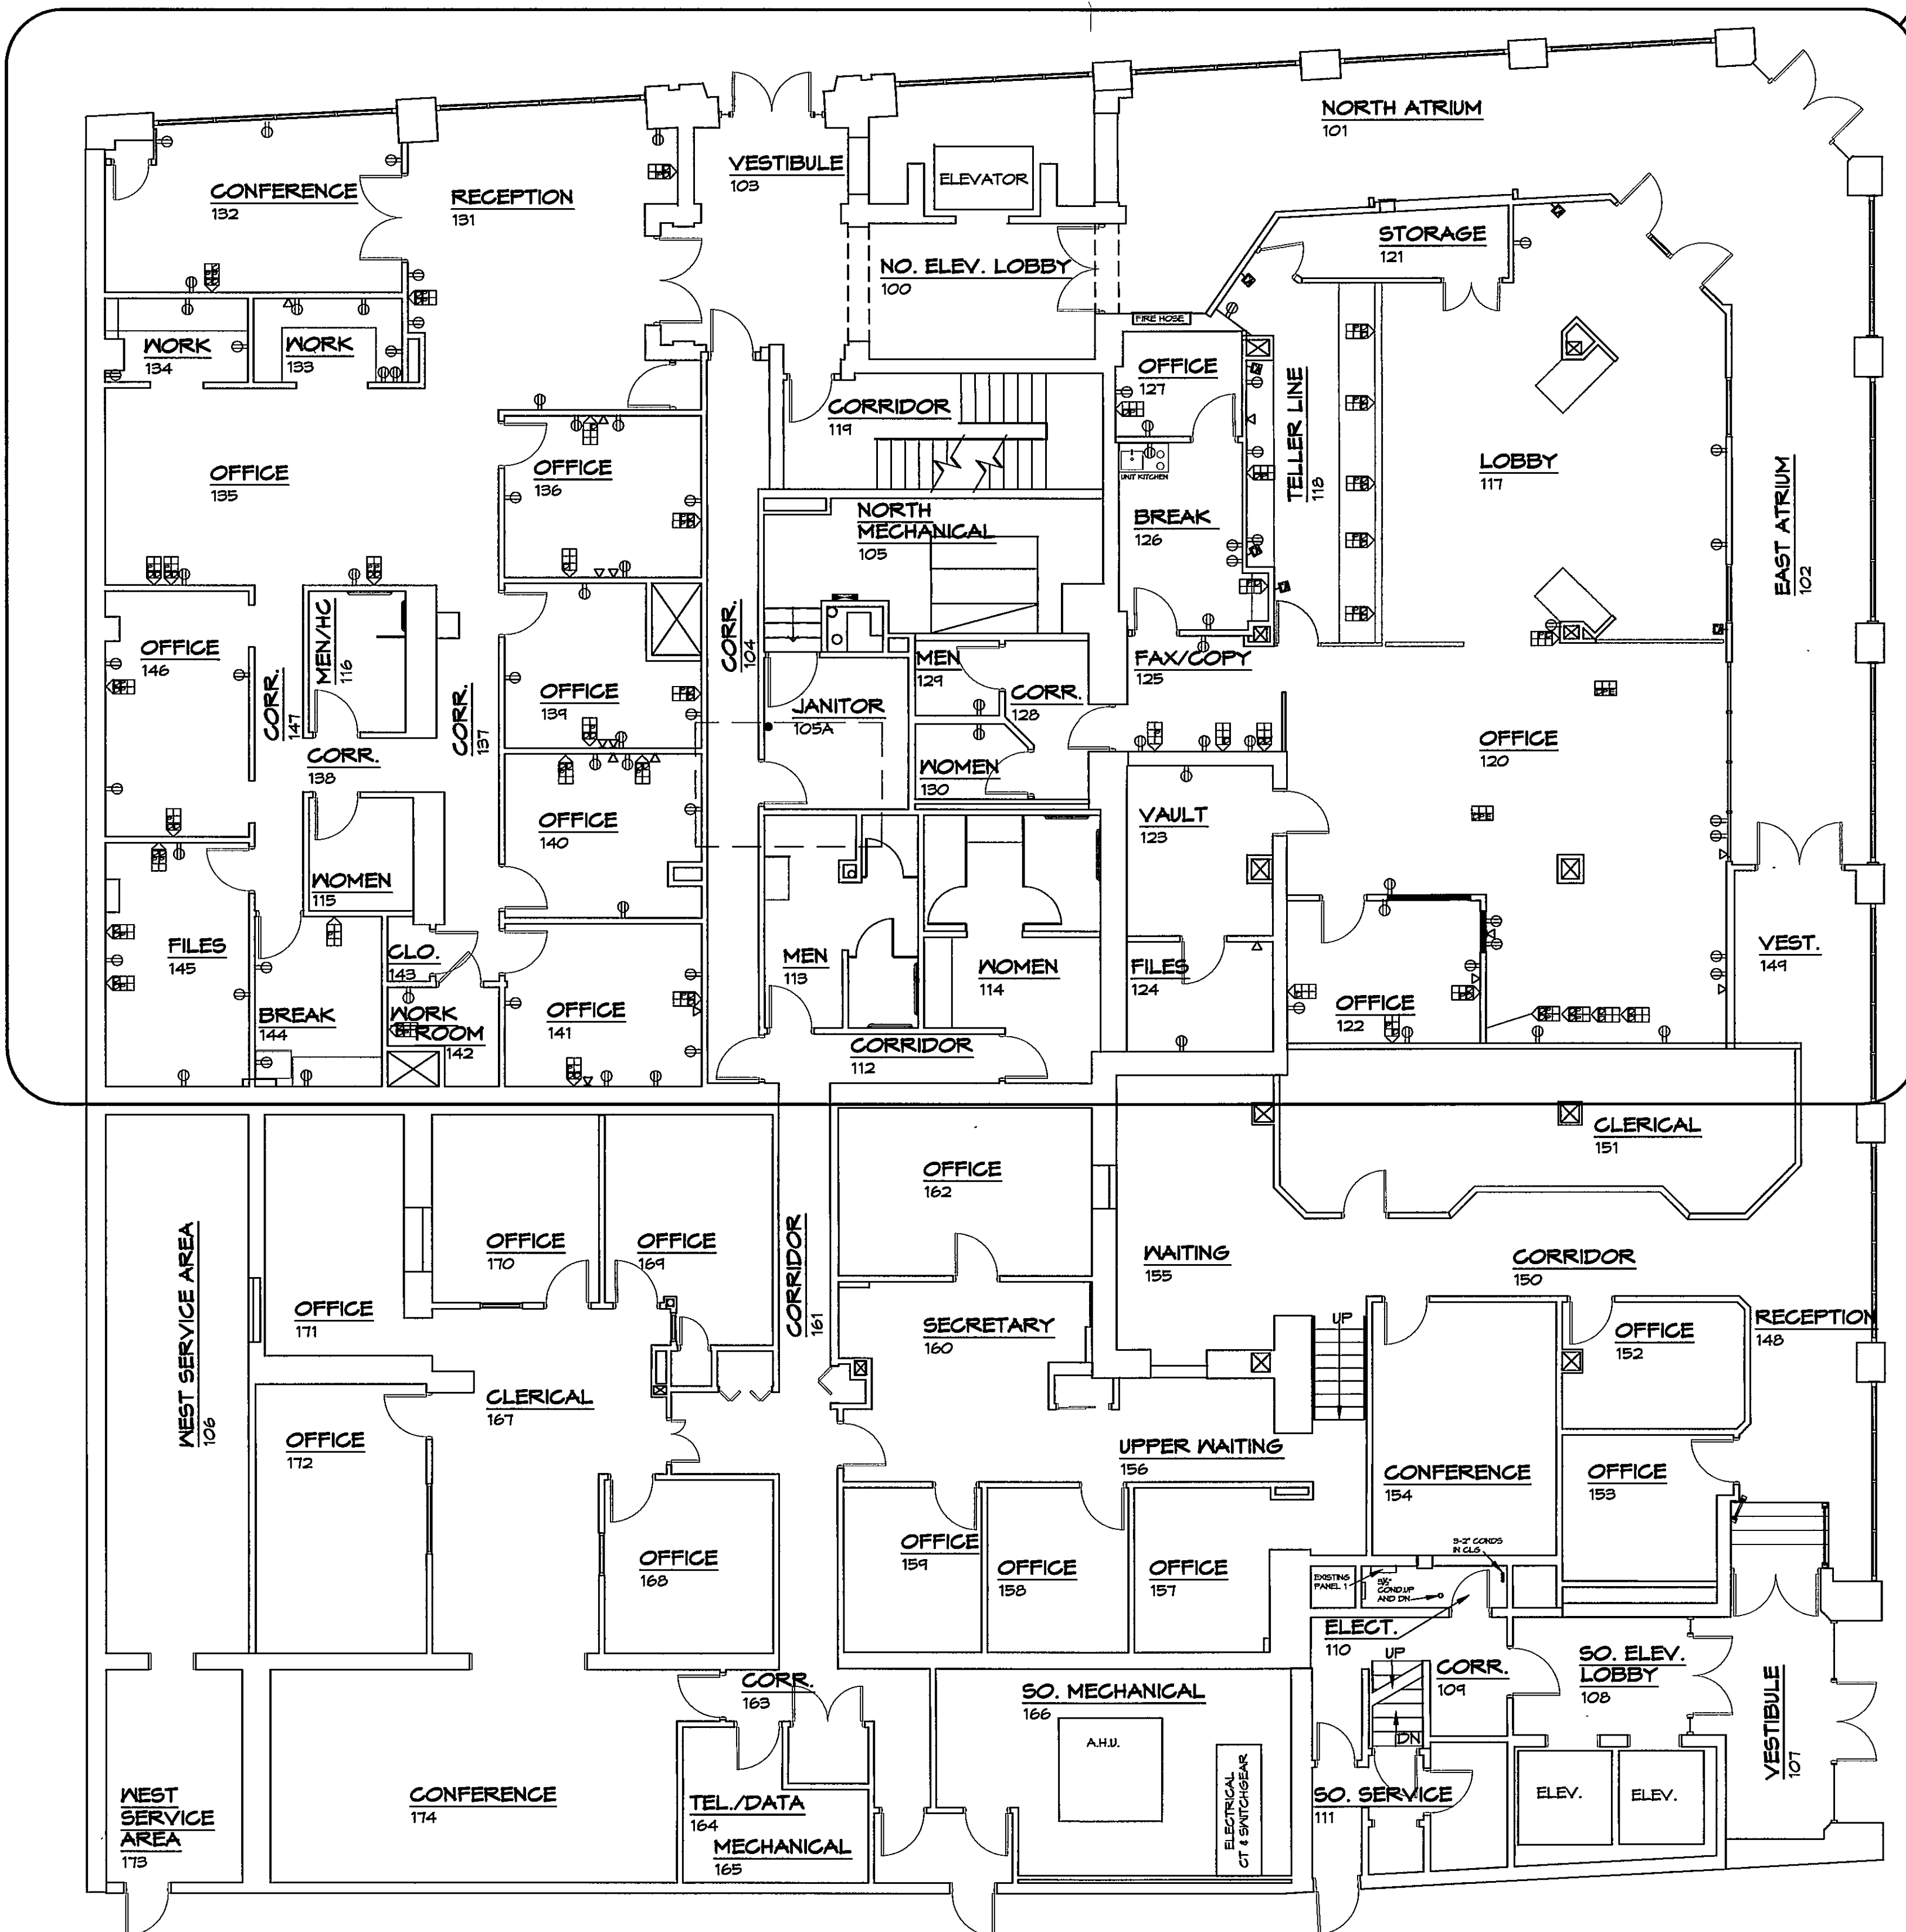

JEFFERSON STREET

FIRST FLOOR PLAN
SCALE: 1/8" = 1'-0"

WIRING LEGEND

DATA — DATA
TELEPHONE — TELEPHONE
COAXIAL — COAXIAL
CABLE — CABLE

ON NEW WALLS, PROVIDE 1 BOX FOR EACH OUTLET NOTED. EXTEND A 3/4" CONDUIT FROM THE BOX 6" INTO CEILING WITH A SNEEP 30, TERMINATED IN A BUSHING. WIRING TO BE PROVIDED BY OWNER.

● PROPOSED KMC/COX CONDUITS

⊕ EXISTING RECEPTACLE TO REMAIN

⊞ EXISTING PHONE JACK

◐ EXISTING DATA PORT

◑ EXISTING TOKEN RING PORT