

DATE: March 22, 2005
REVISIONS
Δ
Δ
Δ
Δ
Δ
Δ

HUGHES ASSOCIATES ARCHITECTS
Architecture • Planning • Consulting

656 ELM AVENUE, S.W.
P.O. BOX 1034
ROANOKE, VIRGINIA 24005-1034

TEL (540) 342-4002
FAX (540) 342-2060
www.HughesArchitects.com

ALTERATIONS TO
**WESTERN VIRGINIA
WATER AUTHORITY
COULTER BUILDING**
601 South Jefferson Street Roanoke, Virginia

**BASEMENT
FLOOR
PLAN
(TELEPHONE,
DATA,
POWER &
ELECTRICAL)**

PHASE I

JACK
No's

4.26.05

COMMISSION No.

04102


SHEET

E1-1

No. 8 of 13

© COPYRIGHT 2005
HUGHES ASSOCIATES ARCHITECTS
A PROFESSIONAL CORPORATION

FRANKLIN ROAD

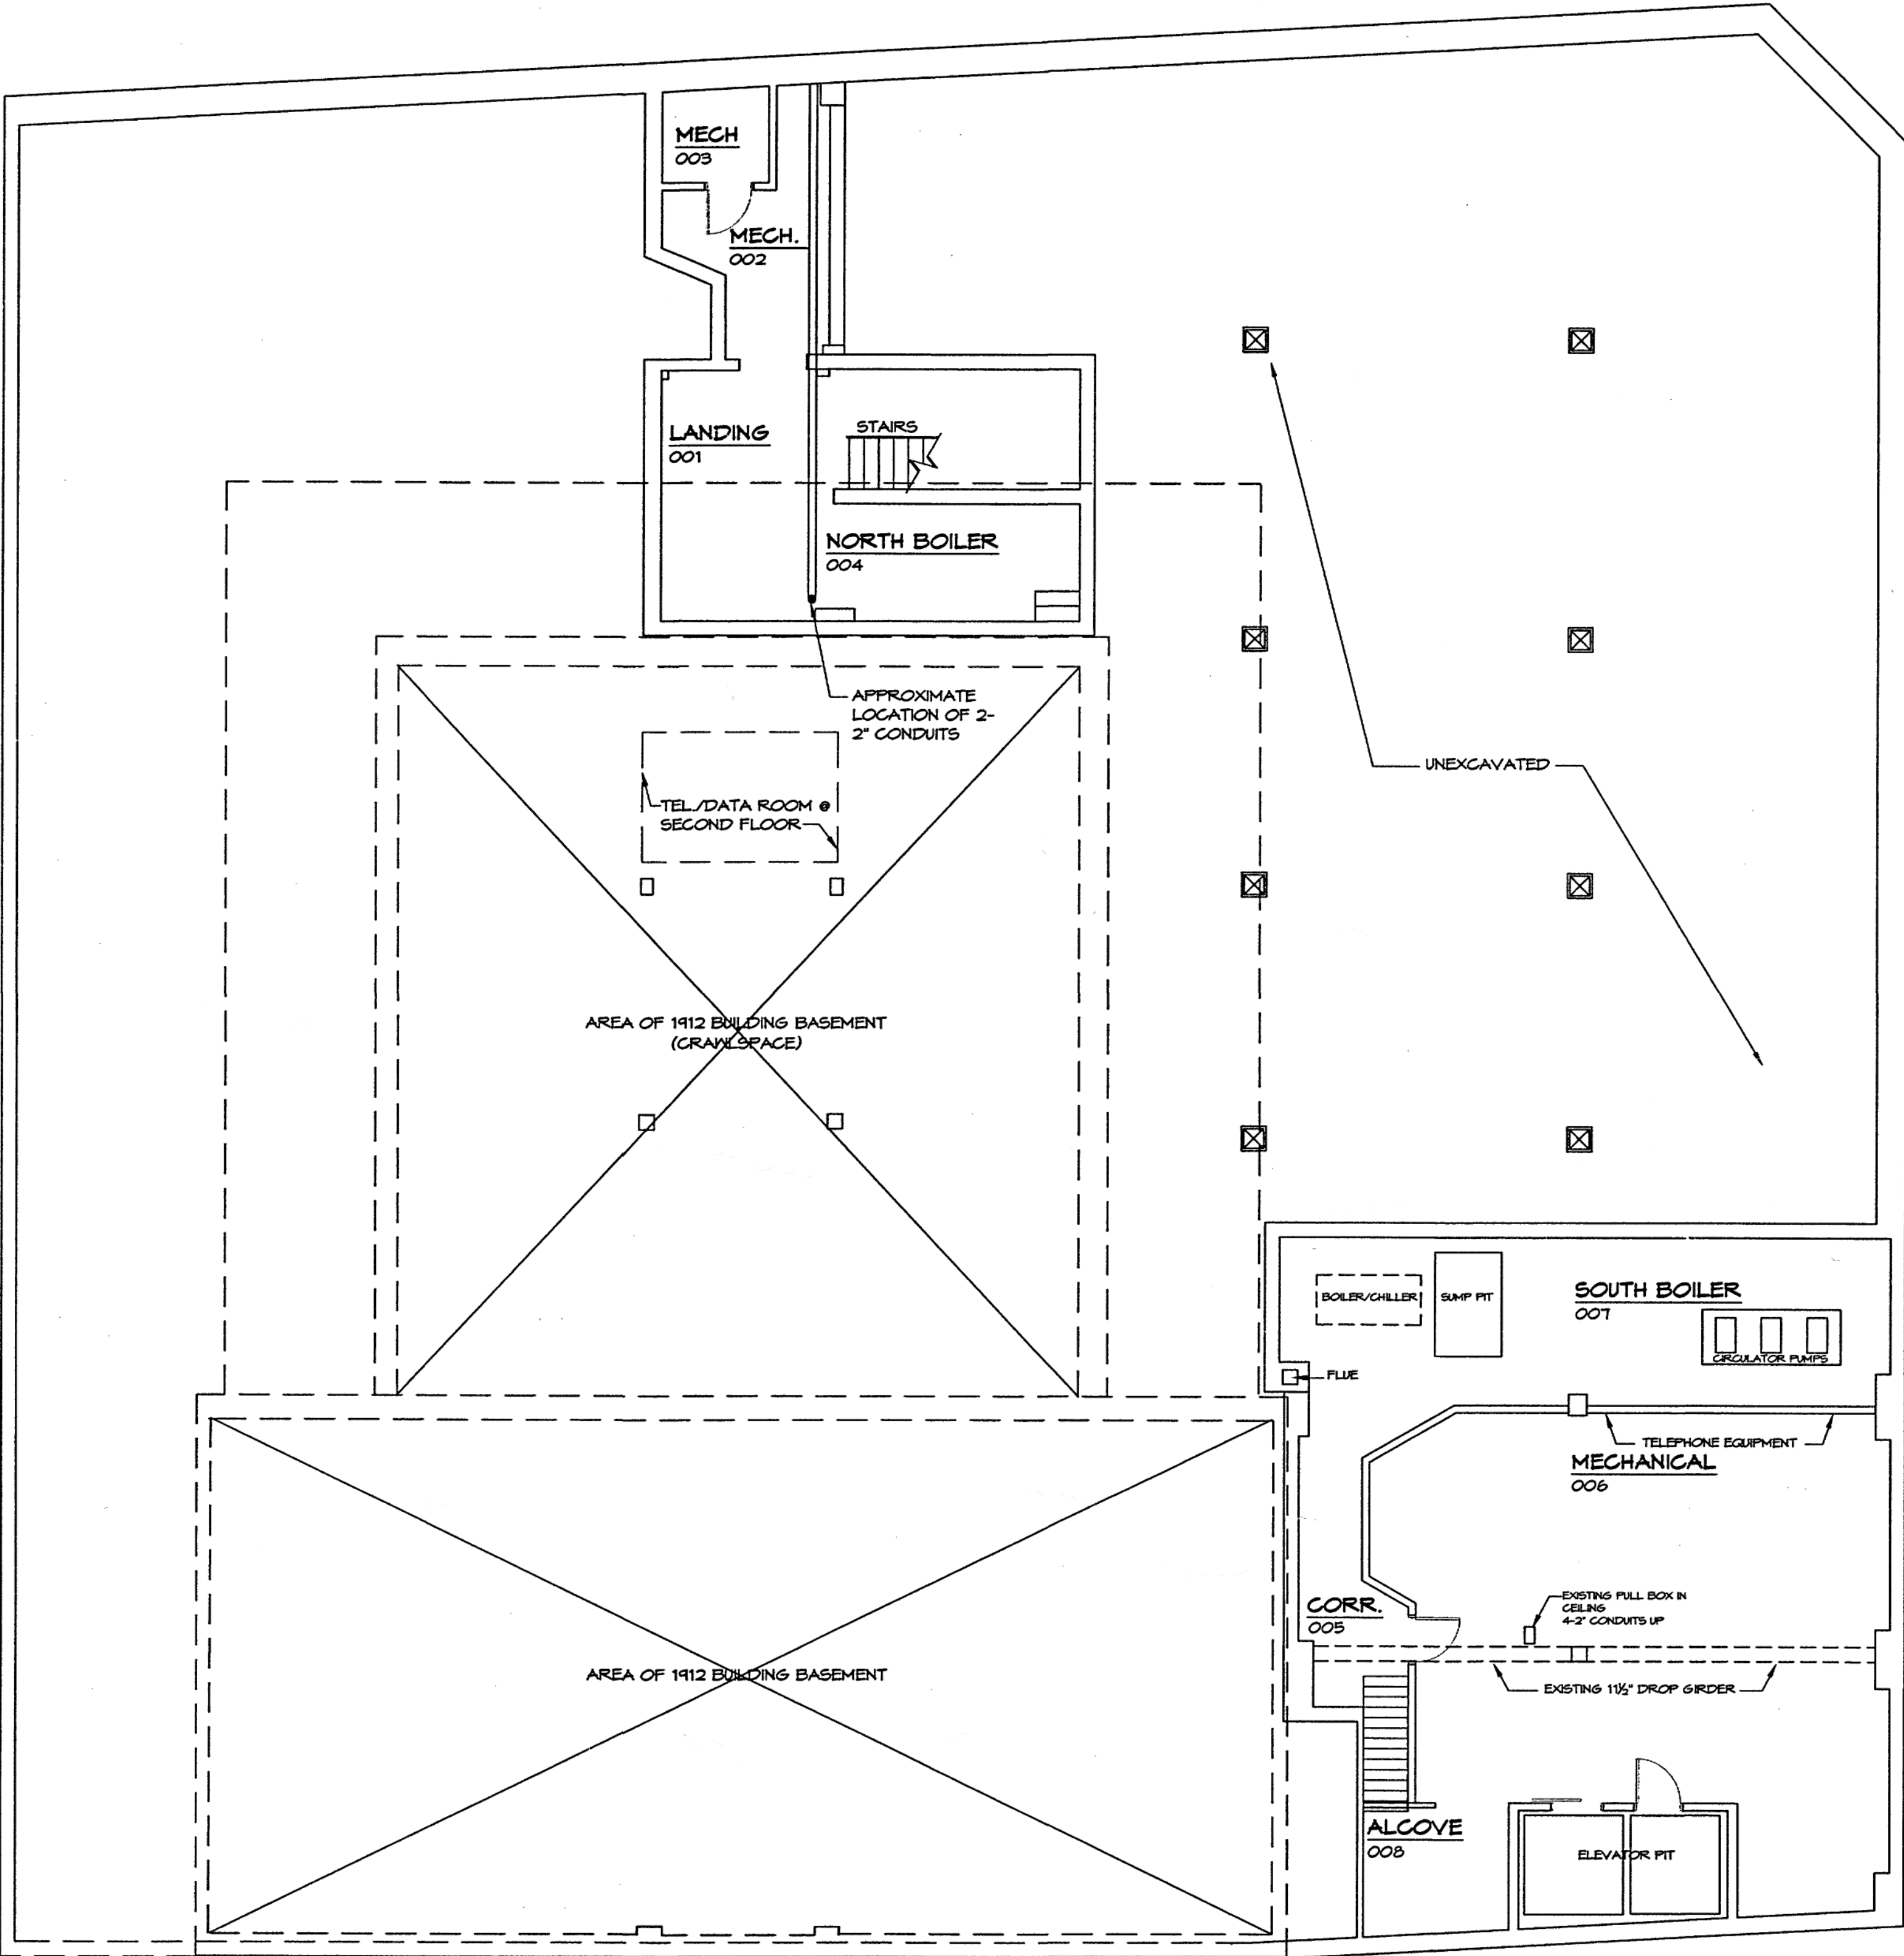

BASEMENT FLOOR PLAN
SCALE: 1/8" = 1'-0"

WIRING LEGEND

- DATA TELEPHONE COAXIAL CABLE
- WALL DATA TELEPHONE ELECTRICAL REC.
- NEW RECEPTACLE ON NEW 40A CIRCUIT WITH ISOLATION GROUND
- NEW 2- 2" CONDUITS
- EXISTING RECEPTACLE TO REMAIN
- EXISTING PHONE JACK
- EXISTING DATA PORT
- EXISTING TOKEN RING PORT