

DATE:	March 22, 2005
REVISIONS	
Δ	
Δ	
Δ	
Δ	

HUGHES ASSOCIATES ARCHITECTS
 Architecture • Planning • Consulting

656 ELM AVENUE, S.W.
 P.O. BOX 1034
 ROANOKE, VIRGINIA 24005-1034



TEL (540) 342-4002
 FAX (540) 342-2060
 www.HughesArchitects.com

**ALTERATIONS TO
 WESTERN VIRGINIA
 WATER AUTHORITY
 COULTER BUILDING**
 601 South Jefferson Street Roanoke, Virginia

**ENLARGED FLOOR PLAN
 (TELEPHONE, DATA, POWER & ELECTRICAL)**

PHASE I
 Jack No's
 4/26/2005

COMMISSION No.
 04102
 SHEET
E1-4
 No. 11 of 19
 COPYRIGHT 2005
 HUGHES ASSOCIATES ARCHITECTS
 A PROFESSIONAL CORPORATION

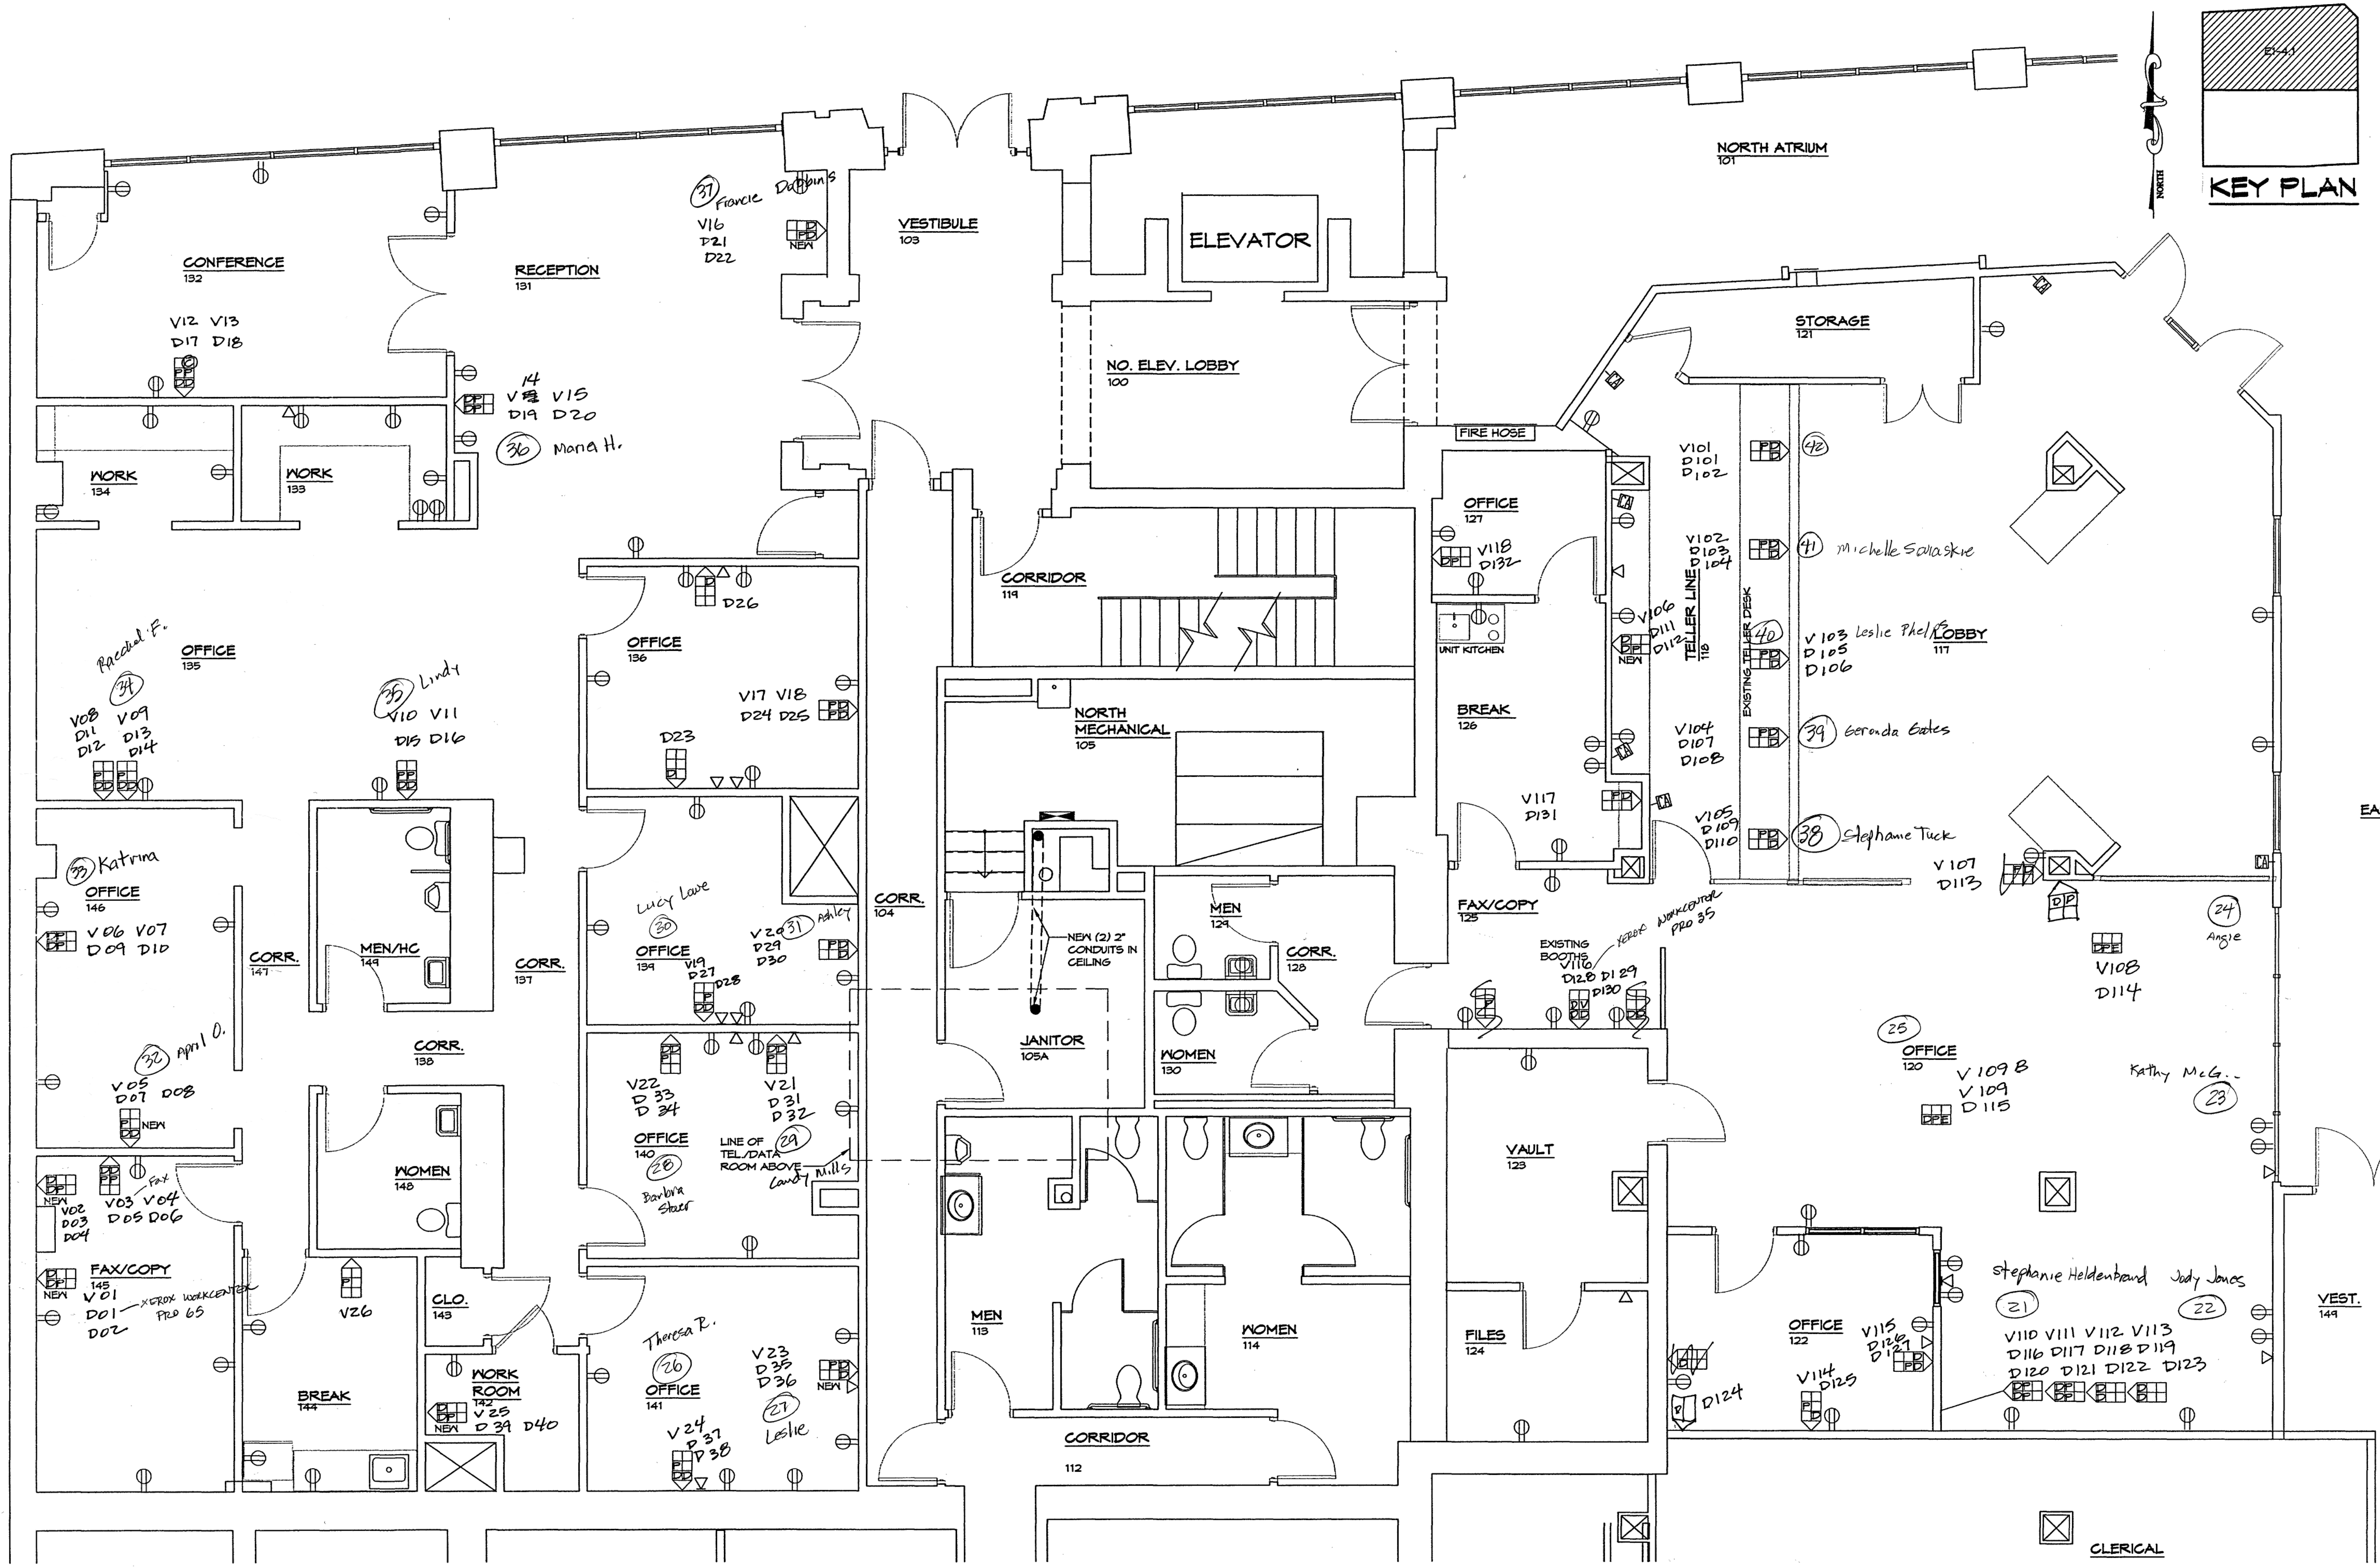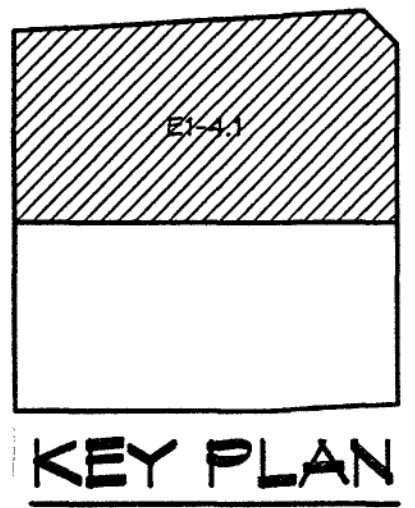

FIRST FLOOR
 SCALE: 1/4" = 1'-0"

Drawing File: P:\Temp\2004\04102 - WVA-Coulter Building\04102.dwg Mar 22, 2005 - 12:30pm