

HUGHES ASSOCIATES ARCHITECTS
Architecture • Planning • Consulting


656 ELM AVENUE, S.W.
P.O. BOX 1034
ROANOKE, VIRGINIA 24005-1034

TEL (540) 342-4002
FAX (540) 342-2080
www.HughesArchitects.com

**WESTERN VIRGINIA
WATER AUTHORITY
COULTER BUILDING**
PHASE II RENOVATIONS
601 South Jefferson Street Roanoke, Virginia

**LIFE SAFETY
FIRST
FLOOR
PLAN**


PHASE 2

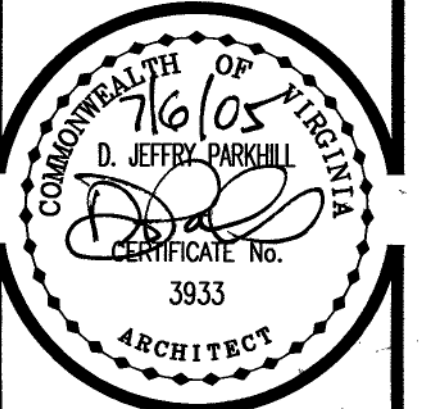

COMMISSION No.
04102
SHEET


LS1-1
No. 2 of 18

© COPYRIGHT 2005
HUGHES ASSOCIATES ARCHITECTS
A PROFESSIONAL CORPORATION

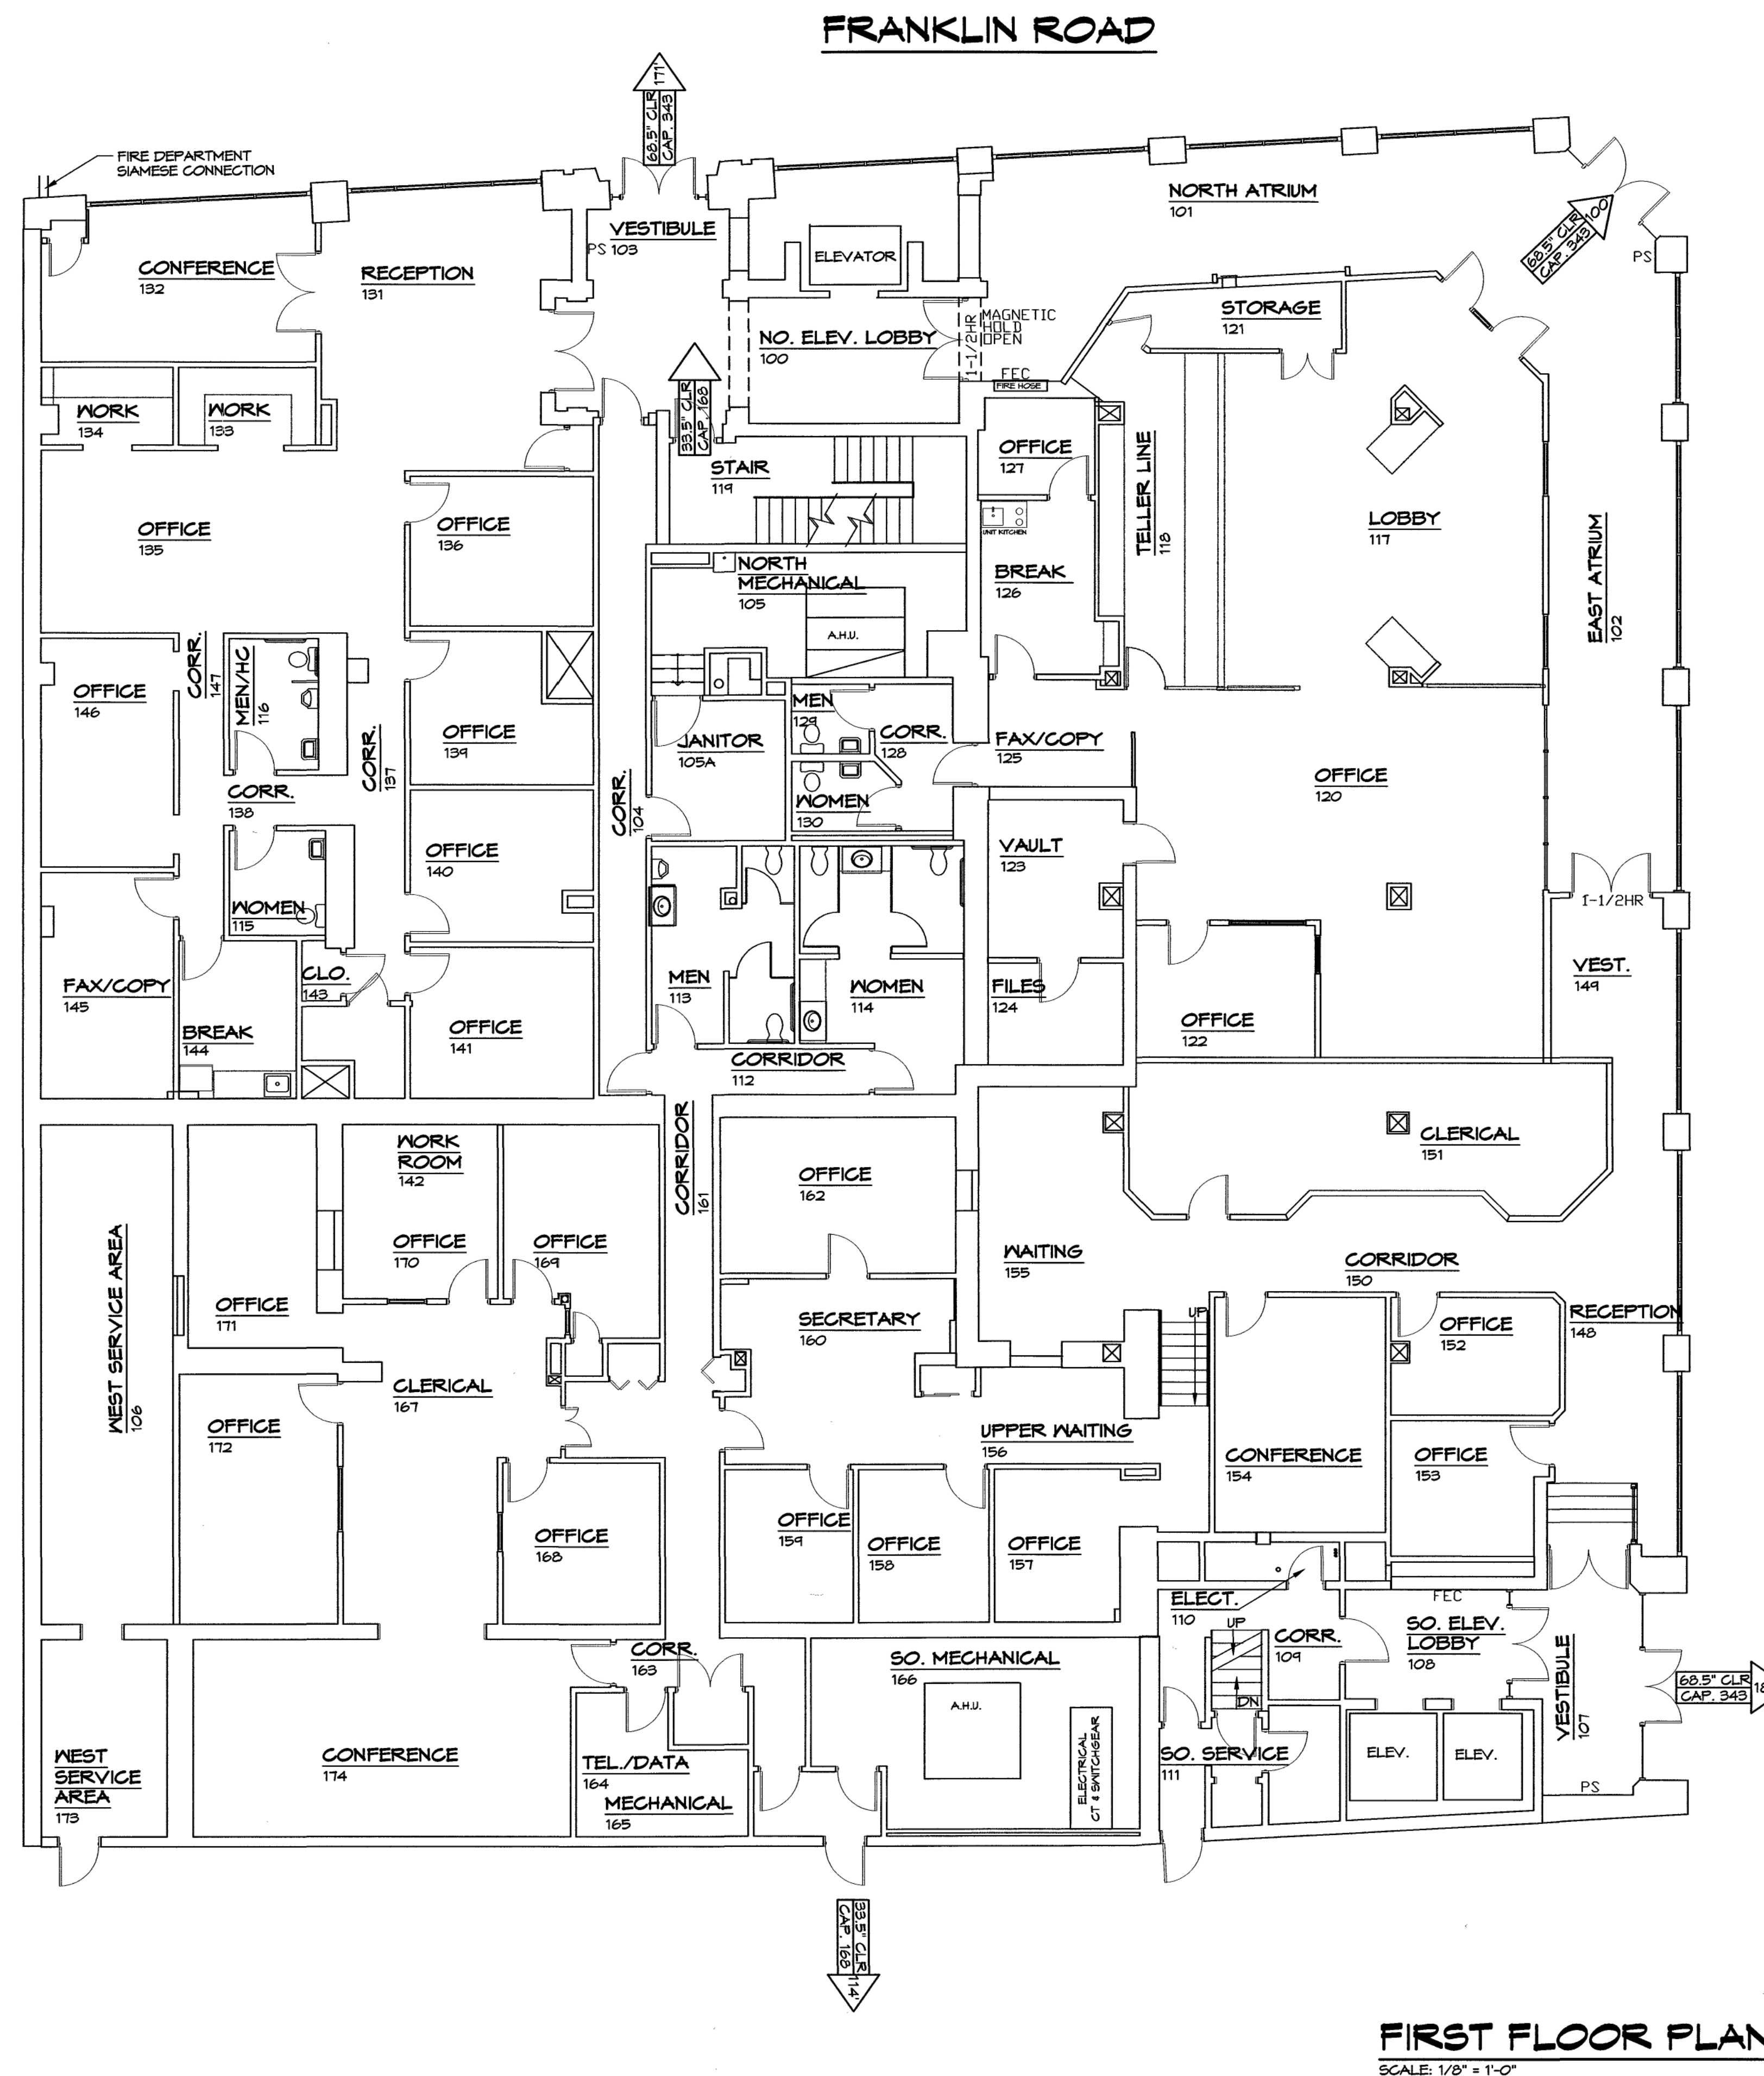


FIRST FLOOR PLAN
SCALE: 1/8" = 1'-0"

PERIMETER OF NORTH ATRIUM SPRINKLERED

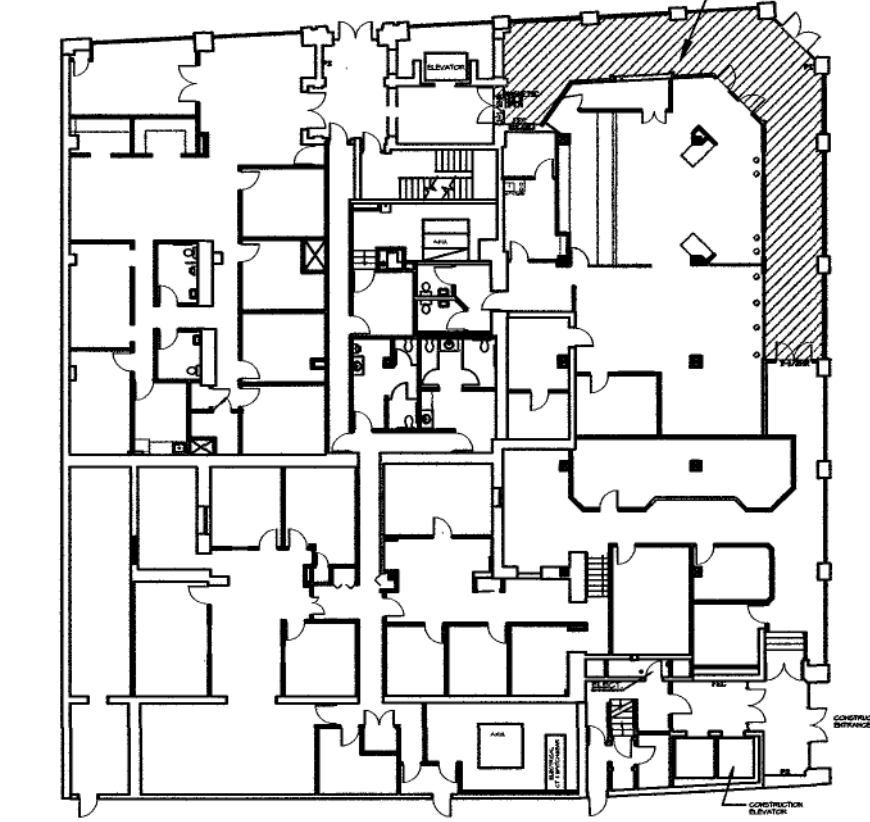

**EXISTING SPRINKLERED
FLOOR AREA**

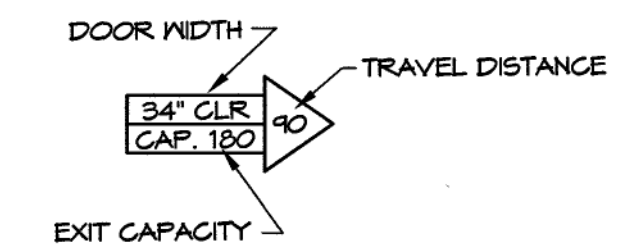

GENERAL NOTE:
ITEMS NOTED AS EXISTING CONDITIONS ARE BASED
ON DRAWINGS BY MARTIN BROTHERS GENERAL
CONTRACTORS DATED 1-4-1987. (RENOVATIONS
AND ALTERATIONS TO COULTER BUILDING AND
NATIONAL BUSINESS COLLEGE)