


GENERAL NOTE:
ITEMS NOTED AS EXISTING CONDITIONS ARE BASED
ON DRAWINGS BY MARTIN BROTHERS GENERAL
CONTRACTORS DATED 1-4-1981. (RENOVATIONS
AND ALTERATIONS TO COULTER BUILDING AND
NATIONAL BUSINESS COLLEGE)

FRANKLIN ROAD

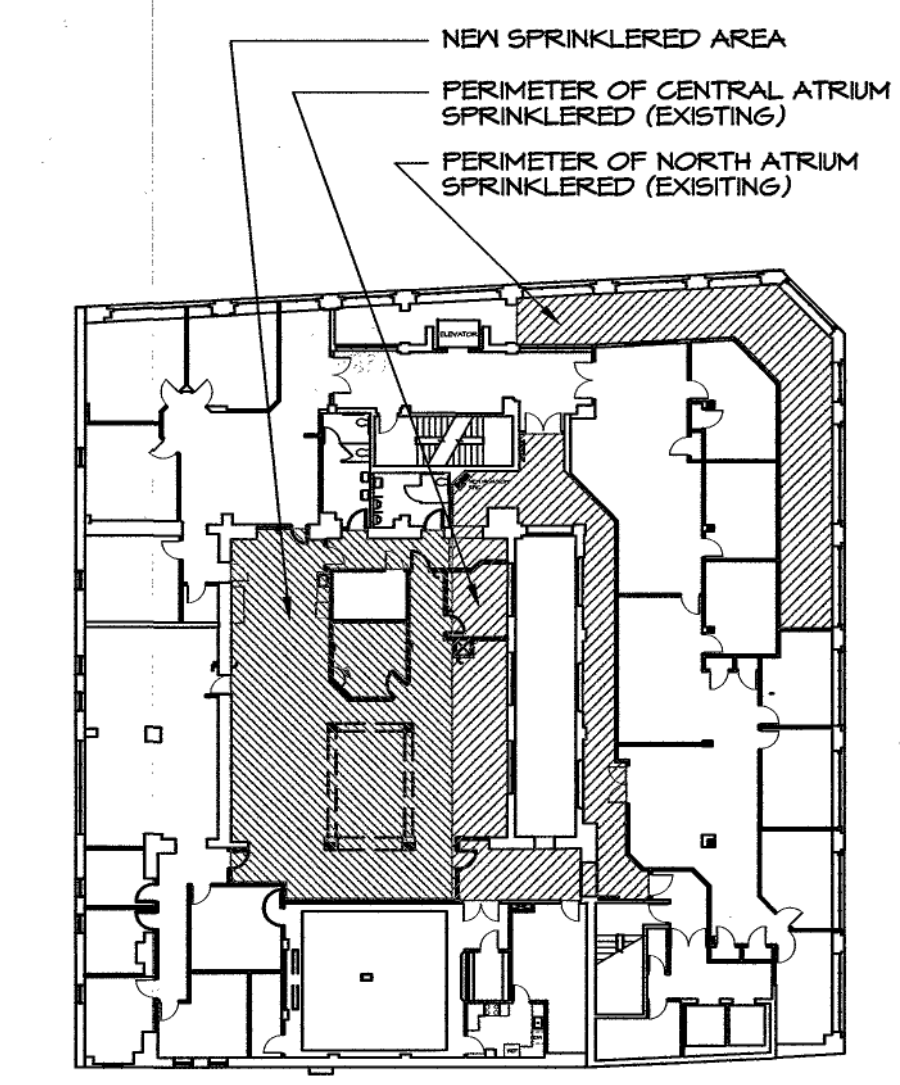

HUGHES
ASSOCIATES
ARCHITECTS
Architecture • Planning • Consulting


656 ELM AVENUE, S.W.
P.O. BOX 1034
ROANOKE, VIRGINIA 24005-1034

TEL (540) 342-4002
FAX (540) 342-2060
www.HughesArchitects.com


WESTERN VIRGINIA
WATER AUTHORITY
COULTER BUILDING
PHASE II RENOVATIONS
601 South Jefferson Street Roanoke, Virginia

LIFE SAFETY
SECOND
FLOOR
PLAN


PHASE 2
COMMONWEALTH OF VIRGINIA
D. JEFFREY PARKHILL
ARCHITECT
COMMISSION No.
04102
SHEET
LS1-2
No. 3 OF 18
COPYRIGHT 2005
HUGHES ASSOCIATES ARCHITECTS
A PROFESSIONAL CORPORATION

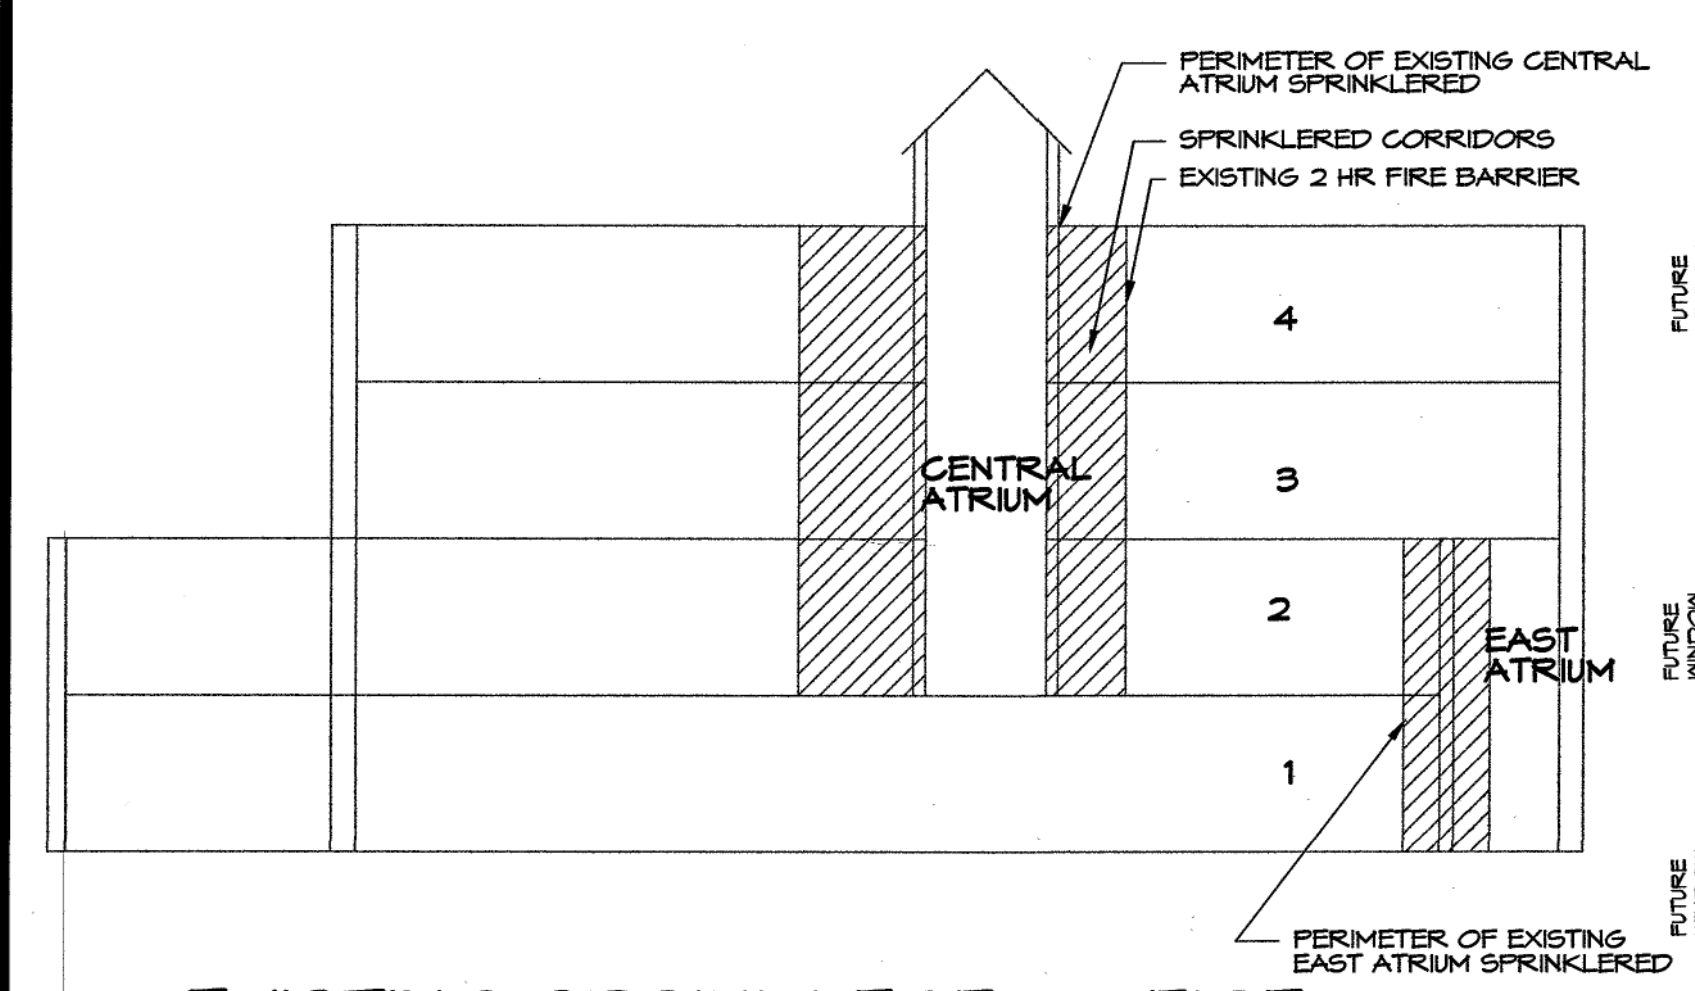

EXISTING SPRINKLERED & FIRE
SEPARATION SECTION- SCHEMATIC

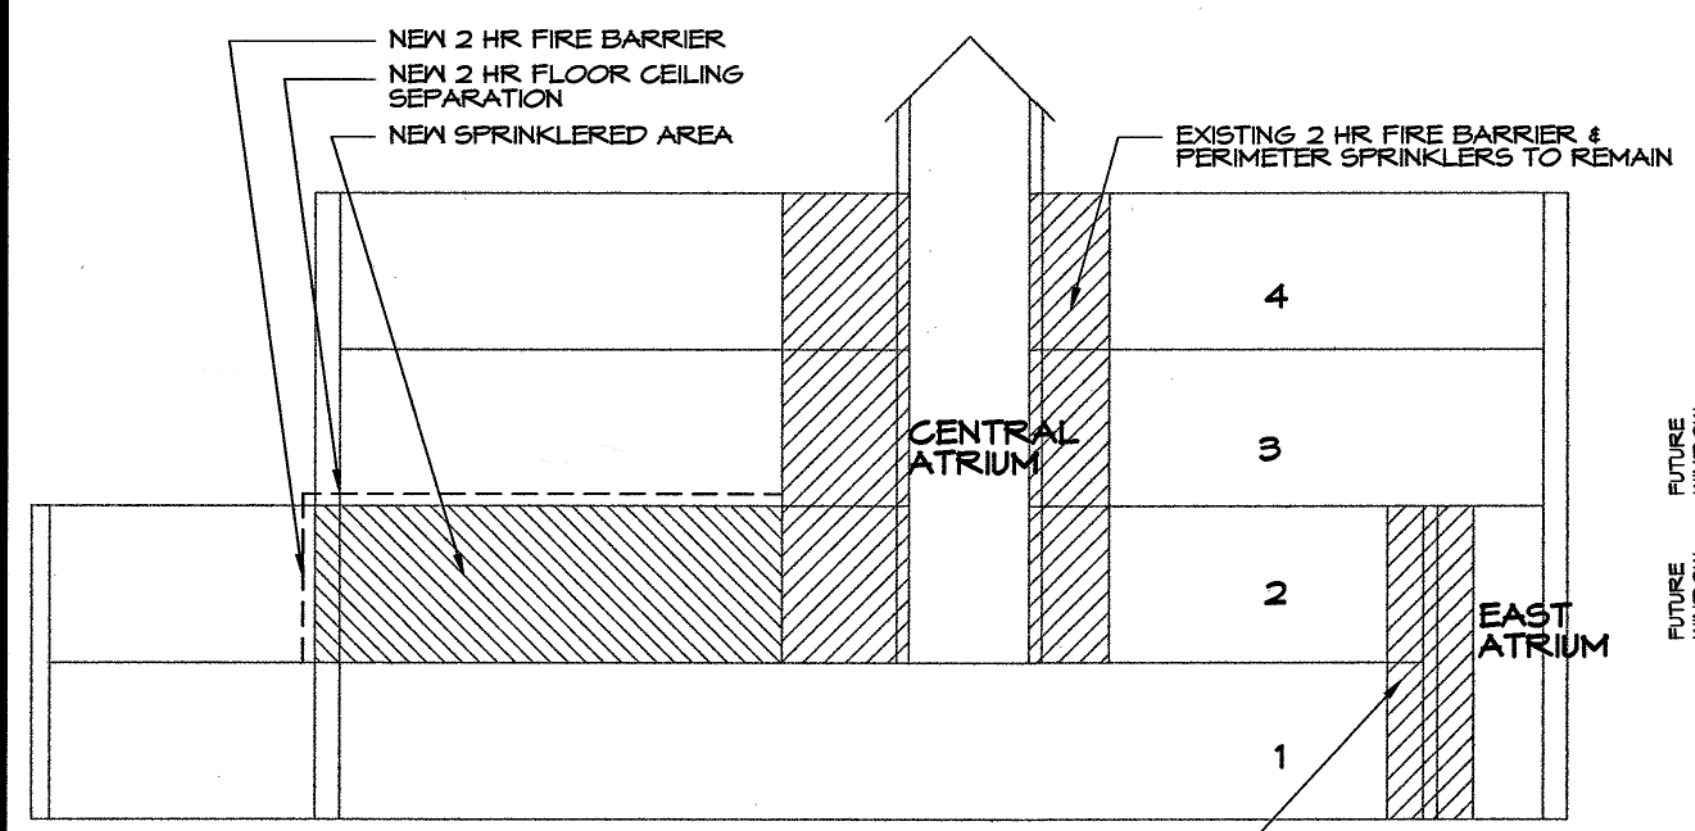

NEW SPRINKLERED & FIRE
SEPARATION SECTION- SCHEMATIC

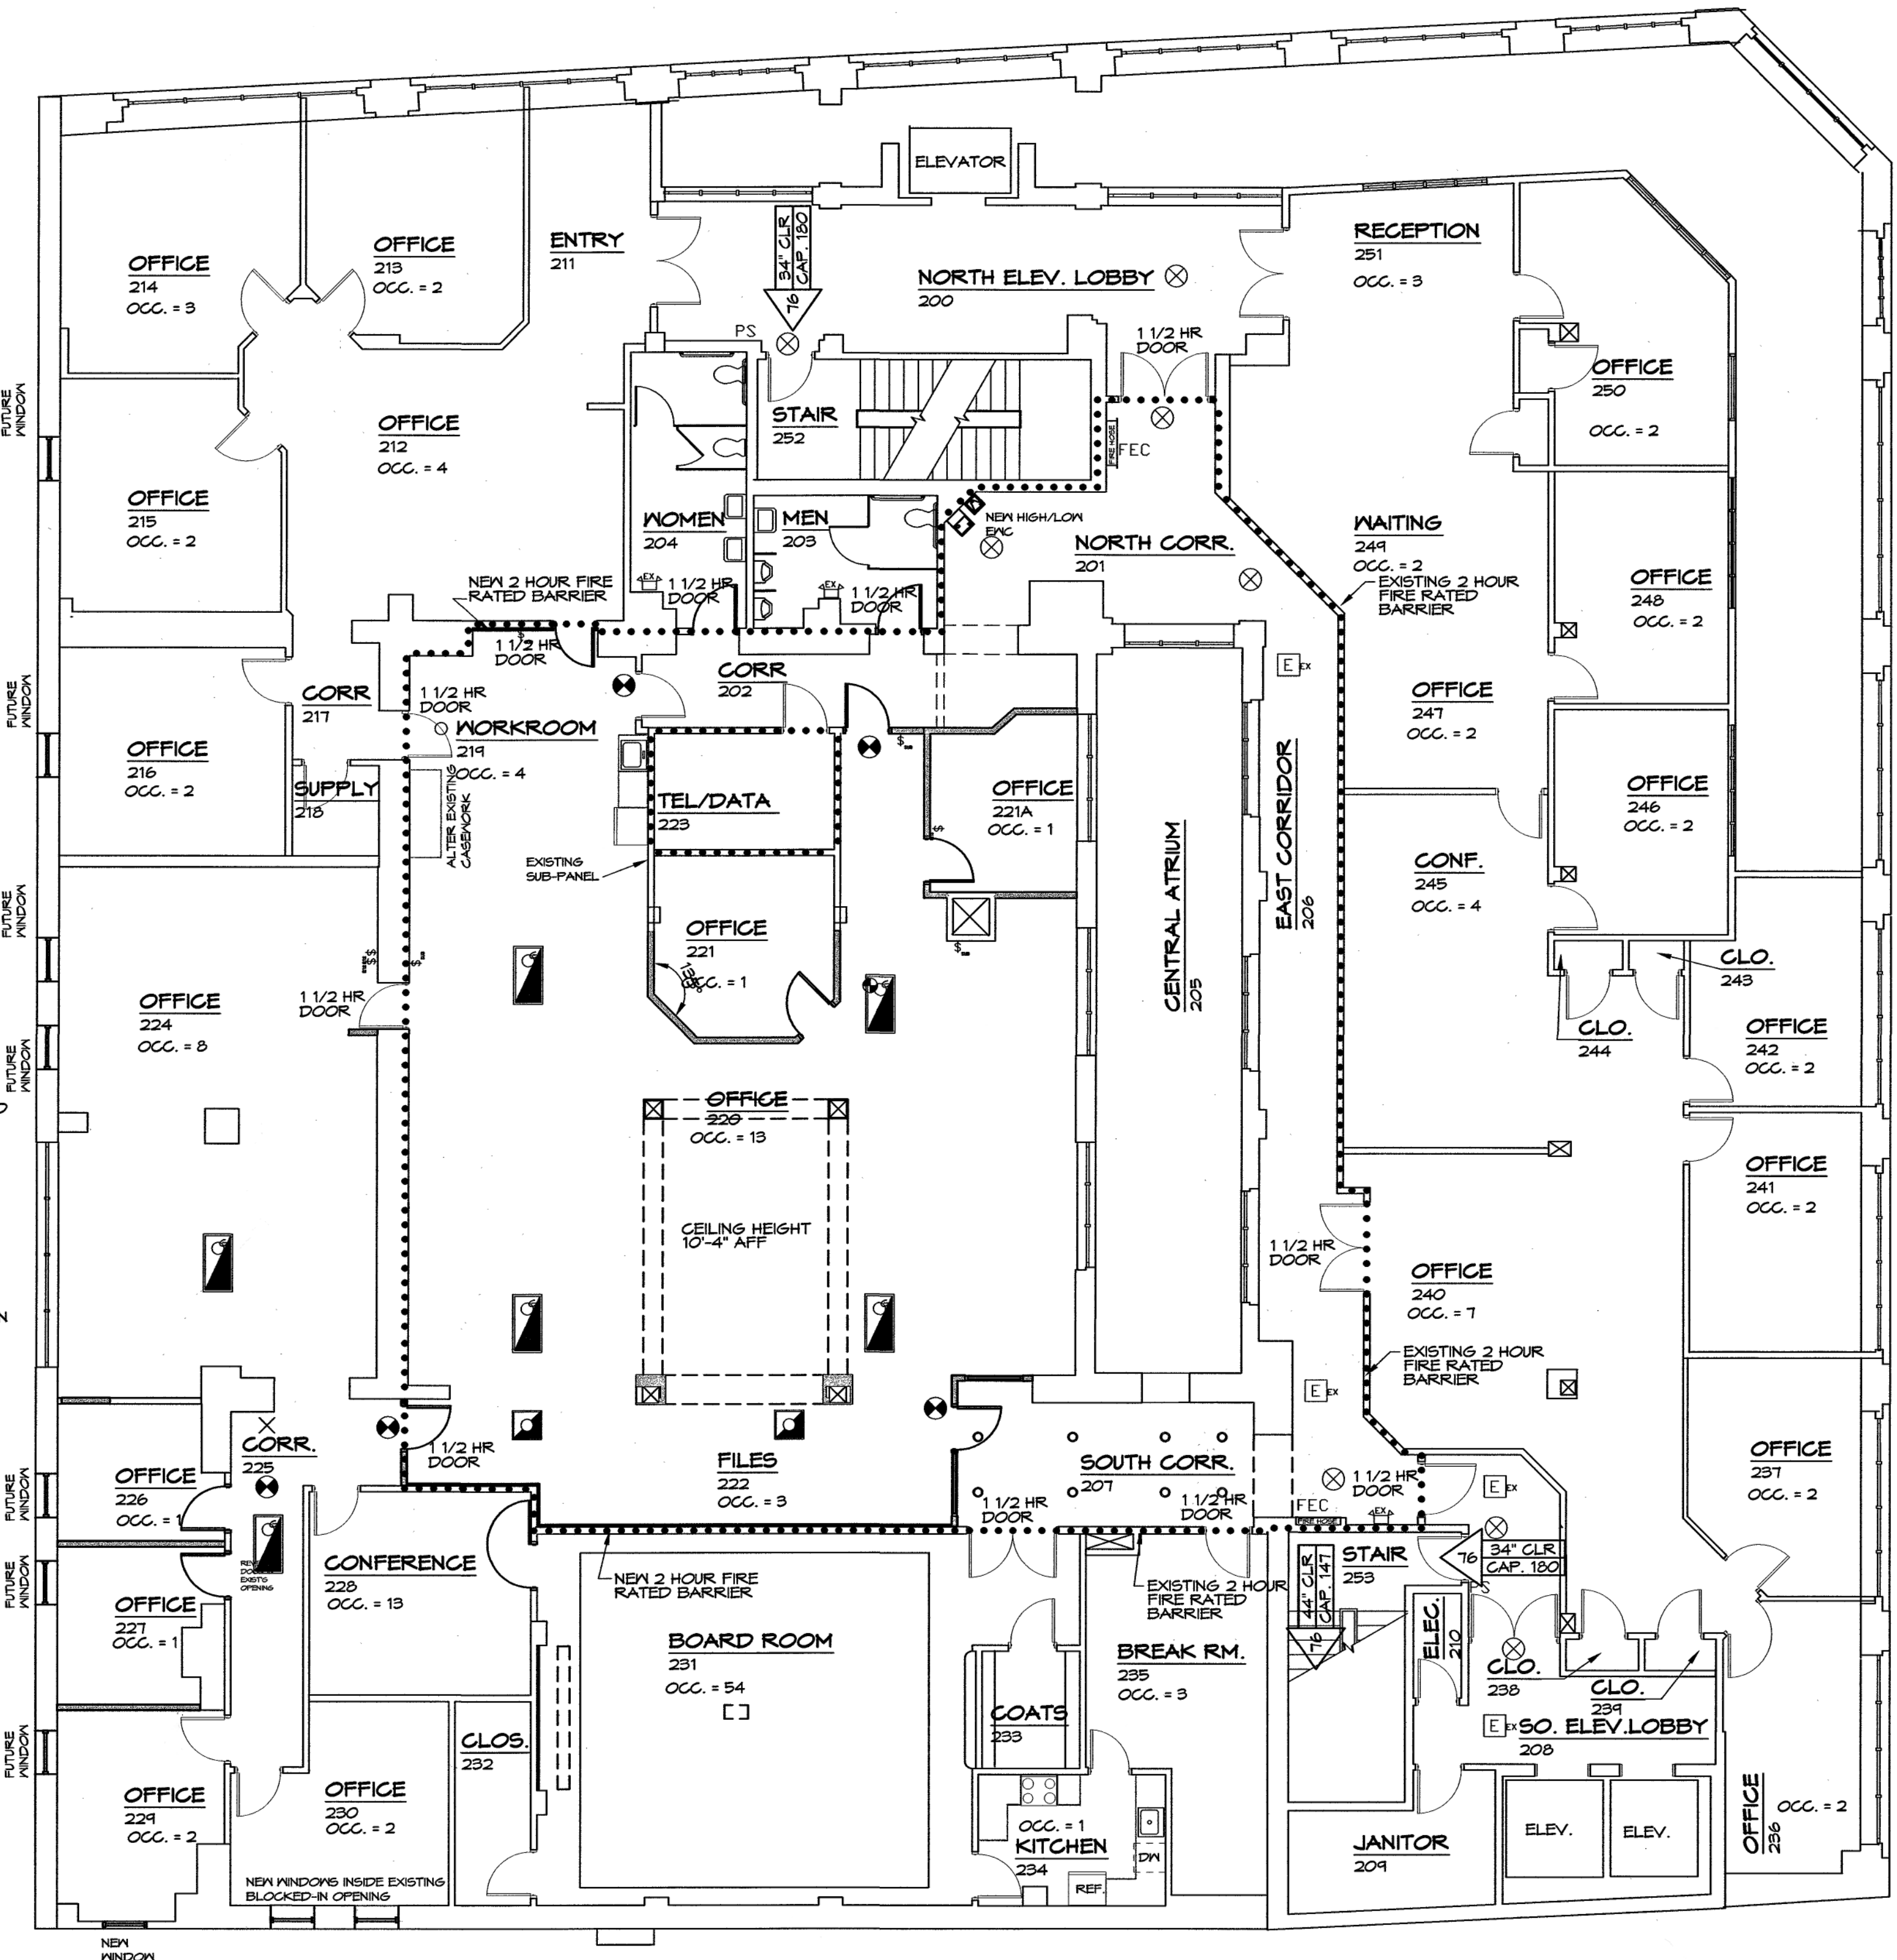

SECOND FLOOR PLAN
SCALE: 1/8" = 1'-0"

SPRINKLERED
FLOOR AREA

