

DATE:	July 1, 2005
REVISIONS	
Δ	
Δ	
Δ	
Δ	
Δ	


HUGHES ASSOCIATES ARCHITECTS
 Architecture • Planning • Consulting

656 ELM AVENUE, S.W.
 P.O. BOX 1034
 ROANOKE, VIRGINIA 24005-1034

TEL (540) 342-4002
 FAX (540) 342-2060
 www.HughesArchitects.com

WALL LEGEND	
	EXISTING WALL
	DEMOLITION OF EXISTING WALL
	NEW WALL
	2 HR FIRE WALL

GENERAL NOTE:
 ITEMS NOTED AS EXISTING CONDITIONS ARE BASED ON DRAWINGS BY MARTIN BROTHERS GENERAL CONTRACTORS DATED 1-4-1987. (RENOVATIONS AND ALTERATIONS TO COULTER BUILDING AND NATIONAL BUSINESS COLLEGE)

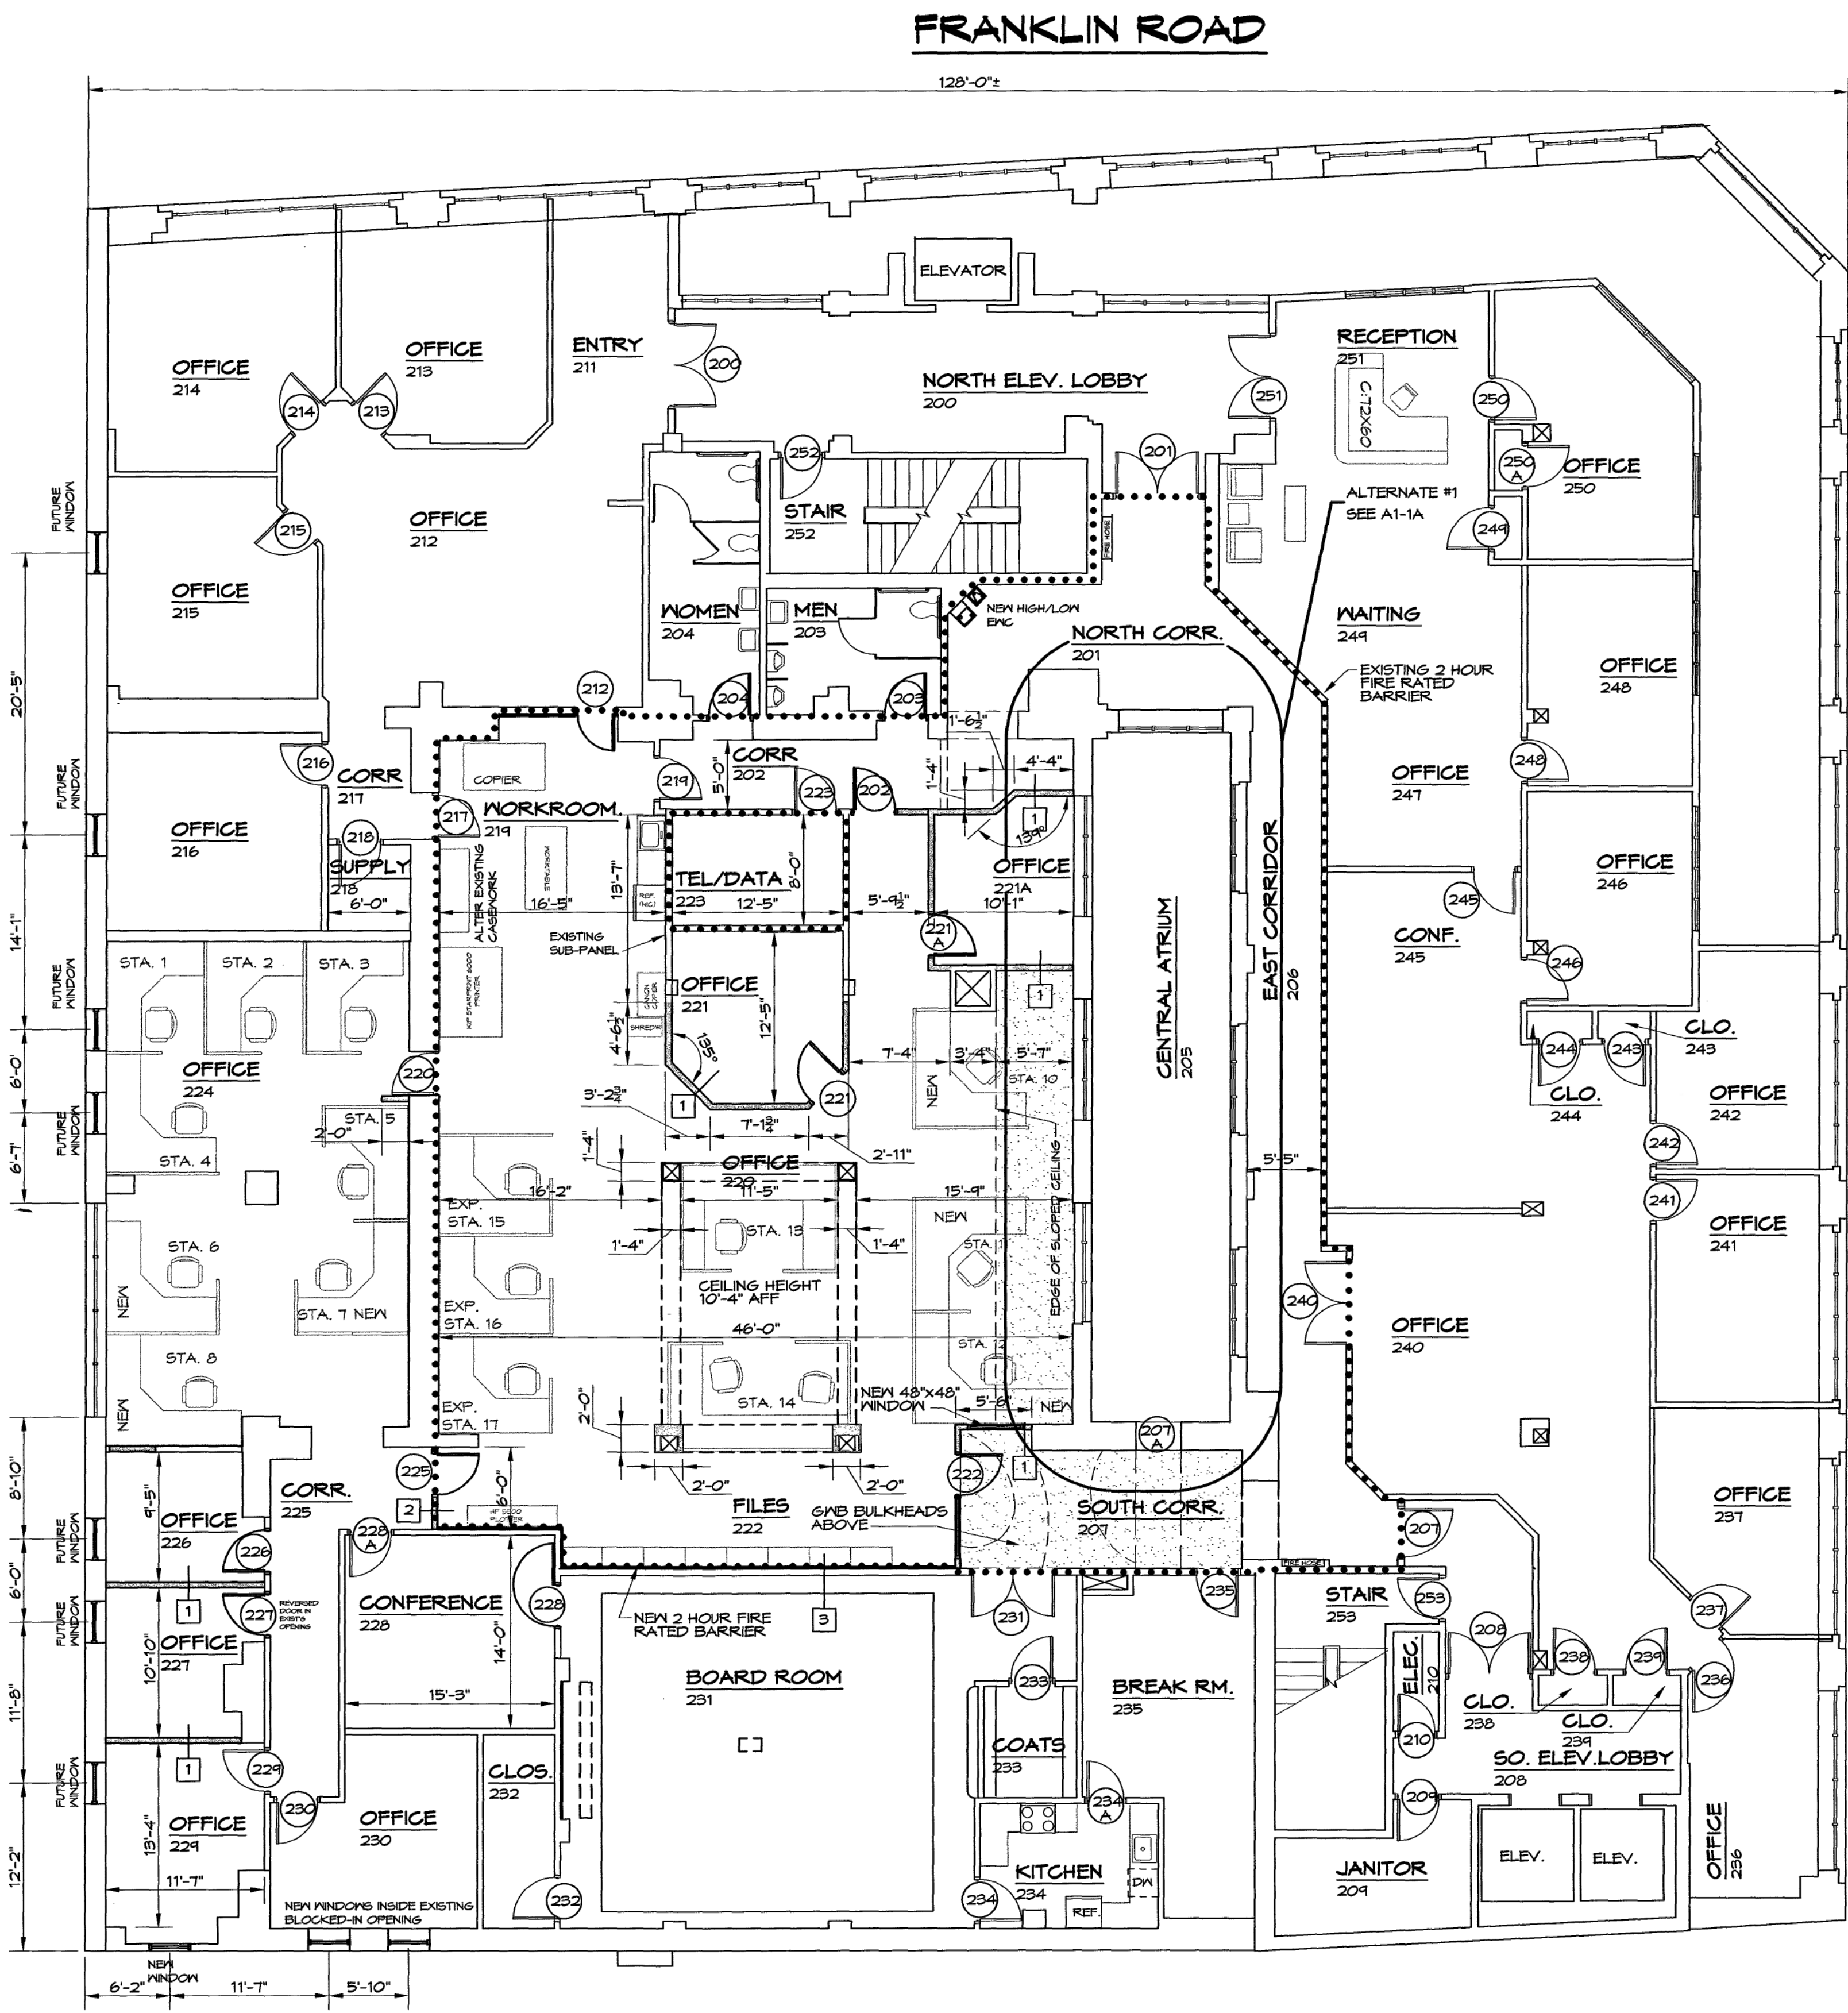

JEFFERSON STREET

SECOND FLOOR PLAN
 SCALE: 1/8" = 1'-0"

WESTERN VIRGINIA WATER AUTHORITY COULTER BUILDING
 PHASE II RENOVATIONS
 601 South Jefferson Street Roanoke, Virginia

SECOND FLOOR PLAN

PHASE 2



COMMISSION No.
 04102
 SHEET
 A1-1

No. 7 of 18
 COPYRIGHT 2005
 HUGHES ASSOCIATES ARCHITECTS
 A PROFESSIONAL CORPORATION