


DATE:	7-1-05
REVISIONS	

HUGHES ASSOCIATES ARCHITECTS
Architecture • Planning • Consulting

656 ELM AVENUE, S.W.
P.O. BOX 1034
ROANOKE, VIRGINIA 24005-1034

TEL (540) 342-4002
FAX (540) 342-2060
www.HughesArchitects.com


MECHANICAL LEGEND	
SYMBOL	DESCRIPTION
----	ITEM TO BE REMOVED
---	EXIST. DUCTWORK
---	NEW DUCTWORK
⊠ CD9 200 CFM	9" CEILING DIFFUSER SUPPLYING 200 CFM
⊠	RETURN OR EXHAUST REGISTER OR GRILLE
⊙	THERMOSTAT OR SENSOR, MOUNT 5'-4" ABOVE FLOOR, UNLESS NOTED OTHERWISE
⌋	MANUAL VOLUME DAMPER
CD	CEILING DIFFUSER
RR	CEILING RETURN REGISTER
AH-201	AIR HANDLER #201
W32	EXIST. VAV BOX 32
●	CONNECT TO EXISTING

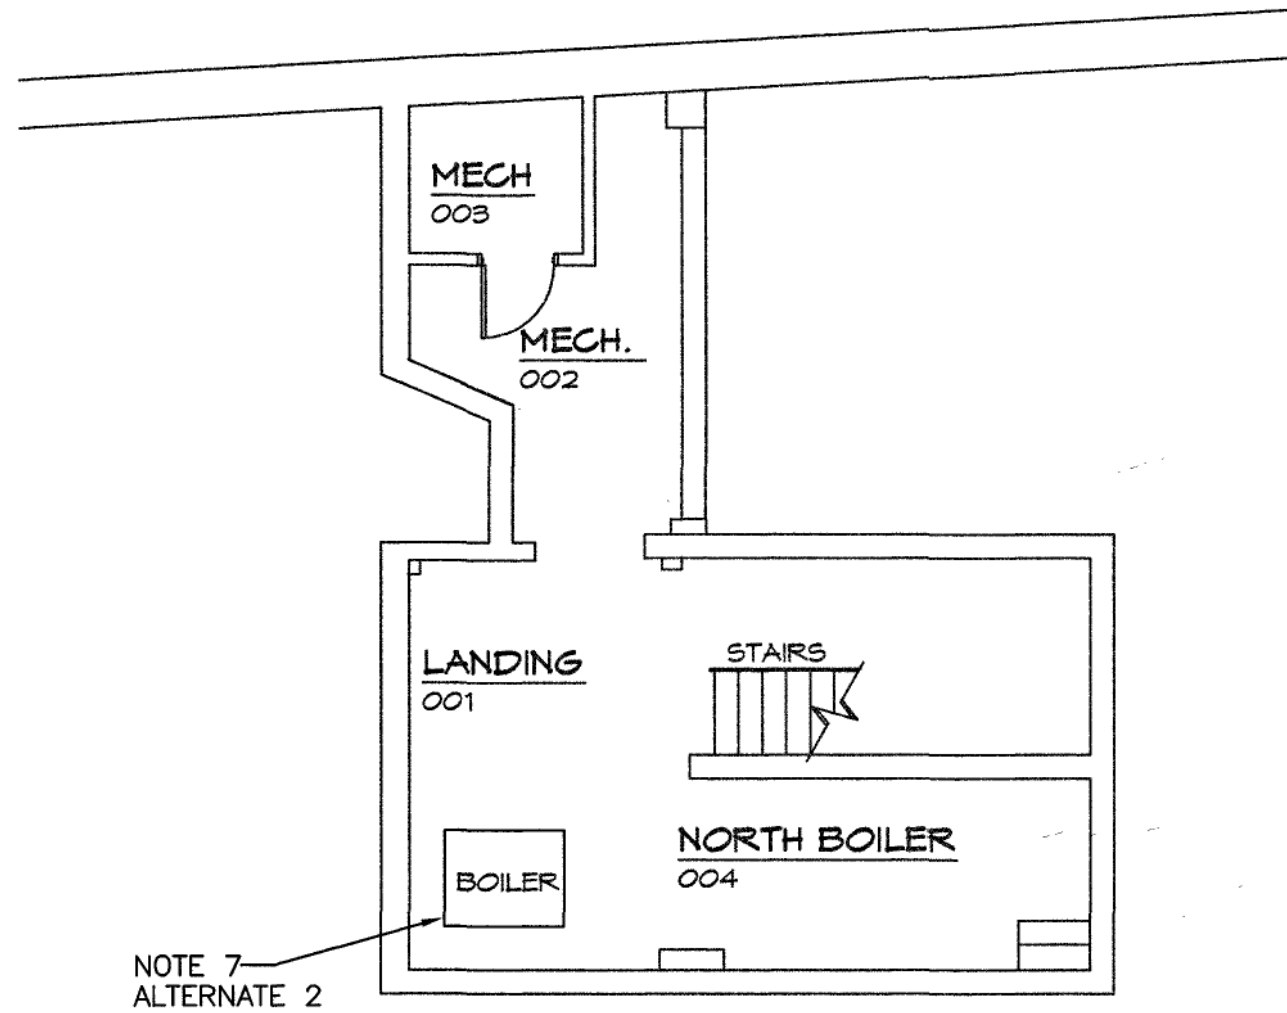

PARTIAL BASEMENT PLAN
SCALE: 1/8" = 1'-0"

NOTES THIS SHEET

1. REMOVE SUPPLY DUCT AND CEILING DIFFUSERS. PREPARE REMAINING DUCT FOR NEW CONNECTION.
2. REMOVE CEILING DIFFUSER & SUPPLY DUCT AND CAP DUCT.
3. REMOVE RETURN DUCT AND CEILING GRILLE. PREPARE REMAINING DUCT FOR NEW CONNECTION.
4. REMOVE CEILING GRILLE AND RETURN DUCT AND CAP DUCT.
5. REMOVE CEILING DIFFUSERS OR REGISTERS AND ASSOCIATED DUCT CONNECTION. PREPARE DUCT FOR CONNECTION TO NEW DIFFUSER.
6. RELOCATE THERMOSTAT. SEE SHEET M-2 FOR NEW LOCATION.
7. ALTERNATE 2: REMOVE ABANDONED BOILER IN BASEMENT AND CAP REMAINING PIPING.

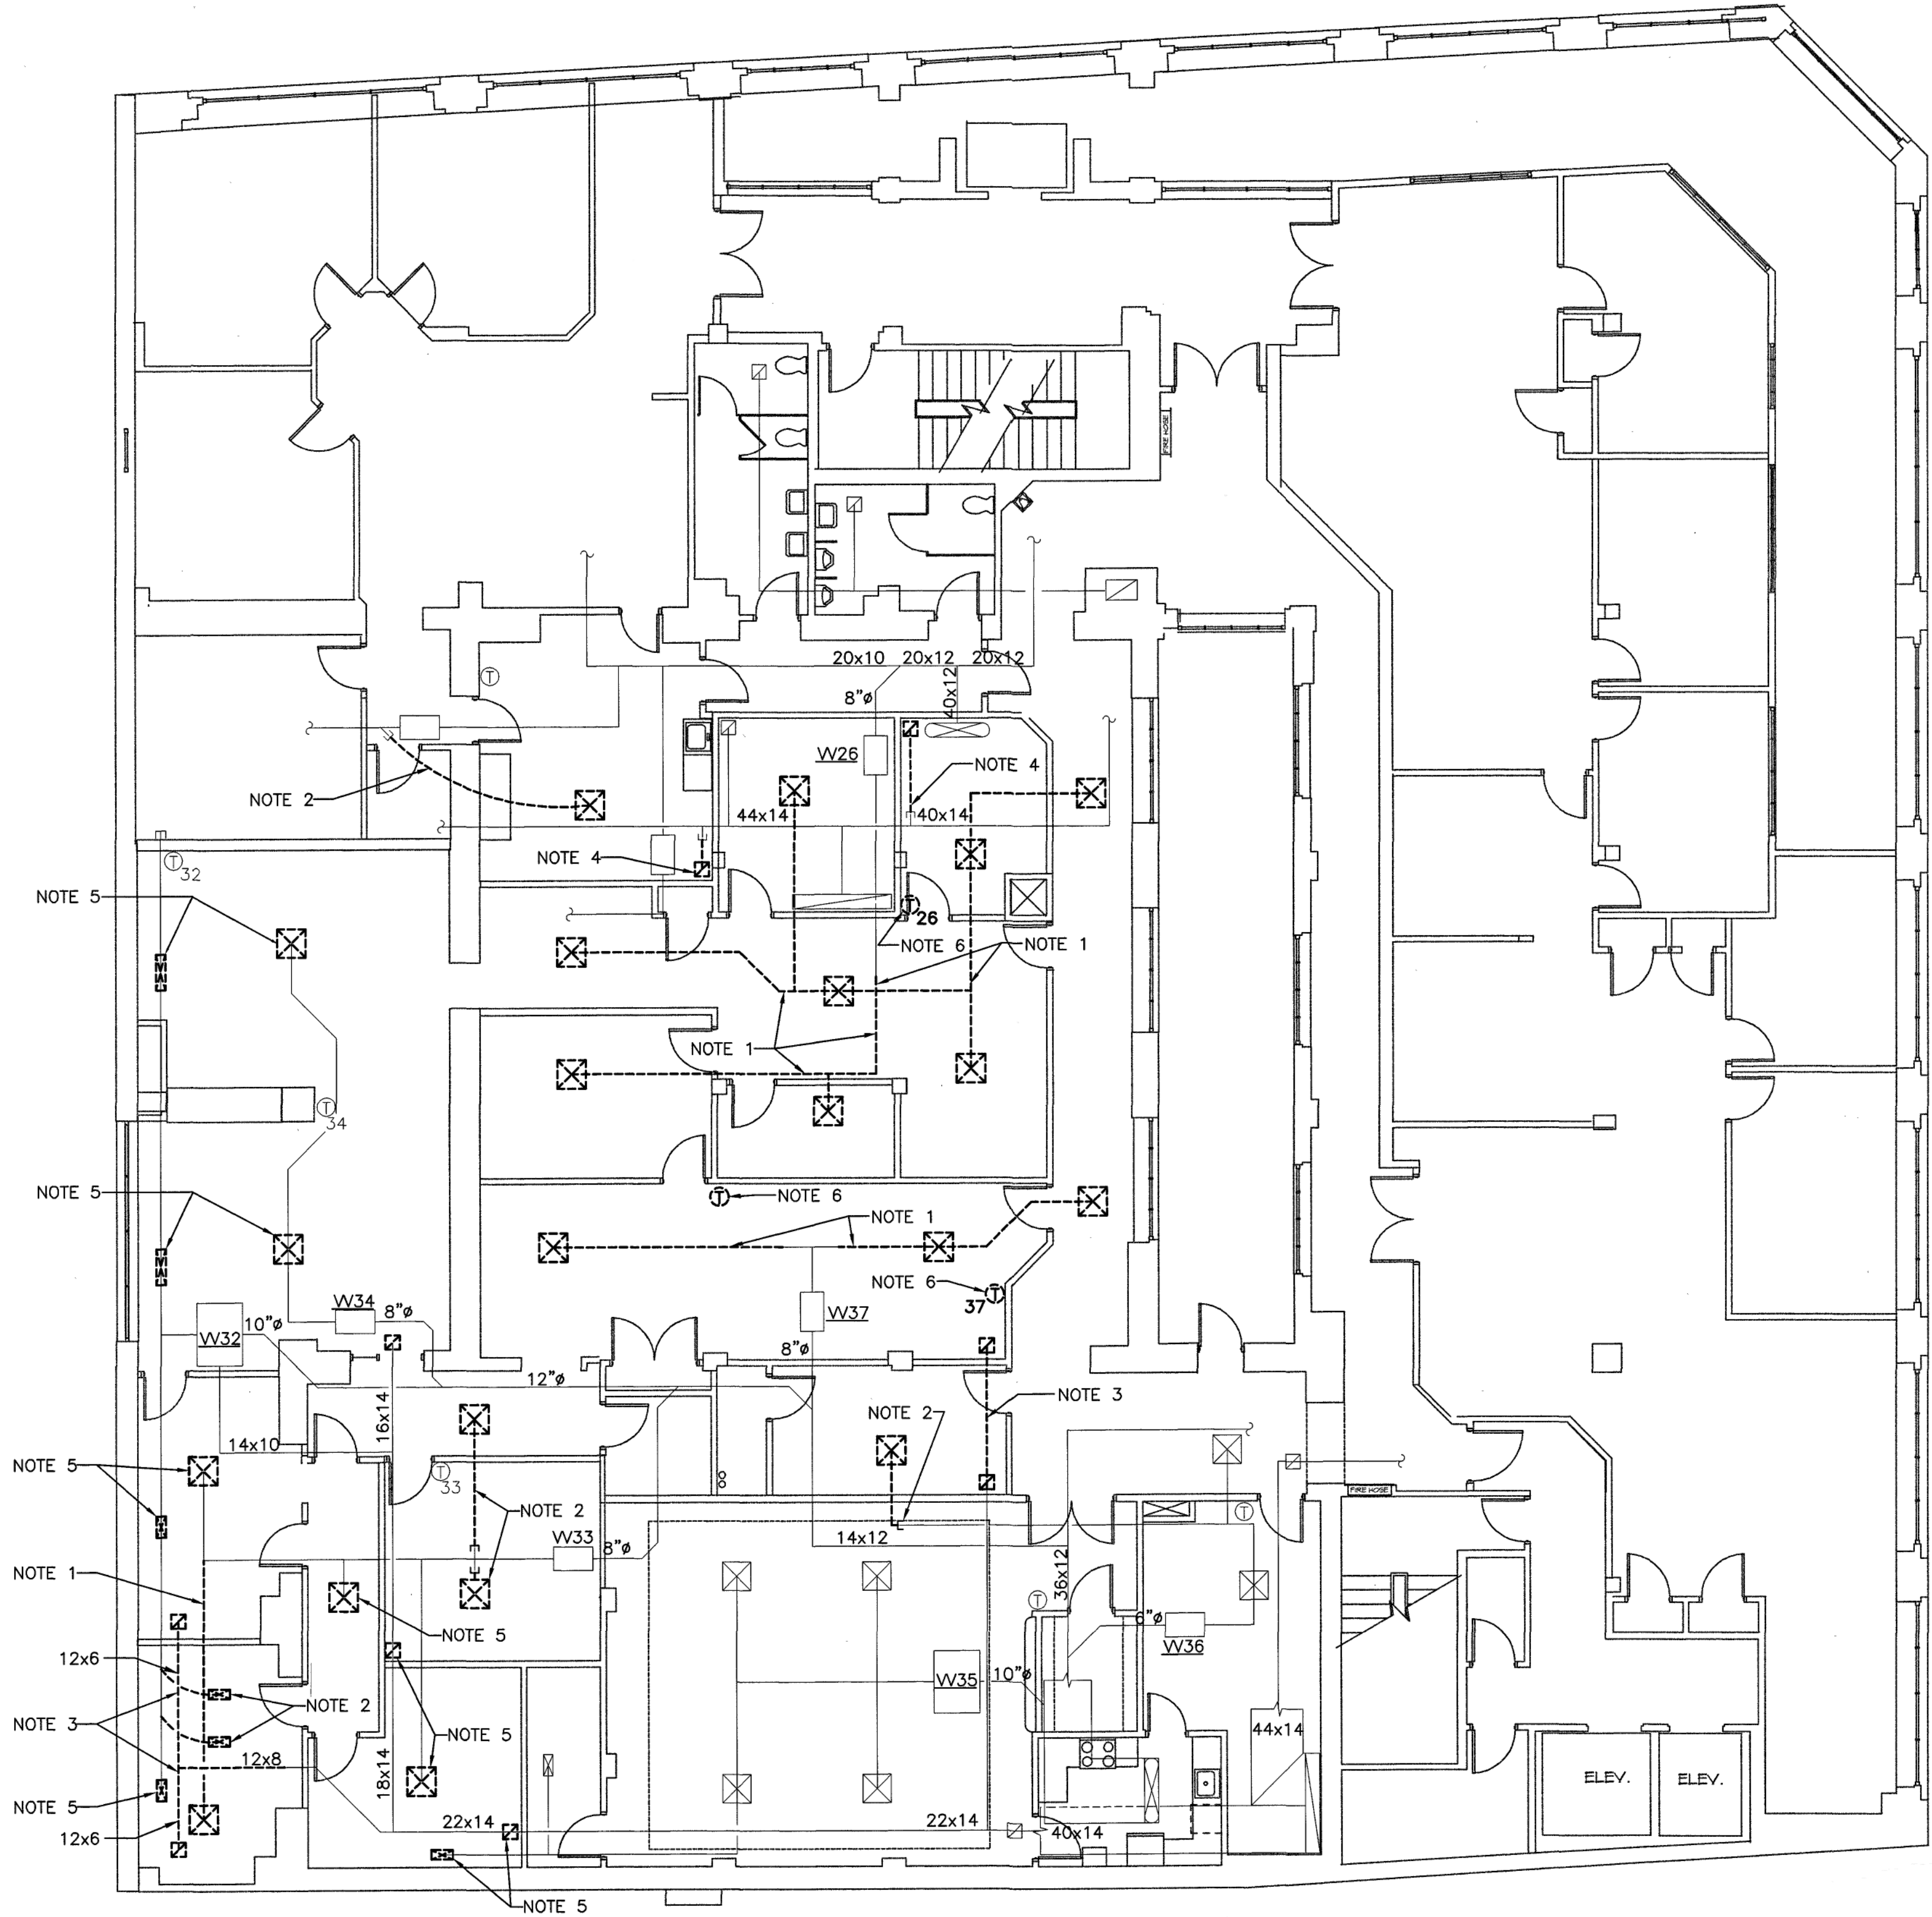


SECOND FLOOR PLAN - DEMOLITION
SCALE: 1/8" = 1'-0"

ALTERATIONS TO WESTERN VIRGINIA WATER AUTHORITY
Jefferson Street at Franklin Road Roanoke, Virginia

SECOND FLOOR PLAN - DEMOLITION

MANN & ASSOCIATES, INC.
305 Market Street
Roanoke, VA 24011
540-344-5515 Fax 343-0235

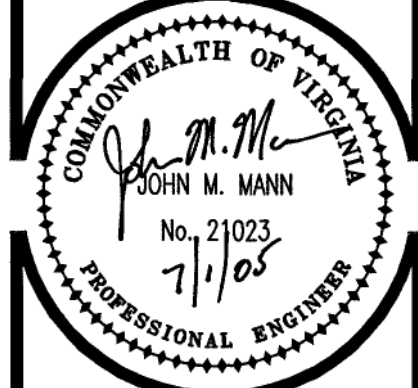

COMMISSION No.
04102
SHEET
M1-1

No. 13 of 18
COPYRIGHT 2005
HUGHES ASSOCIATES ARCHITECTS
A PROFESSIONAL CORPORATION