


Working File: P:\pmp\2004\04102 - WVA-Center Building-Coulters PH2.dwg Jul 05, 2005 - 5:41pm


LEGEND

- | | |
|-----------|------------|
| DATA | WALL |
| TELEPHONE | TELEPHONE |
| COAXIAL | ELECTRICAL |
| CABLE | REC. |
-
- | | |
|--|---|
| | NEW RECEPTACLE ON NEW 40A CIRCUIT WITH ISOLATION GROUND |
| | NEW 2- 2" CONDUITS |
| | EXISTING RECEPTACLE TO REMAIN |
| | EXISTING PHONE JACK |
| | EXISTING DATA PORT |
| | EXISTING TOKEN RING PORT |
| | EXISTING WALL MOUNTED EMERGENCY LIGHT |
| | EXISTING CEILING MOUNTED EMERGENCY LIGHT |
| | EXISTING EXIT SIGN |
| | EXISTING FIRE ALARM PULL STATION |
| | NEW EXIT SIGN |
| | NEW LAY-IN FLUORESCENT WITH EMERGENCY BACK-UP |
| | NEW LAY-IN FLUORESCENT |
| | NIGHT CIRCUIT |
| | EXISTING FIRE HOSE/ EXTINGUISHER CABINET |
| | CEILING DIFFUSER/REGISTER |
| | COLD AIR RETURN REGISTER |

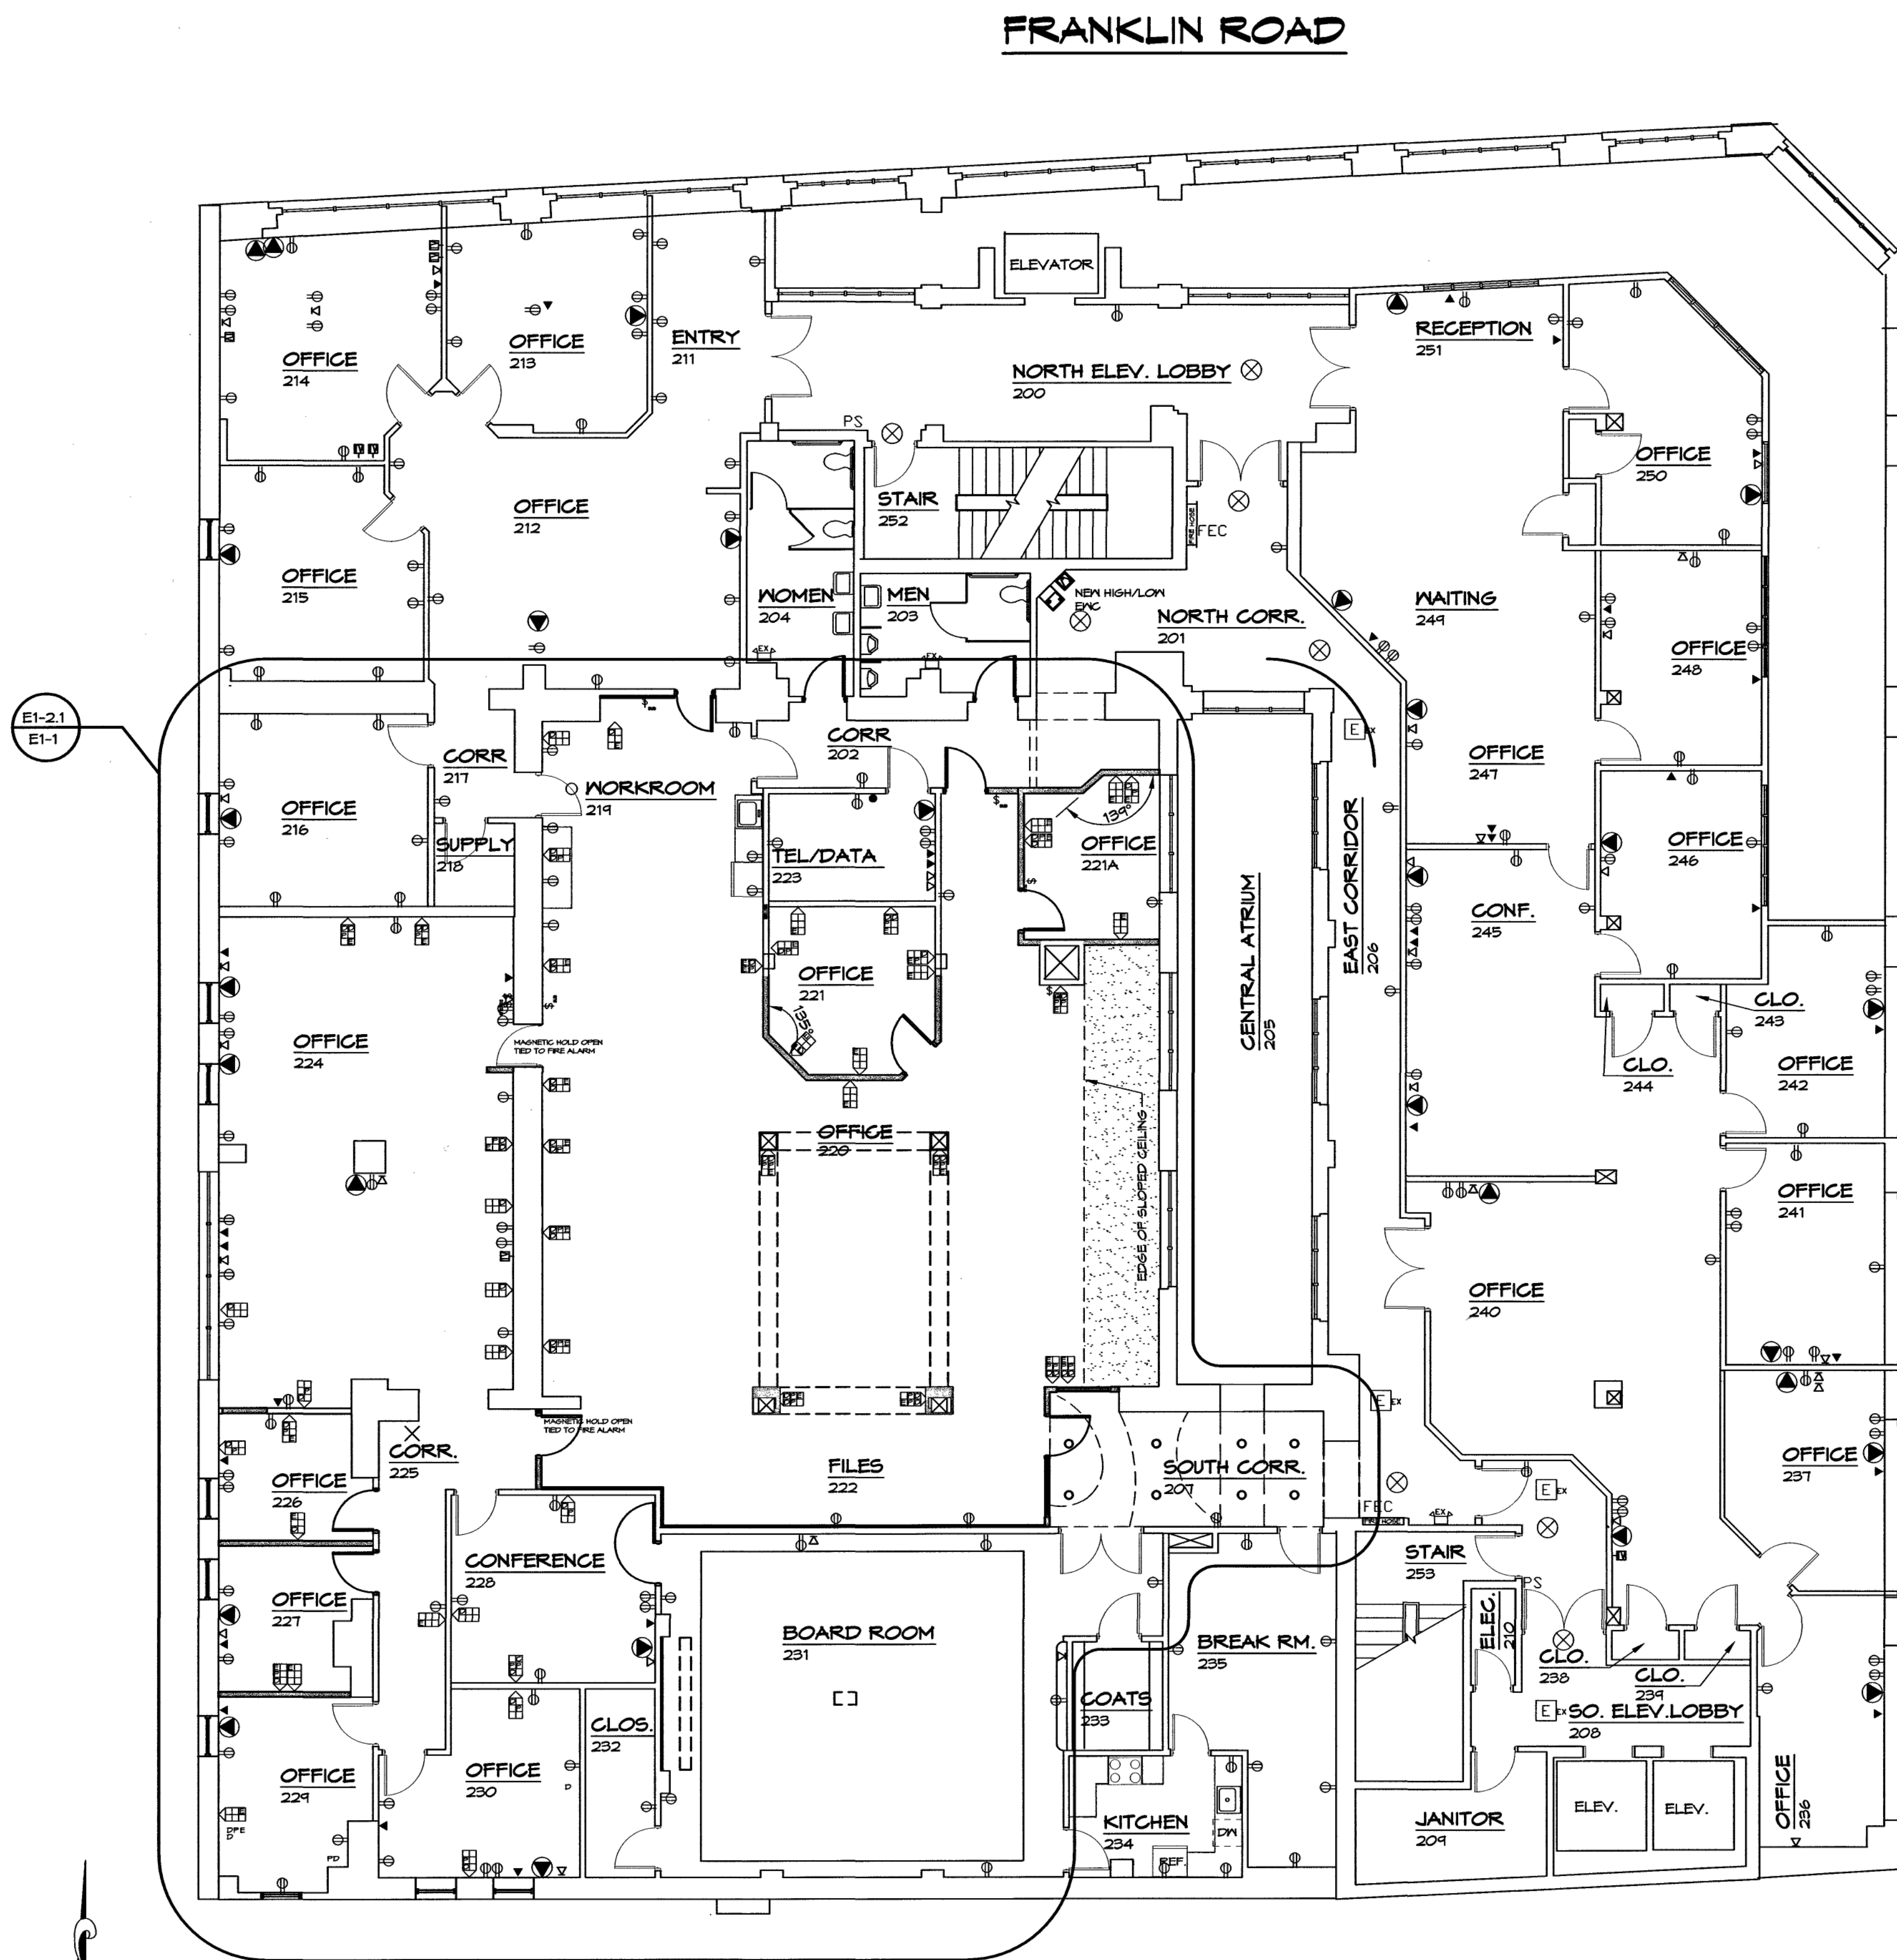


SECOND FLOOR PLAN
SCALE: 1/8" = 1'-0"

JEFFERSON STREET

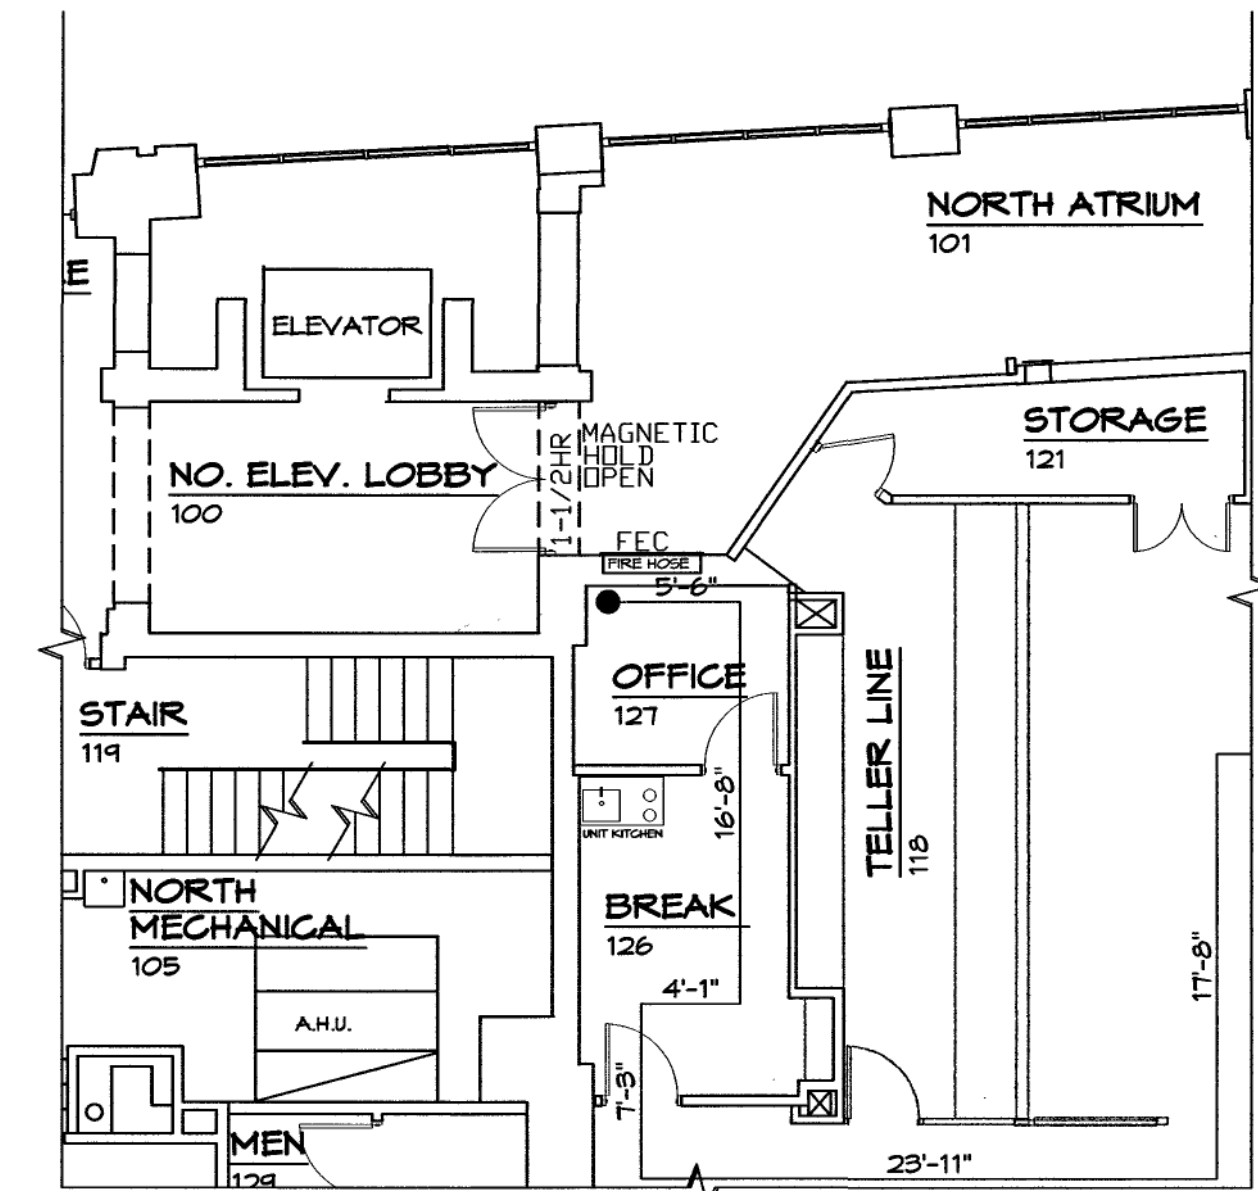

PARTIAL FIRST FLOOR PLAN
SCALE: 1/8" = 1'-0"

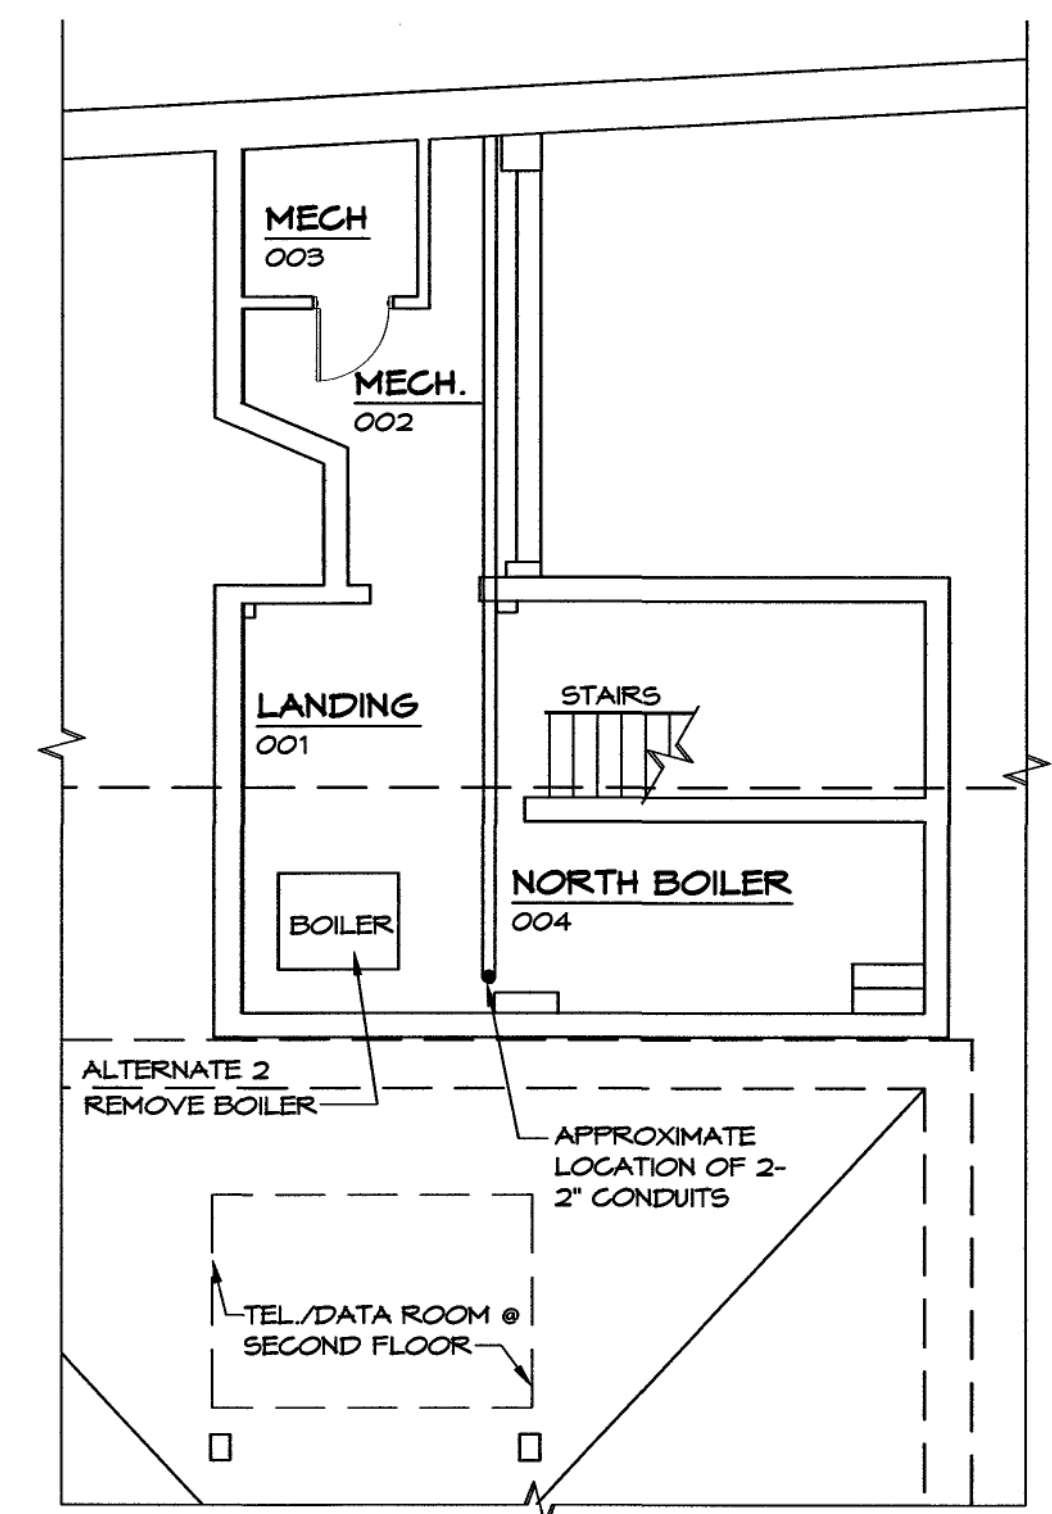


BASEMENT FLOOR PLAN
SCALE: 1/8" = 1'-0"

DATE: July 1, 2005
REVISIONS
HUGHES ASSOCIATES ARCHITECTS
Architecture • Planning • Consulting
656 ELM AVENUE, S.W.
P.O. BOX 1034
ROANOKE, VIRGINIA 24005-1034
TEL (540) 342-4002
FAX (540) 342-2060
www.HughesArchitects.com

**WESTERN VIRGINIA
WATER AUTHORITY
COULTER BUILDINGS
PHASE II RENOVATIONS**
601 South Jefferson Street Roanoke, Virginia

**SECOND
FLOOR
PLAN
(TELEPHONE,
DATA,
POWER &
ELECTRICAL)**

PHASE 2

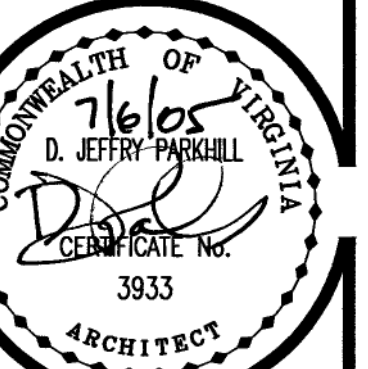

COMMISSION No.
04102
SHEET
E1-1

No. 15 of 18
COPYRIGHT 2005
HUGHES ASSOCIATES ARCHITECTS
A PROFESSIONAL CORPORATION