


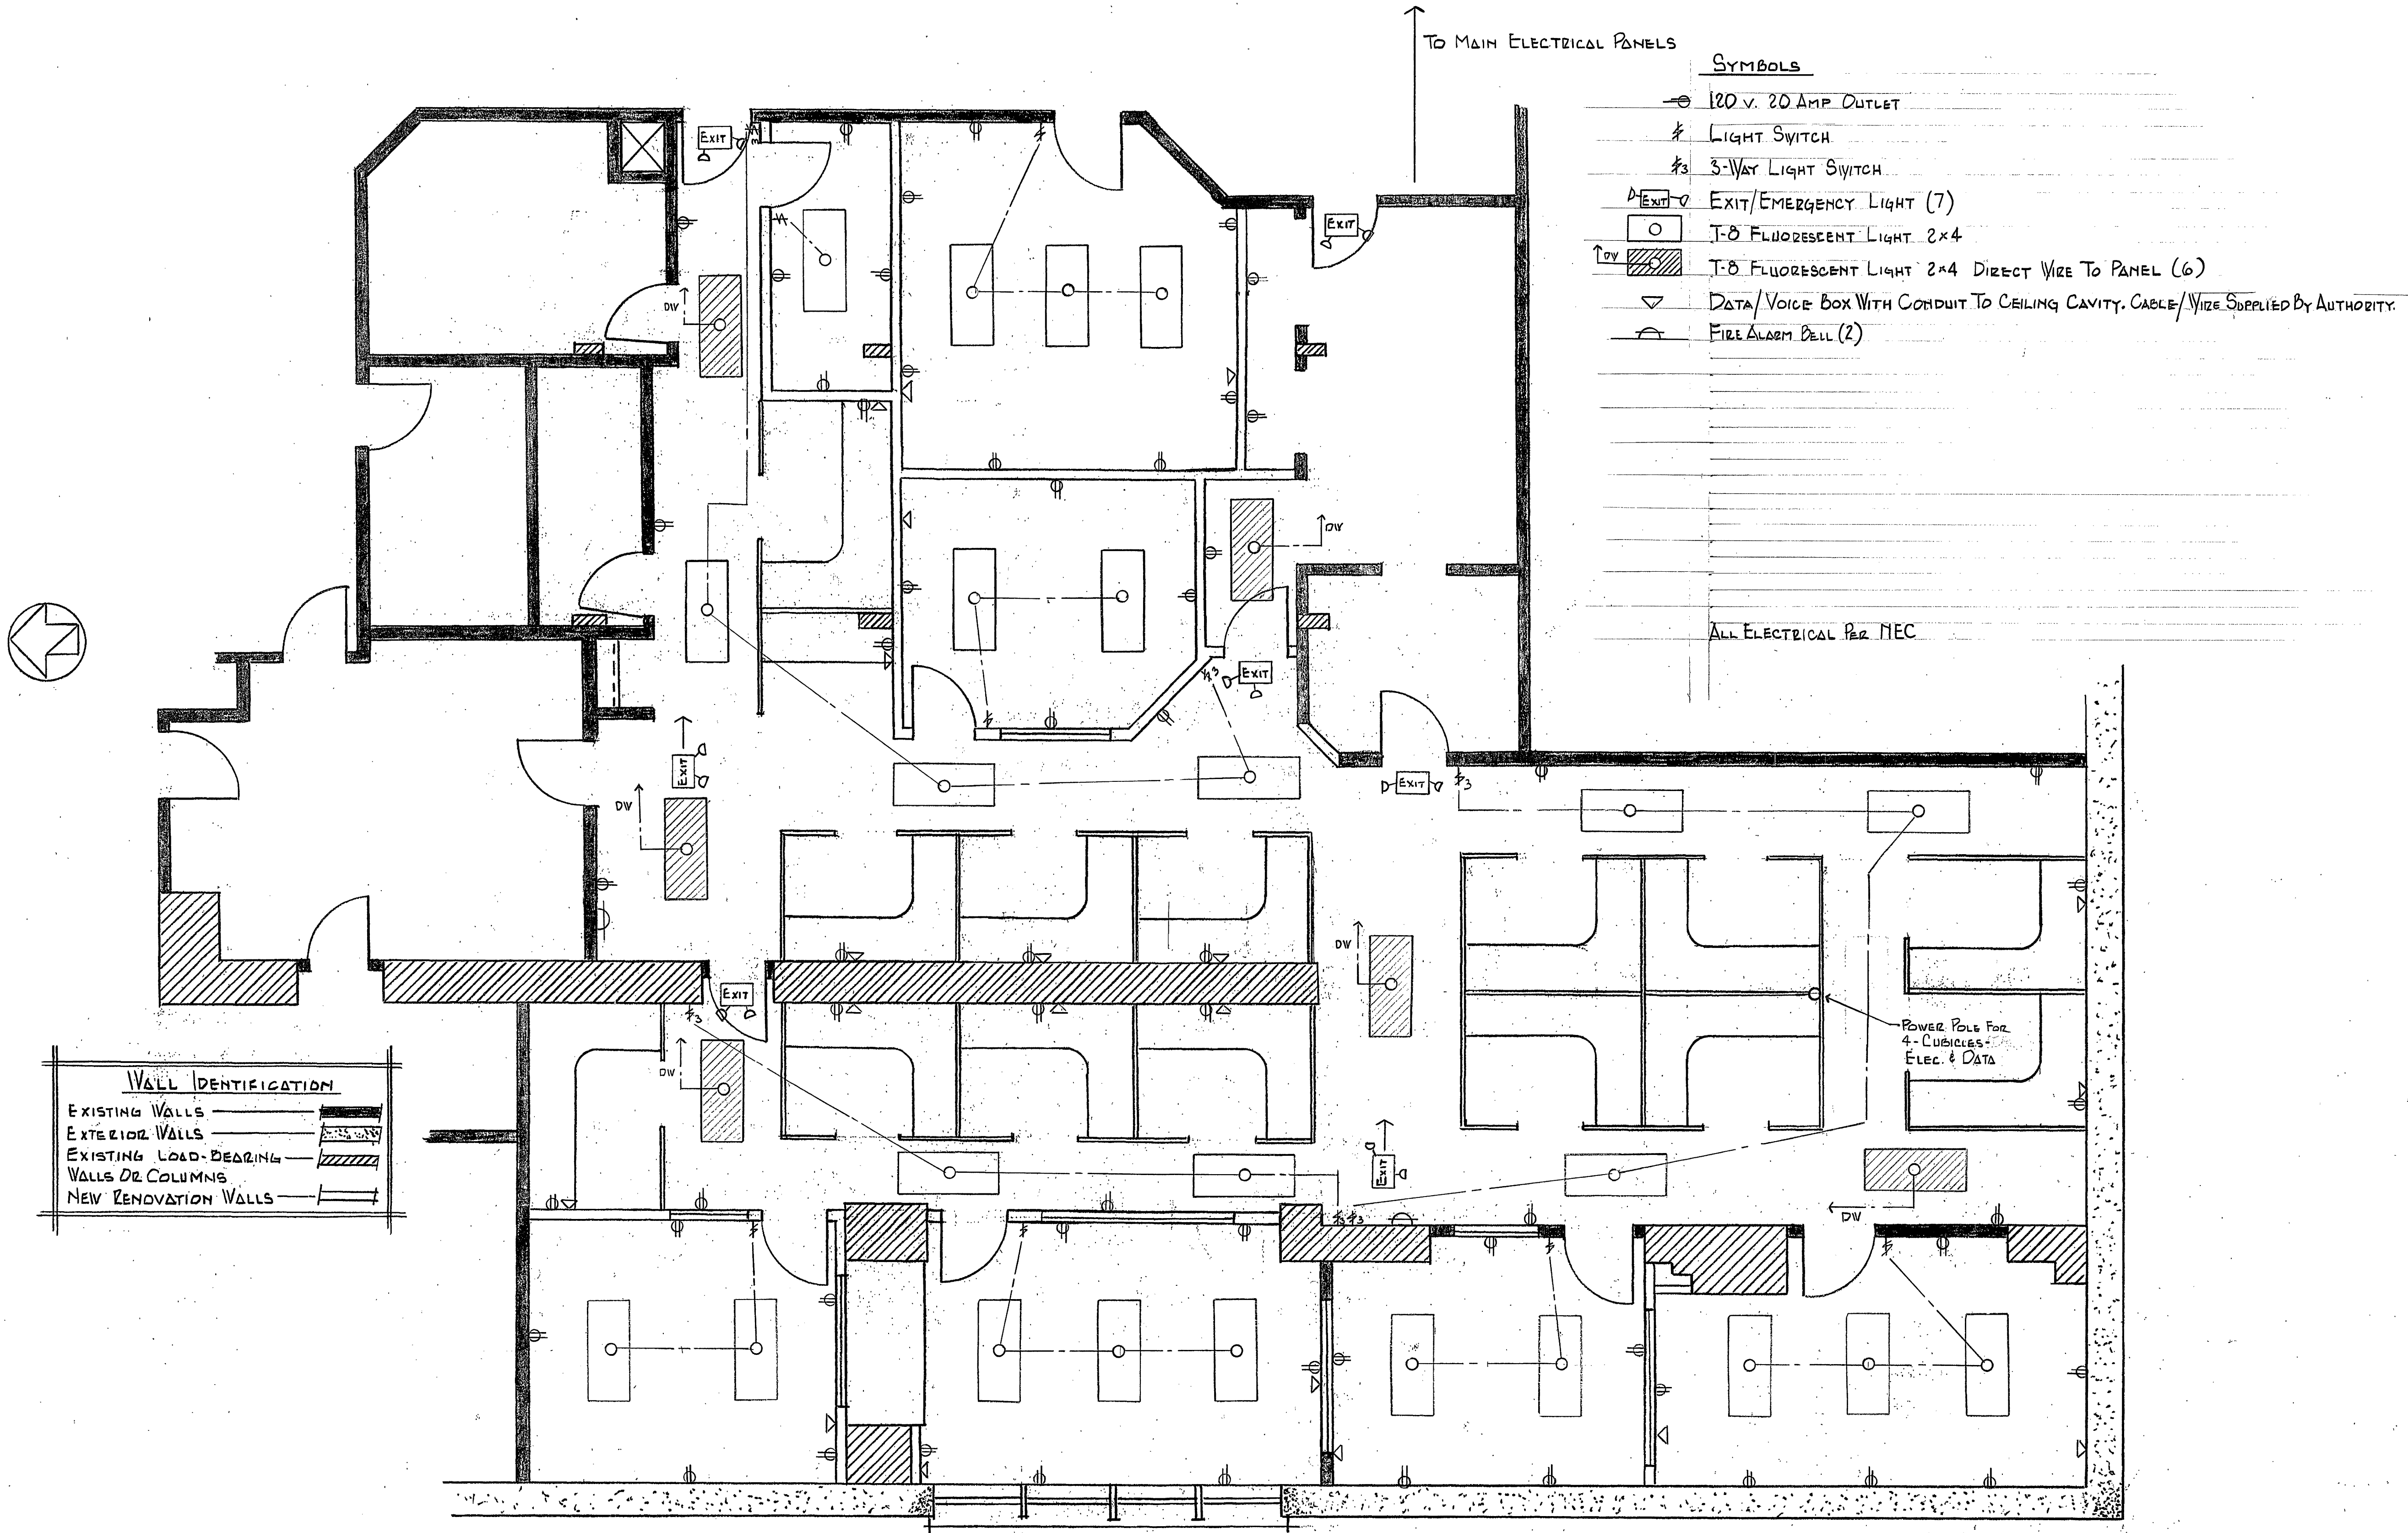

ALL ELECTRICAL PER NEC

POWER POLE FOR
4 CUBICLES -
ELEC. & DATA

CONSTRUCTION TYPE — 2B
OCCUPANCY LOAD — LESS THAN 30

ELECTRICAL - LIGHTING - FIRE ALARM LAYOUT

PG. 3 OF 5

WESTERN VIRGINIA WATER AUTHORITY WVWA-ZEH-14	
2ND FLOOR RENOVATION - COULTER BUILDING	
601 S. JEFFERSON ST. ROANOKE VA 24011	
SCALE: 1/4" = 1'-0"	DATE: 12-26-13 DWN: GVS