
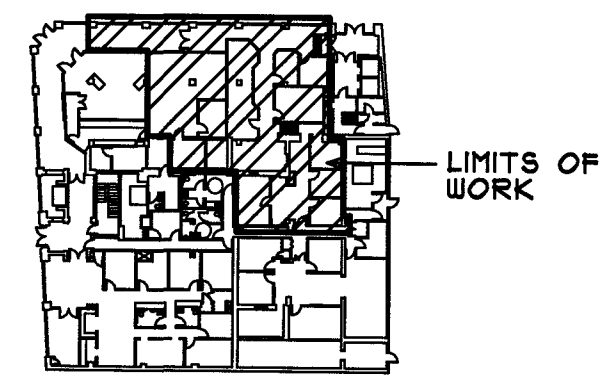


RENOVATIONS
FOR
**COULTER OFFICE
BUILDING**
401 S. JEFFERSON ST.
ROANOKE, VA.

△	_____	_____
△	- _____	- _____
△	- _____	- _____
△	- _____	- _____
△	- _____	- _____
△	- _____	- _____
REVISIONS	DATE	

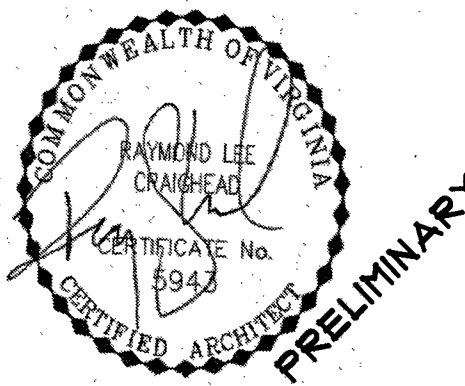

KEY PLAN

INTERIOR ALTERATIONS FOR
WESTERN VIRGINIA
WATER AUTHORITY

PROJECT NO: 2017043
DATE: 06/15/2017
DRAWN BY: RLC
CHECKED BY: RLC

APPROVED FOR THE CONTRACTOR : DATE

APPROVED FOR THE OWNER _____ DATE _____

A-2
DIMENSIONAL FLOOR PLAN
SCALE: 1/4" = 1'-0"

GRAPHIC:



SCALE: 1/16" = 1'-0"

4,211 SF

GROUND LEVEL ENTRY, LOWER LEVEL PLAN

TAX ID # 1013307, WESTERN VIRGINIA WATER AUTHORITY, OWNER