


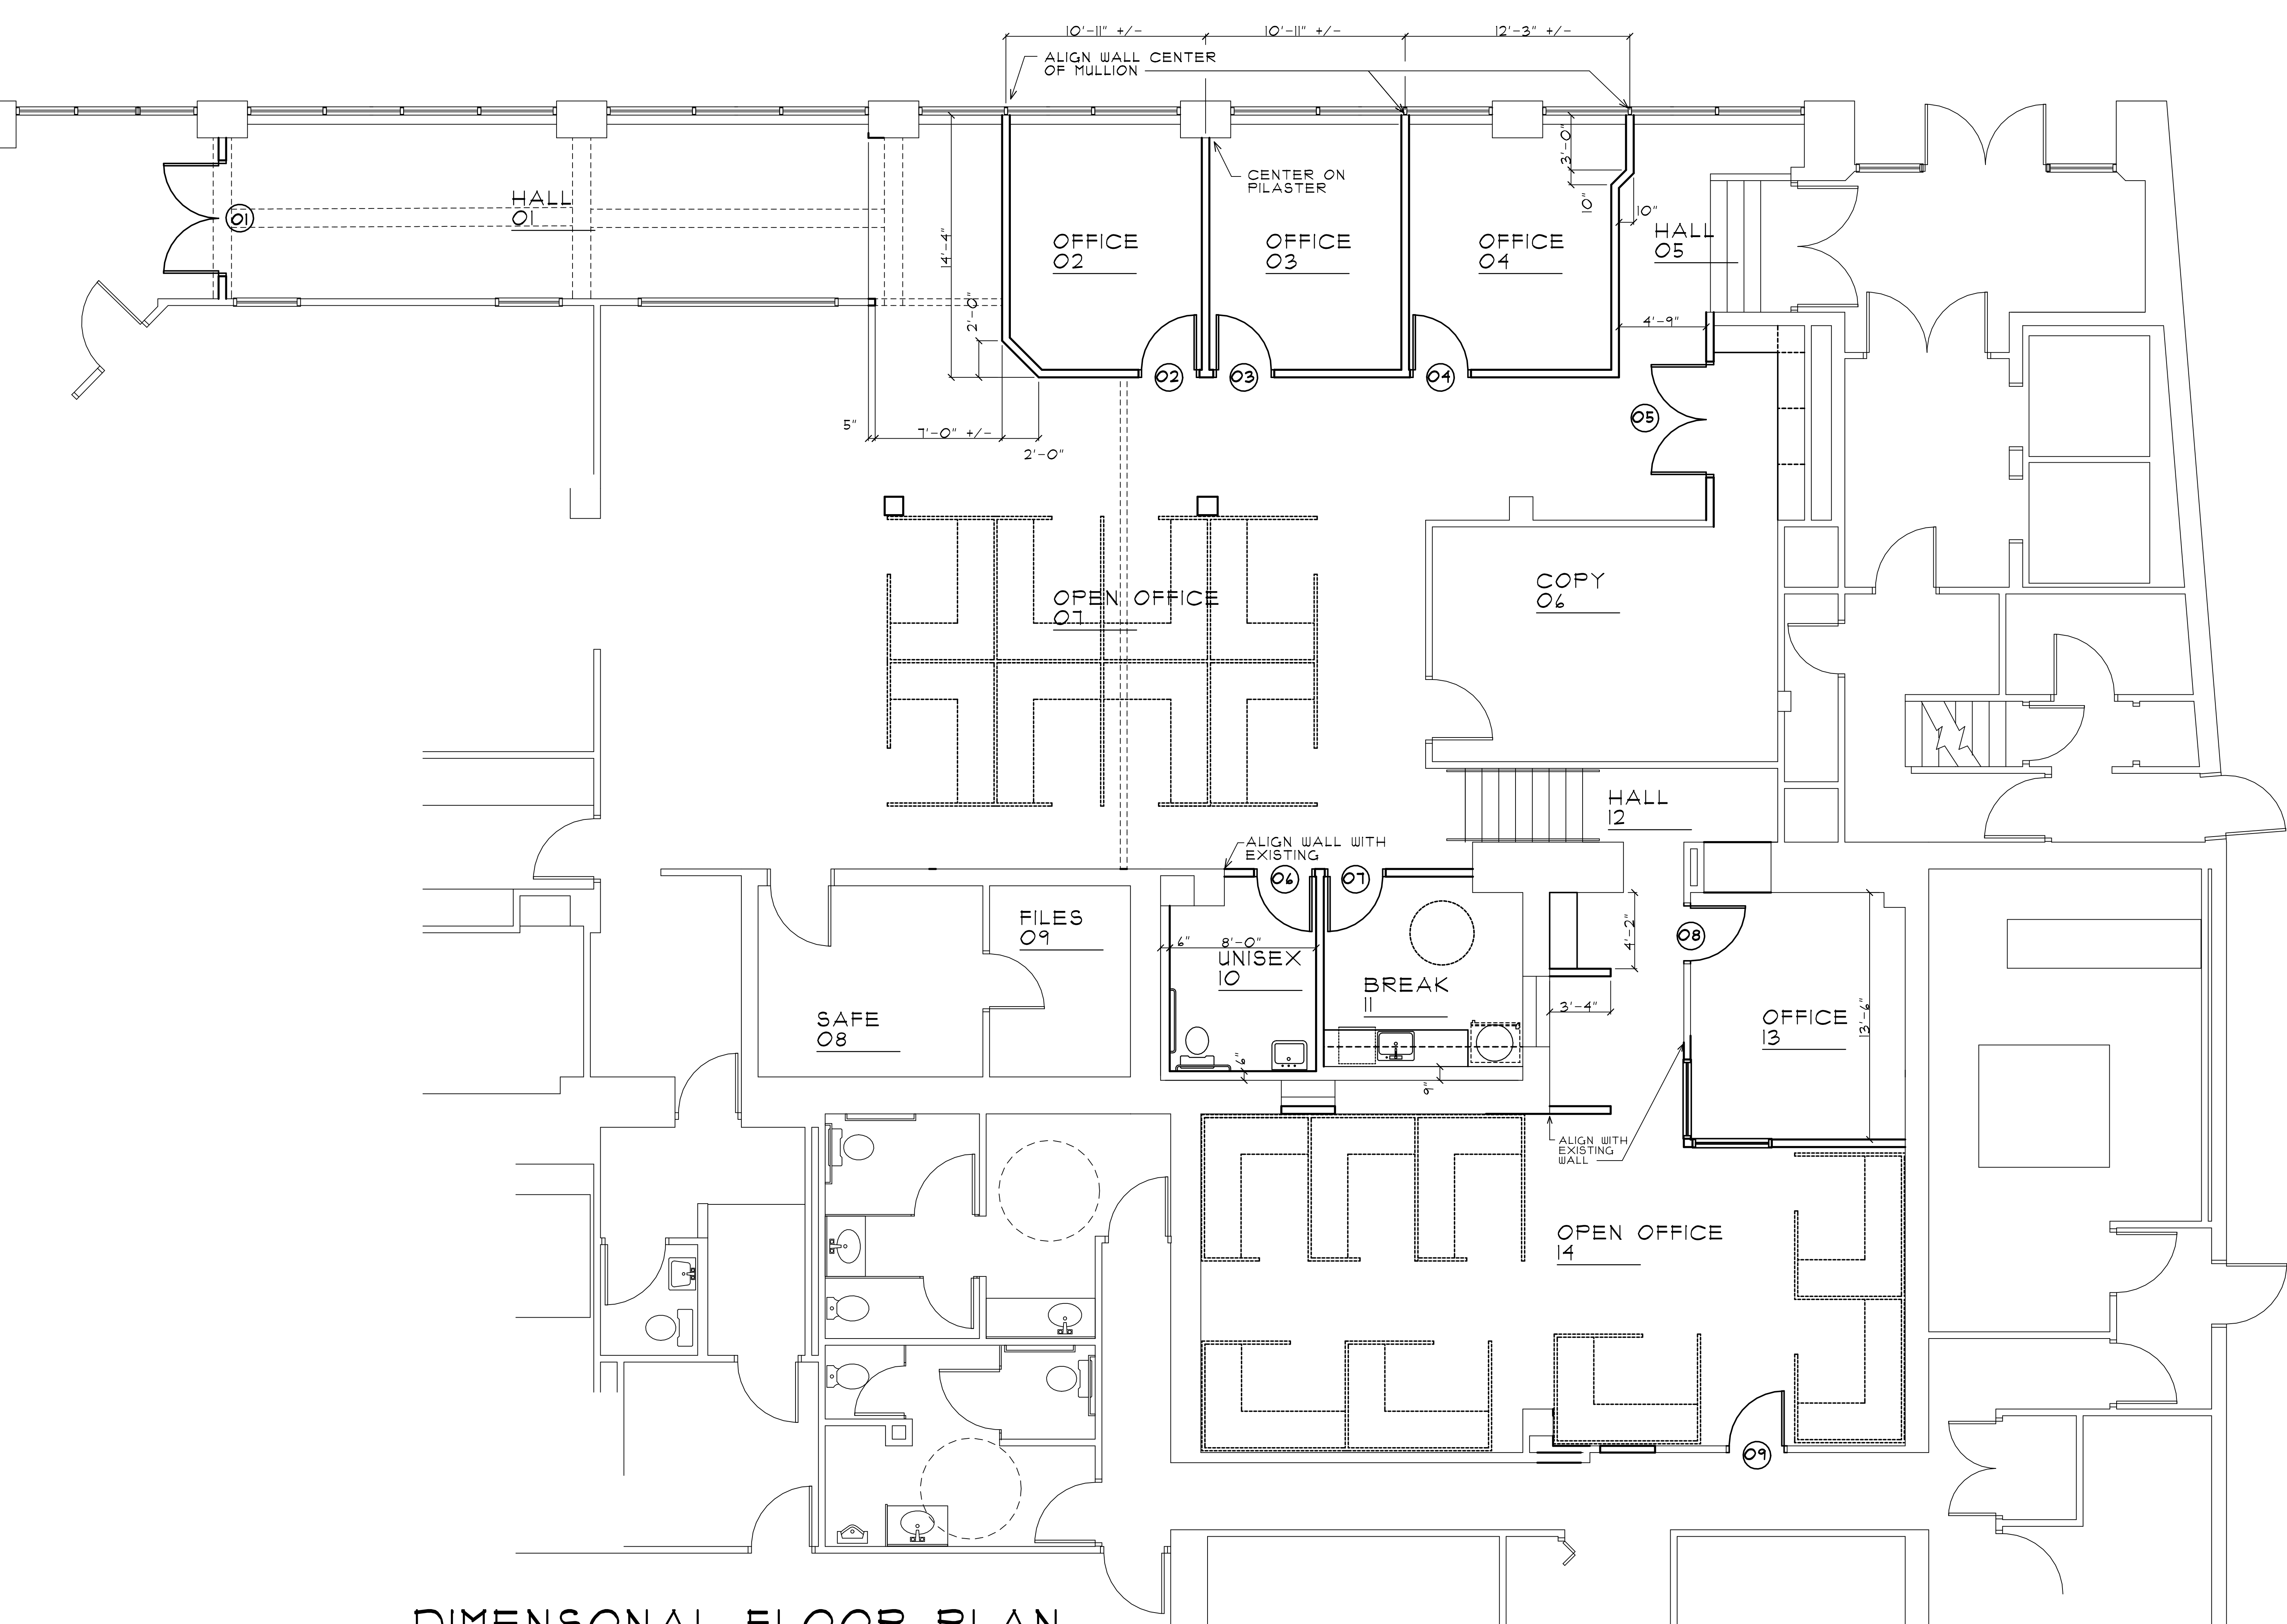


DIMENSIONAL FLOOR PLAN

SCALE: 1/16" = 1'-0"  
4,211 SF  
GROUND LEVEL ENTRY, LOWER LEVEL PLAN  
TAX ID # 1013301, WESTERN VIRGINIA WATER AUTHORITY, OWNER

**CRAIGHEAD & ASSOCIATES**  
Architects, Designers, Construction Managers  
3536 BRAMBLETON AVENUE SW  
SUITE 18  
ROANOKE, VIRGINIA 24018  
(540) 714-5324  
rcraigheadarchitect@yahoo.com

RENOVATIONS  
FOR  
**COULTER OFFICE  
BUILDING**  
601 S. JEFFERSON ST  
ROANOKE, VA.

|           |       |       |
|-----------|-------|-------|
| △         | _____ | _____ |
| △         | _____ | _____ |
| △         | _____ | _____ |
| △         | _____ | _____ |
| △         | _____ | _____ |
| REVISIONS | DATE  |       |

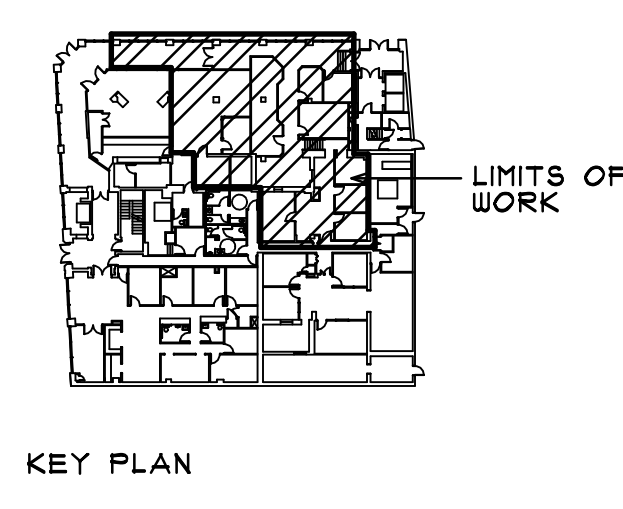

INTERIOR ALTERATIONS FOR  
**WESTERN VIRGINIA  
WATER AUTHORITY**

PROJECT NO: 2011043  
DATE: 04/15/2011  
DRAWN BY: RLC  
CHECKED BY: RLC

APPROVED FOR THE CONTRACTOR \_\_\_\_\_ DATE \_\_\_\_\_  
APPROVED FOR THE OWNER \_\_\_\_\_ DATE \_\_\_\_\_

**A-2**  
DIMENSIONAL FLOOR PLAN  
SCALE: 1/4"= 1'-0"  
GRAPHIC: