


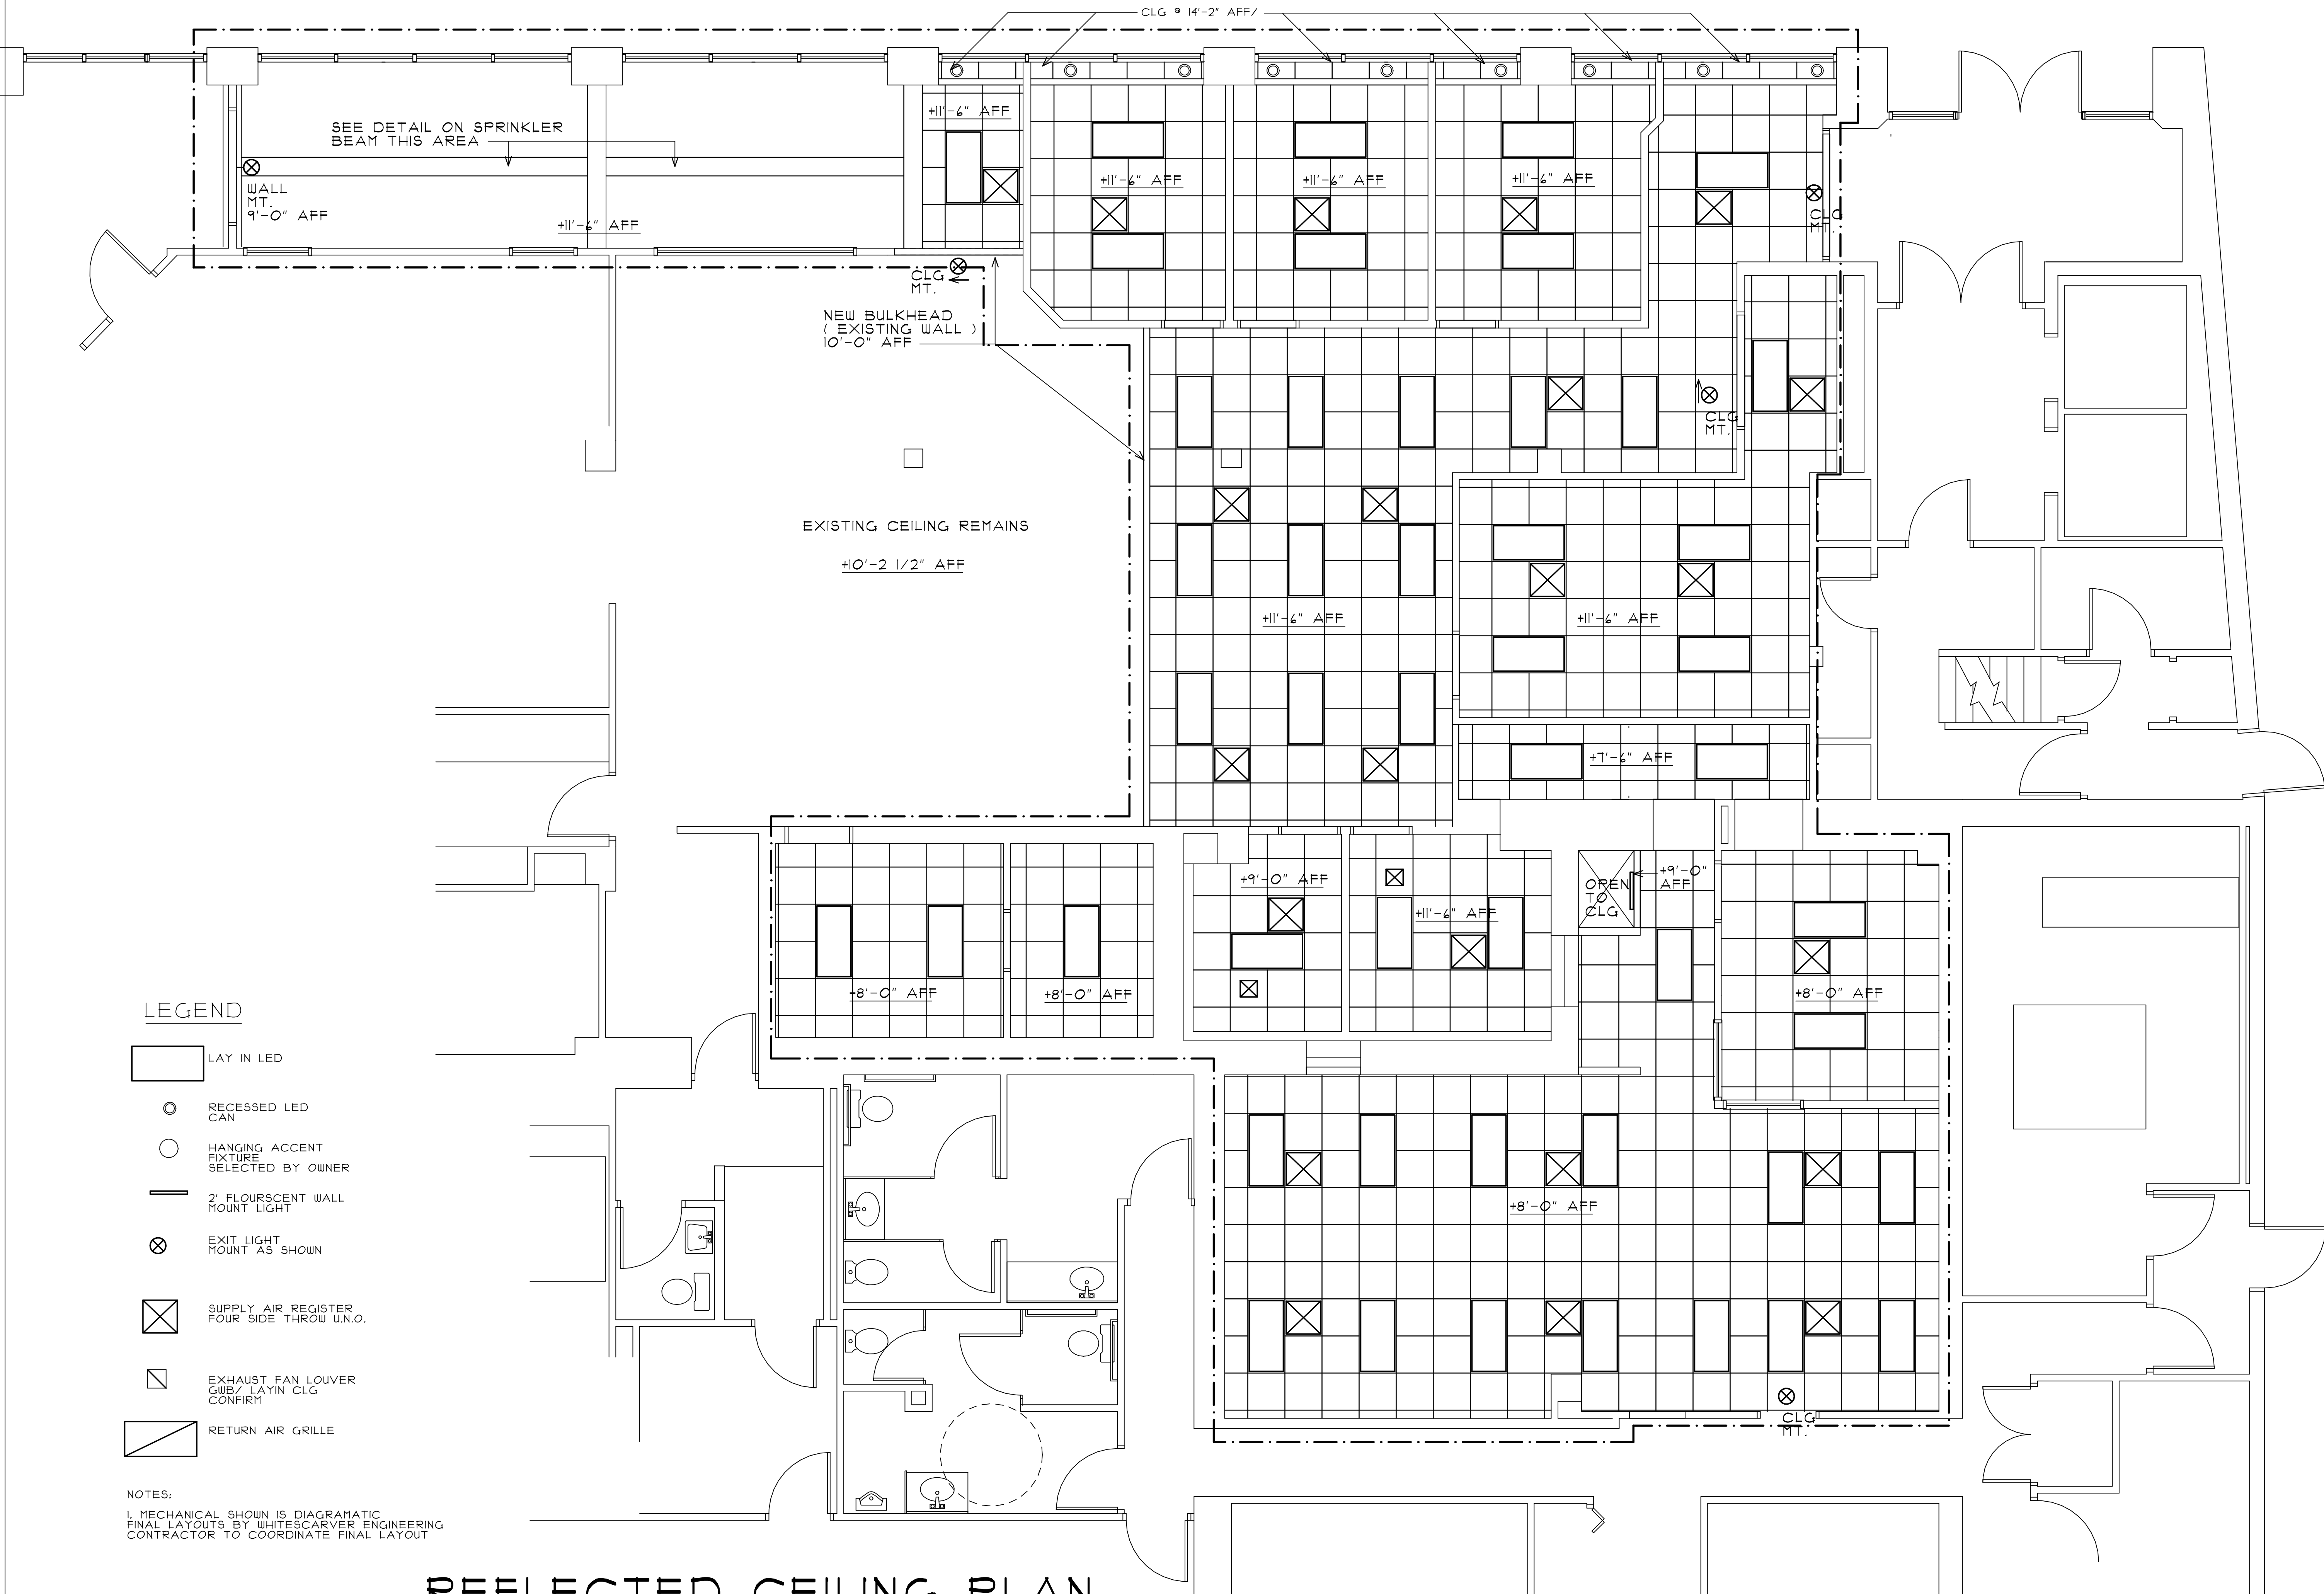

REFLECTED CEILING PLAN


SCALE: 1/4" = 1'-0" 4,211 SF

GROUND LEVEL ENTRY, LOWER LEVEL PLAN

CRAIGHEAD ASSOCIATES
Architects, Designers, Construction Managers
3534 BRAMBLETON AVENUE SW
SUITE 8
ROANOKE, VIRGINIA 24018
(540) 714-5324
rcraigheadarchitect@yahoo.com

RENOVATIONS
FOR
**COULTER OFFICE
BUILDING**
601 S. JEFFERSON ST
ROANOKE, VA.

△	_____	_____
△	-	-
△	-	-
△	-	-
△	-	-
REVISIONS	DATE	

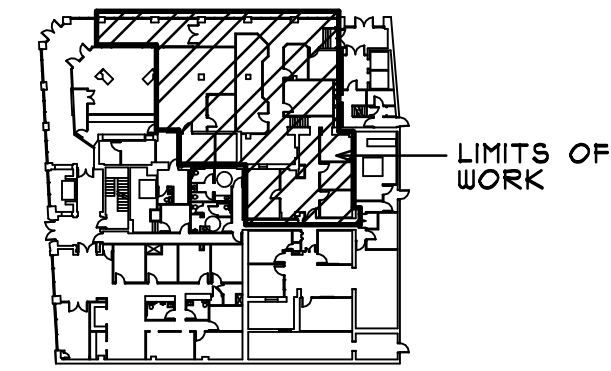

KEY PLAN

INTERIOR ALTERATIONS FOR
**WESTERN VIRGINIA
WATER AUTHORITY**

PROJECT NO: 2011043
DATE: 04/15/2017
DRAWN BY: RLC
CHECKED BY: RLC

APPROVED FOR THE CONTRACTOR _____ DATE _____

APPROVED FOR THE OWNER _____ DATE _____

A-4
REFLECTED CEILING PLAN
SCALE: 1/4" = 1'-0"
GRAPHIC: